


CITY ENVIRONMENTAL, SERVICE, INC. OF FLORIDA

7202 EAST EIGHT AVENUE

TAMPA, FLORIDA, 33619

DRAWING INDEX		
SHEET	DESCRIPTION	PAGE
SP-1	EXISTING SITE PLAN	1 OF 11
SP-2	PROPOSED SITE PLAN	2 OF 11
A-1	EXISTING LOADING DOCK FLOOR PLAN	3 OF 11
A-2	DEMOLITION PLAN	4 OF 11
A-3	PROPOSED CONTAMINANT AREA & LOADING DOCK FLOOR PLAN	5 OF 11
A-4	EAST & WEST ELEVATION PLAN	6 OF 11
A-5	NORTH & SOUTH ELEVATION PLAN	7 OF 11
A-6	ROOF & CROSS SECTION PLAN	8 OF 11
S-1	CONTAMINANT AREA FOUNDATION PLAN	9 OF 11
S-2	FOUNDATION DETAILS	10 OF 11
S-2	ELECTRICAL LIGHTING PLAN	11 OF 11

Attachment 8.3

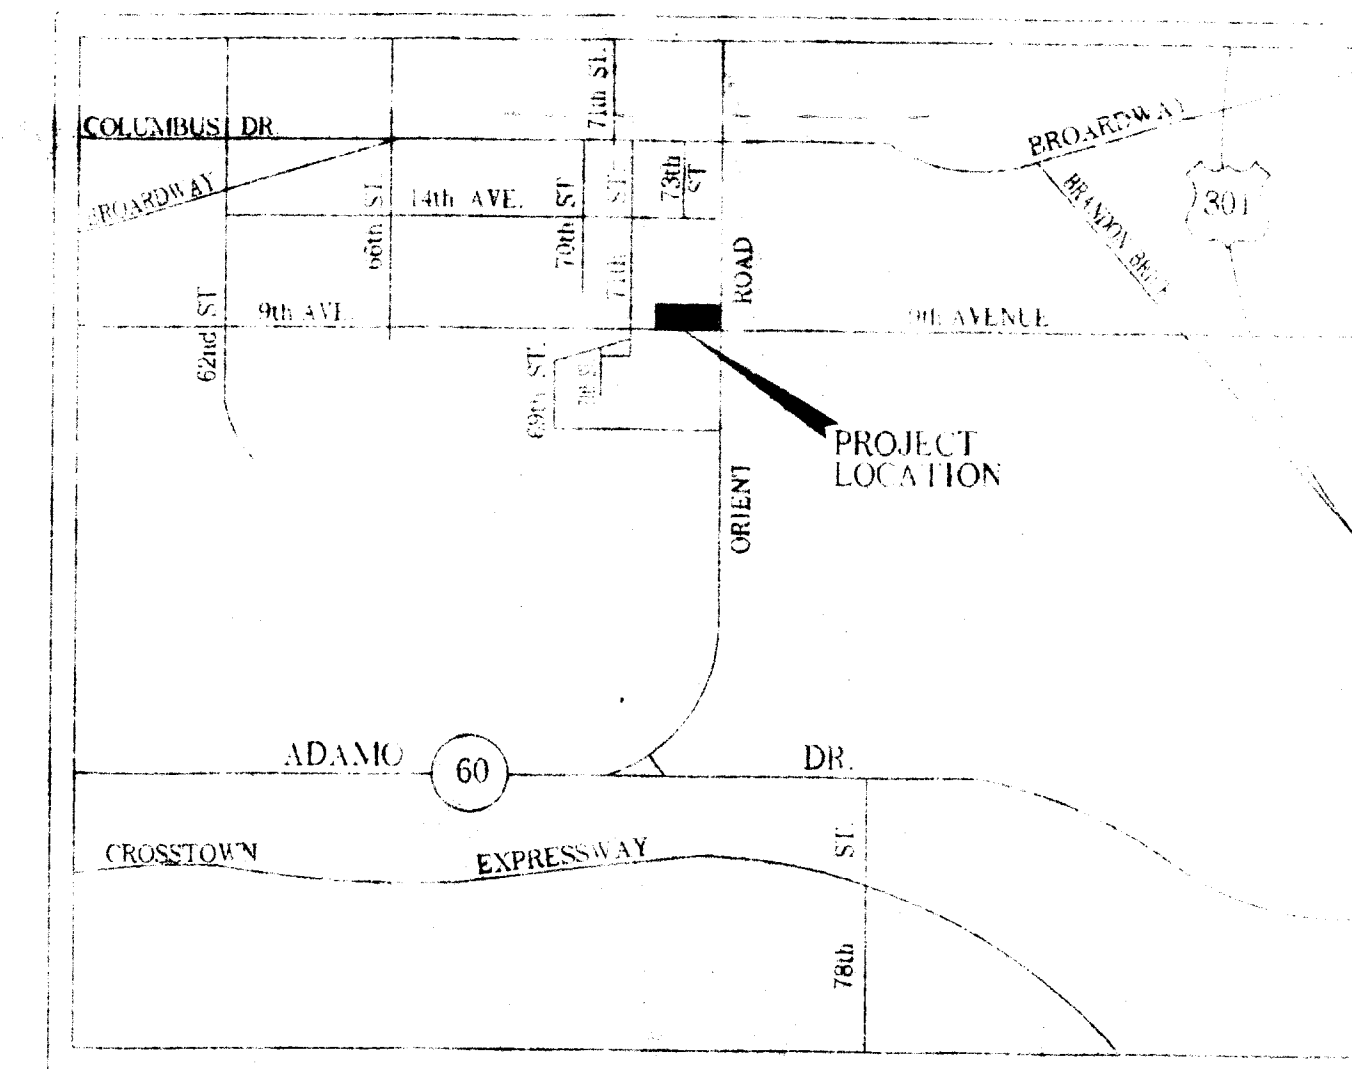

KEY MAP
N.T.S.

RECEIVED
JAN 18 2000
Hazardous Waste Regulation
RCRA


DEC 30 1999
DEP
Columbus District Tampa



DATE	REVISION	BY	12/15/99
1			
2			
3			
4			
5			

CITY ENVIRONMENTAL, SERVICE, INC. OF FLORIDA 7202 EAST EIGHT AVENUE TAMPA, FLORIDA, 33619	
P.J. CALLAGHAN GENERAL CONTRACTORS 10525 49th ST. NO CLEARWATER FL 34622 PH 573-2205 FAX 573-2077	


DATE	12/15/99
DRAWN BY	RD
FILE #	1623
PAGE NO.	
SHEET NO.	COVER

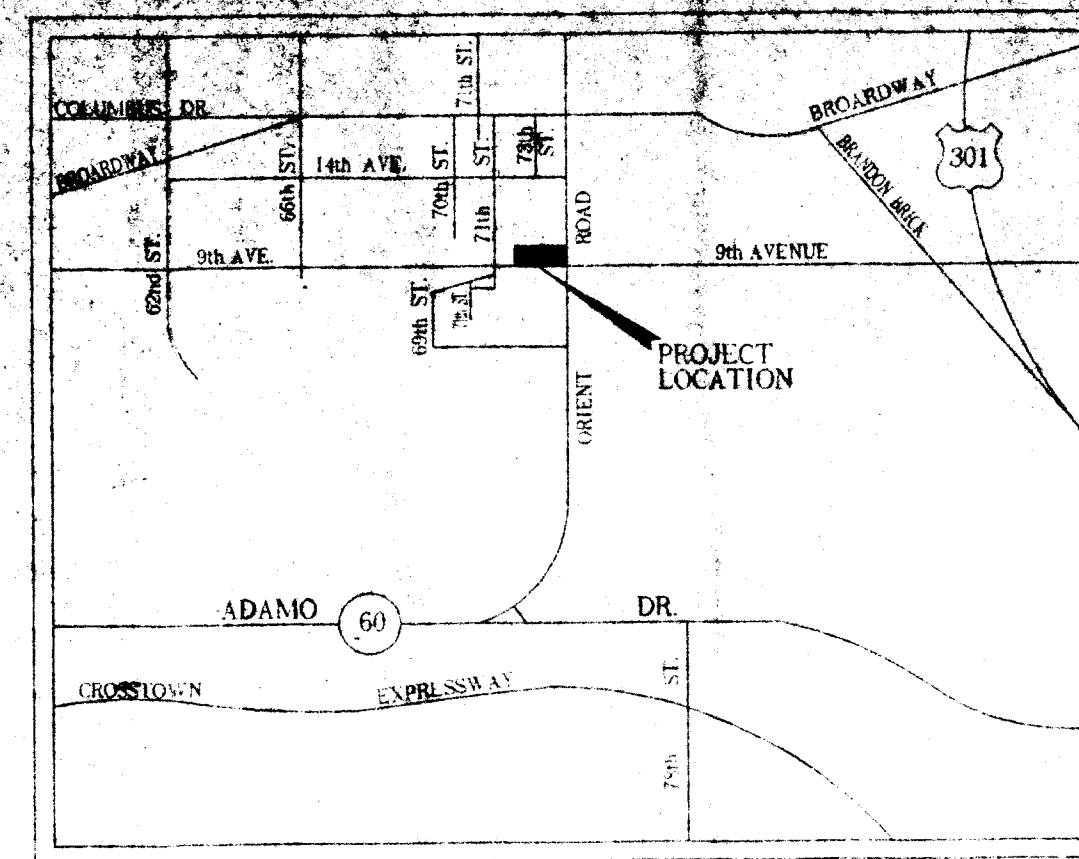

KEY MAP NOT TO SCALE

LEGAL DESCRIPTION:

A SURVEY OF LOTS 8,9,10,11,12,13, AND 14, BLOCK 1, OF ORIENT PARK SUBDIVISION, ACCORDING TO THE MAP OR PLAT THEREOF AS RECORDED IN PLAT BOOK 11, PAGE 7, OF THE PUBLIC RECORDS OF HILLSBOROUGH COUNTY, FLORIDA.

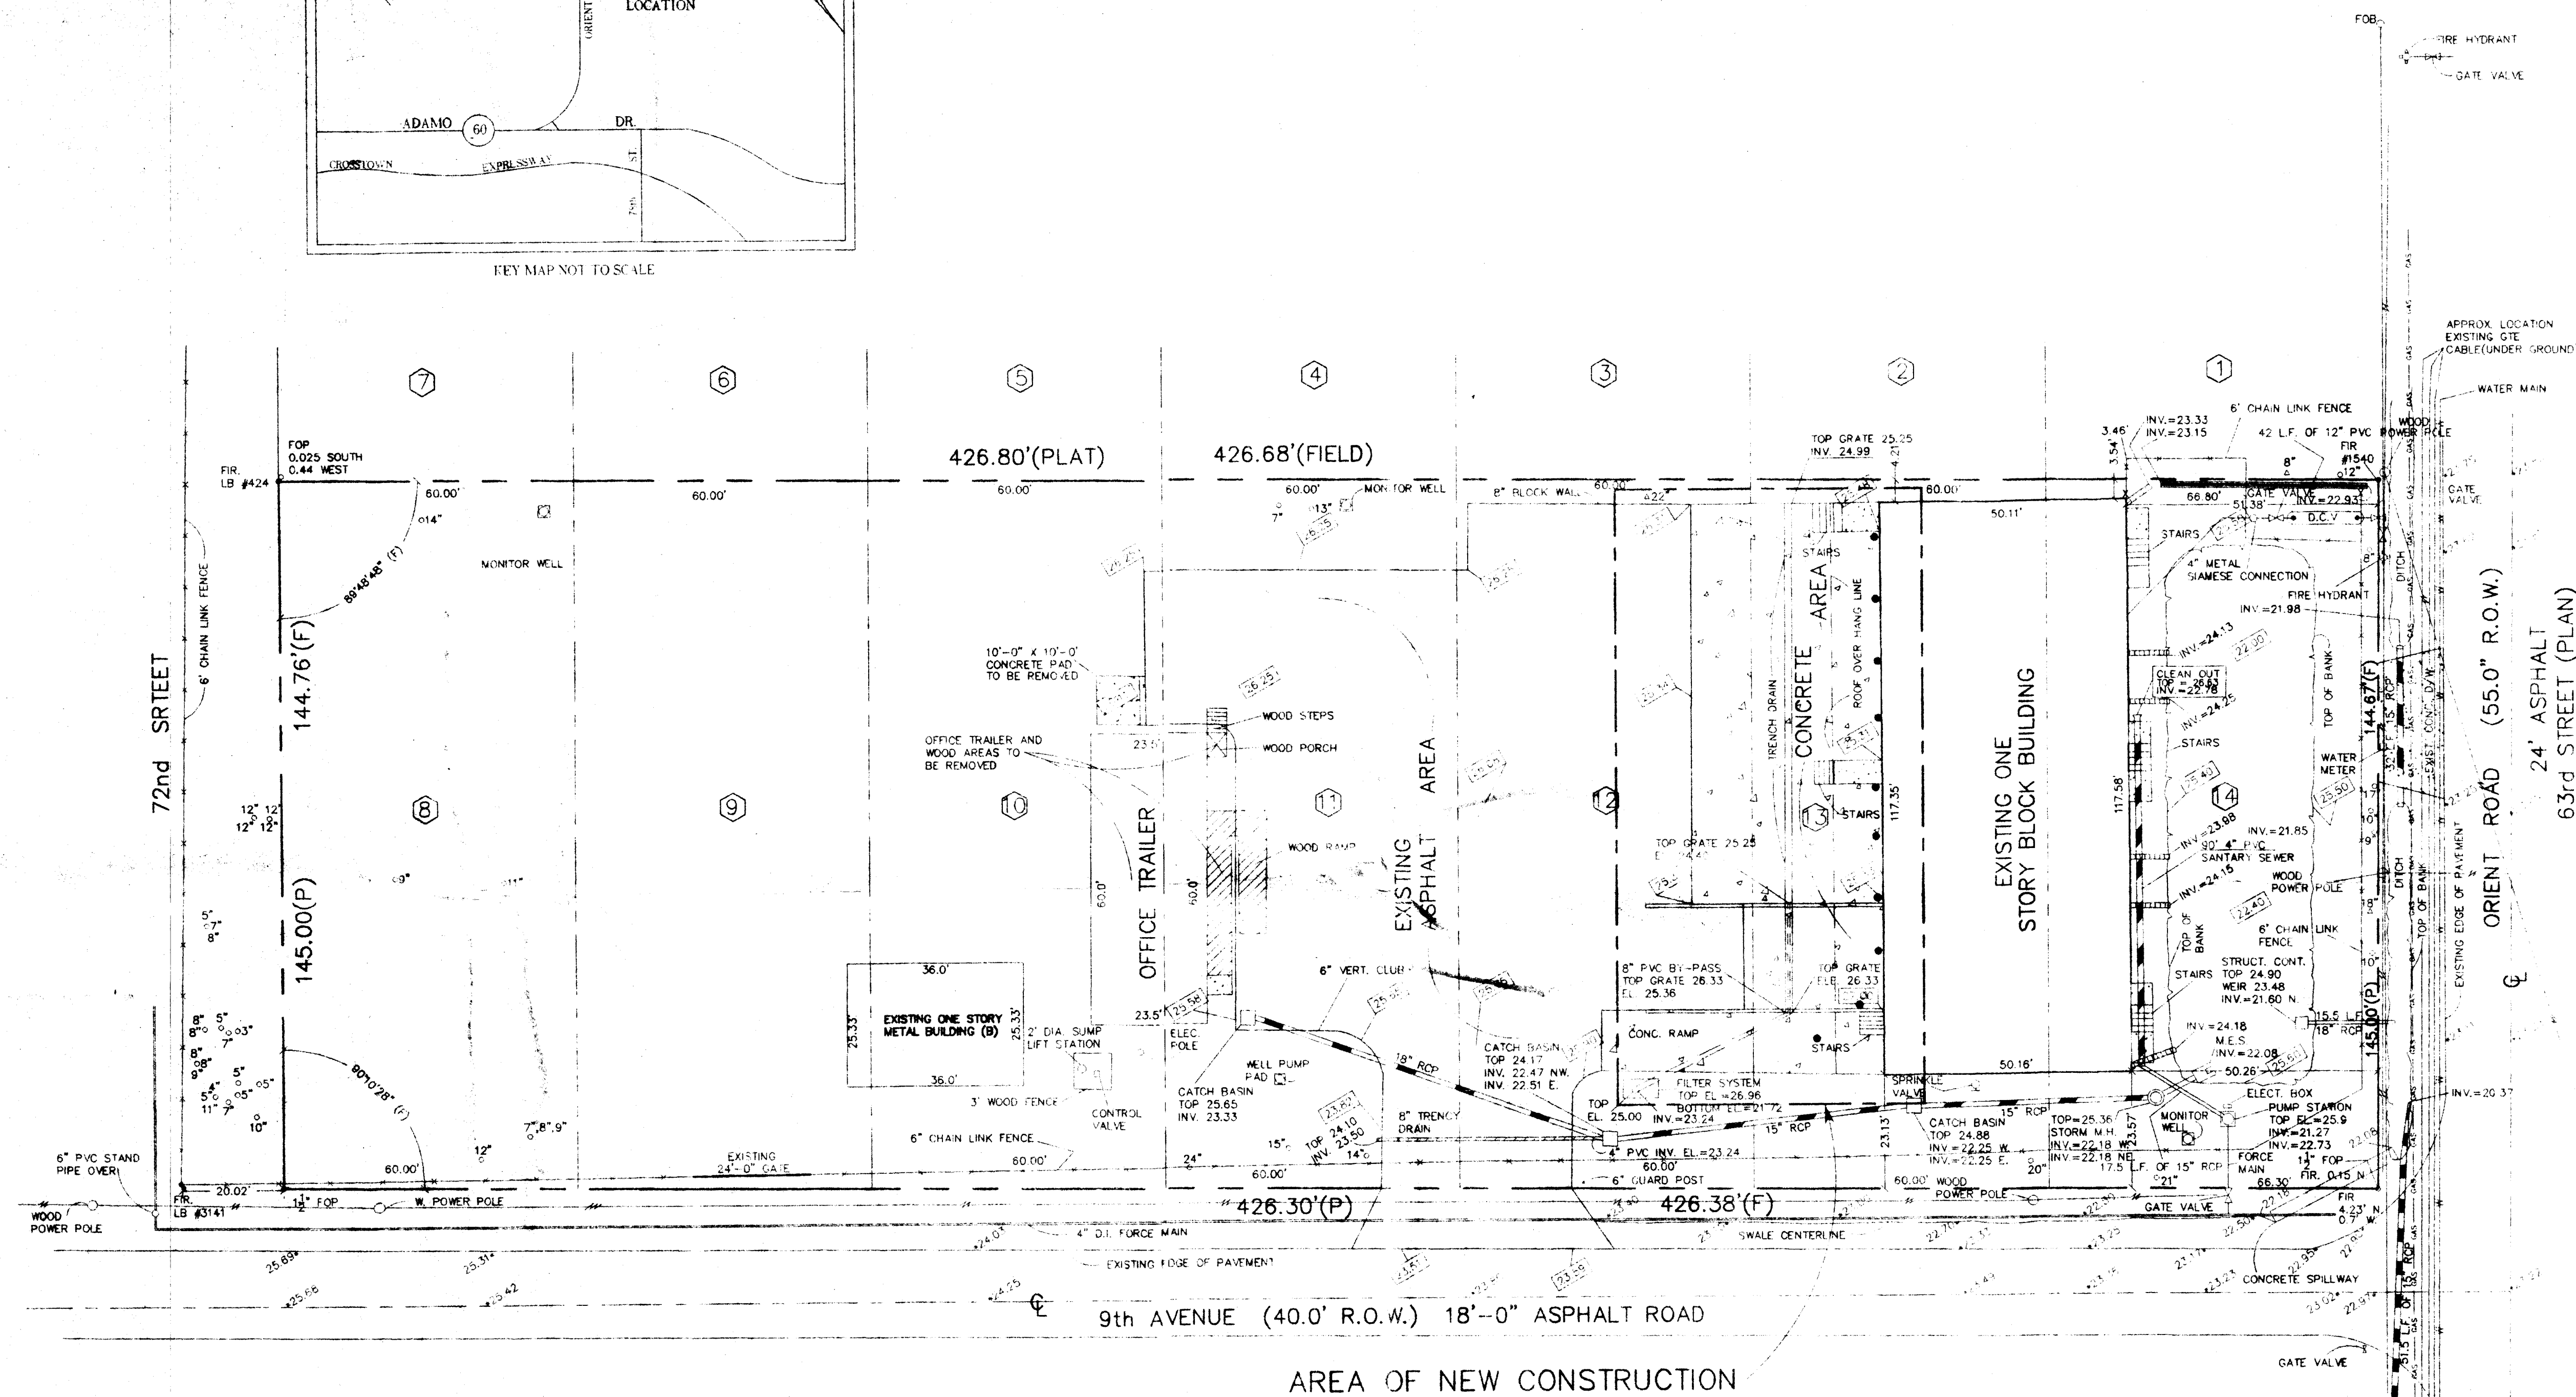


EXISTING SITE PLAN
SCALE 1" = 20.0'

GENERAL NOTE:


- 1)- ALL PALM TREE INDICATED BY: Δ 12"
- 2)- ALL OAK TREE INDICATED BY: $\circ$ 14"
- 3)- ALL OVERHEAD WIRE INDICATED BY: --- W
- 4)- ALL WATER LINE INDICATED BY: --- W
- 5)- ALL GAS LINE INDICATED BY: --- GAS
- 6)- BENCH MARK: CITY OF TAMPA @ CUT SW. COR. CONC. WALK, 5' SOUTH CORNER CONCRETE BLOCK BUILDING AT NE. CORNER ORIENT ROAD AND EAST BROADWAY, ELEVATION = 28.94; MEAN SEA LEVEL = 0.00
- 7)- ALL GUARD POST INDICATED BY: $\bullet$
- 8)- ALL FINISH GRADES INDICATED BY: $\star$

INFORMATION WAS UTILIZED IN THE PREPARATION OF THIS SITE PLAN WAS TAKEN FROM A SURVEY PREPARED BY EARL W. RAMER, FLORIDA REG. LAND SURVEYOR NO. 3618, AND THEREBY GIVE CREDIT.

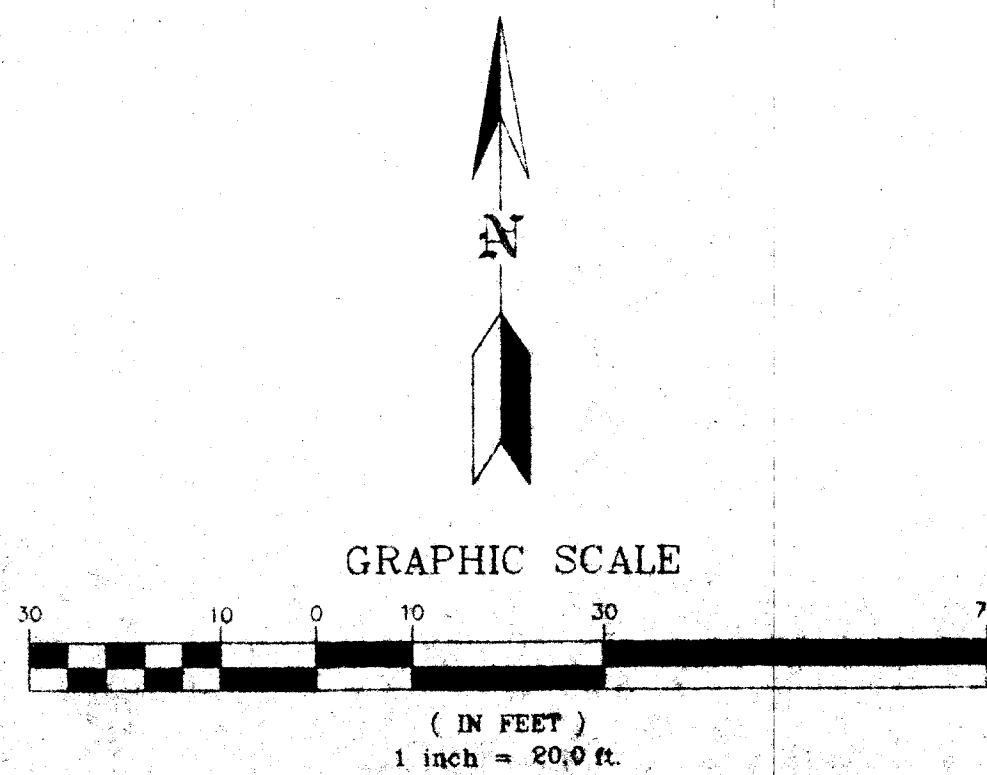

DATE	REVISION	BY	SCALE 1" = 20.0'	189
	1		CITY ENVIRONMENTAL, SERVICE, INC. OF FLORIDA	
	2		7202 EAST EIGHT AVENUE	
	3		TAMPA, FLORIDA, 33619	
	4			
	5			

P.J. CALLAGHAN
GENERAL CONTRACTORS
LICENSE NO. CG-000149
10525 49th ST. NO.
CLEARWATER, FL 34625
PH 813-250-1300 FAX 813-250-1301



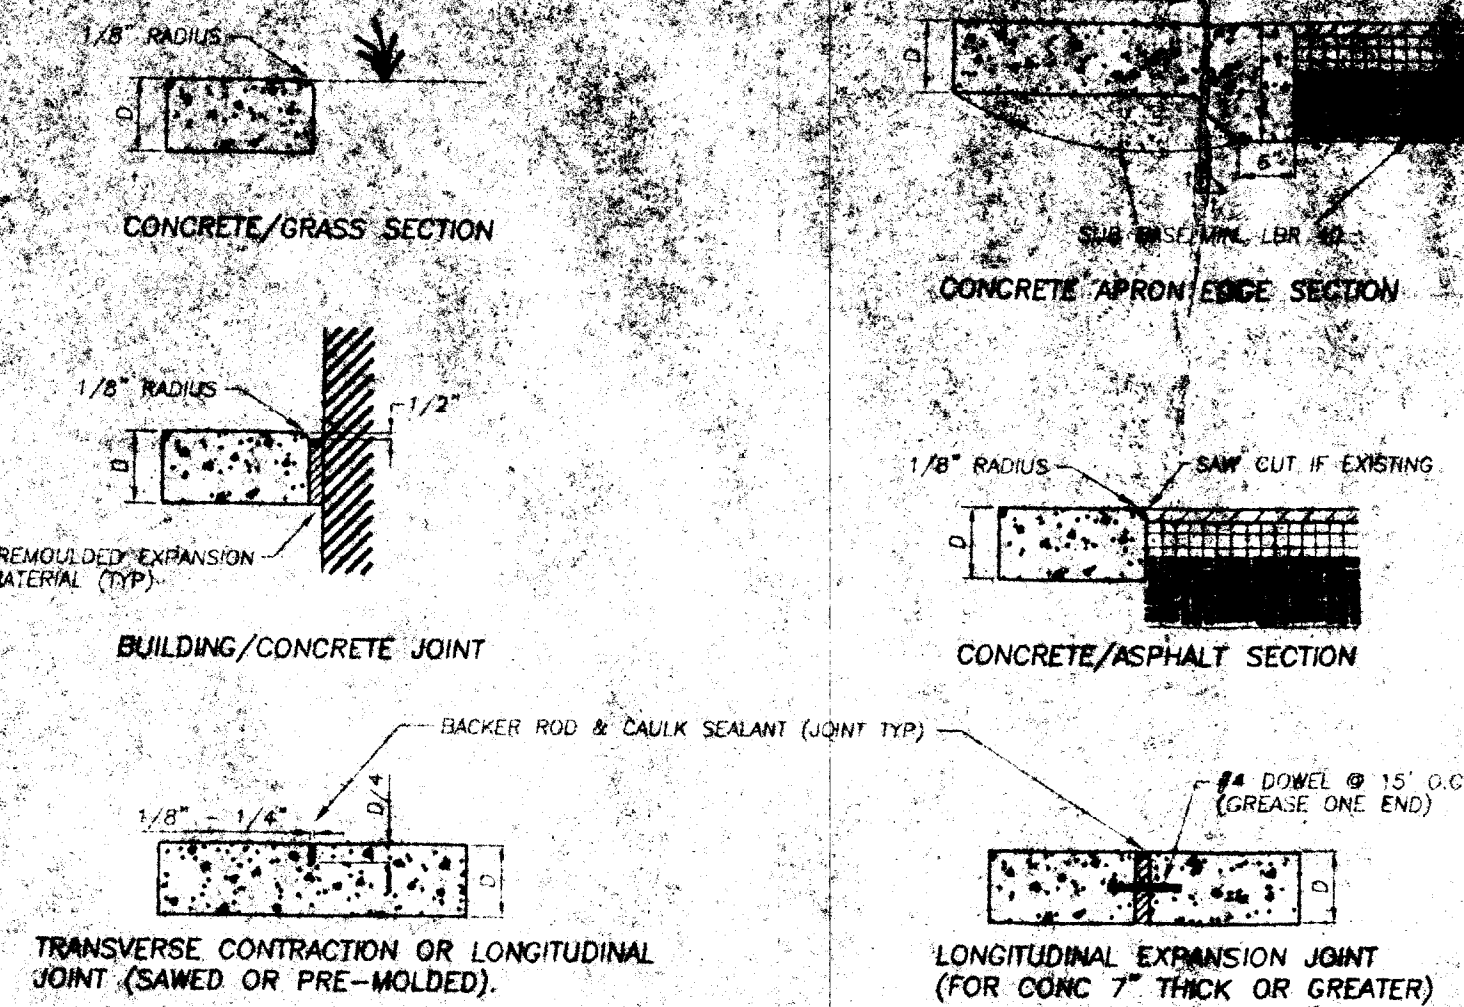


ALL CONCRETE PAVEMENT ON-SITE IS TO BE FIBERMESH REINFORCED. 8" THICK CONCRETE IN TRUCK TRAFFIC AREAS. MATERIAL AND CONSTRUCTION TO BE IN STRICT ACCORDANCE WITH RECOMMENDED SPECIFICATIONS FOR NON-REINFORCED PORTLAND CEMENT CONCRETE PAVING BY THE PORTLAND CEMENT ASSOCIATION. JOINTS TO BE SPACED AT 18 FEET FOR 8 INCH THICK CONCRETE. JOINTS TO BE CONSTRUCTED AS SHOWN ABOVE.

NO STEEL REINFORCEMENT IS REQUIRED FOR PAVEMENT AREAS PROVIDE FIBER REINFORCEMENT AT 3.0 LBS PER CUBIC YARD

CONCRETE PAVEMENT DETAILS

N.T.S.

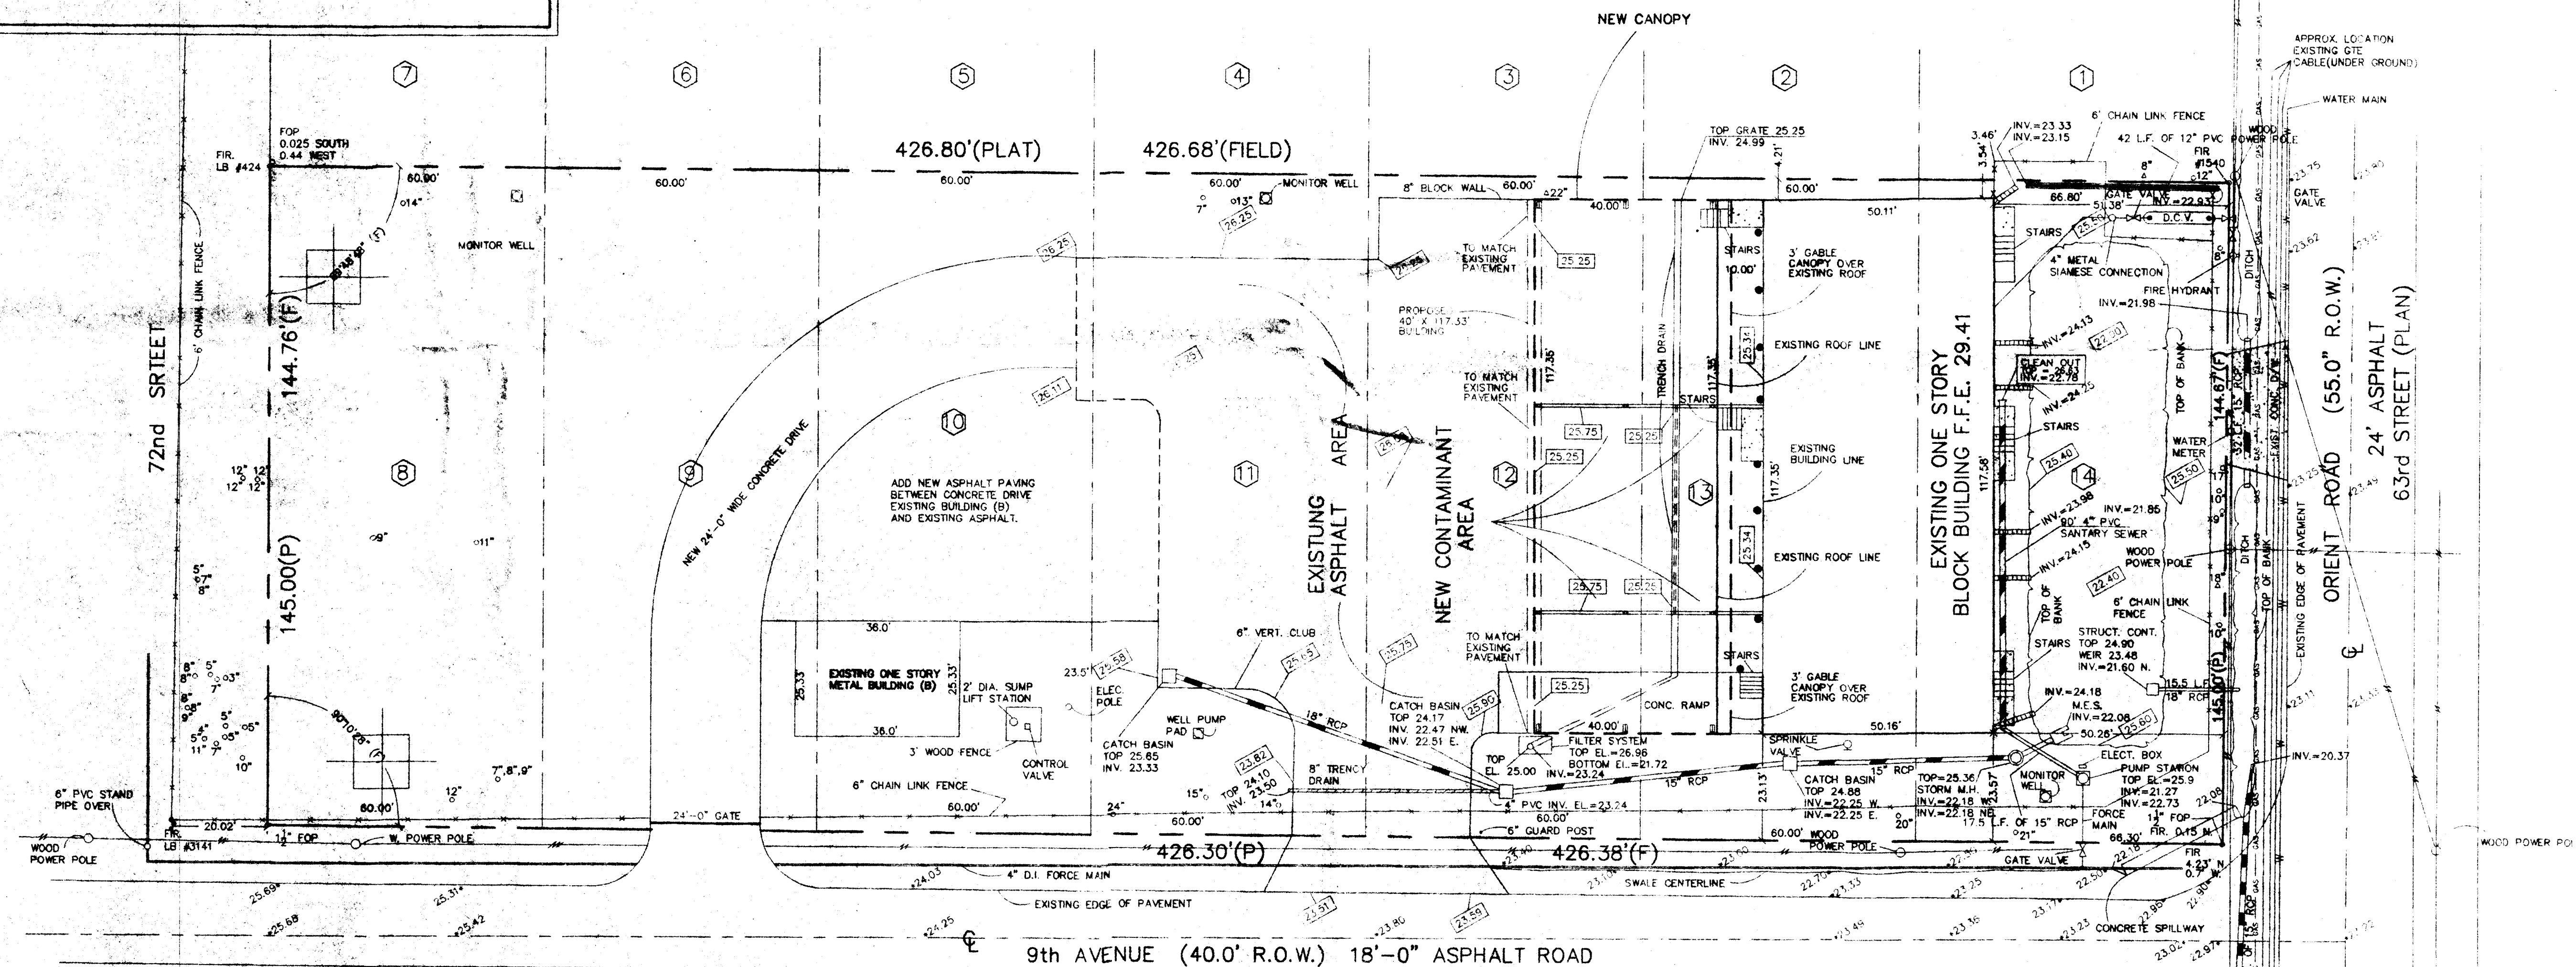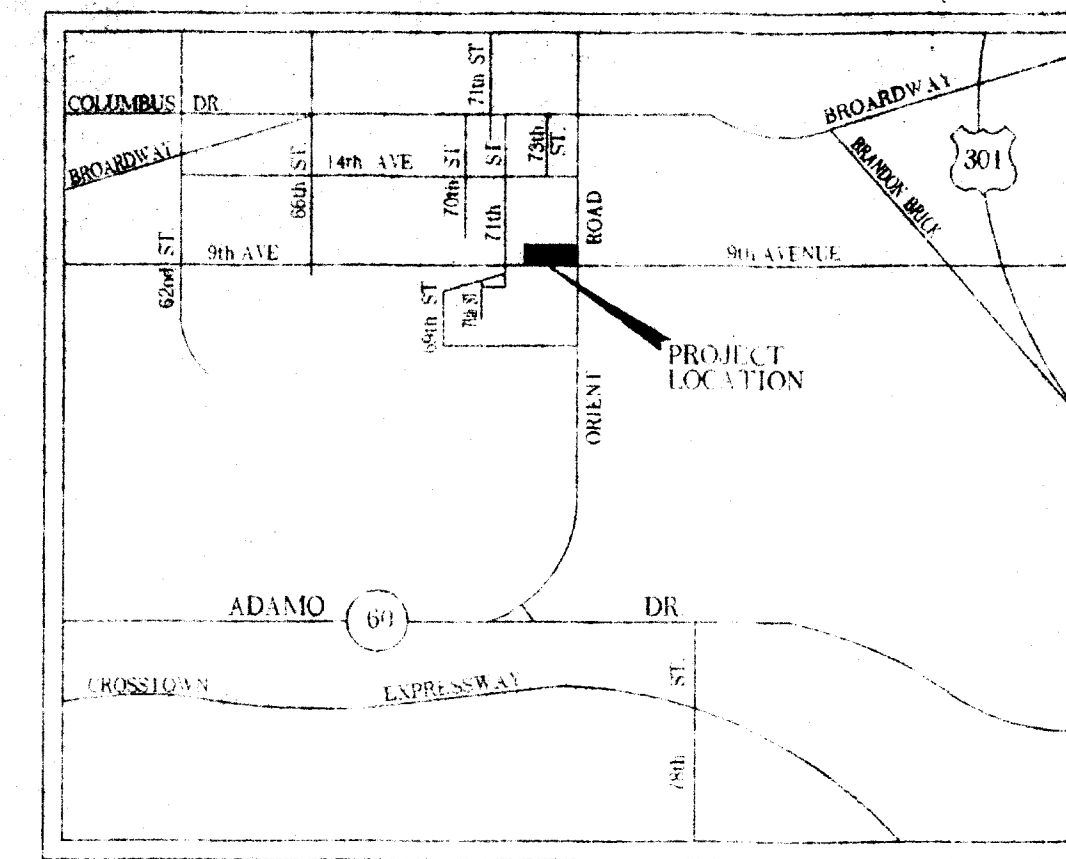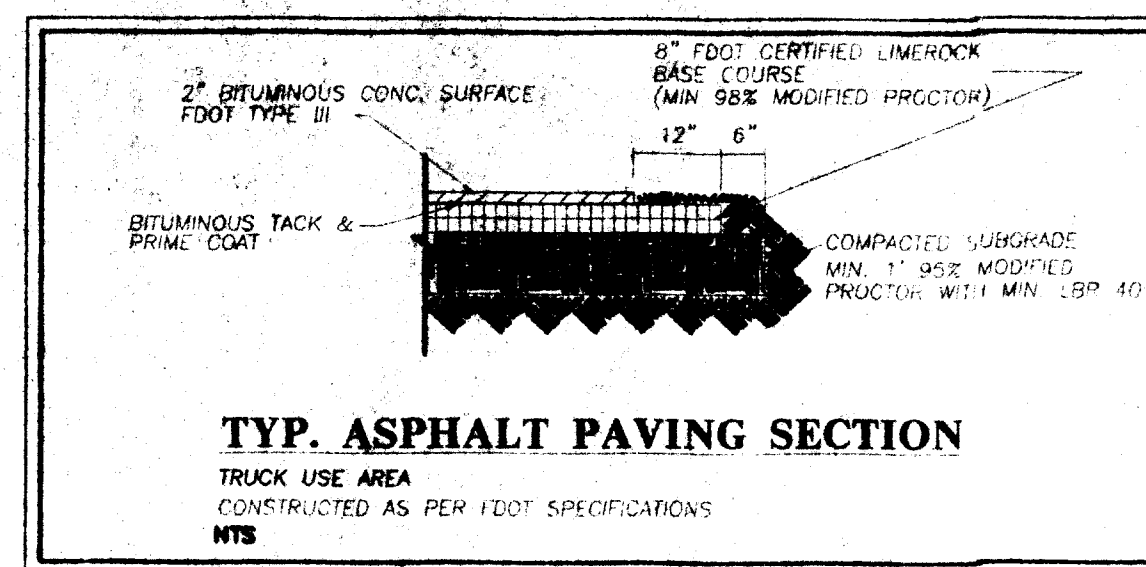

GENERAL NOTE:

- 1) ALL PALM TREE INDICATED BY: Δ 12"
- 2) ALL OAK TREE INDICATED BY: $\bigcirc$ 14"
- 3) ALL OVERHEAD WIRE INDICATED BY: $---$
- 4) ALL WATER LINE INDICATED BY: $---$
- 5) ALL GAS LINE INDICATED BY: $---$
- 6) BENCH MARK: CITY OF TAMPA @ CUT SW. COR. CONC. WALK, 5' SOUTH CORNER CONCRETE BLOCK BUILDING AT NE. CORNER ORIENT ROAD AND EAST BROADWAY, ELEVATION = 28.94; MEAN SEA LEVEL = 0.00.
- 7) ALL GUARD POST INDICATED BY: $\bullet$
- 8) ALL FINISH GRADES INDICATED BY: ∇

LEGAL DESCRIPTION:

A SURVEY OF LOTS 8,9,10,11,12,13, AND 14, BLOCK 1, OF ORIENT PARK SUBDIVISION ACCORDING TO THE MAP OR PLAT THEREOF AS RECORDED IN PLAT BOOK 11, PAGE 7, OF THE PUBLIC RECORDS OF HILLSBOROUGH COUNTY, FLORIDA.


SECTION 14 TOWNSHIP 29 SOUTH, RANGE 19 EAST

INFORMATION WAS UTILIZED IN THE PREPARATION OF THIS SITE PLAN WAS TAKEN FROM A SURVEY PREPARED BY EARL W. RAMER FLORIDA REG. LAND SURVEYOR NO.3618. AND I HEREBY GIVE CREDIT.

DATE	REVISION	BY	SCALE 1" = 20.0'	© 1999
12/20/99	1		CITY ENVIRONMENTAL SERVICE, INC. OF FLORIDA	
	2		7202 EAST EIGHT AVENUE	
	3		TAMPA, FLORIDA, 33619	
	4			
	5			


P.J. CALLAGHAN
GENERAL CONTRACTORS
LICENSE NO. CC000049
10529 48th ST. NO.
01582-276 FAX 079-9077

DATE 12/20/99
DRAWN BY RD
FILE # 1623
PAGE NO 2 OF 11
SHEET NO SP-2

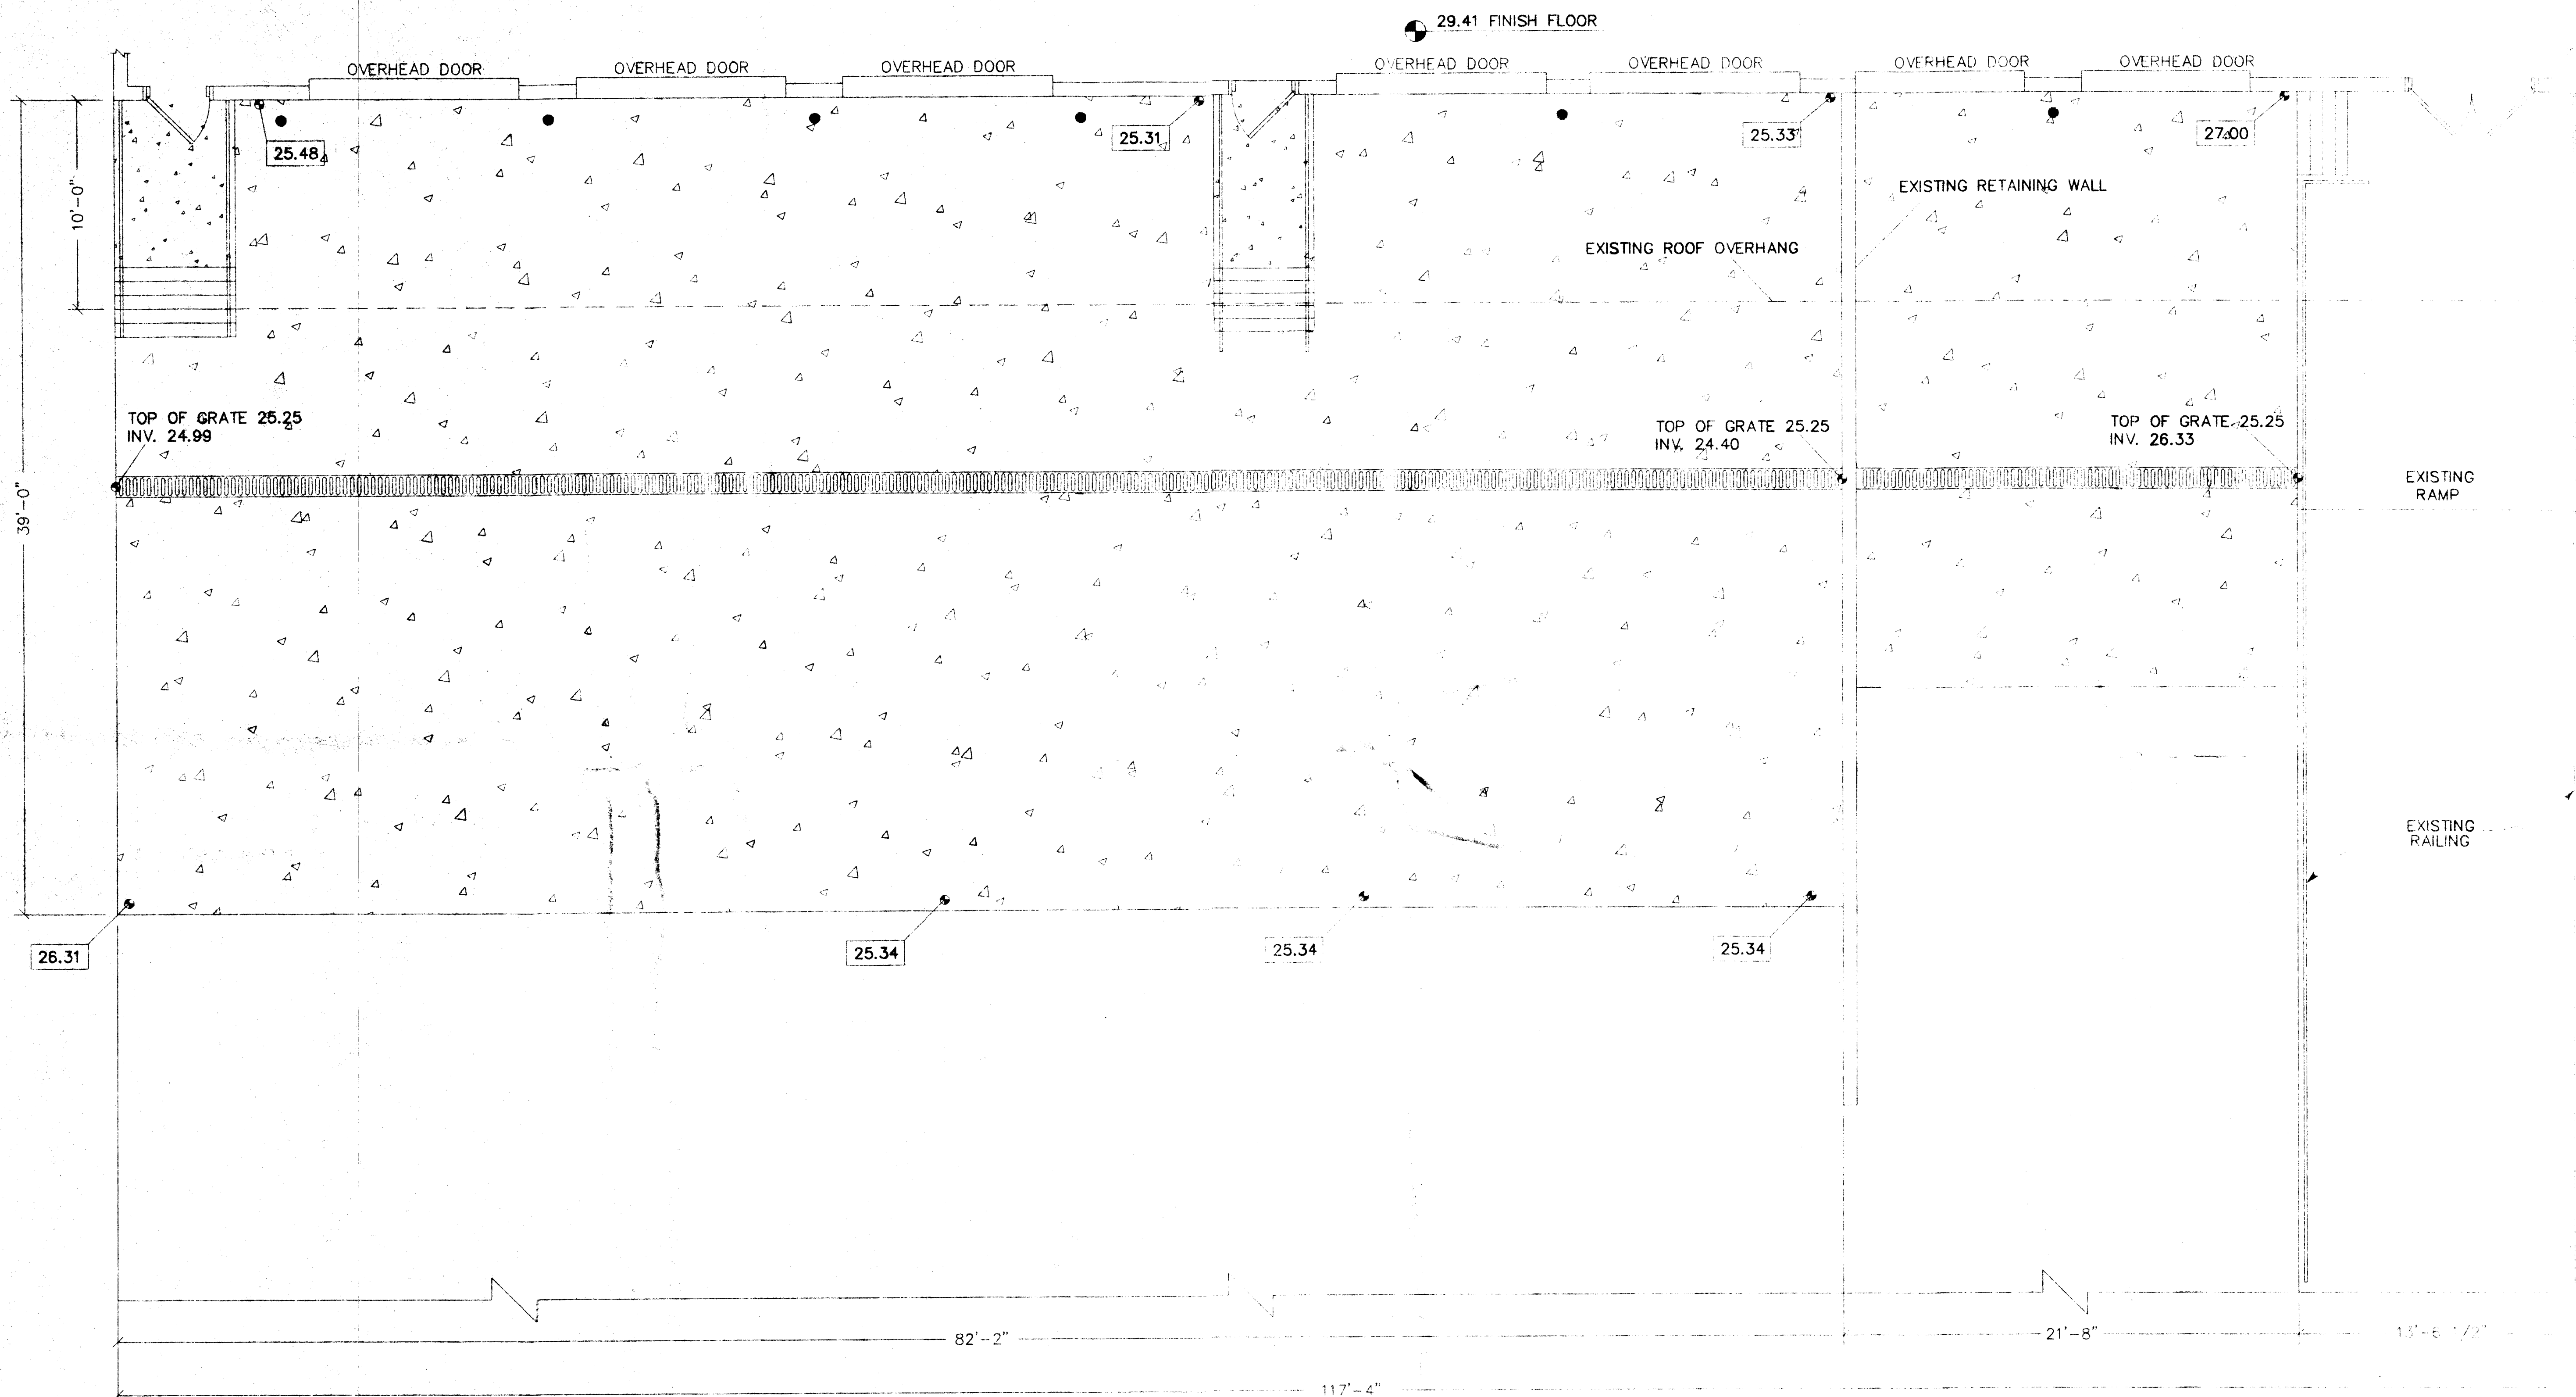


EXISTING LOADING DOCK FLOOR PLAN
SCALE 1/4" = 1'-0"

 KEY


-  CONCRETE
-  ASPHALT
-  EXISTING PIPE BOLLARD
-  EXISTING TRENCH DRAIN



DATE	REVISION	BY	SCALE 1/4" = 1'-0"	© 1999
	1		CITY ENVIRONMENTAL SERVICE, INC. OF FLORIDA	
	2		7202 EAST EIGHT AVENUE	
	3		TAMPA, FLORIDA, 33619	
	4			
	5			

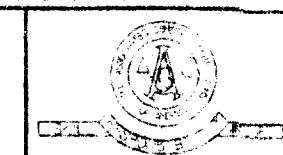


P.J. CALLAGHAN
GENERAL CONTRACTORS
LICENSE NO. 10525
10525 49th ST. NO.
CLEARWATER FL 33762
PH 573-2505, FAX 572-9077

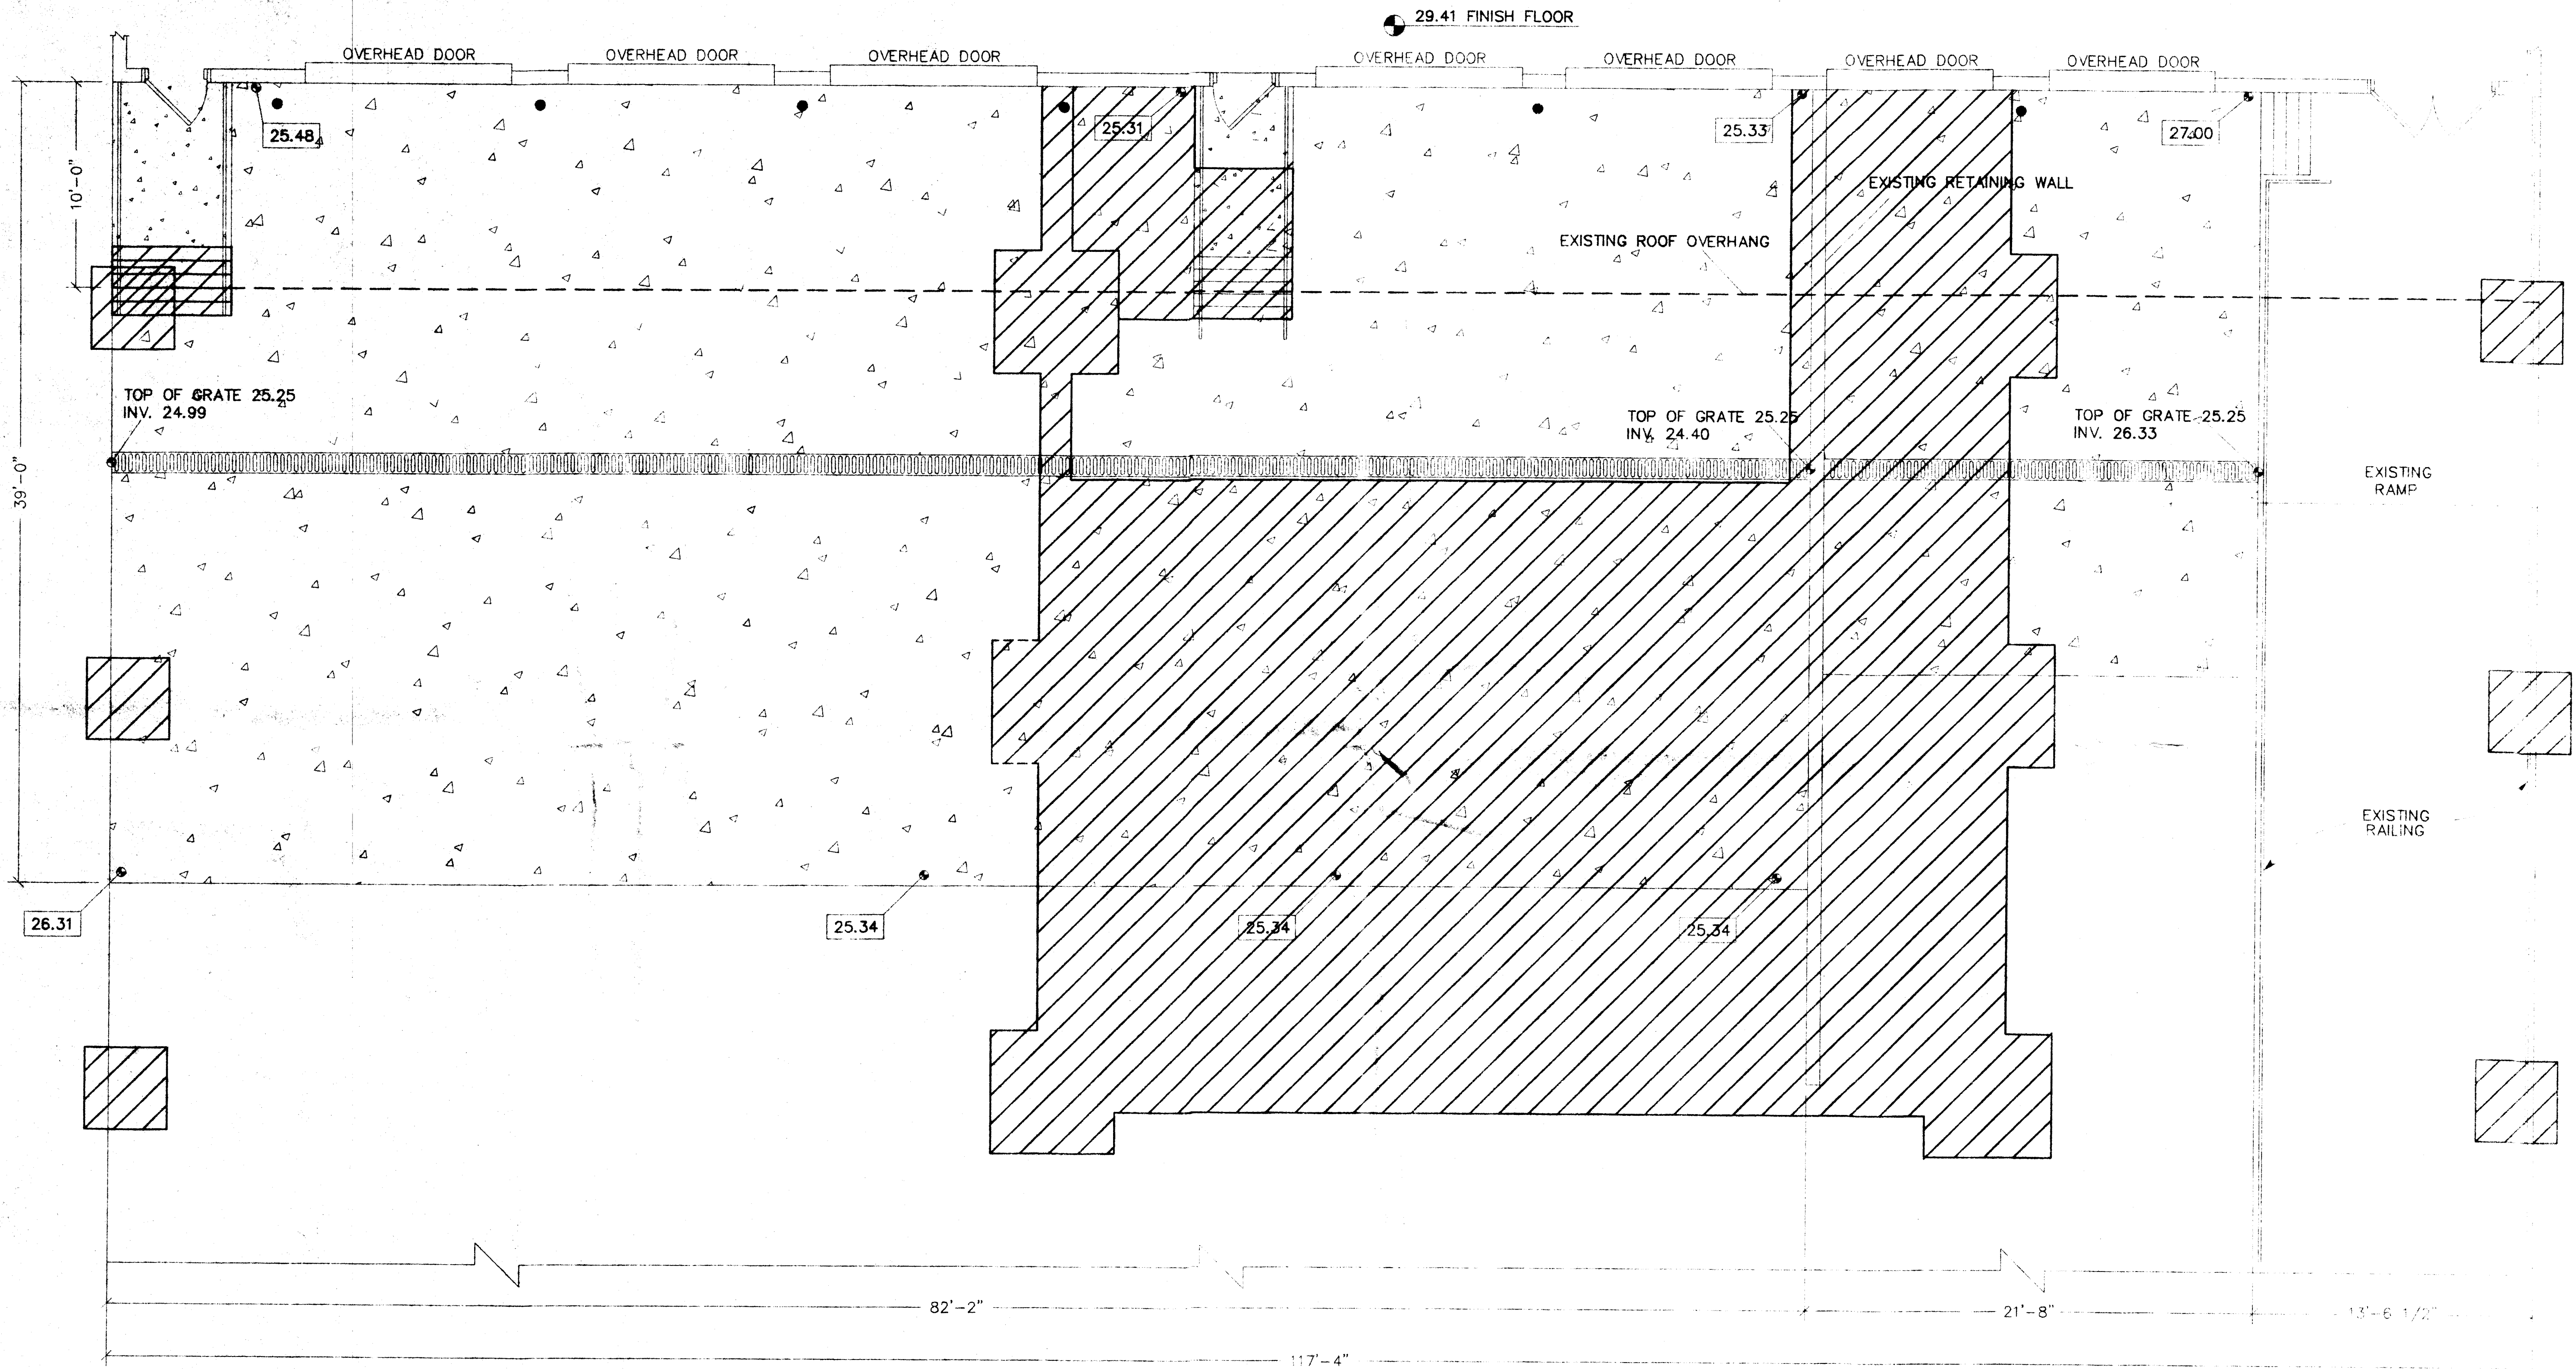

KEY

- CONCRETE
- ASPHALT
- EXISTING PIPE BOLLARD
- EXISTING TRENCH DRAIN
- AREAS OF DEMOLITION

DEMOLITION PLAN
SCALE 1/4" = 1'-0"

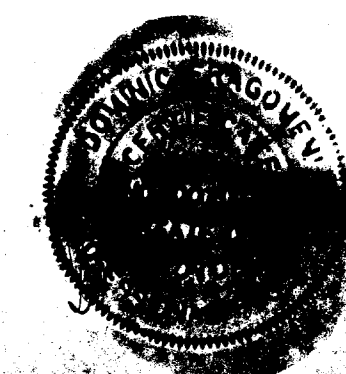


DATE	REVISION	BY	SCALE 1/4" = 1'-0"	© 1999
1			CITY ENVIRONMENTAL SERVICE, INC. OF FLORIDA	
2			7202 EAST EIGHT AVENUE	
3			TAMPA, FLORIDA, 33619	
4				
5				


P.J. CALLAGHAN

GENERAL CONTRACTORS
LICENSE NO. 10525
10525 4TH ST. NO.
CLEARWATER, FL 33762
PH 573-2505 FAX 572-8071

DATE: 12/15/99
DRAWN BY: RD
PROJECT: 1623
PAGE NO: 4 OF 11
SHEET NO: A-2

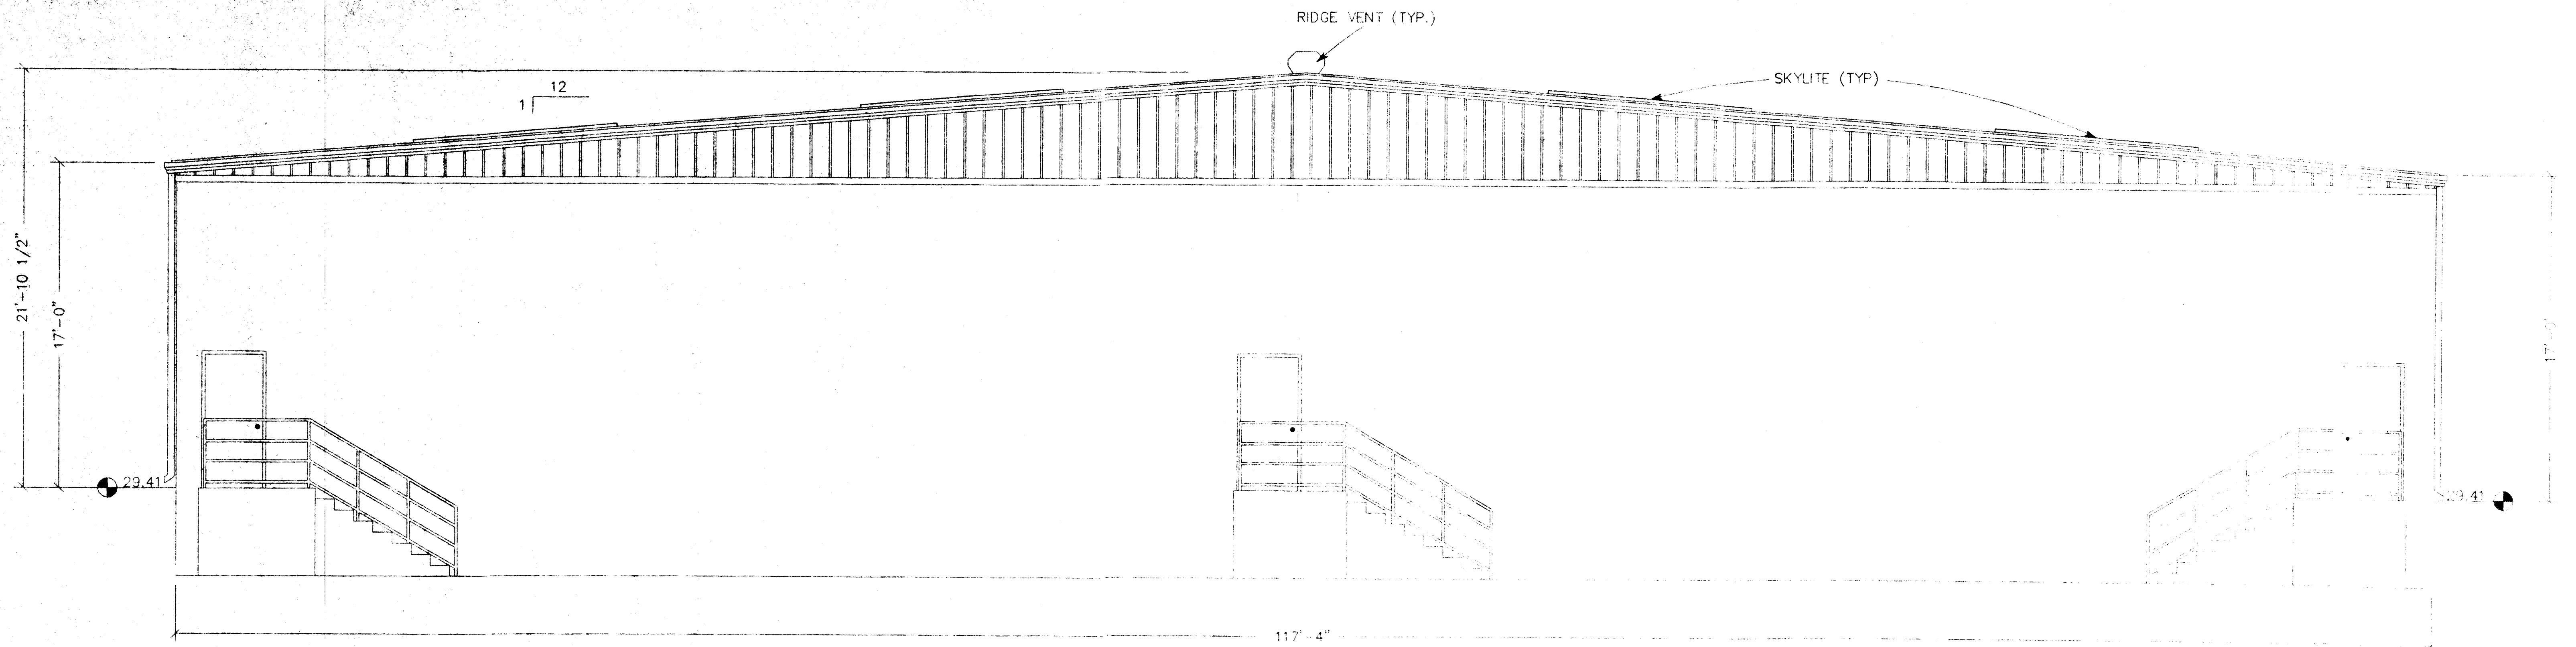

WEST ELEVATION
SCALE 1/4" = 1'-0"

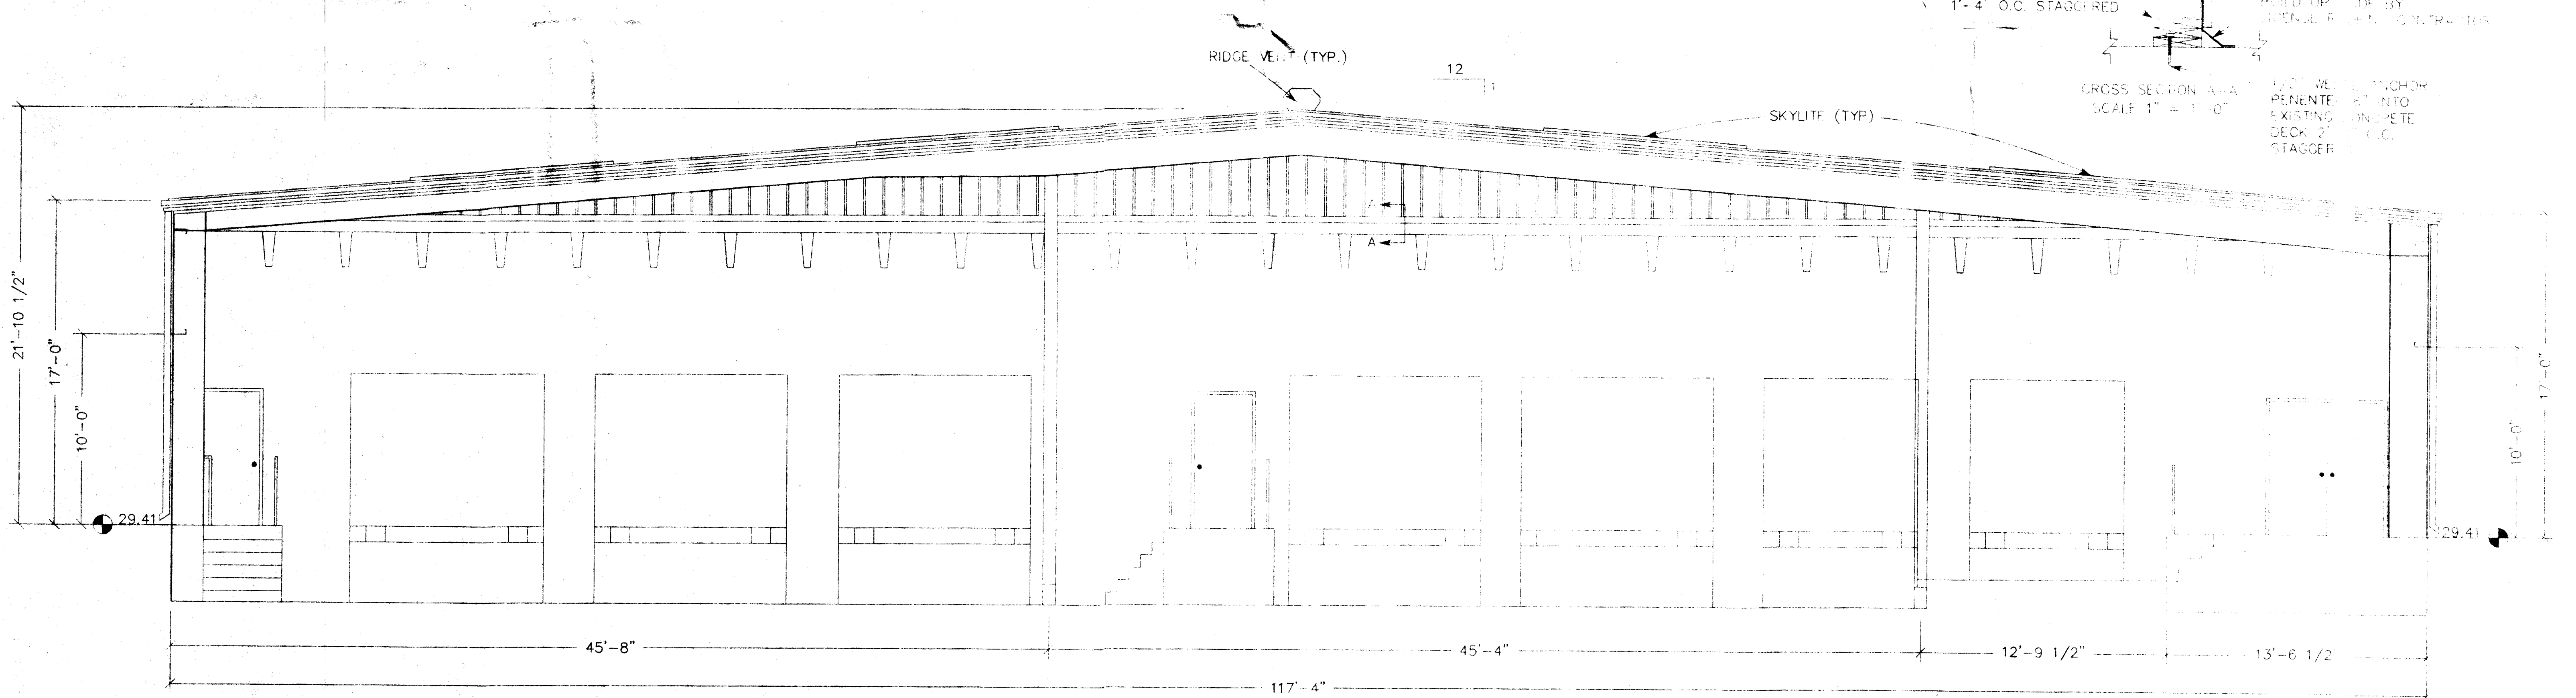

WEST ELEVATION
SCALE 1/4" = 1'-0"




DATE	REVISION	BY	SCALE 1/4" = 1'-0"	© 1999
	1			
	2			
	3			
	4			
	5			

CITY ENVIRONMENTAL, SERVICE, INC. OF FLORIDA
7202 EAST EIGHT AVENUE
TAMPA, FLORIDA, 33619




P.J. CALLAGHAN
GENERAL CONTRACTORS
LICENSE NO. 10523
10523 49th ST. NO.
CLEARWATER, FL 33762
PH 573-2505, FAX 572-9077

DATE 12/15/99
DRAWN BY FD
FILE # 1623
PAGE NO. 6 OF 11
SHEET NO. A-4

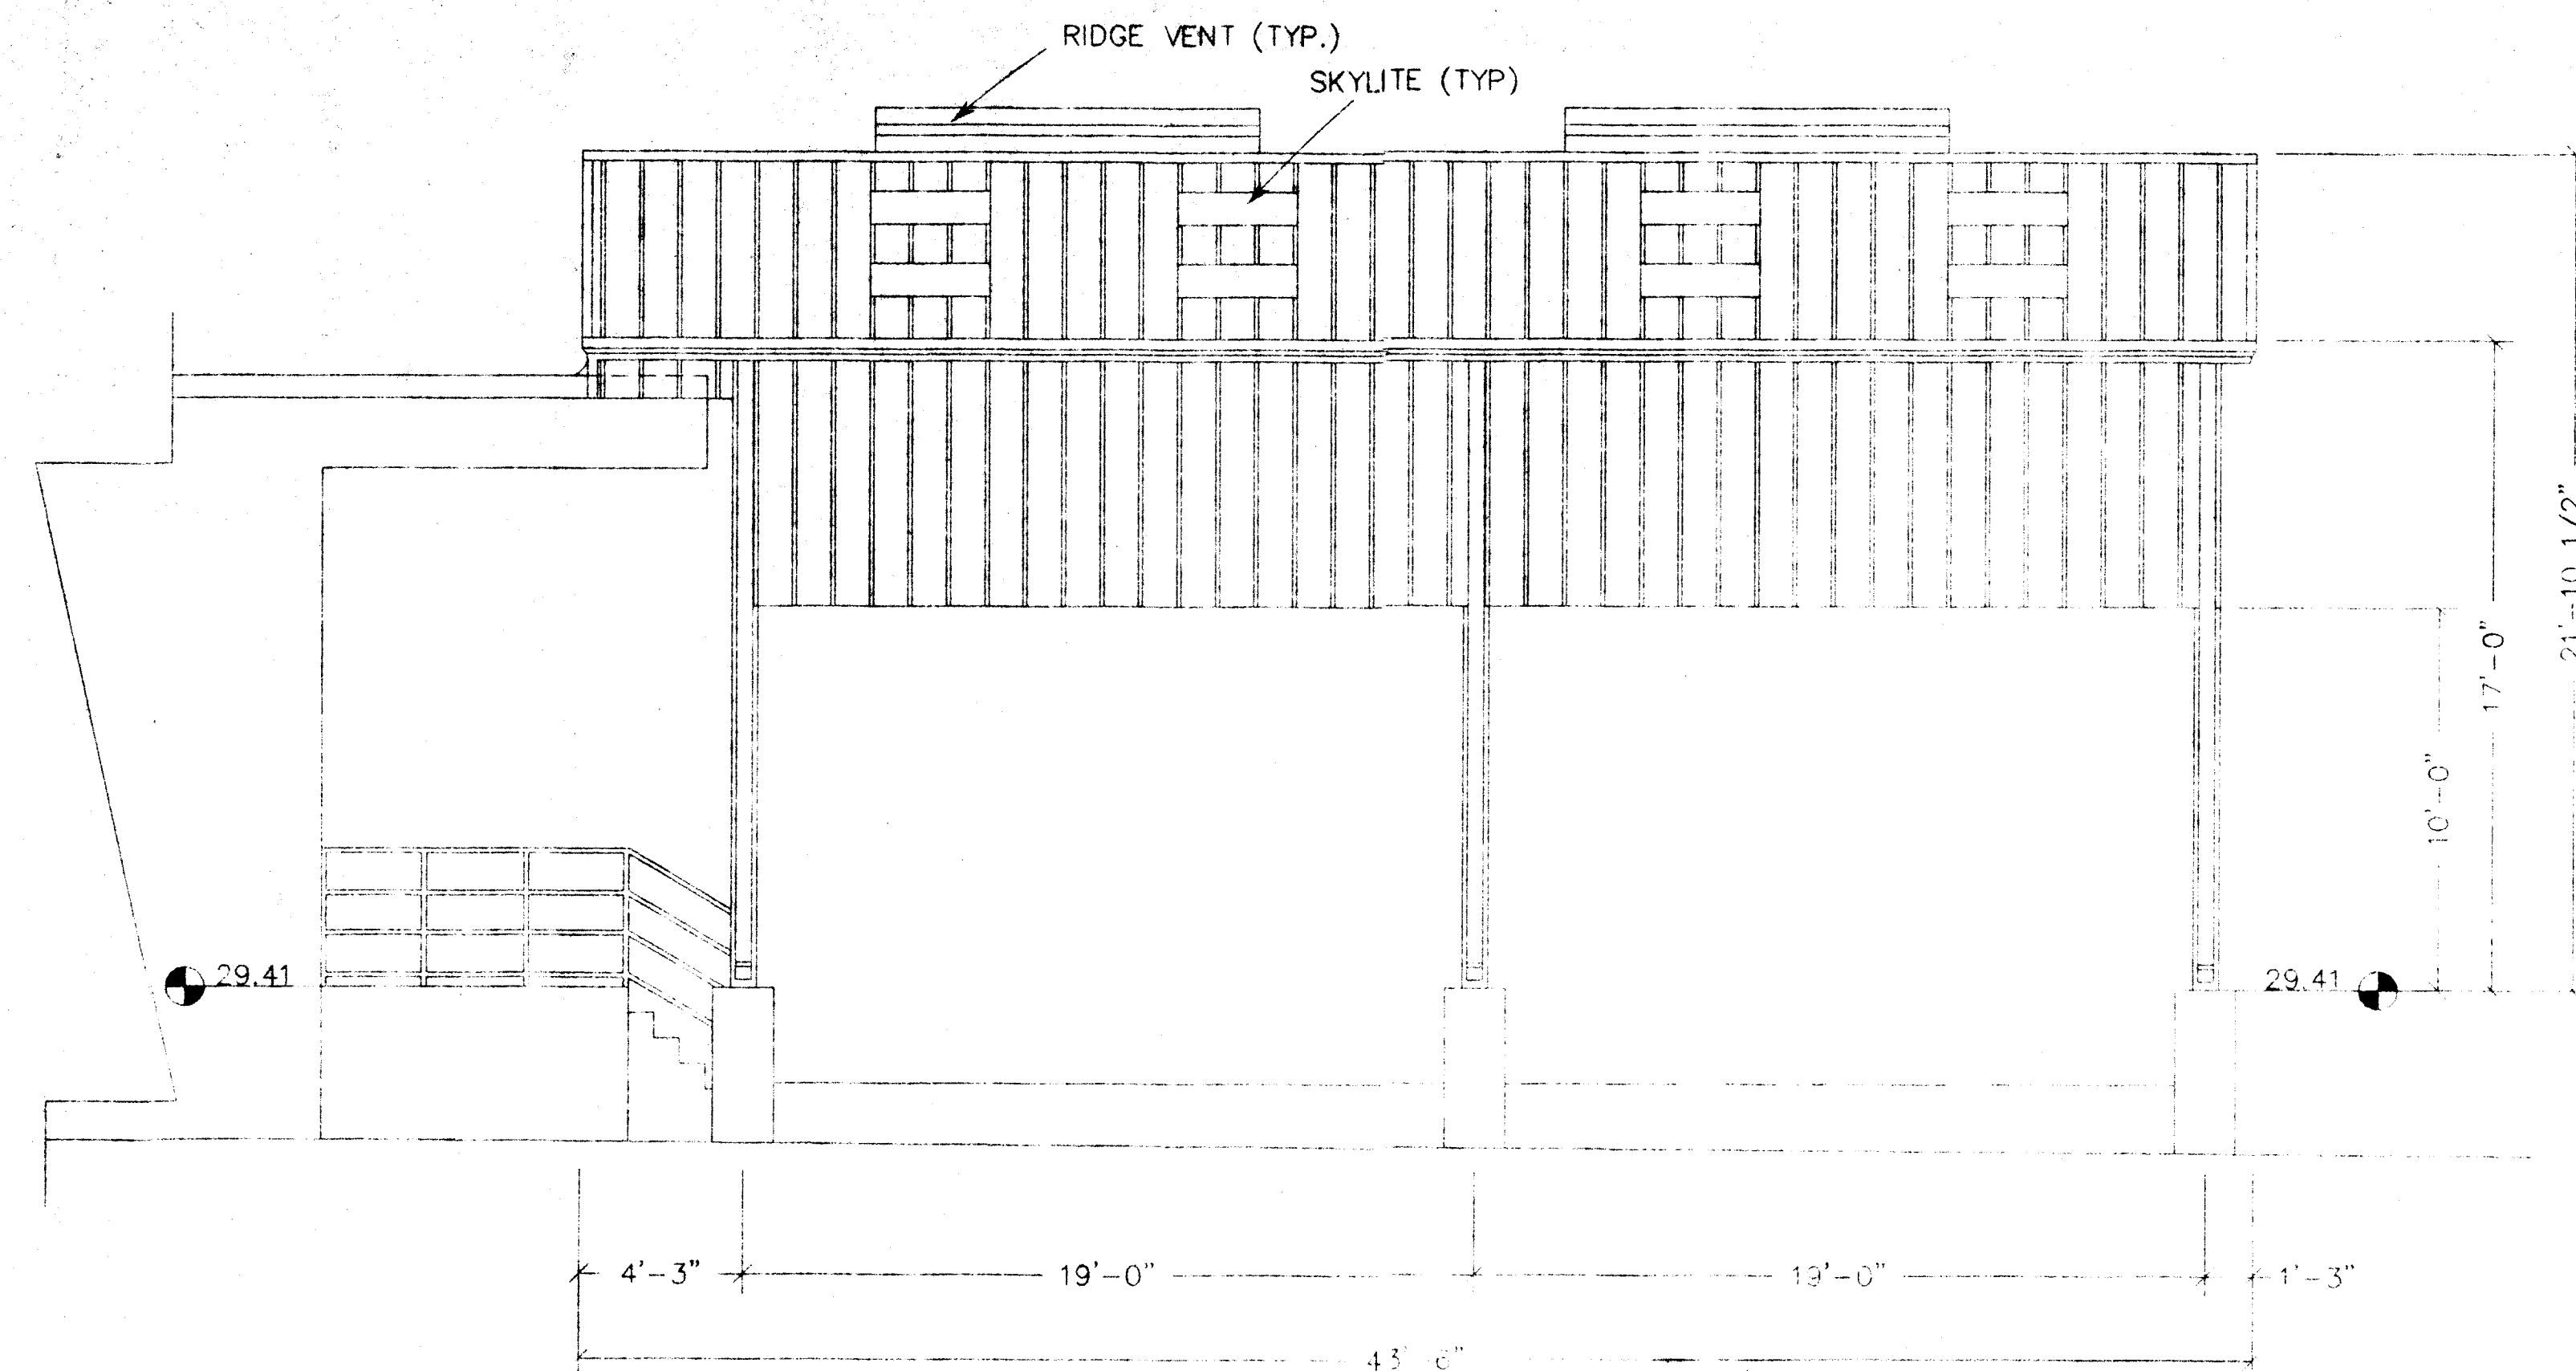

NORTH ELEVATION
SCALE 1/4" = 1'-0"

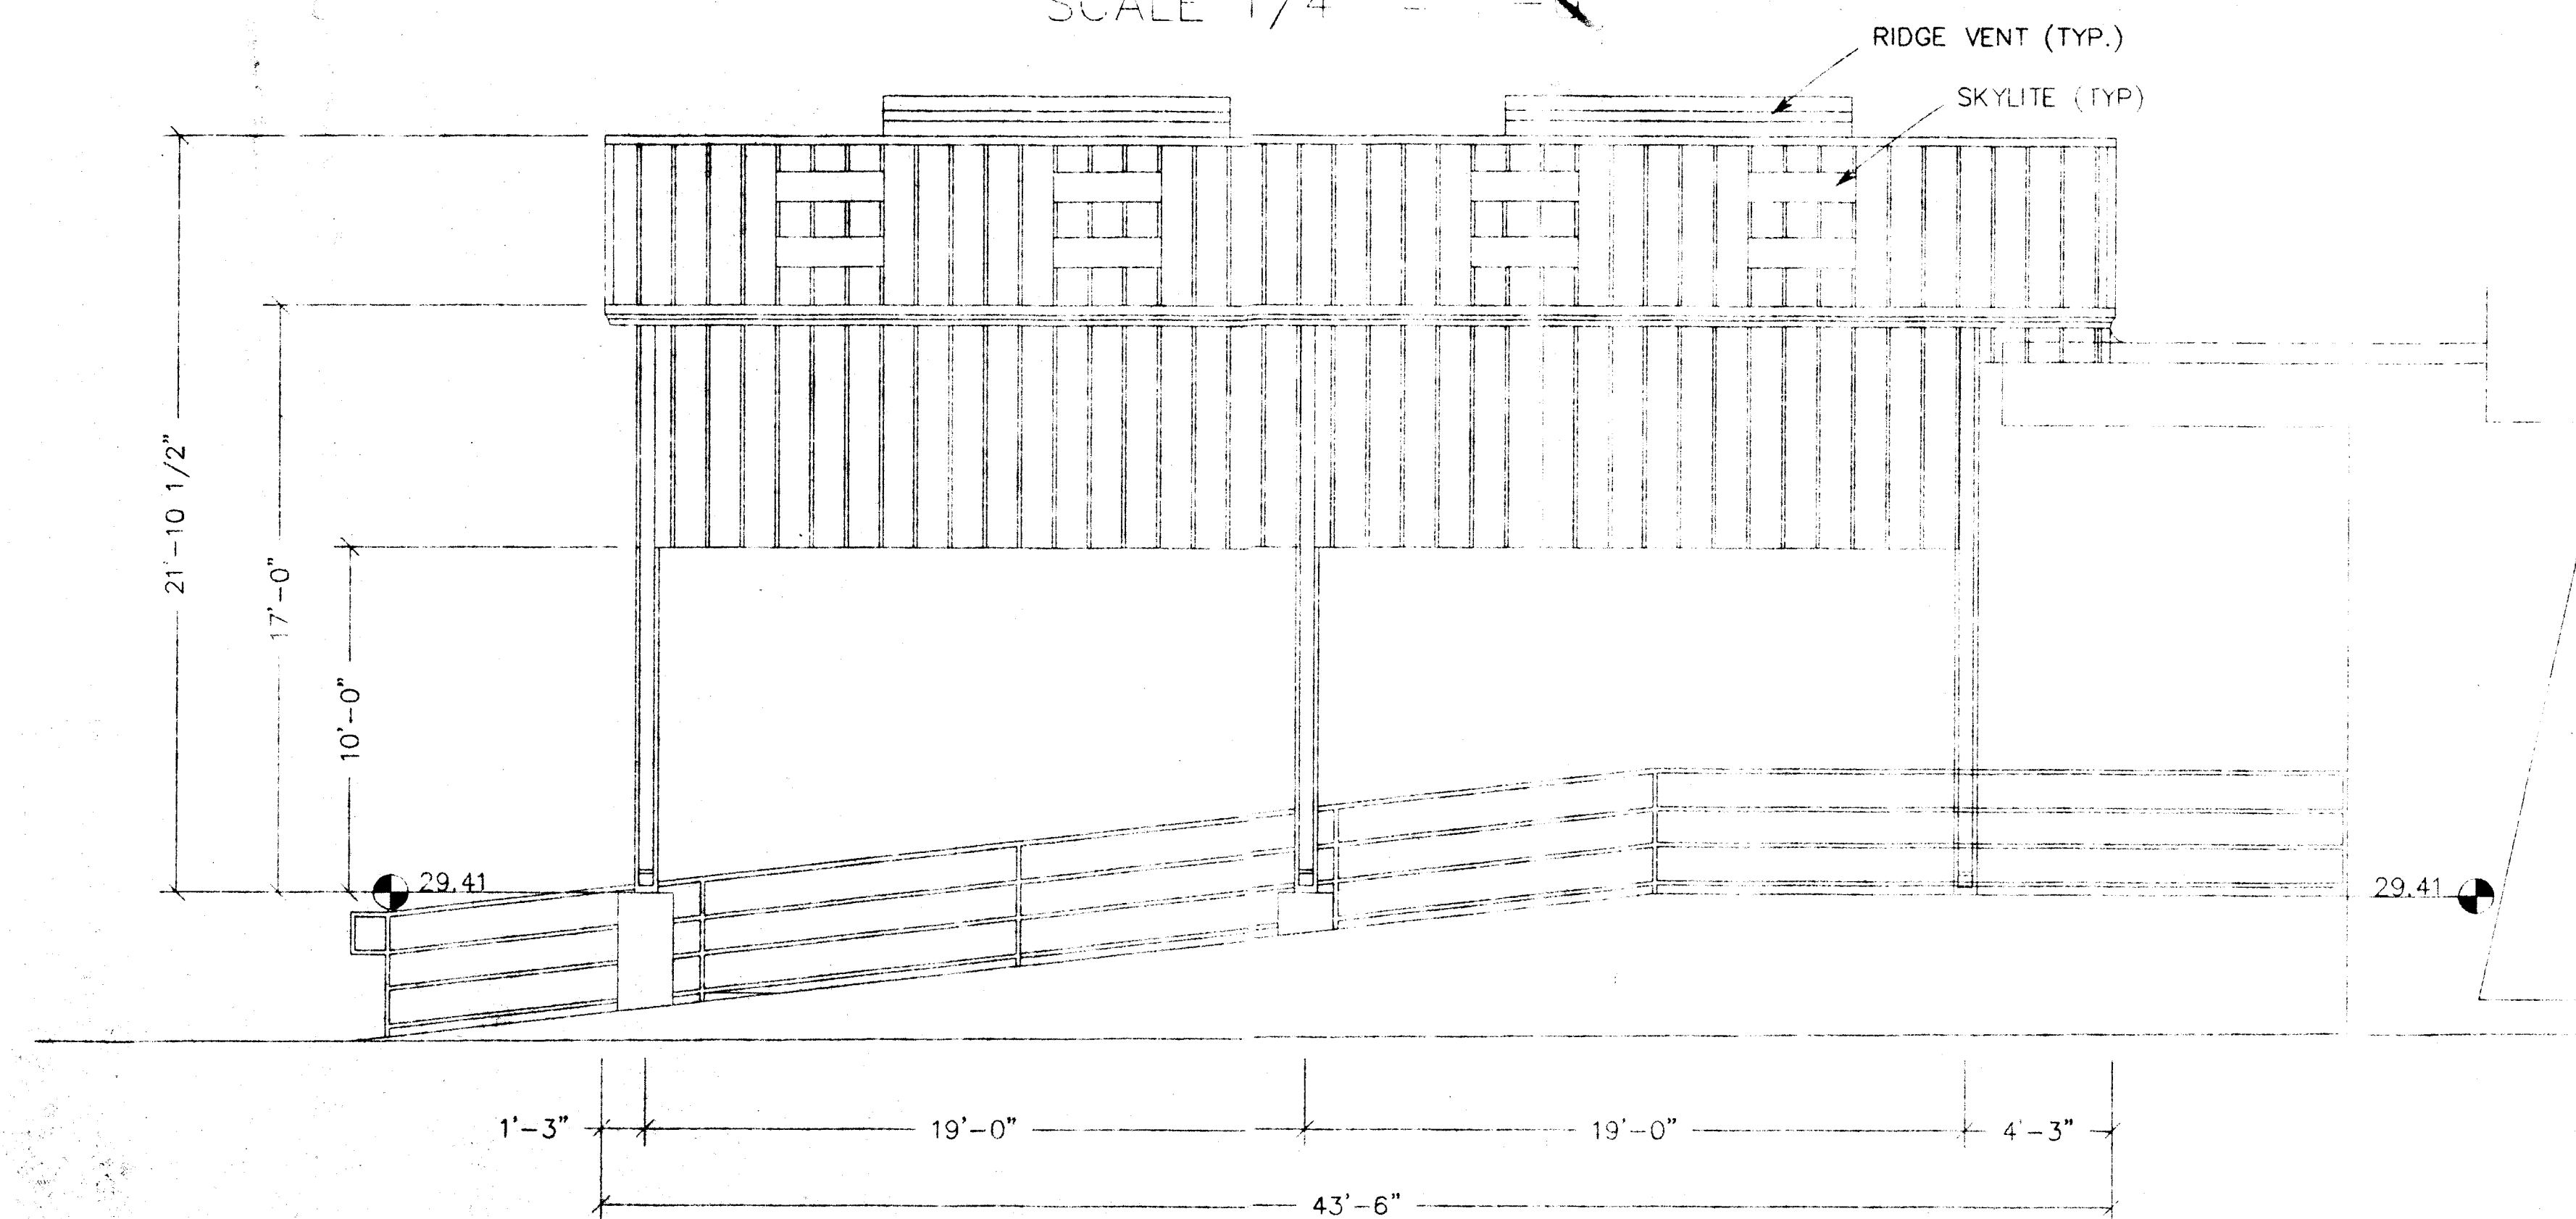


SOUTH ELEVATION
SCALE 1/4" = 1'-0"




DATE	REVISION	BY	SCALE 1/4" = 1'-0"	DATE
12/15/99	1			
	2			
	3			
	4			

CITY ENVIRONMENTAL SERVICE, INC. OF FLORIDA 7202 EAST EIGHT AVENUE TAMPA, FLORIDA, 33619			DATE 12/15/99
			DRAWN BY RD
			PAGE NO 1623
			SHEET NO 7 OF 11
			A-5

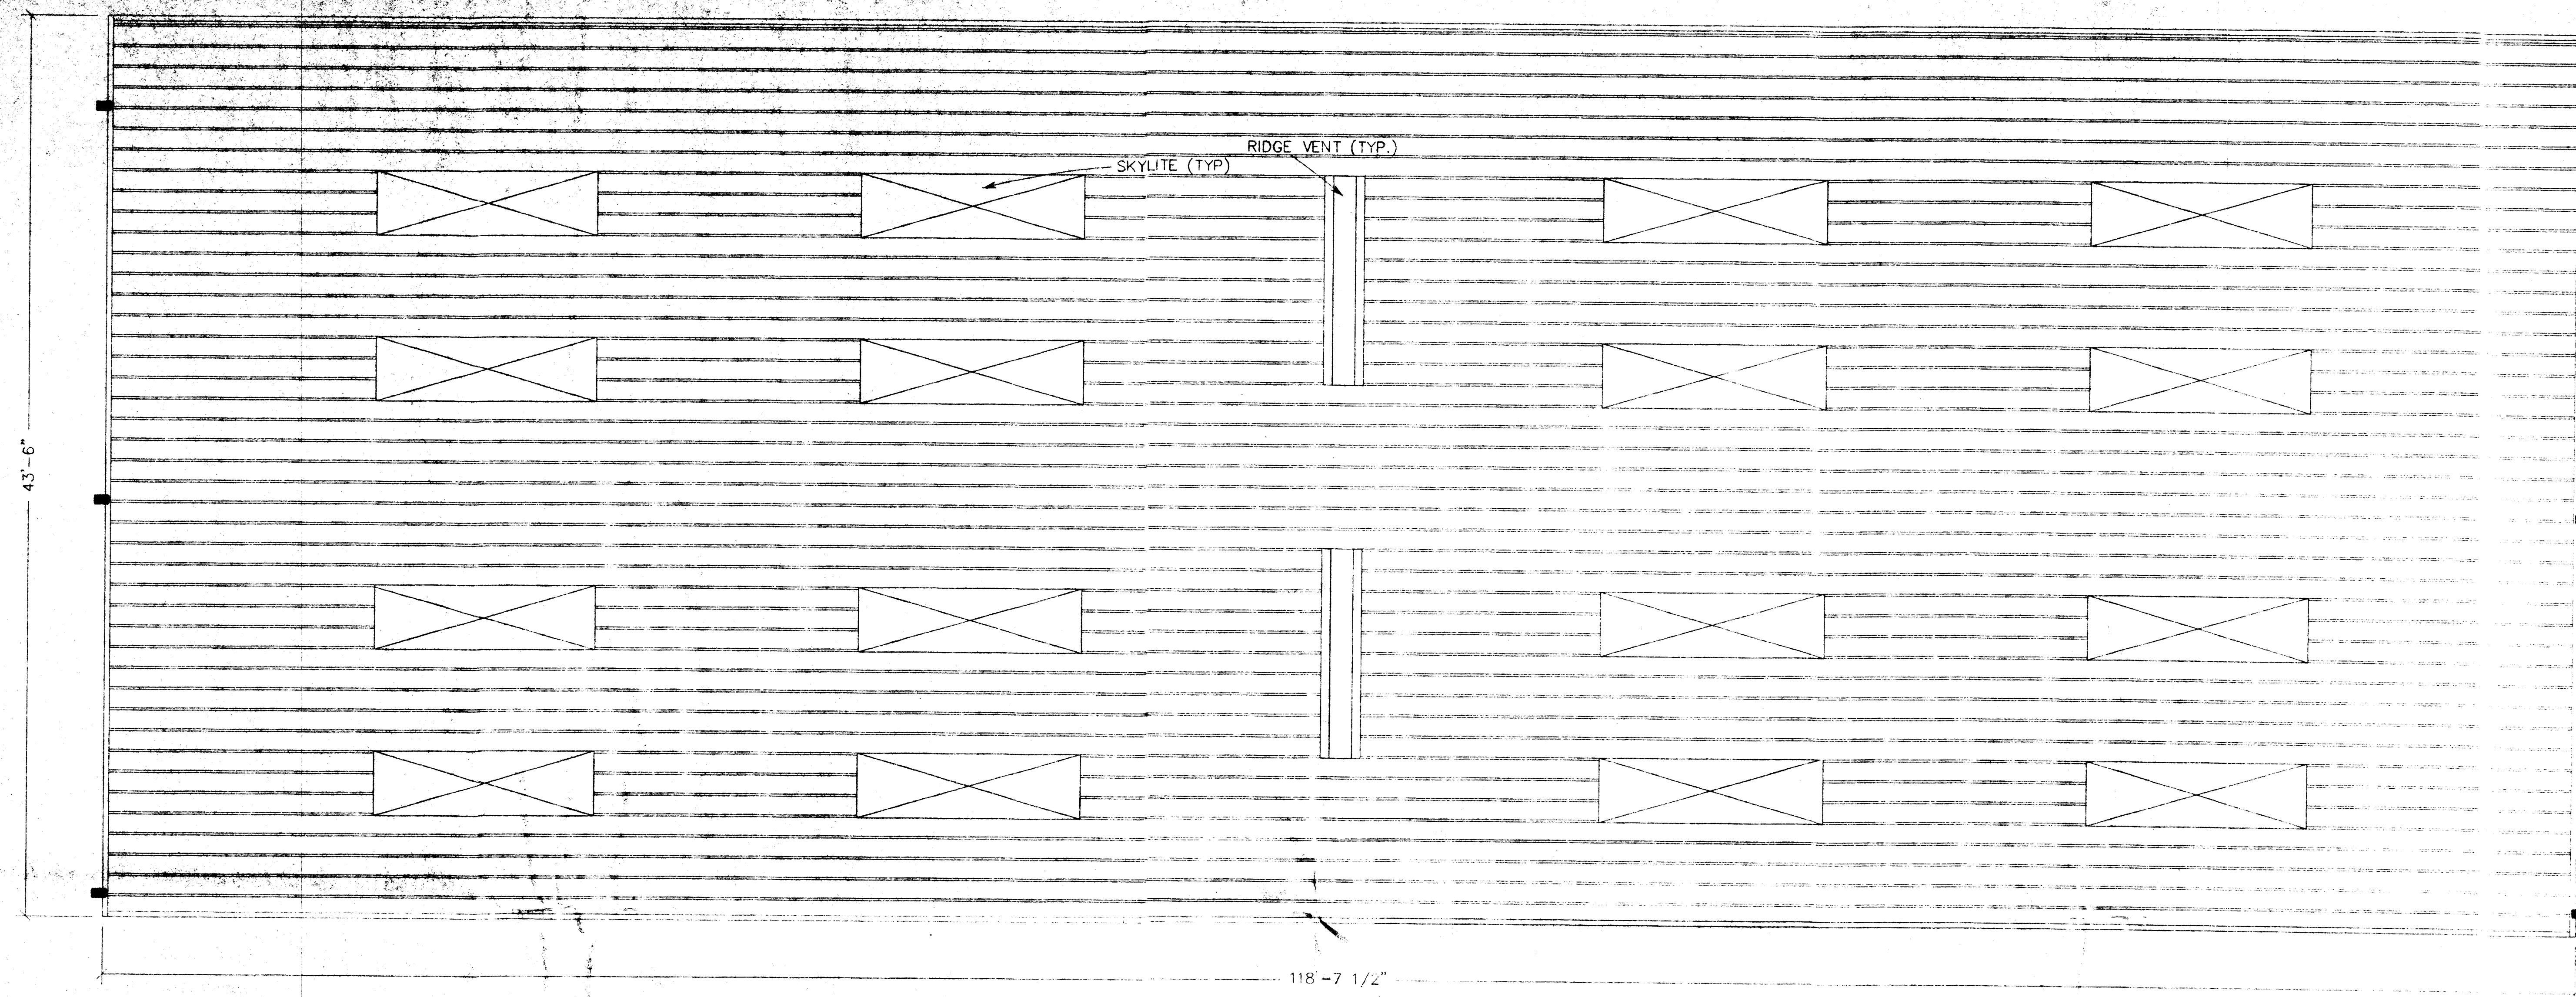



ROOF PANEL PLAN
SCALE 1/4" = 1'-0"

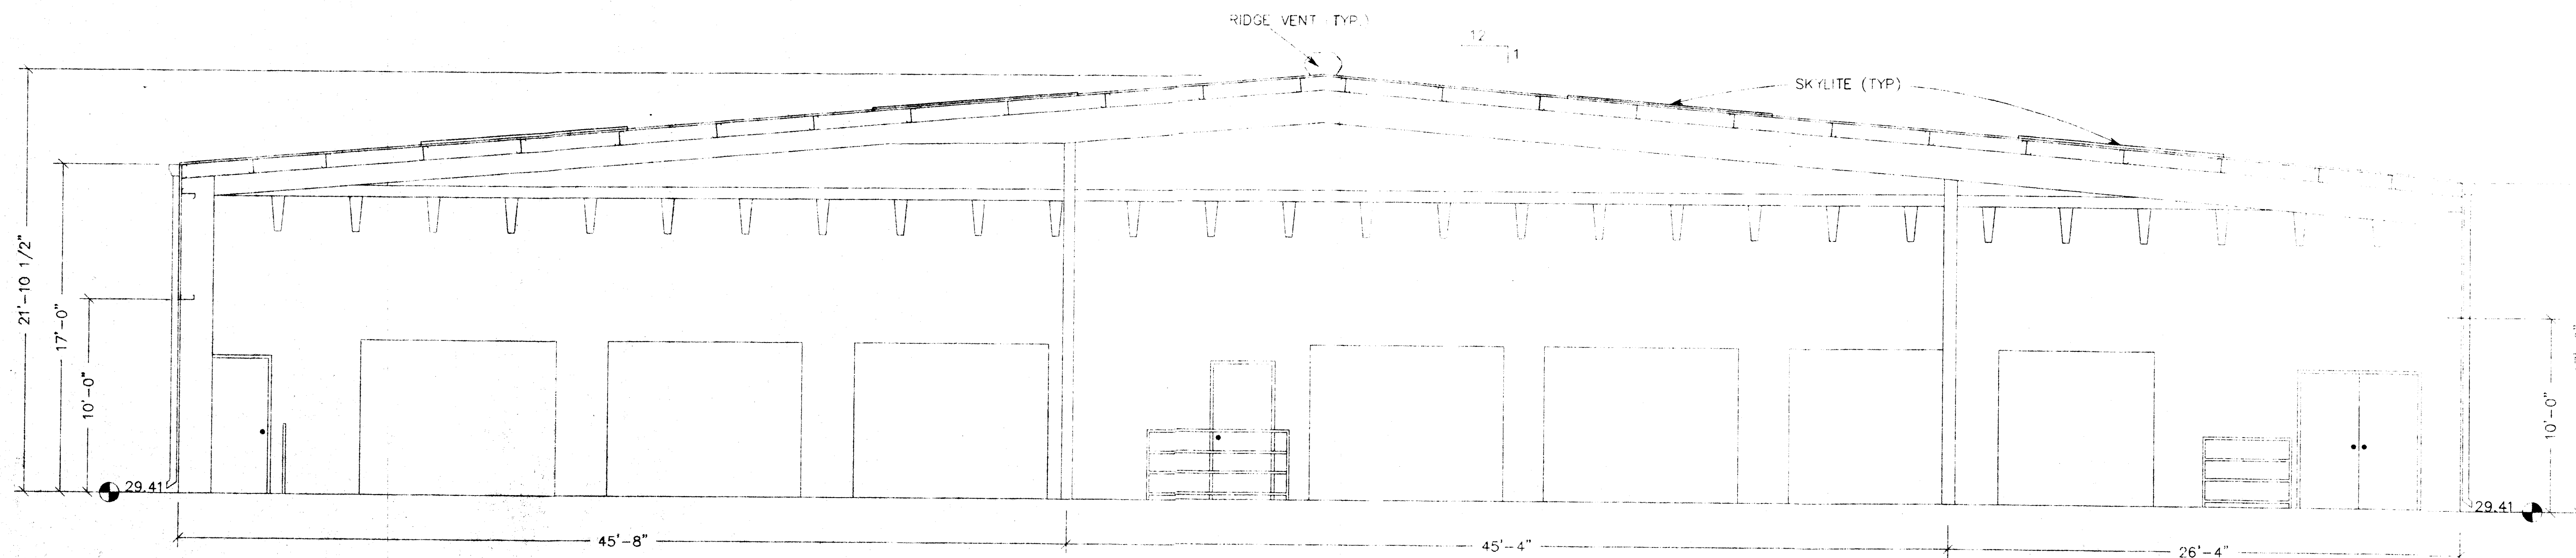


WALL SECTION
SCALE 1/4" = 1'-0"


DATE	REVISION	BY	SCALE 1/4" = 1'-0"	© 1999
1			CITY ENVIRONMENTAL SERVICE, INC. OF FLORIDA	
2			7202 EAST EIGHT AVENUE	
3			TAMPA, FLORIDA 33619	
4				
5				
6				

DATE	12/15/99
DESIGN BY	RD
FILE #	1623
SHEET NO.	8 OF 11
SHEET NO.	A-6

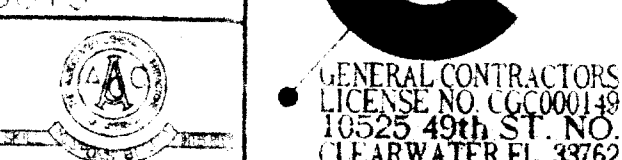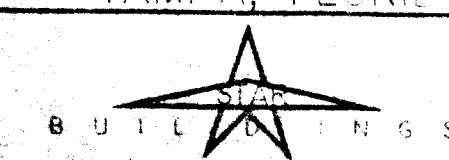


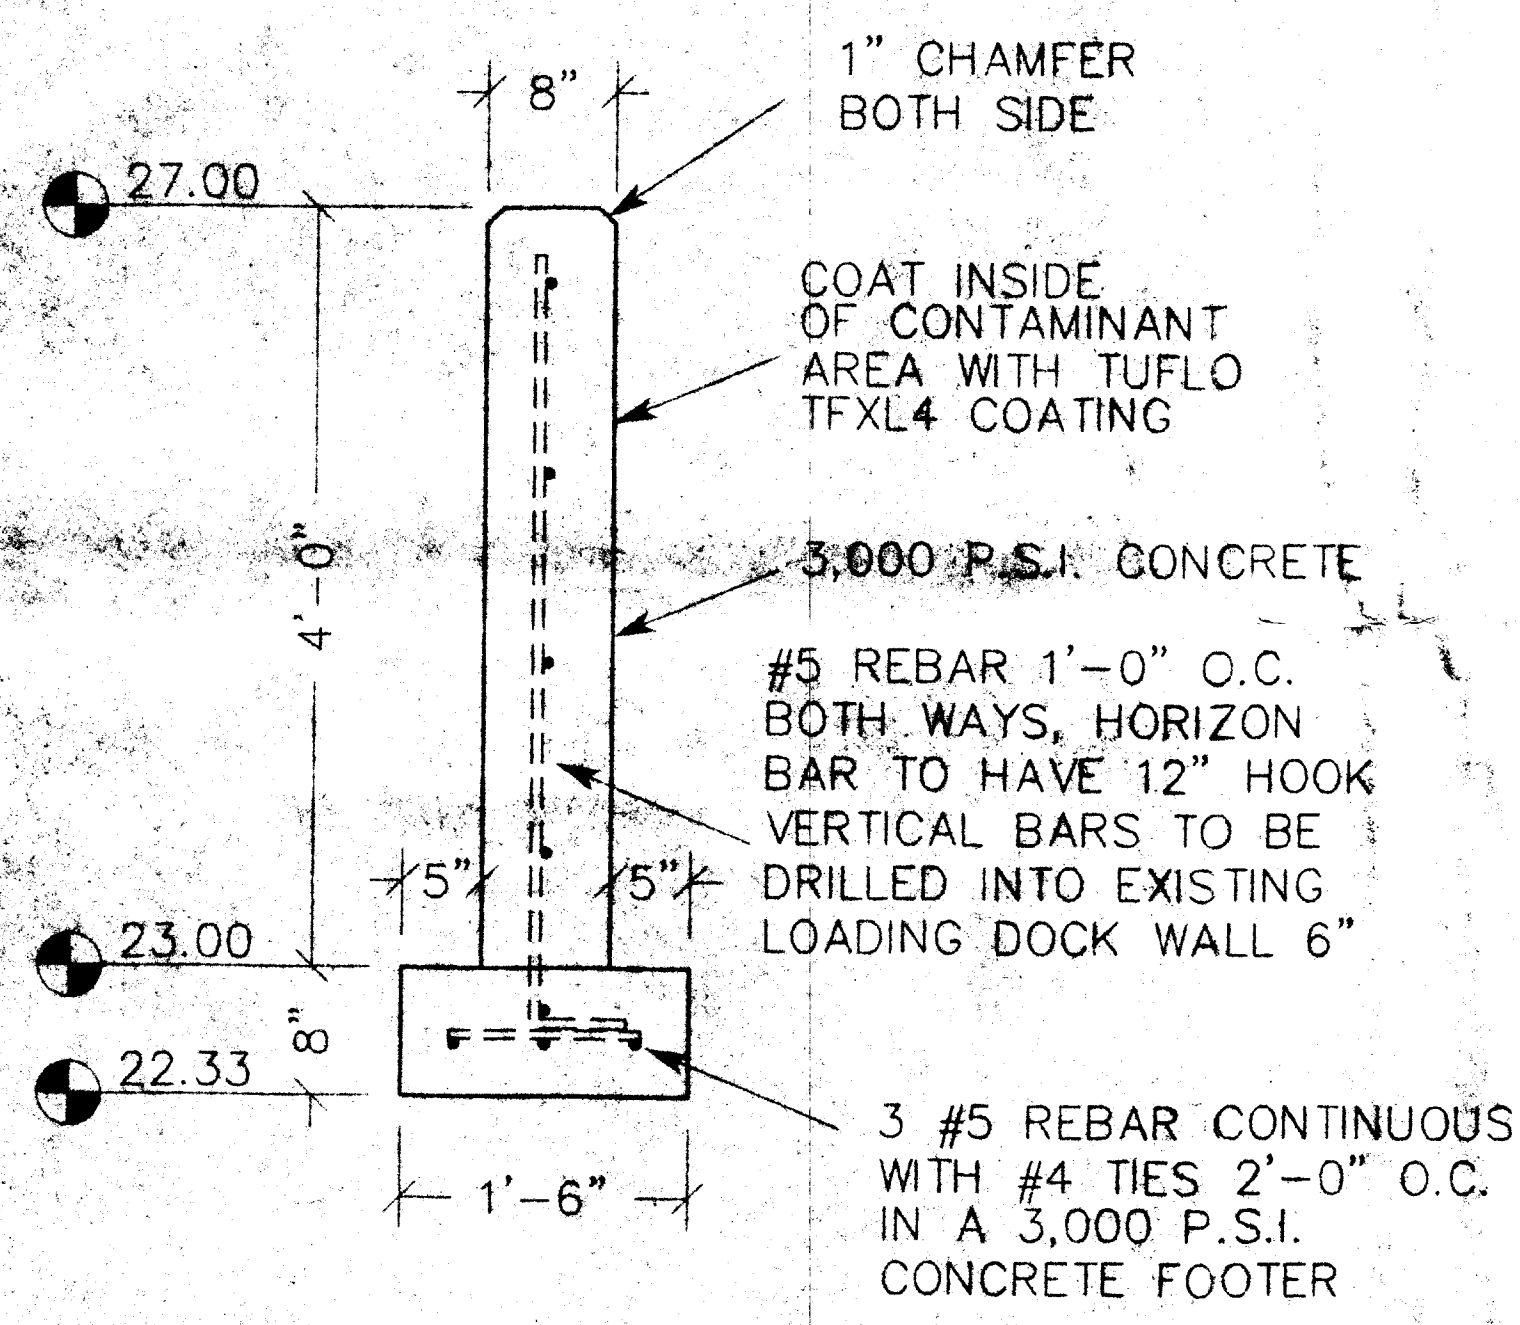

1
S-2 SEE PAGE S-1
SCALE 1" = 1'-0"

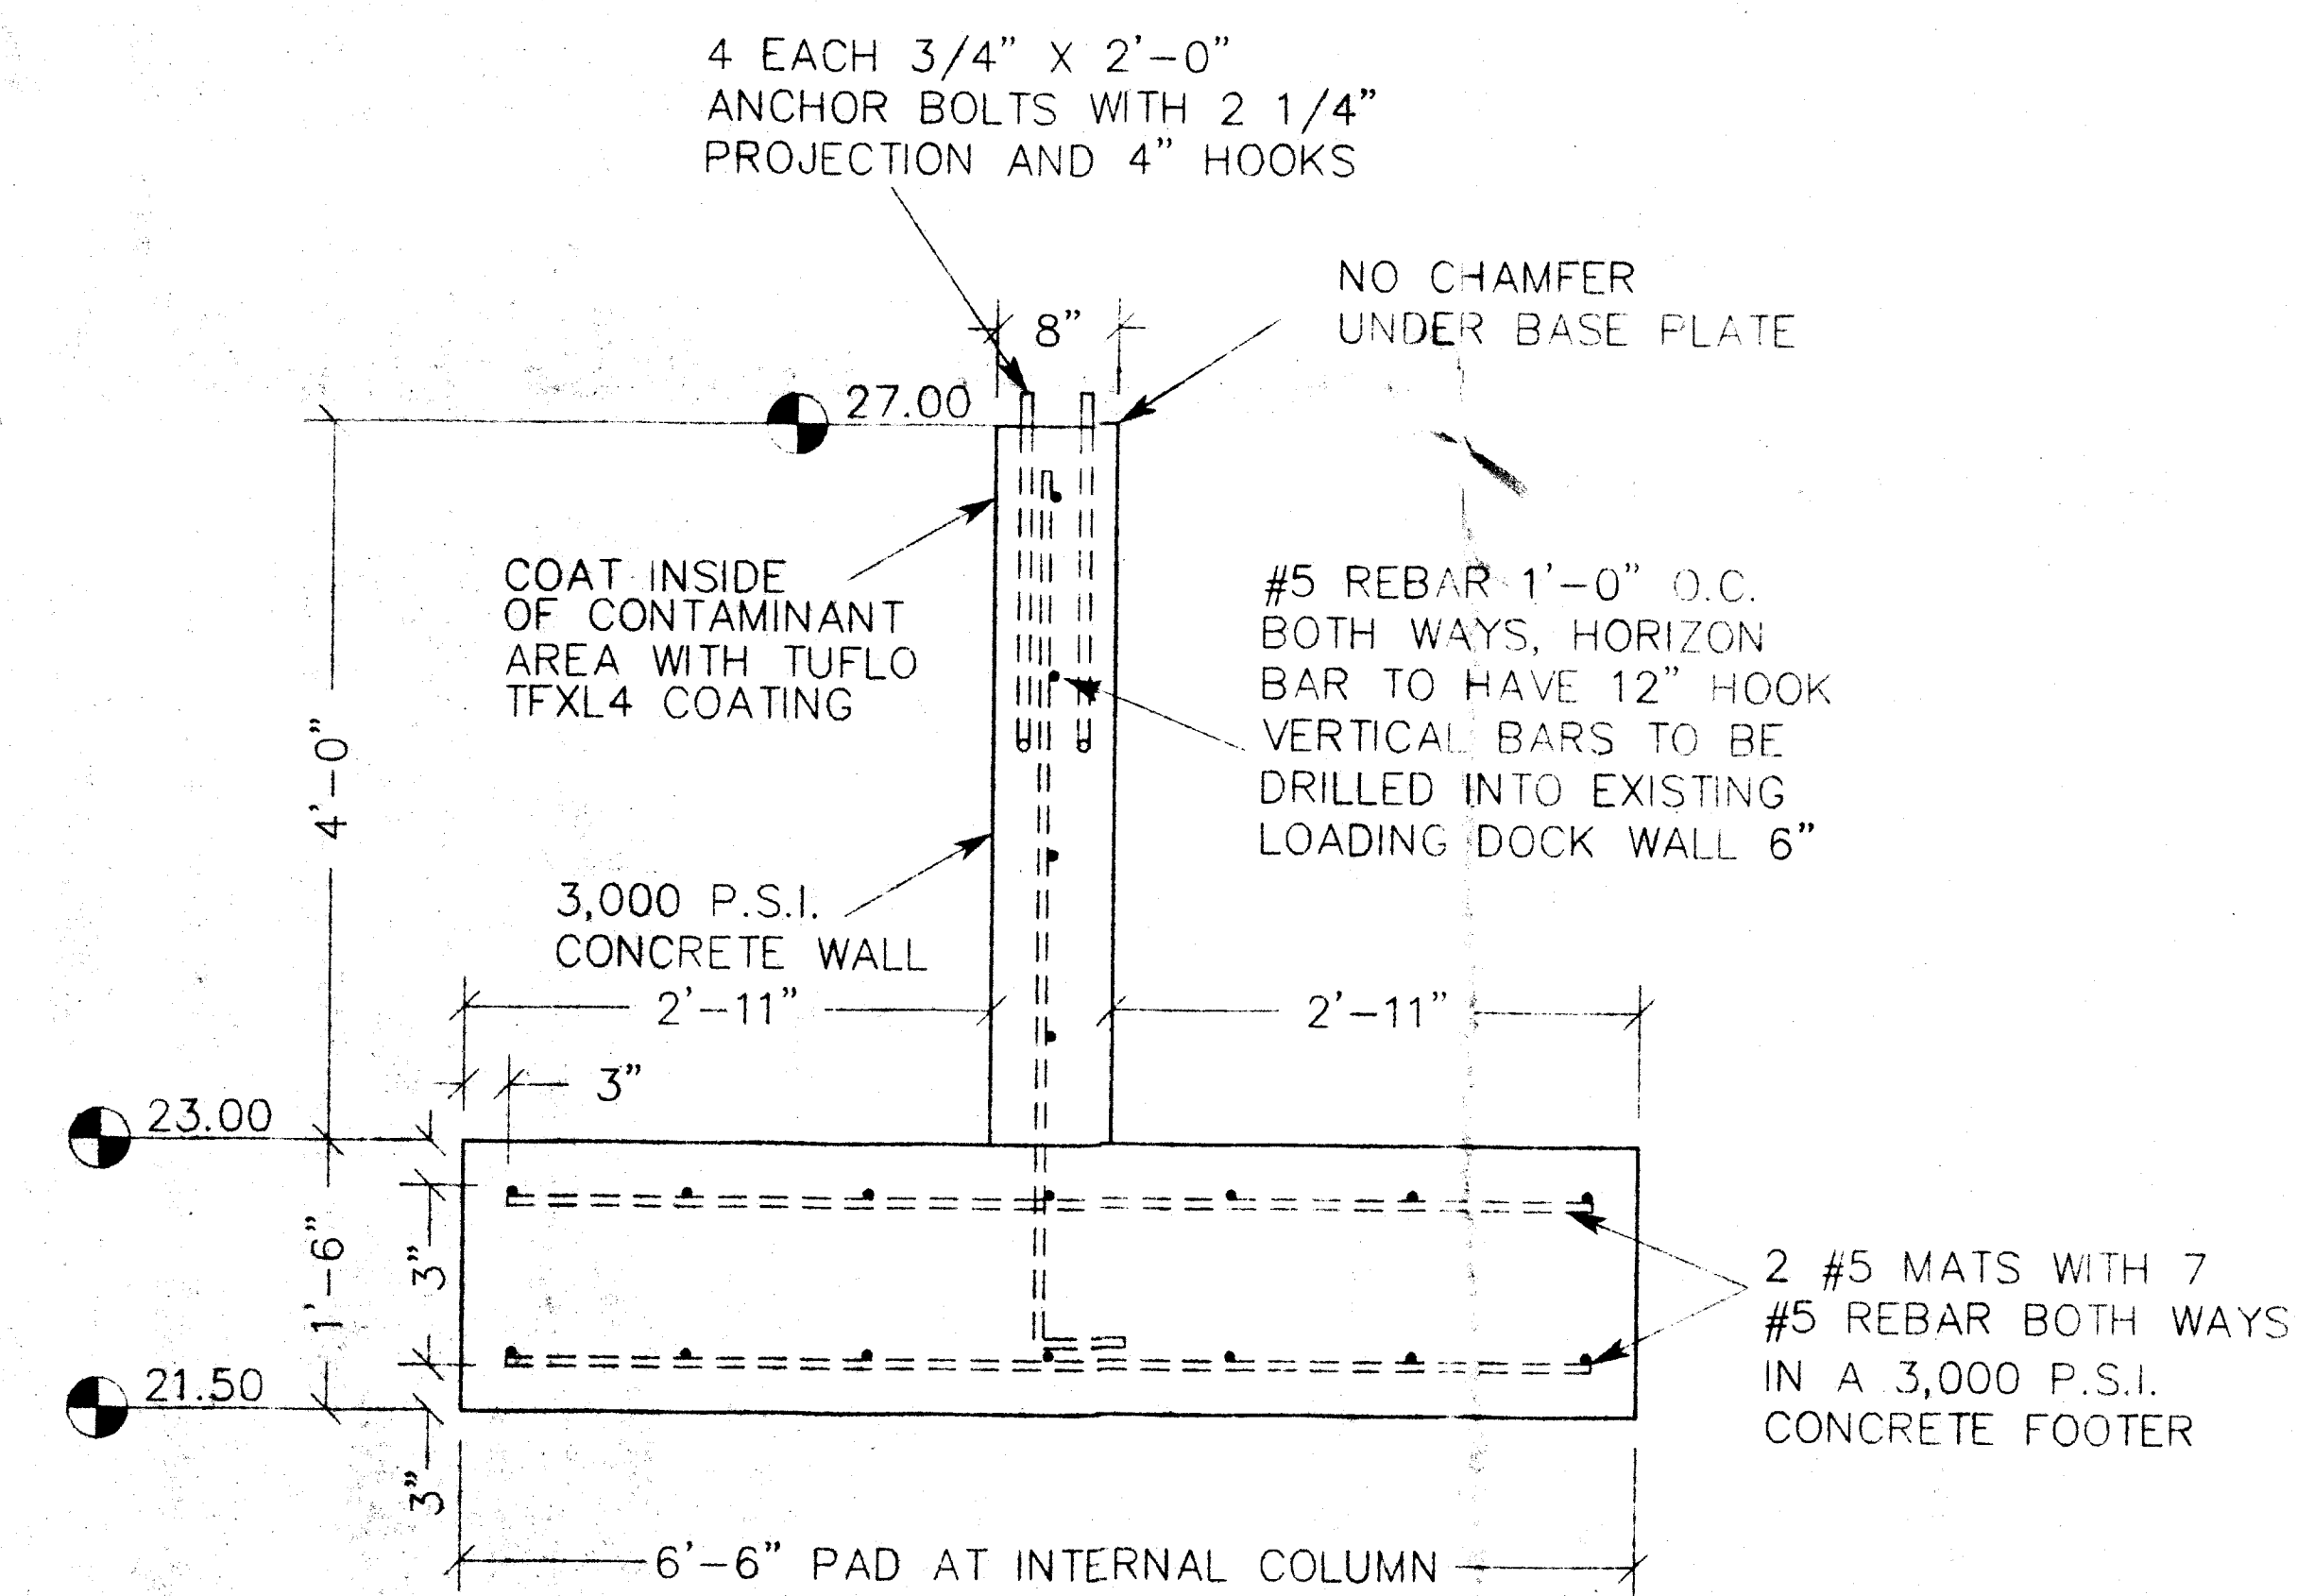

2
S-2 SEE PAGE S-1
SCALE 1" = 1'-0"

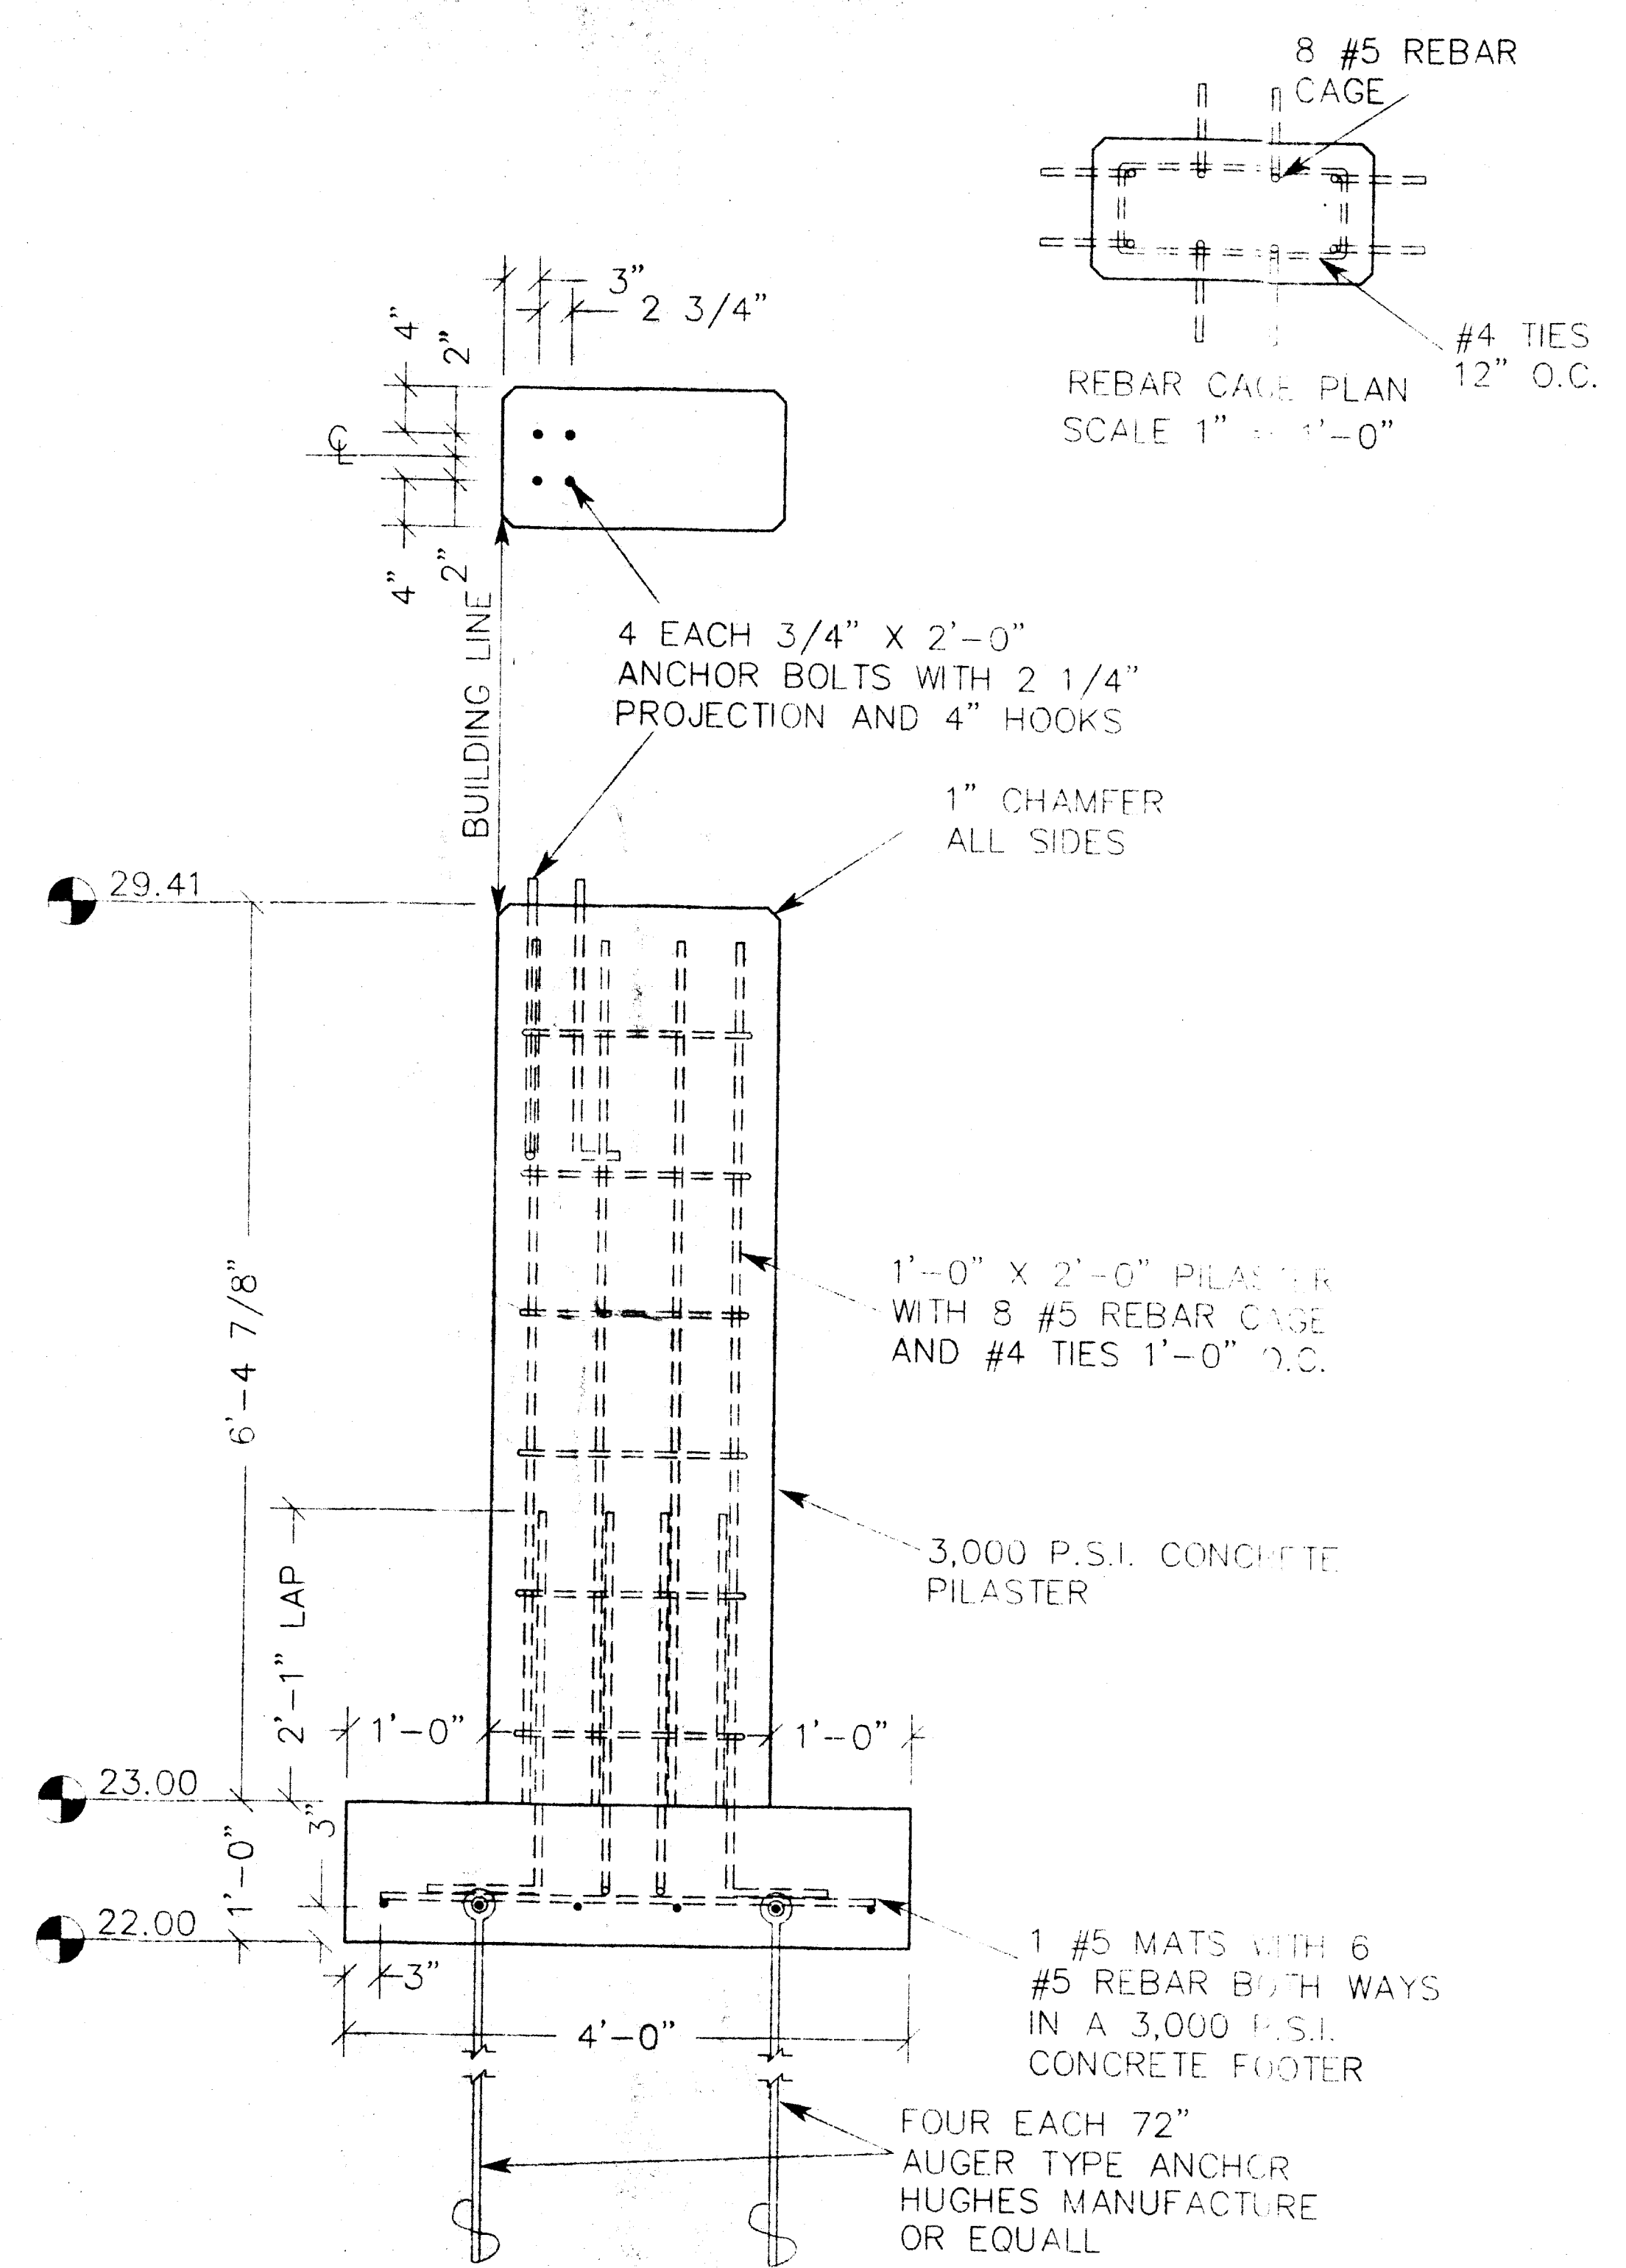

3
S-2 SEE PAGE S-1
SCALE 1" = 1'-0"


FOUNDATION DETAILS
SCALE 1" = 1'-0"

DATE	REVISION	BY	SCALE 1" = 1'-0"	© 1999
	1		CITY ENVIRONMENTAL SERVICE, INC. OF FLORIDA	
	2		7202 EAST EIGHT AVENUE	
	3		TAMPA, FLORIDA, 33619	
	4			
	5			

DATE	12/15/93
DRAWN BY	RD
FILE #	1623
PAGE NO	10 OF 11
SHEET NO	S-2


P.J. CALLAGHAN

GENERAL CONTRACTORS
LICENSE NO. CC-000146
10525 48TH ST. NO.
CLEARWATER, FL 33762

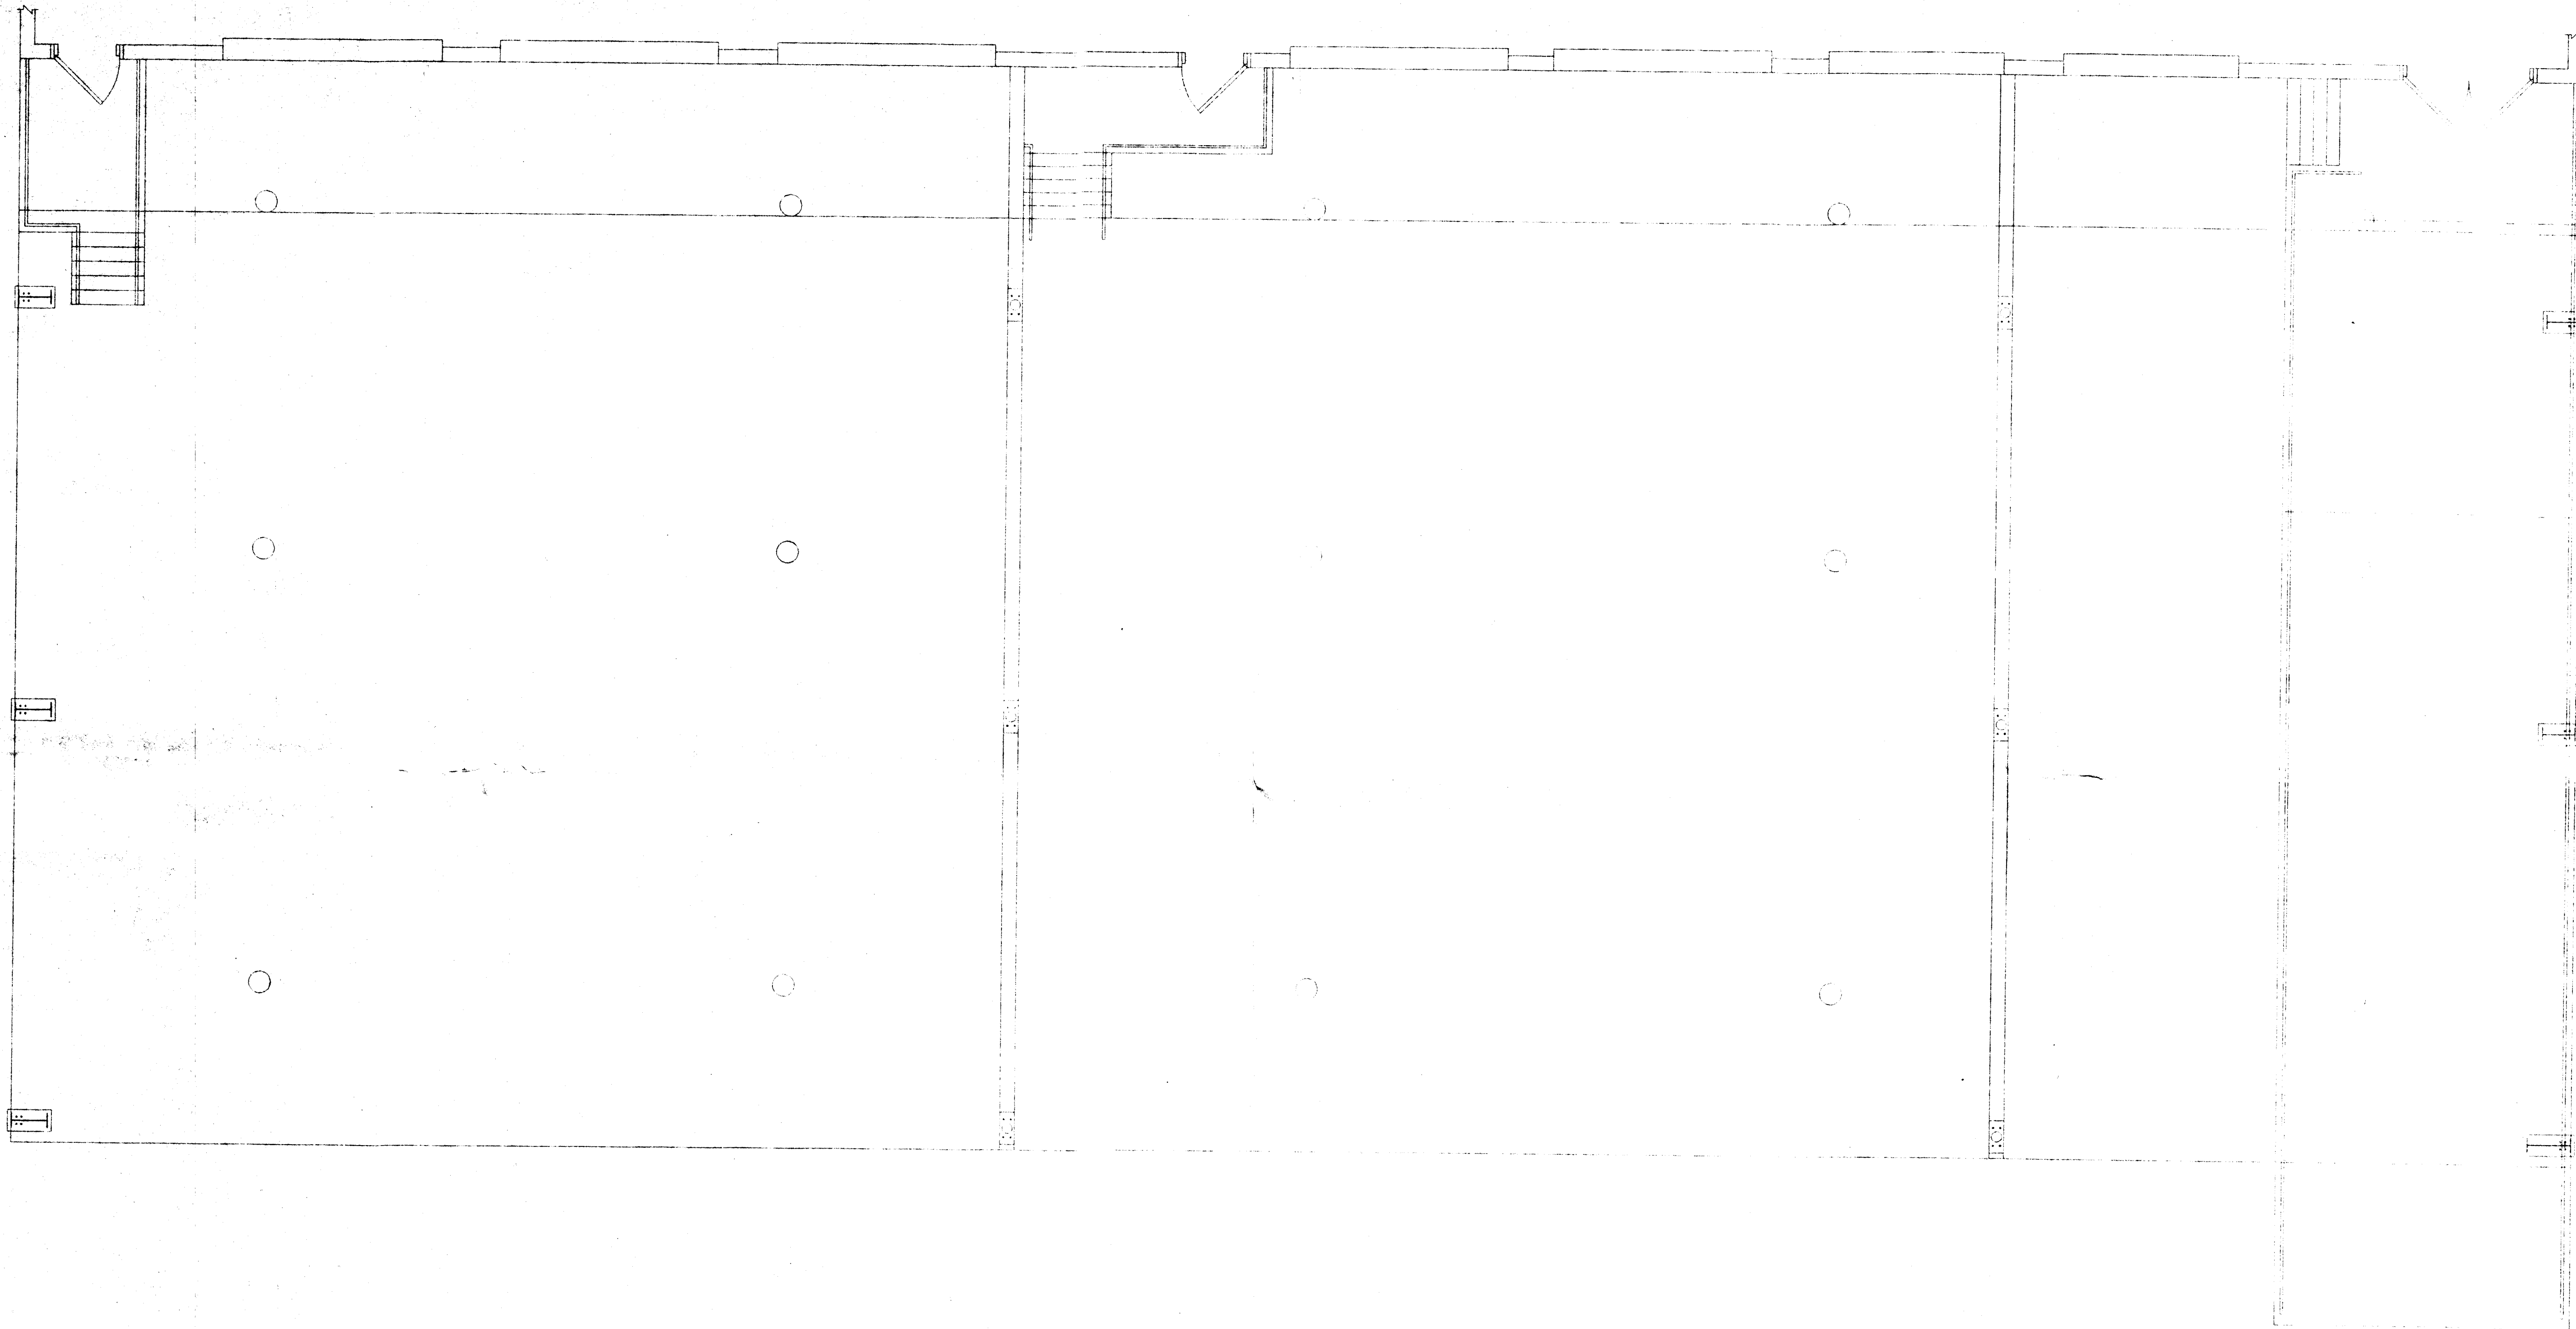

KEY
 ○ 250W METAL HALIDE FIXTURE
 ○ 277V FUSED LITHONIA LOW BAY
 #7XL 250M A20 277 SF LCPP TP4

ELECTRICAL LIGHTING PLAN
 SCALE 1/4" = 1'-0"

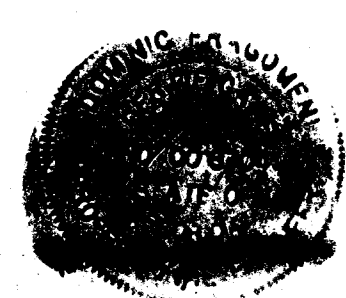

DATE	REVISION	BY	SCALE 1/4" = 1'-0"	DATE
	1		CITY ENVIRONMENTAL SERVICE, INC. OF FLORIDA	12/15/99
	2		7202 EAST EIGHT AVENUE	RD
	3		TAMPA, FLORIDA, 33619	1523
	4			11 OF 11
	5			F-1

P.J. CALLAGHAN

GENERAL CONTRACTORS
 LICENSE NO. 10529, STATE OF FLORIDA
 CLEARWATER, FL 33762