


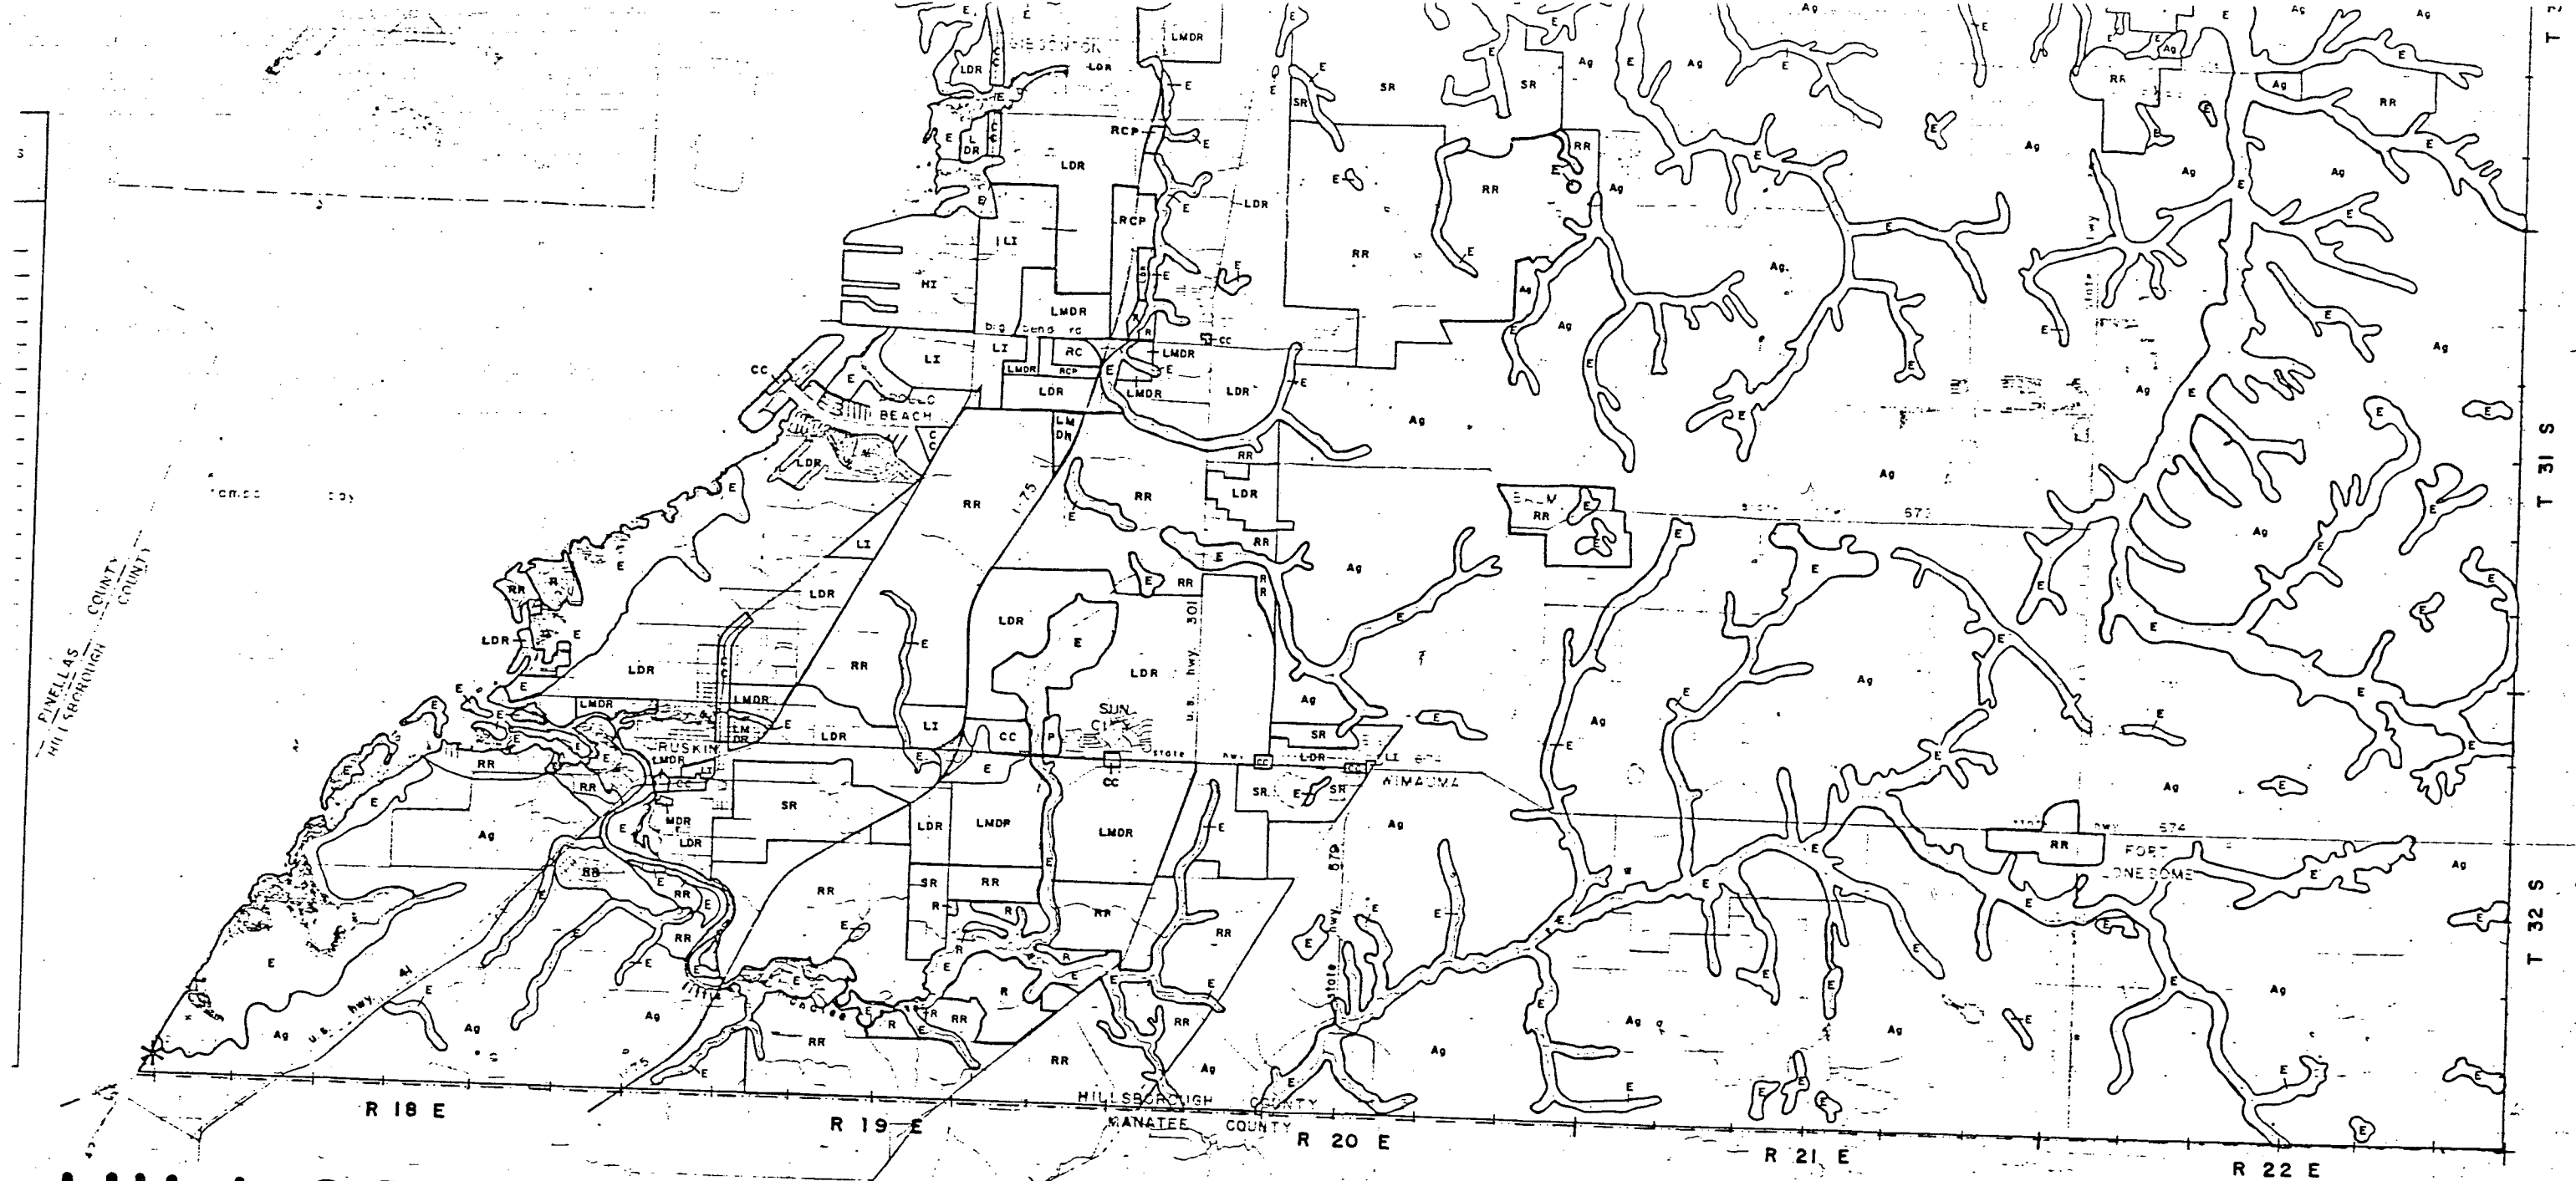


HILLSBOROUGH COUNTY, FLORIDA LAND USE PLAN MAP

- LMDR LOW-MEDIUM DENSITY RESIDENTIAL (12*)
 MDR MEDIUM DENSITY RESIDENTIAL (20*)
 CC COMMUNITY COMMERCIAL
 RC REGIONAL COMMERCIAL

- RCP RESEARCH / CORPORATE PARK
 LI LIGHT INDUSTRIAL
 HI HEAVY INDUSTRIAL
 R RECREATION / OPEN SPACE

- P PUBLIC / SEMI-PUBLIC
 E ENVIRONMENTALLY SENSITIVE AREAS
 (SUBJECT TO ON-SITE INSPECTION)
 * PROPOSED POWER PLANT SITE
 * DWELLING UNITS PER GROSS ACRE

 EXHIBIT I.C




DATE: JUN. 16, 1982



EFFECTIVE ADOPTION DATE: OCT 27 1982

hillsborough county

city-county


planning

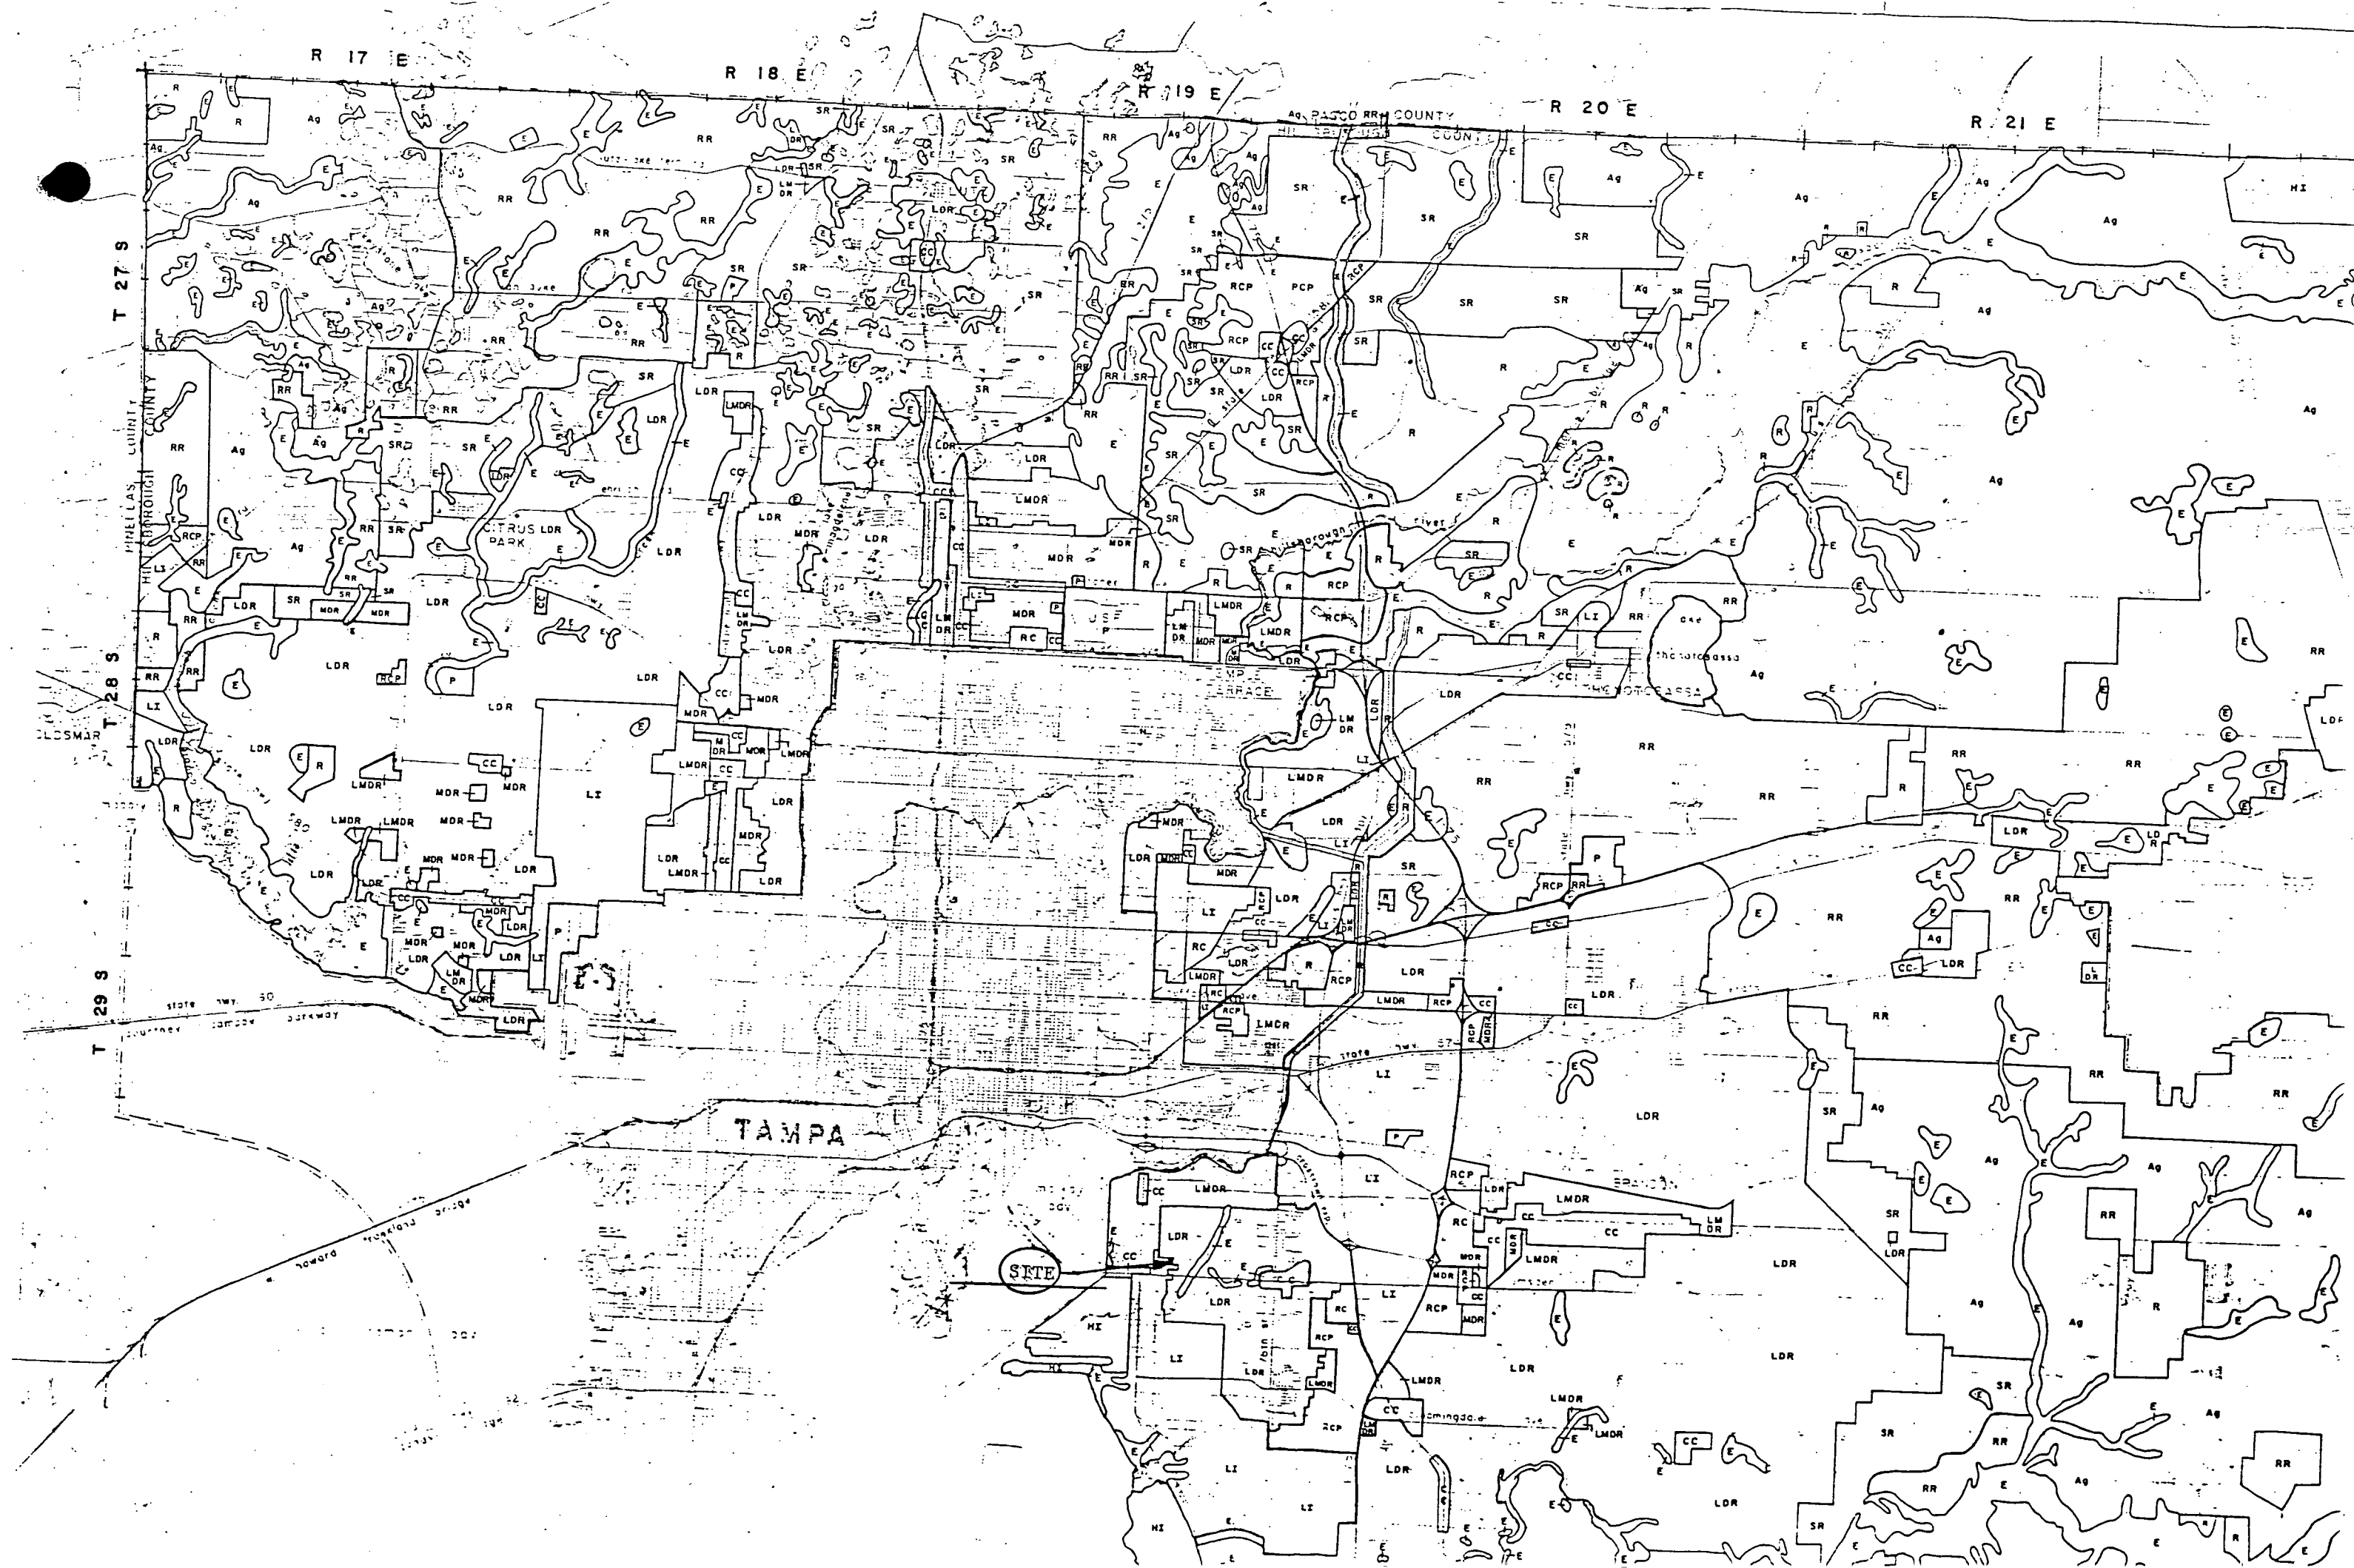

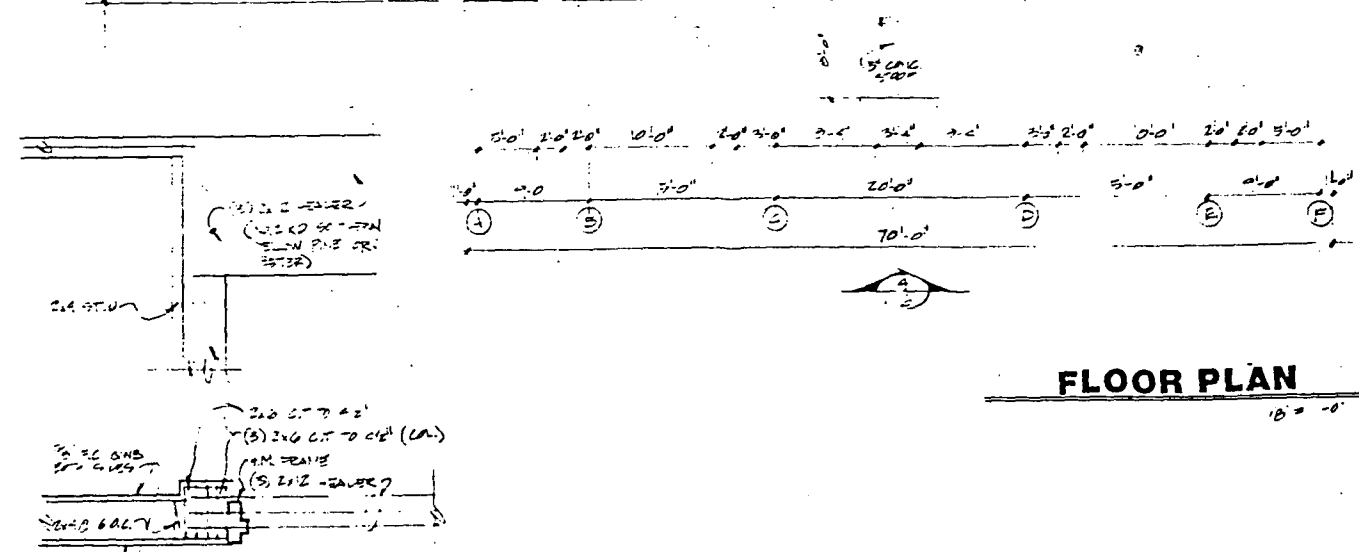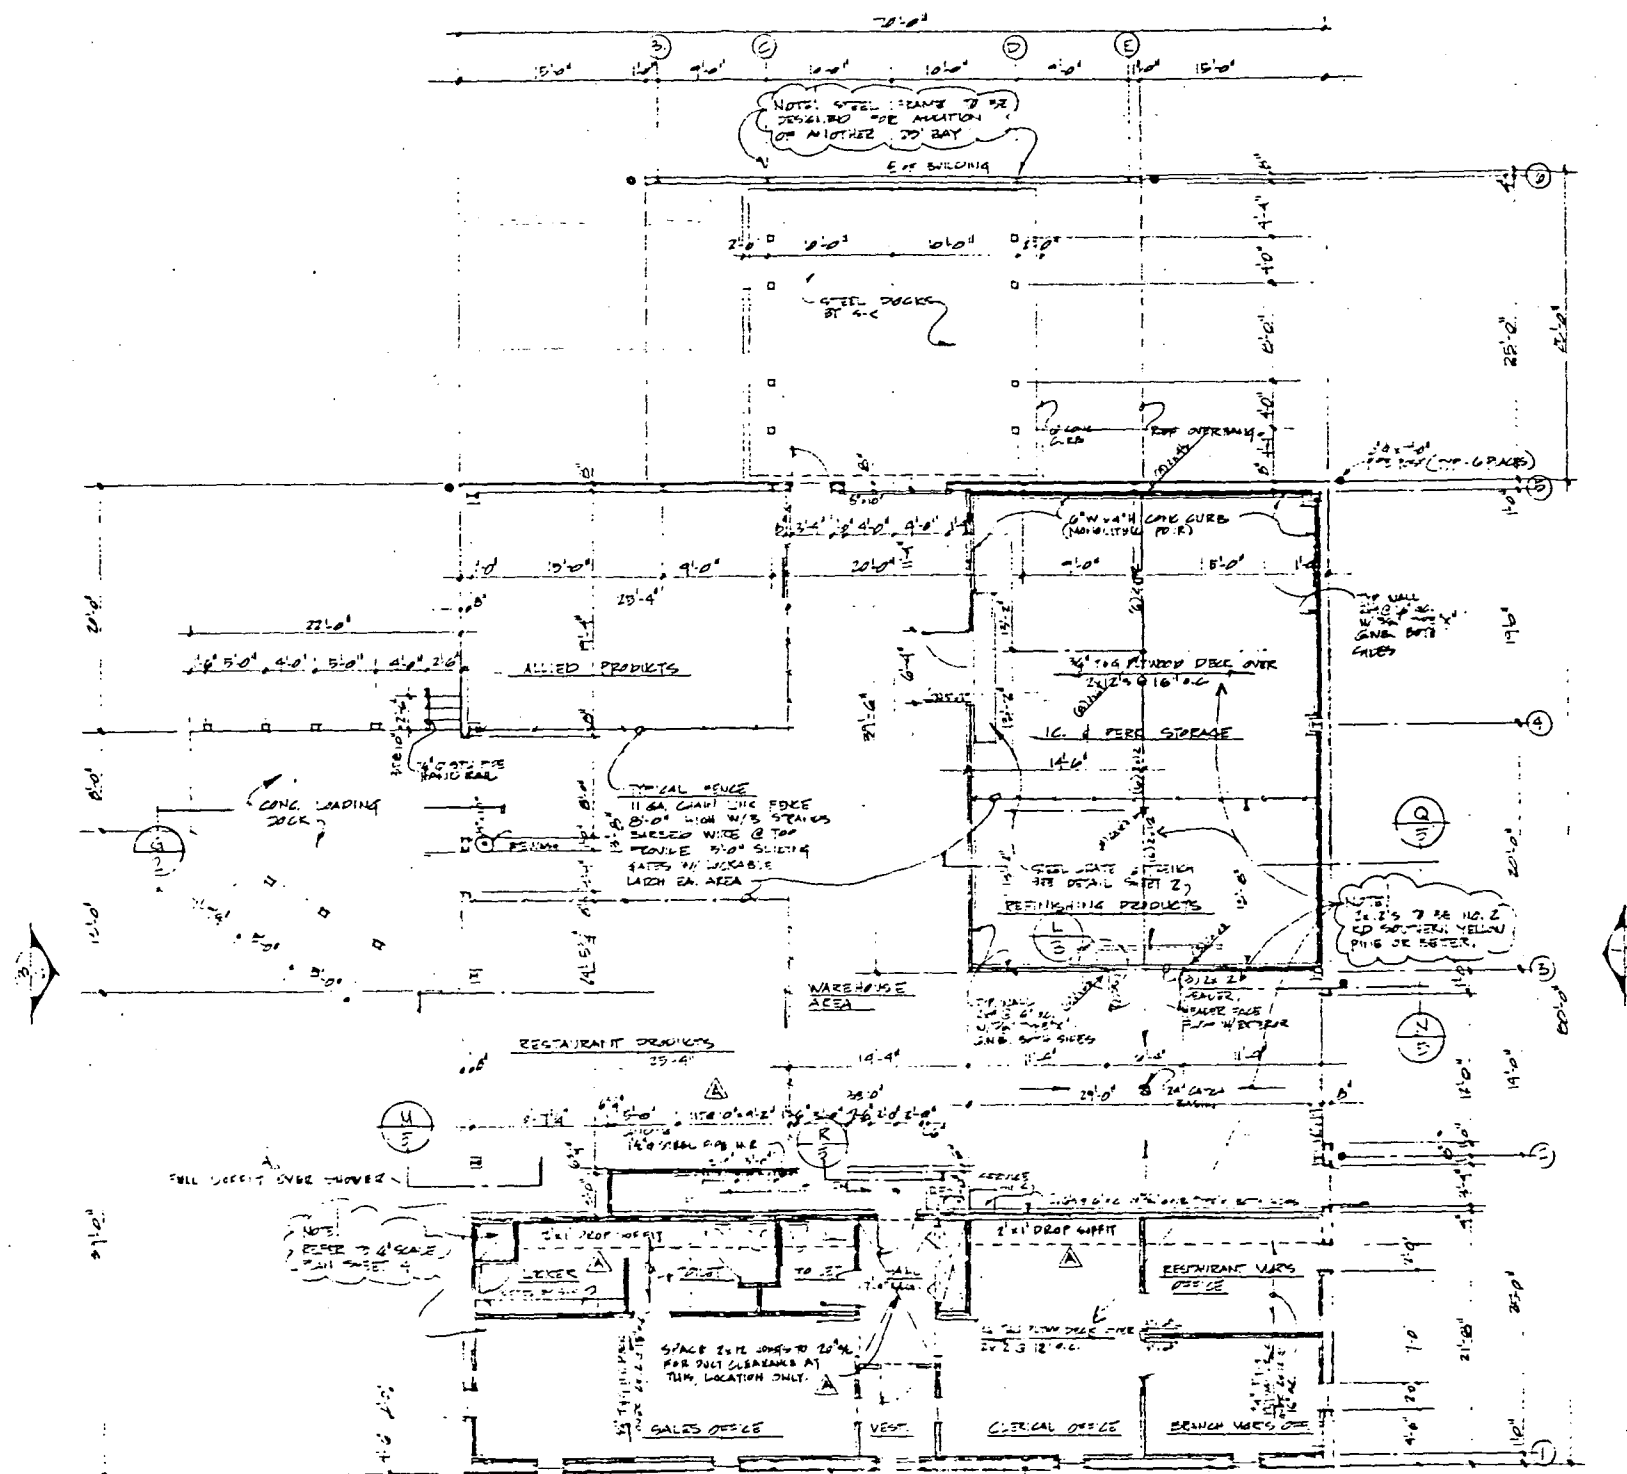

FLOOR PLAN

FRAME DETAIL

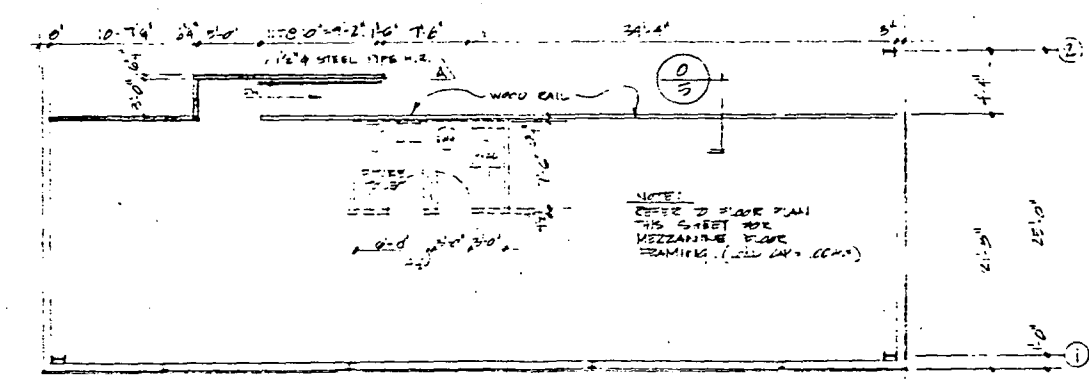

MEZZANINE PLAN

CONSTRUCTION CONTRACT REQUIREMENTS

1. AIA General Conditions dated 1976 shall form a part of this contract.
2. Contractors shall secure and pay for all permits, inspections, licenses, etc. related to their work.
3. Each contractor shall submit to the Owner insurance policies, minimum \$500,000.00, which comply with Safety-Kleen insurance requirements:
 - a. Liability
 - b. Workman's Compensation
 - c. Automobile
 - d. Hold Harmless Clause to Owner and Engineer
 These must be submitted before starting work.
4. Owner shall secure and pay for Builder's Risk Insurance.
5. Equal opportunity policies of employment must be maintained.
6. Each contractor shall visit site and verify all existing conditions.
7. Any adjoining property damaged during construction shall be repaired and restored to original condition by contractor responsible for the damage at his own expense.
8. All contractors shall remove their own rubbish and debris from the site as it accumulates and transfer same to a location determined by the Owner.
9. All work shall comply with OSHA, State and Local codes.
10. All work shall be guaranteed for one year after final acceptance by Owner and Engineer.



Safety-Kleen Corp.	
615 BIG TIMBER ROAD - ELGIN, ILLINOIS 60120	
PHONE 312-701-1100	
80'x70'x16' SERVICE CENTER	
FLOOR & MEZZ. PLANS	
DATE: 5-25	BY: J.M.W.
SCALE: 1/8" = 1'-0"	




BLOW-OFF PANEL DETAIL

BUILDING SECTION

MASONRY WALL DETAIL

FOUNDATION DETAIL

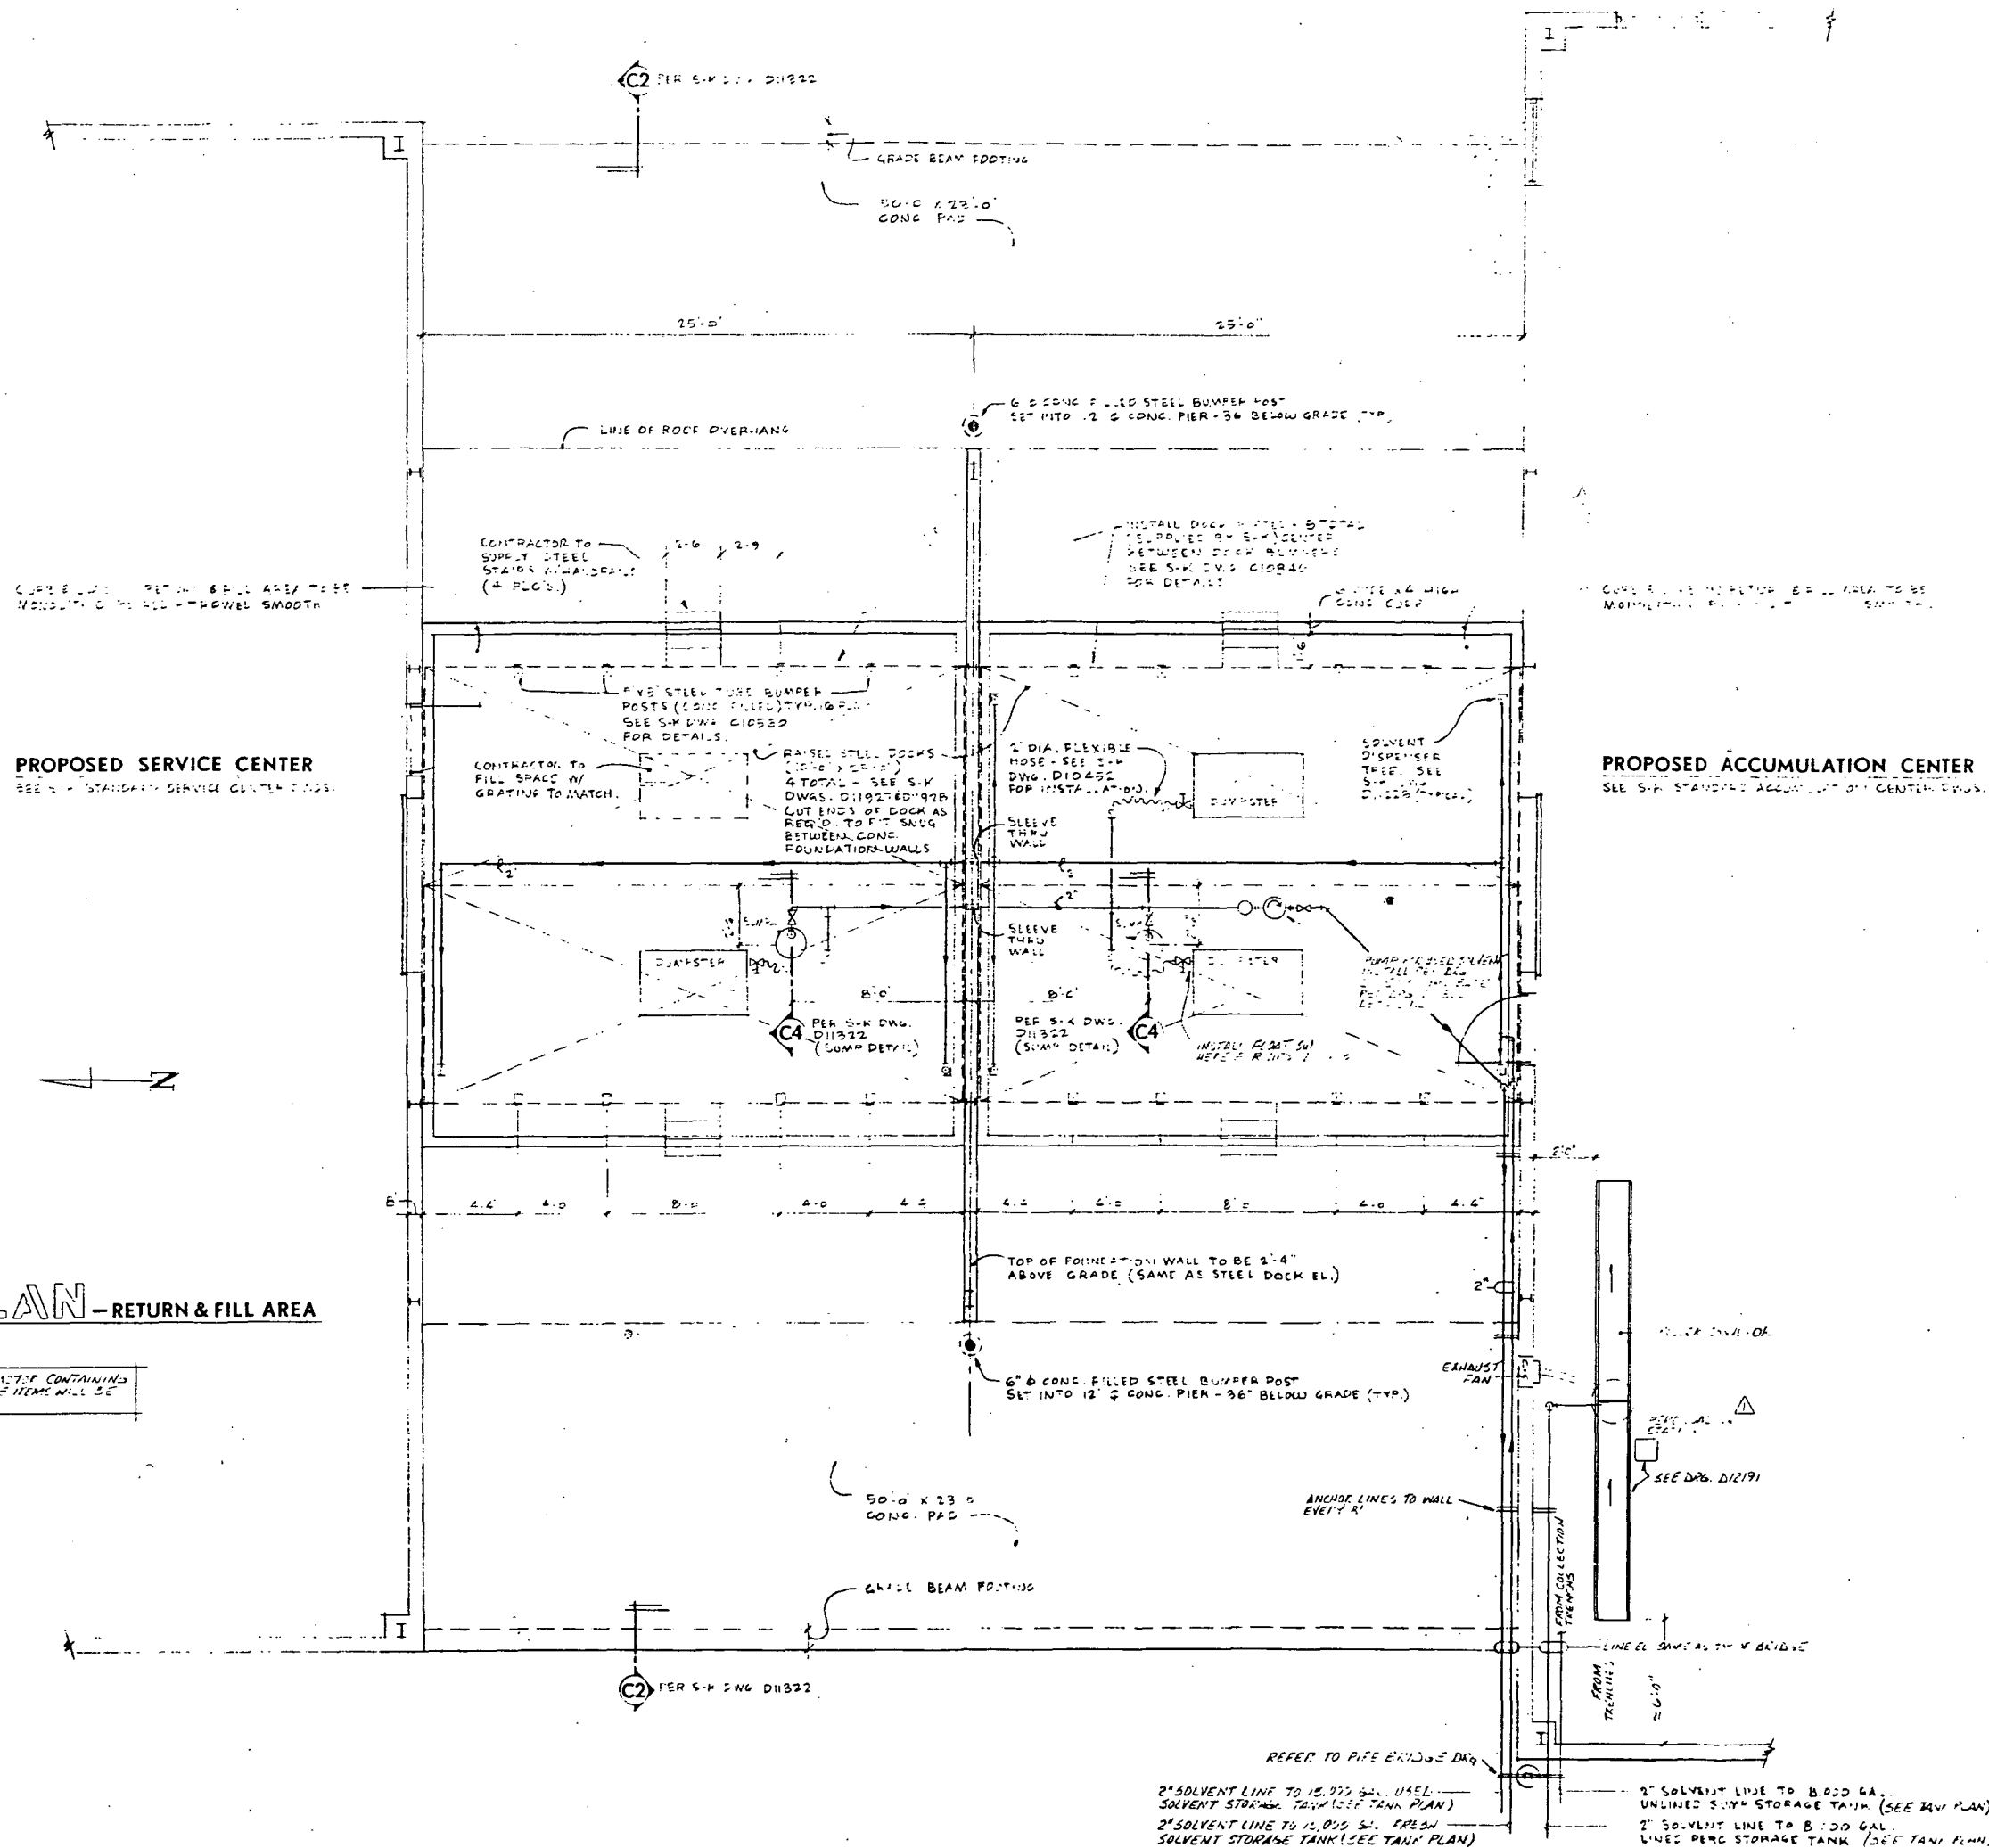

DOCK PLAN - RETURN & FILL AREA


SCALE: 1/4" = 1'-0"

ALL DOCKS SUPPLIED TO CONTRACTOR CONTAINING
S-W PART # REFERENCES. THESE ITEMS WILL BE
SUPPLIED BY SAFETY-KLEEN.



Safety-Kleen Corp. 777 BIG TIMBER ROAD • ELGIN, ILLINOIS 60120 PHONE 312/887-8400			
DOCK PLAN - RETURN & FILL AREA			
DATE	BY	REVISION	DATE
1/4/80	WOM	ADDED 1500 GALLON 1/4 STATION	3/10/80
1/4/80	WOM	RECORDED SOLVENT LINES	4/1/80
FOR SERVICE/ACCUMULATION CENTER TENTS F1 (2/11/83)			

CONFIDENTIAL

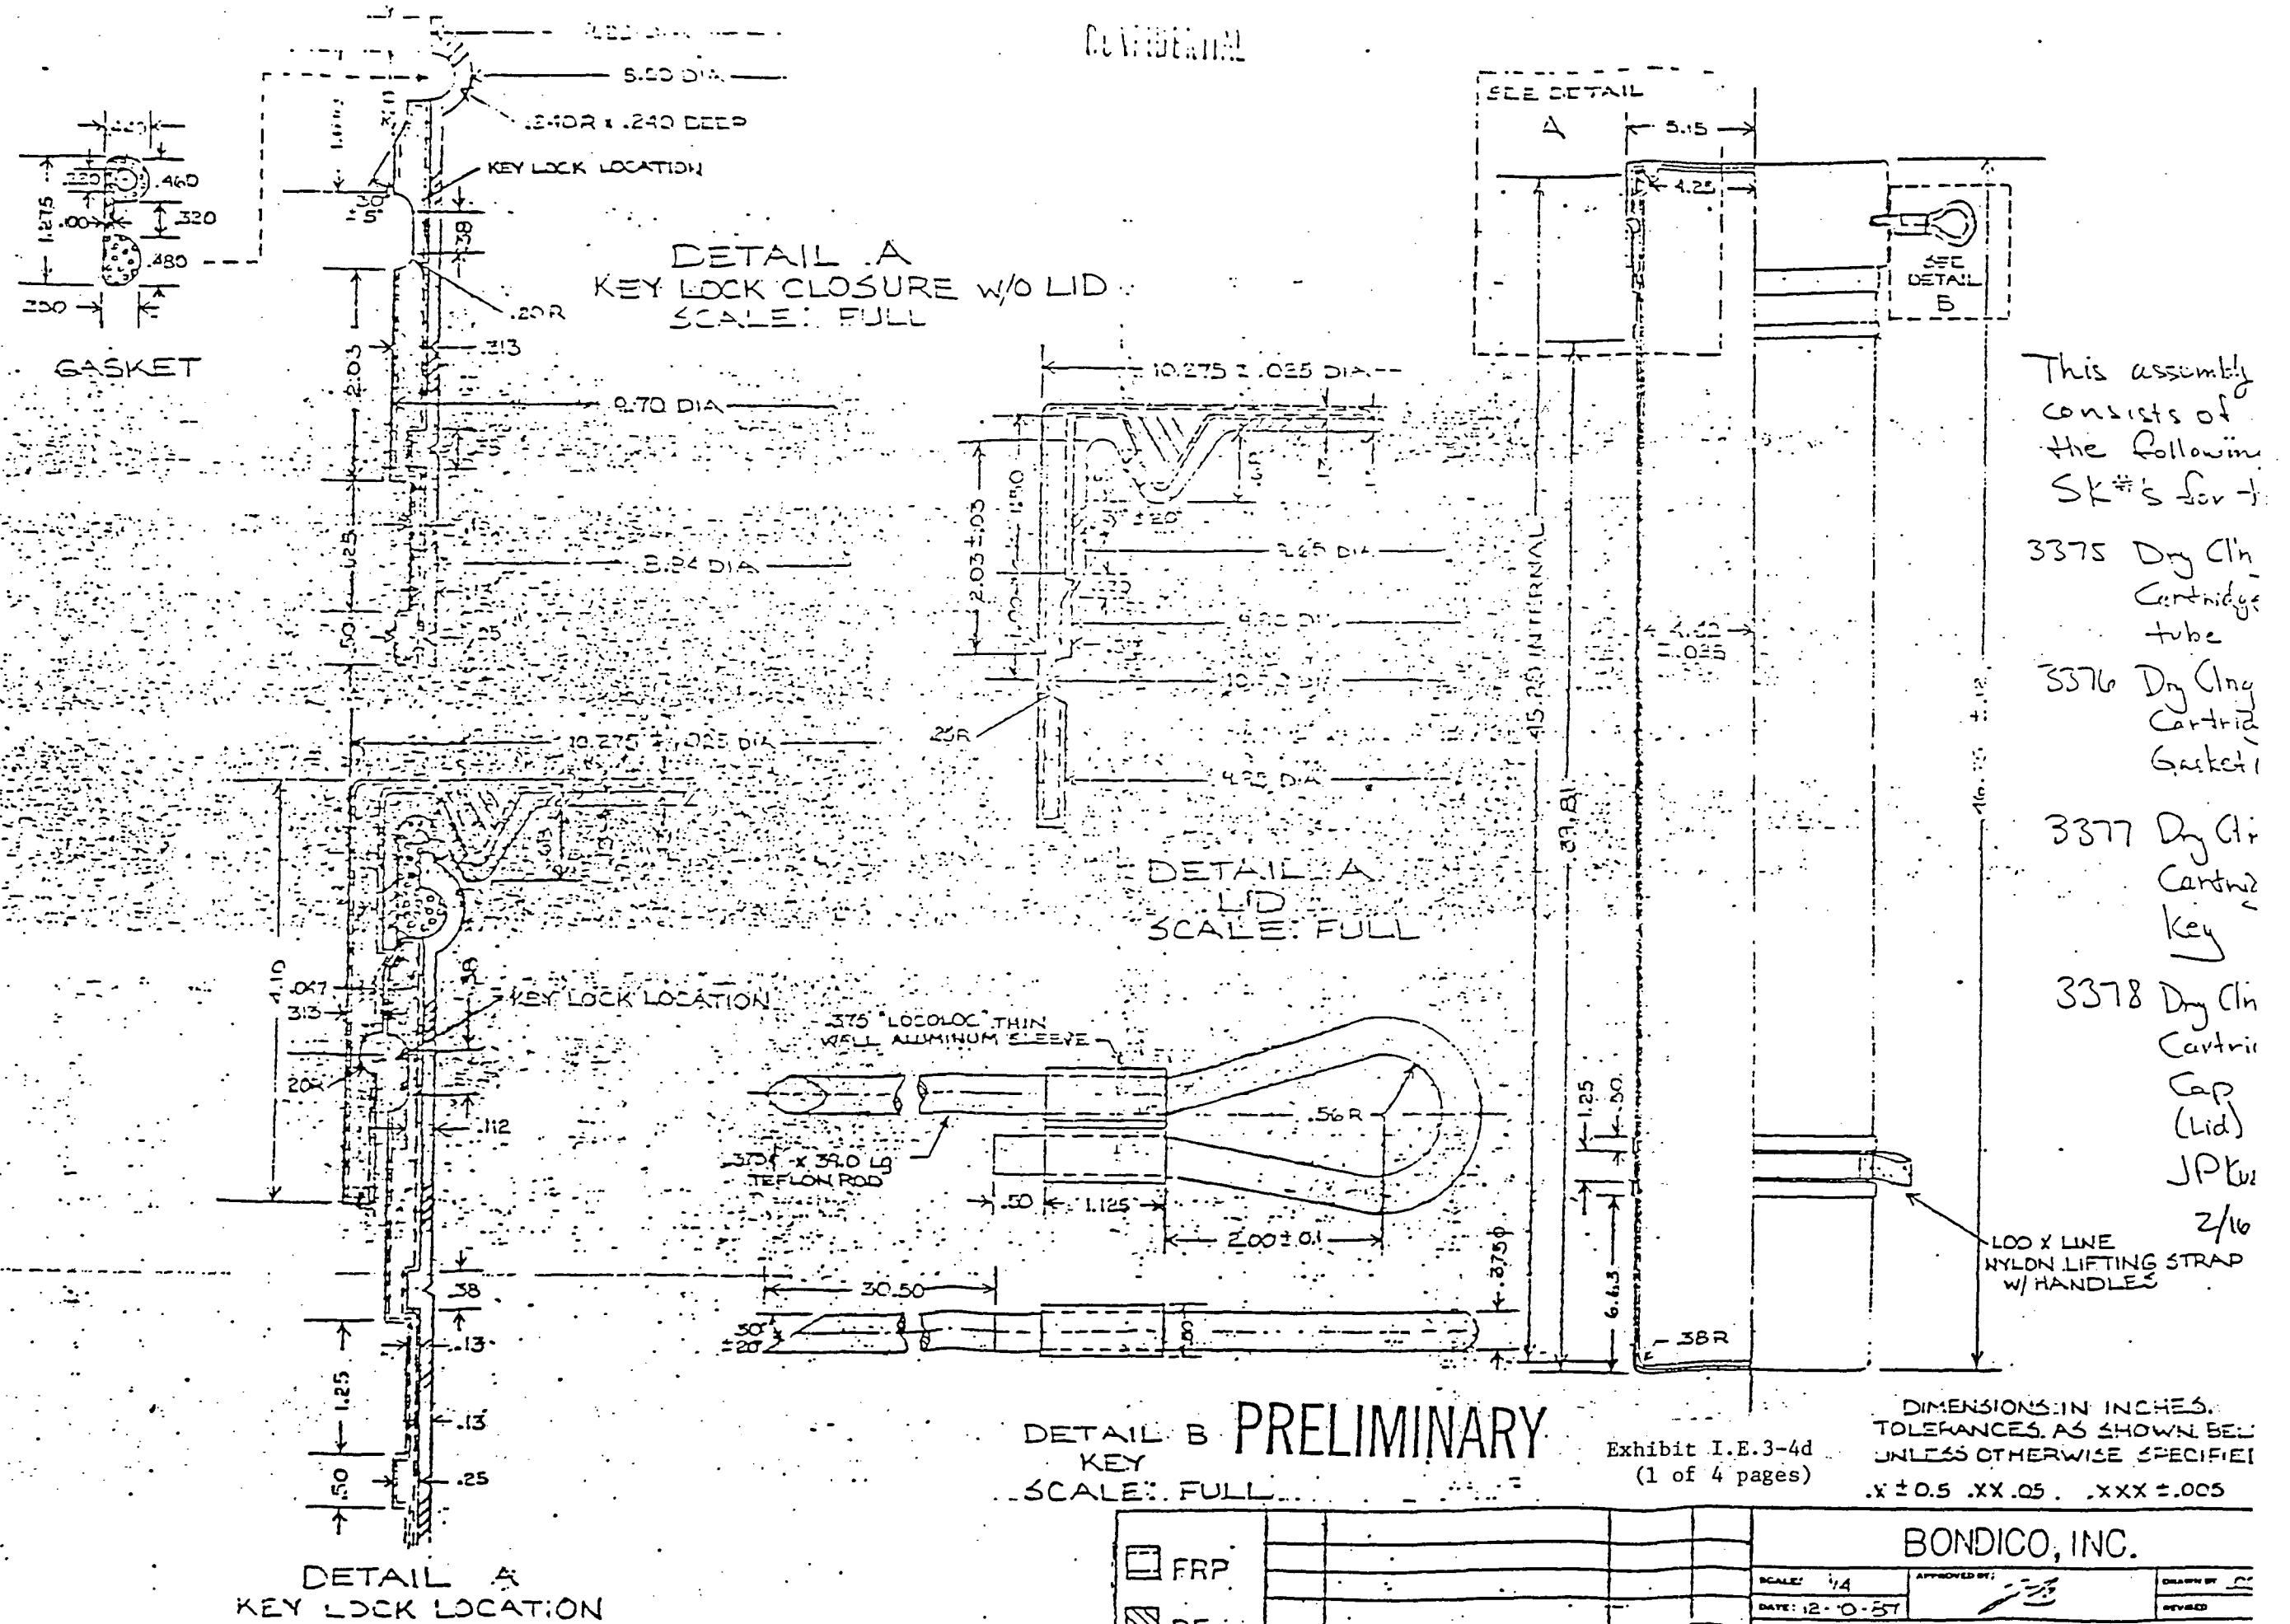

This assembly consists of the following SK #'s for the:

3375 Dry Clin
Centrifuge
tube

3376 Dry Clng
Cartrid
Gasket

3377 Dry Air
Cartwz
Key

3378 Dry Clin
Cartridge
Cap
(Lid)
JPK_{W2}

2/16
100 X LINE
NYLON LIFTING STRAP
W/ HANDLES

DIMENSIONS IN INCHES
TOLERANCES AS SHOWN BELOW
UNLESS OTHERWISE SPECIFIED
.X ± 0.5 .XX .05 .XXX ± .005

BONDICO, INC.


SCALE: 1/4

DATE: 12-0-57

APPROVED BY: 

DEATH BY 2
REVEREND

FRP

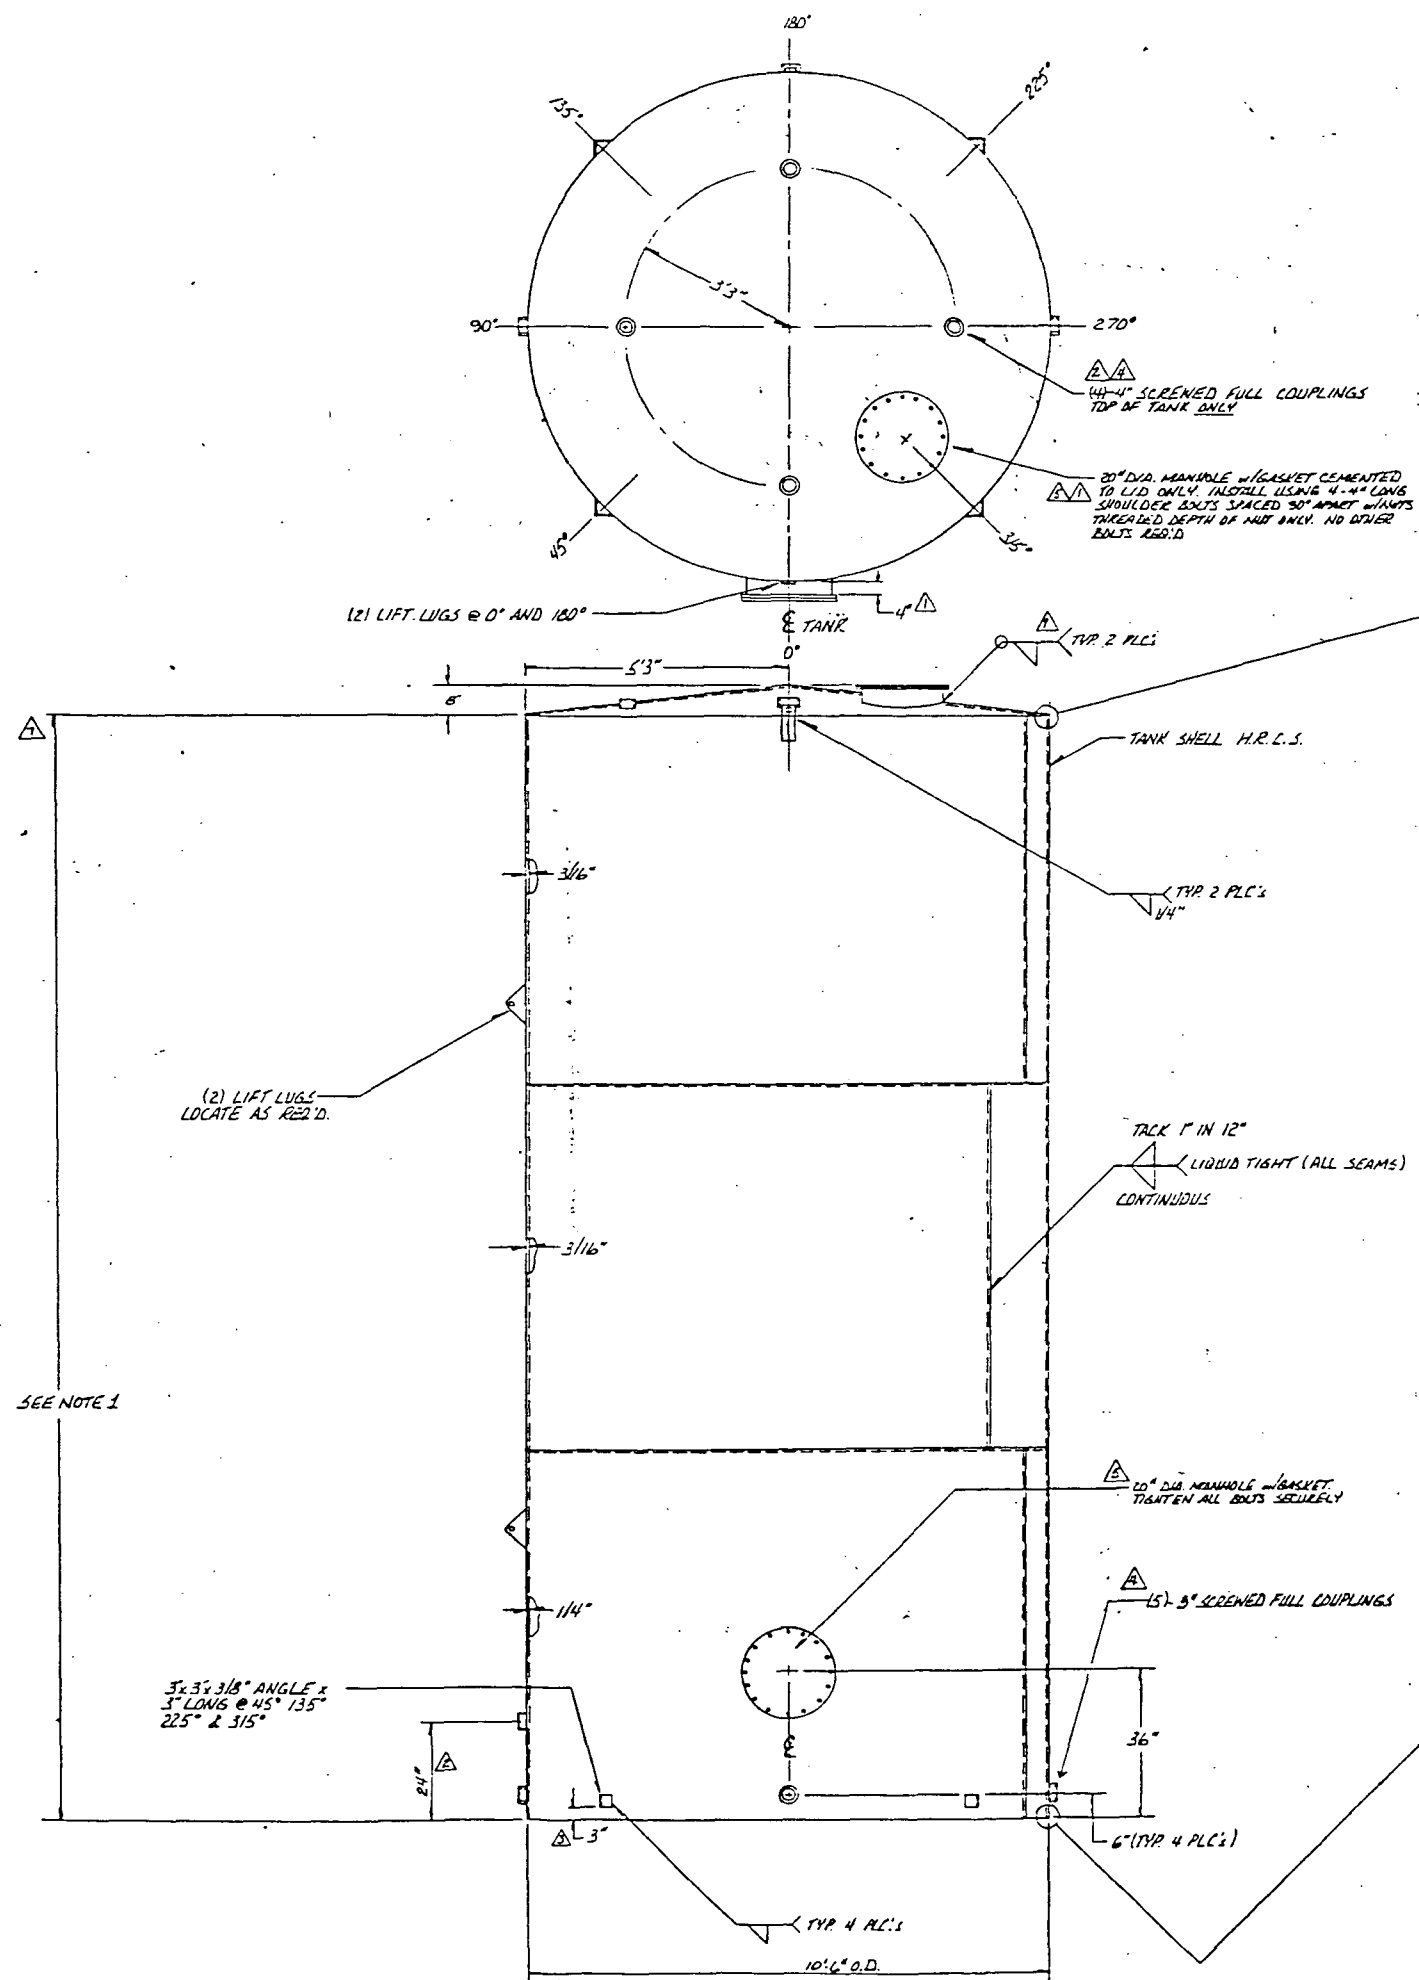

NOTES:

- HEIGHT OF TANK WILL DEPEND ON GALLONAGE
A) 12,000 GAL. - 18'7"
B) 15,000 GAL. - 23'3"
- TEST PRESSURE TO BE 2 P.S.I. AIR MIN. & 5 P.S.I. MAX.
- CONSTRUCTION TO MEET "UNDERWRITERS LABORATORIES" REQUIREMENTS AND SO LABELED.
- EXTERIOR OF TANK SURFACE ONLY TO BE PREPARED IN ACCORDANCE WITH "STEEL STRUCTURE PAINTING COUNCIL" CODE #SSPL-SP3-631.
A) REMOVE LOOSE RUST & MILL SCALE BY SANDBLASTING & POWER TOOL WIRE BRUSHING AND GRINDING.
- AFTER SURFACE PREPARATION, APPLY (1) COAT OF WHITE OXIDE PAINT AND (2) COATS OF ALKYD BASE GLOSS WHITE STRUCTURAL ENAMEL, E.G. MOBIL 12-W-4. ALLOW PAINT TO DRY 16-24 HOURS BETWEEN COATS TO INSURE PROPER SEALING.
- COAT BOTTOM OF TANK (EXTERIOR ONLY) ADD 4" UP SIDES WITH BUFFHIDE OR MOBIL GILSO-MASTIC #55-J-8 OR AN EQUIVALENT.

12,000 GALLON TANK: SK PART #5285
15,000 GALLON TANK: SK PART #5286

Exhibit I.E. 3-5

REV	DESCRIPTION	DATE	BY	CHKD
1	MAILED DIMENSION	C.S.	1-21	
2	TANK TEST PRESSURES WERE 5 MIN. & 7 MAX.	RD	4-11	
3	CLARIFIED MANHOLE WELDS, SEE TOP MANHOLE, ADDED MORE FOR TIGHT LIQUID MANHOLE	RD	8-20	
4	NUMBER OF COUPLINGS WAS 3; CHANGED COUPLINGS AT BOTTOM OF TANK TO 1" INSTEAD OF 2" LONG AND MORE	RD	3-4	
5		DT		


Safety-Kleen Corp.
655 BIG TIMBER ROAD • ELGIN, ILLINOIS 60120 PHONE 312/887-8480

REV	DESCRIPTION	DATE	BY	CHKD
1	12" - 1'-0"			
2	2-12-82	11	RD	RD
3	RD	15	RD	RD
4	15	15	RD	RD
5	15	15	RD	RD
6	15	15	RD	RD
100	15	15	RD	RD


12,000 OR 15,000 GAL. ABOVEGROUND VERTICAL TANK FABRICATION DETAILS

FOR: SERVICE CENTER UPGRADE & /OR CONSTRUCTION

D10576

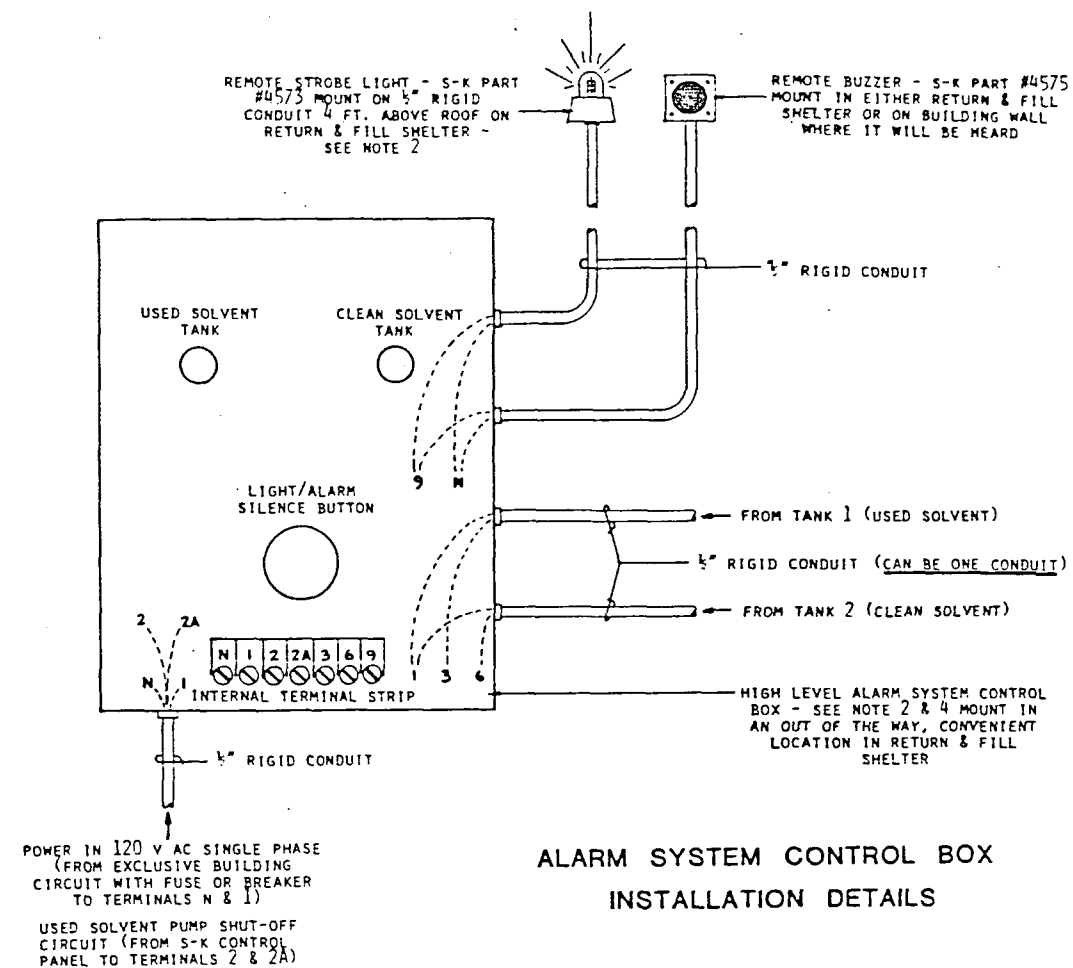



ALARM SYSTEM CONTROL BOX
INSTALLATION DETAILS

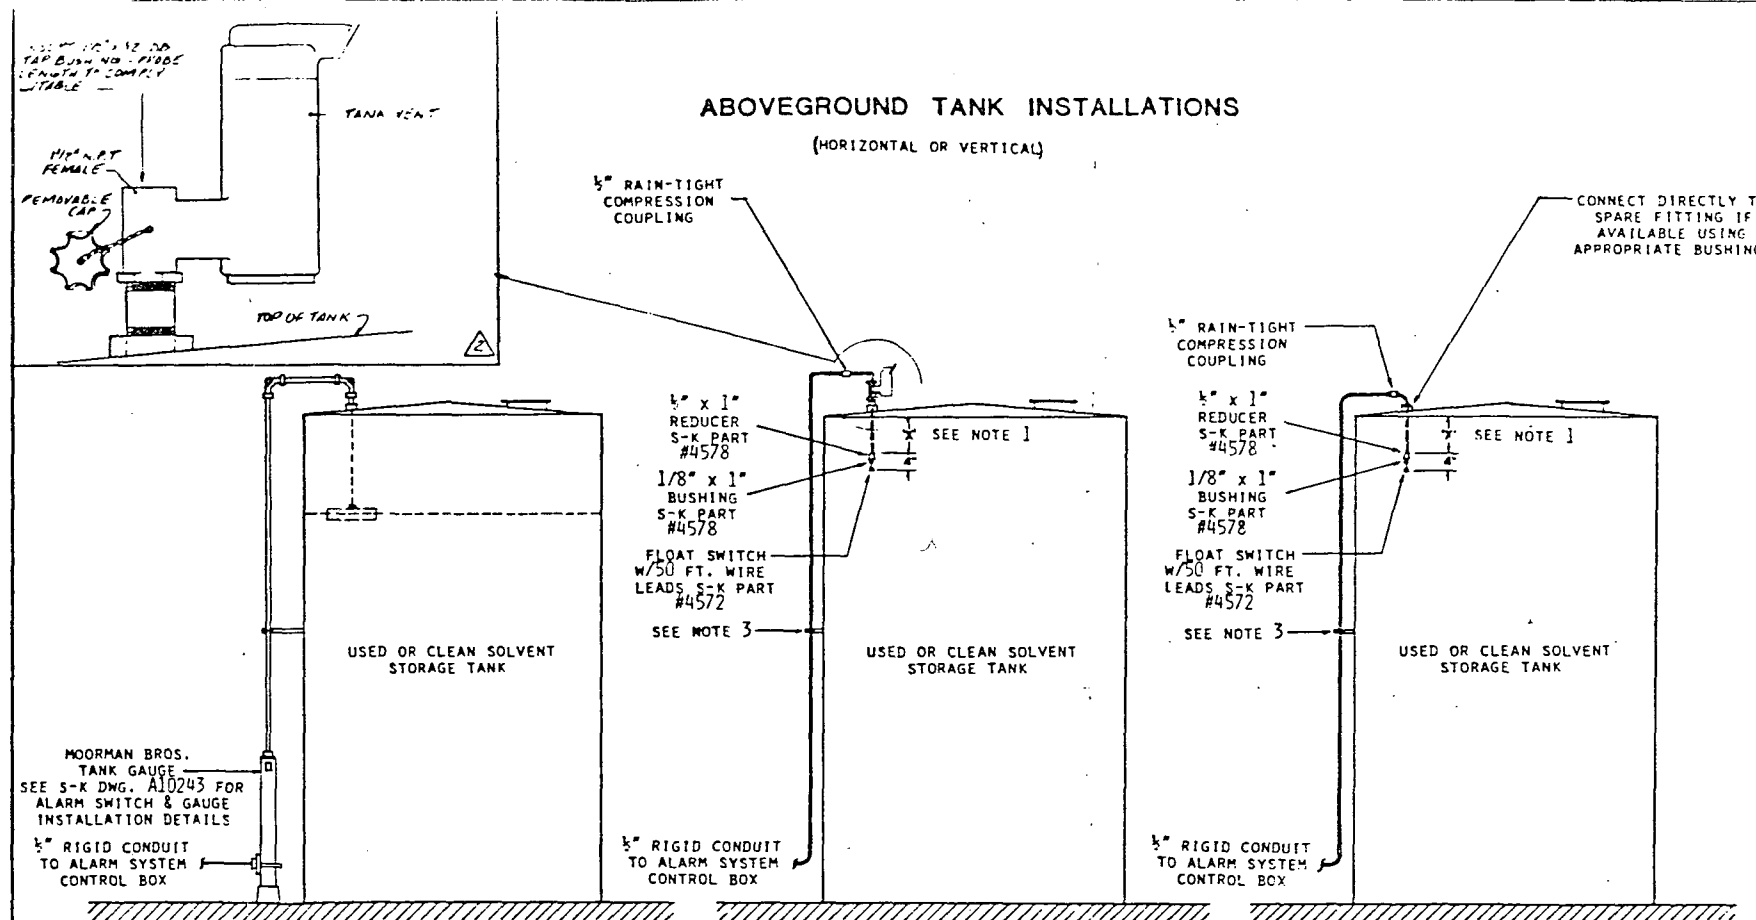

- OPTION 1 -

- OPTION 2 -

- OPTION 3 -

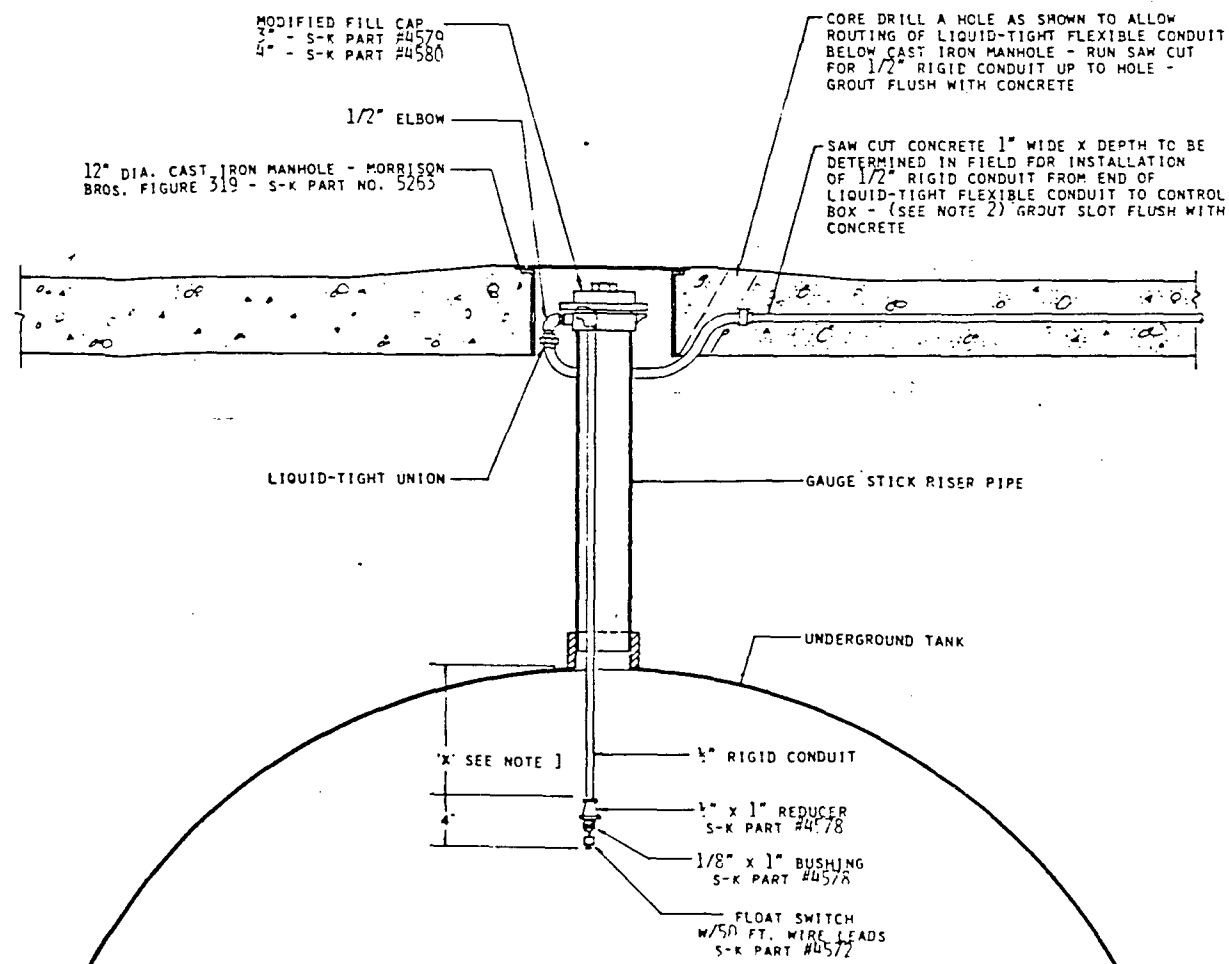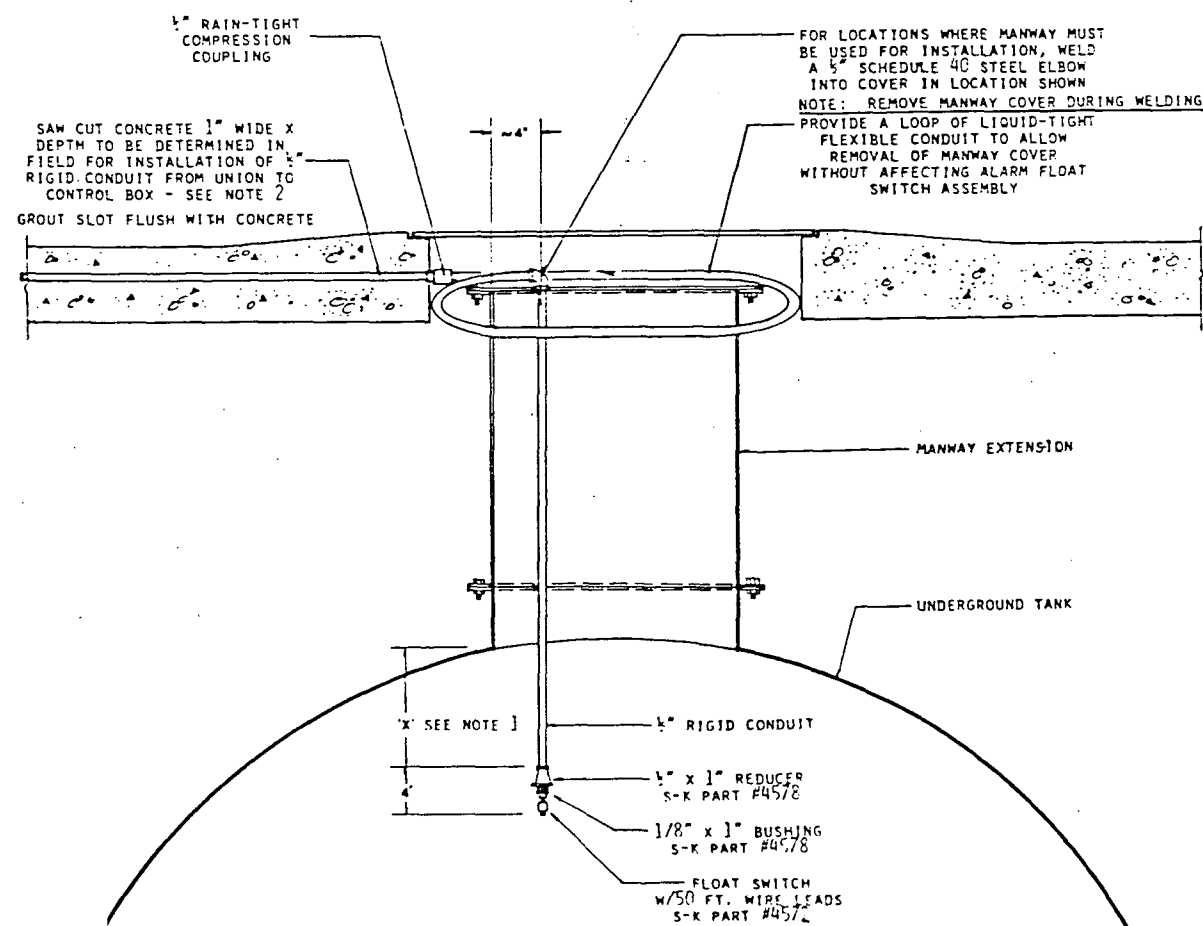

— GENERAL NOTES —

- 1 THE 'X' DIMENSION SHOWN IS VARIABLE & IS DIFFERENT FOR VARIOUS TANK TYPES & SIZES. FOR TABLE OF THESE VALUES REFER TO SAFETY-KLEEN DWG. 11152.
- 2 SEE INDIVIDUAL SERVICE CENTER SITE PLAN FOR RELATIVE LOCATIONS OF THESE DETAILS.
- 3 CONTRACTOR TO SUPPLY & INSTALL CONDUIT SUPPORTS &/OR BRACKETS AS REQUIRED.
- 4 KITS FOR INITIAL INSTALLATION OF HIGH LEVEL ALARM SYSTEMS ARE AVAILABLE FROM NEW BERLIN THROUGH THE TECHNICAL SERVICE DEPT. AS FOLLOWS:
 - 2 TANK KIT S-K PART #4572
 - 2 FLOAT SWITCHES W/COUPLING & BUSHING
 - 1 CONTROL BOX (2 TANK SIZE)
 - 1 STROBE LIGHT
 - 1 BUZZER
- 4 TANK KIT S-K PART #4571
- 4 FLOAT SWITCHES W/COUPLING & BUSHING
- 1 CONTROL BOX (4 TANK SIZE)
- 1 STROBE LIGHT
- 1 BUZZER

5 THIS DRAWING CONTAINS INFORMATION PROPRIETARY TO SAFETY-KLEEN CORP. ANY REPRODUCTION, DISCLOSURE OR USE OF THIS DRAWING IS EXPRESSLY PROHIBITED BY SAFETY-KLEEN OR AS SAFETY-KLEEN MAY AGREE IN WRITING.

6 ALL ITEMS SHOWN WITH A SAFETY-KLEEN PART NUMBER WILL BE SUPPLIED BY SAFETY-KLEEN CORP.

7 IF INDIVIDUAL SERVICE CENTER CONDITIONS ARE NOT COVERED BY DETAILS SHOWN HERE, PLEASE CONTACT TECHNICAL SERVICES AT THE CORPORATE OFFICE FOR ASSISTANCE.

REV	DESCRIPTION	BY
1	REVISED U.G. TANK RISER INSTALL'N	WL
2	SAFETY-KLEEN CORP.	BY