



SCALE: 1" = 30'

SEVENTH STREET (18' ASPHALT)

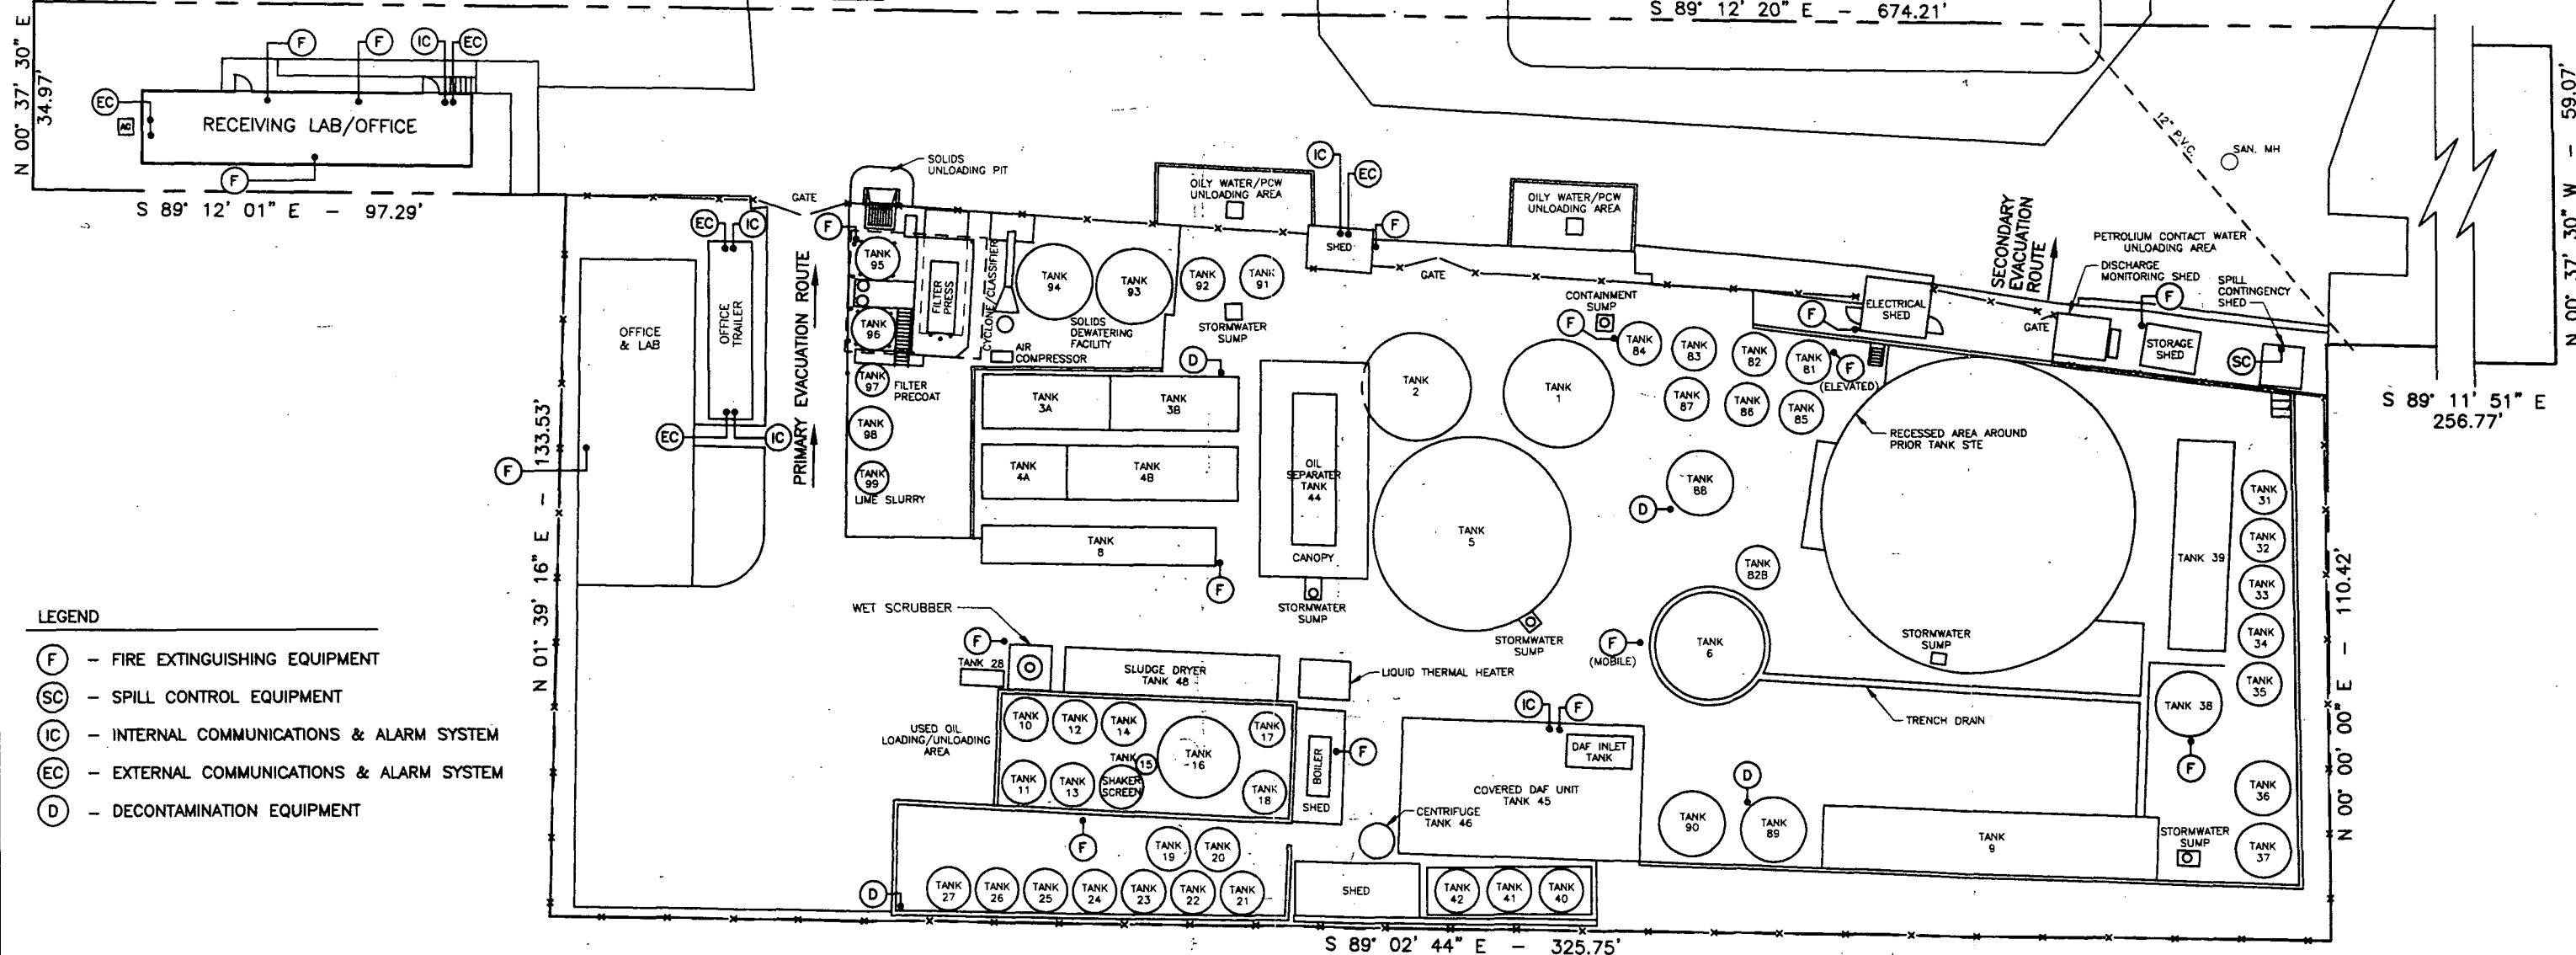

MITTAUER & ASSOCIATES, INC.
CONSULTING ENGINEERS
1202 Kingsley Avenue, Orange Park, Florida (904) 278-0030

INDUSTRIAL WATER SERVICES, INC.
Used Oil Processing Facility Permit
SPCC Plan - Site Plan
Jacksonville, Florida

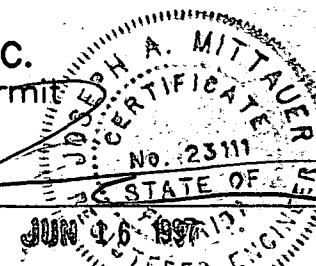

JOB No.
9122-15-1
ATTACHMENT
C-7e.1
JUNE 1997