


SCHEDULE OF EXISTING TANKS

No.	NAME/USE	CAPACITY	No.	NAME/USE	CAPACITY	No.	NAME/USE	CAPACITY
1	OW	27,270	36	W	20,000	87	OW	6,000
2	OW	27,270	37	W	20,000	88	OW	6,000
6	OW	62,000	38	W	20,000	89	S	10,000
7	W	22,000	39	W	30,000	90	S	10,000
8	W	22,000	40	HEAT EXCHANGER	N/A	91	OW	5,000
9	W	23,000	44	OIL SEPARATOR	10,000	92	OW	5,000
10	O	4,800	45	DAF UNIT	2,000	93	S/OW	12,000
12	O	7,800	45A	DAF INLET	1,000	94	S/OW	12,000
14	O	9,750	47	DAF CLARIFIER	4,200	95	S	4,000
16	O	16,075	50	HEAT EXCHANGER	N/A	96	S	4,000
17	VIRGIN FUELS	1,200	51	O	15,000	97	FILTER PRECOAT	1,000
18	O	9,950	52	O	15,000	98	W	12,000
19	O	7,800	53	O	85,000	99	LIME SLURRY	1,000
20	O	7,800	54	O	19,000	101	O	6,000
21	VIRGIN FUELS	8,000	55	O	9,750	110	FOG	20,000
22	O	7,800	56	O	20,000	111	FOG	20,000
23	O	9,950	60	S	12,000	112	FOG	37,000
24	O	15,000	61	S	8,000	113	FOG	37,000
25	O	15,000	62	S	8,000	114	FOG	37,000
26	O	15,000	70	S/OW	9,500	115	FOG	4,000
27	O	15,700	71	OW	6,500	121	OW	37,000
30	W	500	72	OW	6,500	122	OW	37,000
31	W	10,000	81	PCW	5,000			
32	W	12,000	82	PCW	5,000			
33	W	12,000	83	OW	5,500			
34	W	12,000	84	OW	5,500			
35	W	10,000	85	OW	6,000			
35A	W	11,650	86	OW	6,000			

NOTE: TANK NUMBERS CROSSED OUT ARE SCHEDULED FOR REMOVAL

- TANK LEGEND
- FOG - FAT, OIL & GREASE
 - O - OIL MANAGEMENT UNIT
 - OW - OILY WATER
 - PCW - PETROLEUM CONTACT WATER
 - S - SLUDGE OR SOLIDS
 - W - WATER
 - - EXISTING TANK

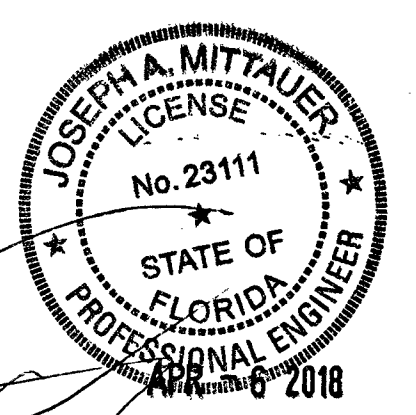

LIQUID ENVIRONMENTAL SOLUTIONS
 Permit Modification for Tanks 121 & 122
 Site Plan
 Jacksonville, FL

JOB NO. 9122-43-1
 SHEET NO.


MITTAUER & ASSOCIATES, INC.
 CONSULTING ENGINEERS
 580-1 WELLS ROAD, ORANGE PARK, FLORIDA 32073
 TEL. (904) 278-0030 FAX. (904) 278-0840

DESIGN	JAM
DRAWN	DSH
PROJECT MGR.	JAM
DATE	4/9/18

NO.	DATE	BY	REVISION DESCRIPTION


M:\CAD Files\Liquid Environmental Solutions\9122431\Submittal Sheets 1, 2 & 3.dwg, 4/6/2018 1:32:12 PM

SCALE: N.T.S.

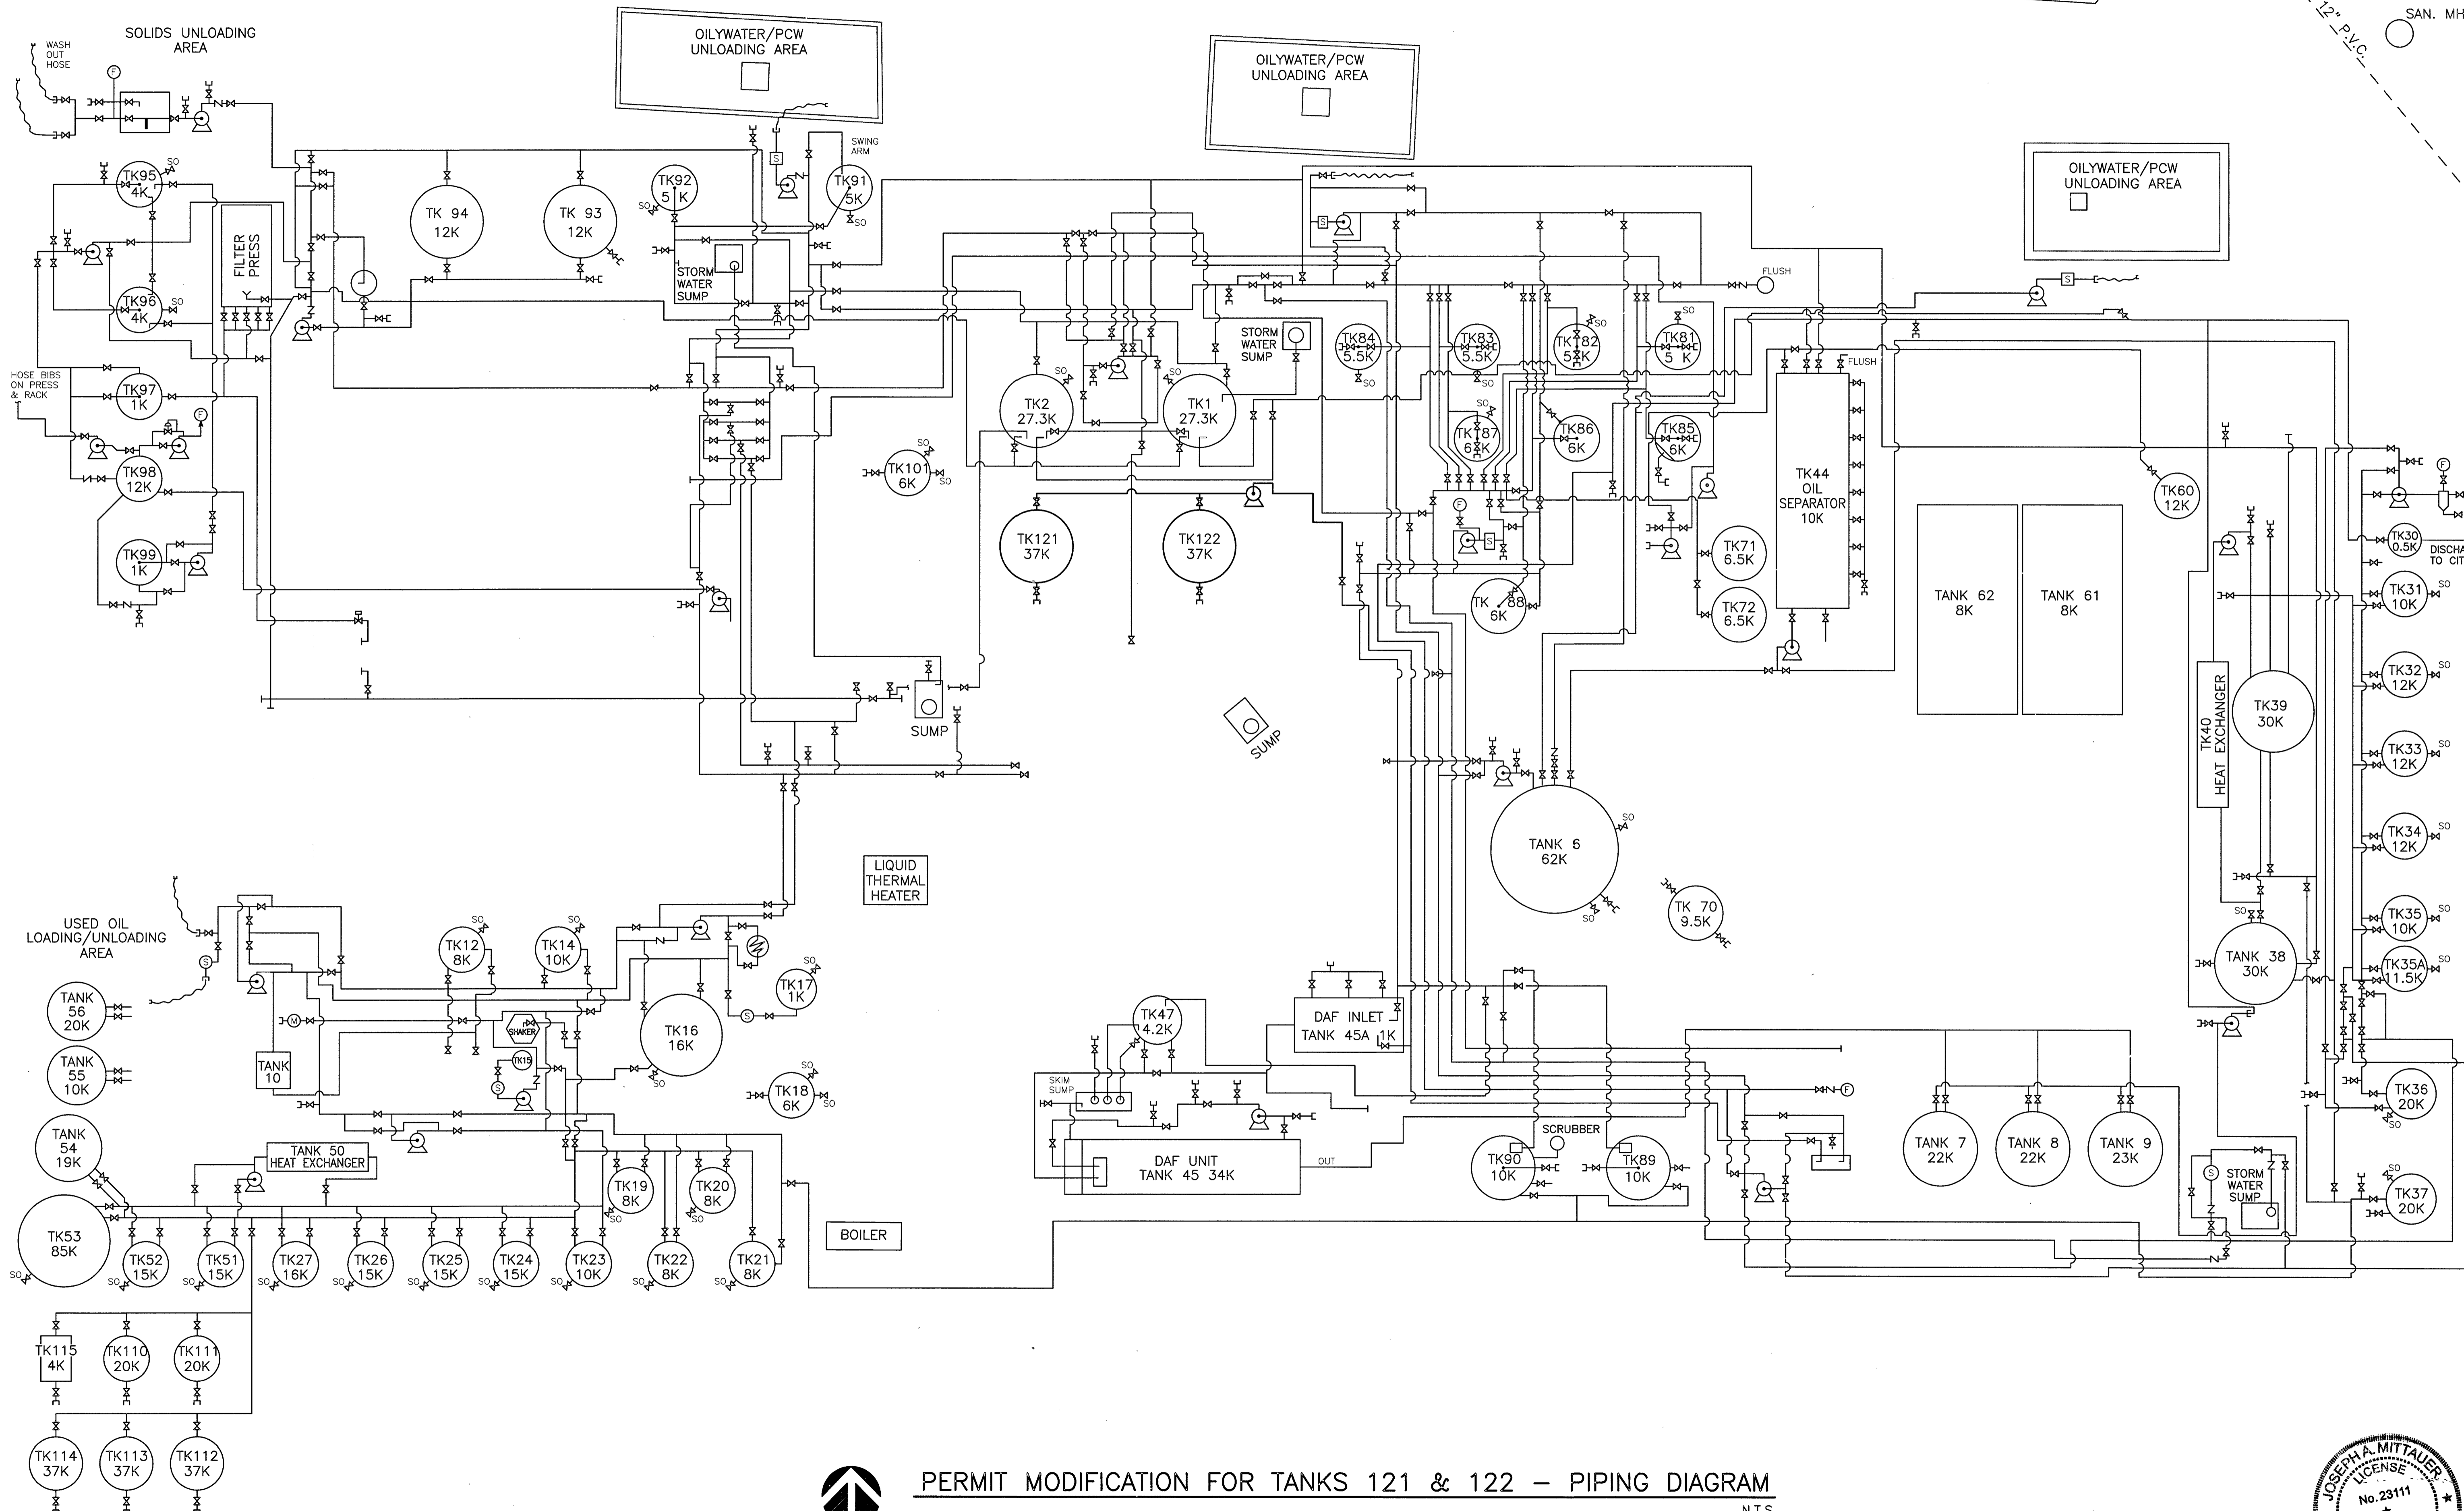

PERMIT MODIFICATION FOR TANKS 121 & 122 - PIPING DIAGRAM

N.T.S.

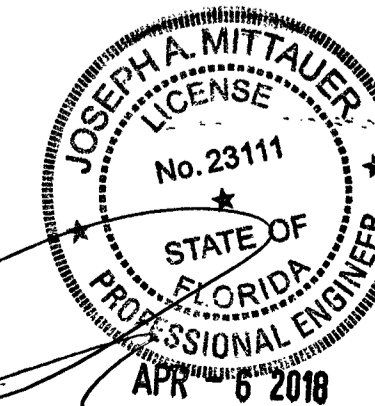

LIQUID ENVIRONMENTAL SOLUTIONS
 Permit Modification for Tanks 121 & 122
 Piping Diagram
 Jacksonville, FL

JOB NO.
 9122-43-1
 SHEET NO.

MITTAUER & ASSOCIATES, INC.
 CONSULTING ENGINEERS
 580-1 WELLS ROAD, ORANGE PARK, FLORIDA 32073
 TEL: (904) 278-0830 FAX: (904) 278-0840


DESIGN	JAM
DRAWN	DSH
PROJECT	JAM
DATE	4/8/18

NO.	DATE	BY


REVISION DESCRIPTION

M:\CAD Files\Liquid Environmental Solutions\9122431\Submittal Shis 1.2 & 3.dwg, 4/8/2018 1:32:37 PM

M:\CAD Files\Liquid Environmental Solutions\9122431\Submittal SHs 1, 2 & 3.dwg 4/6/2018 1:33:19 PM

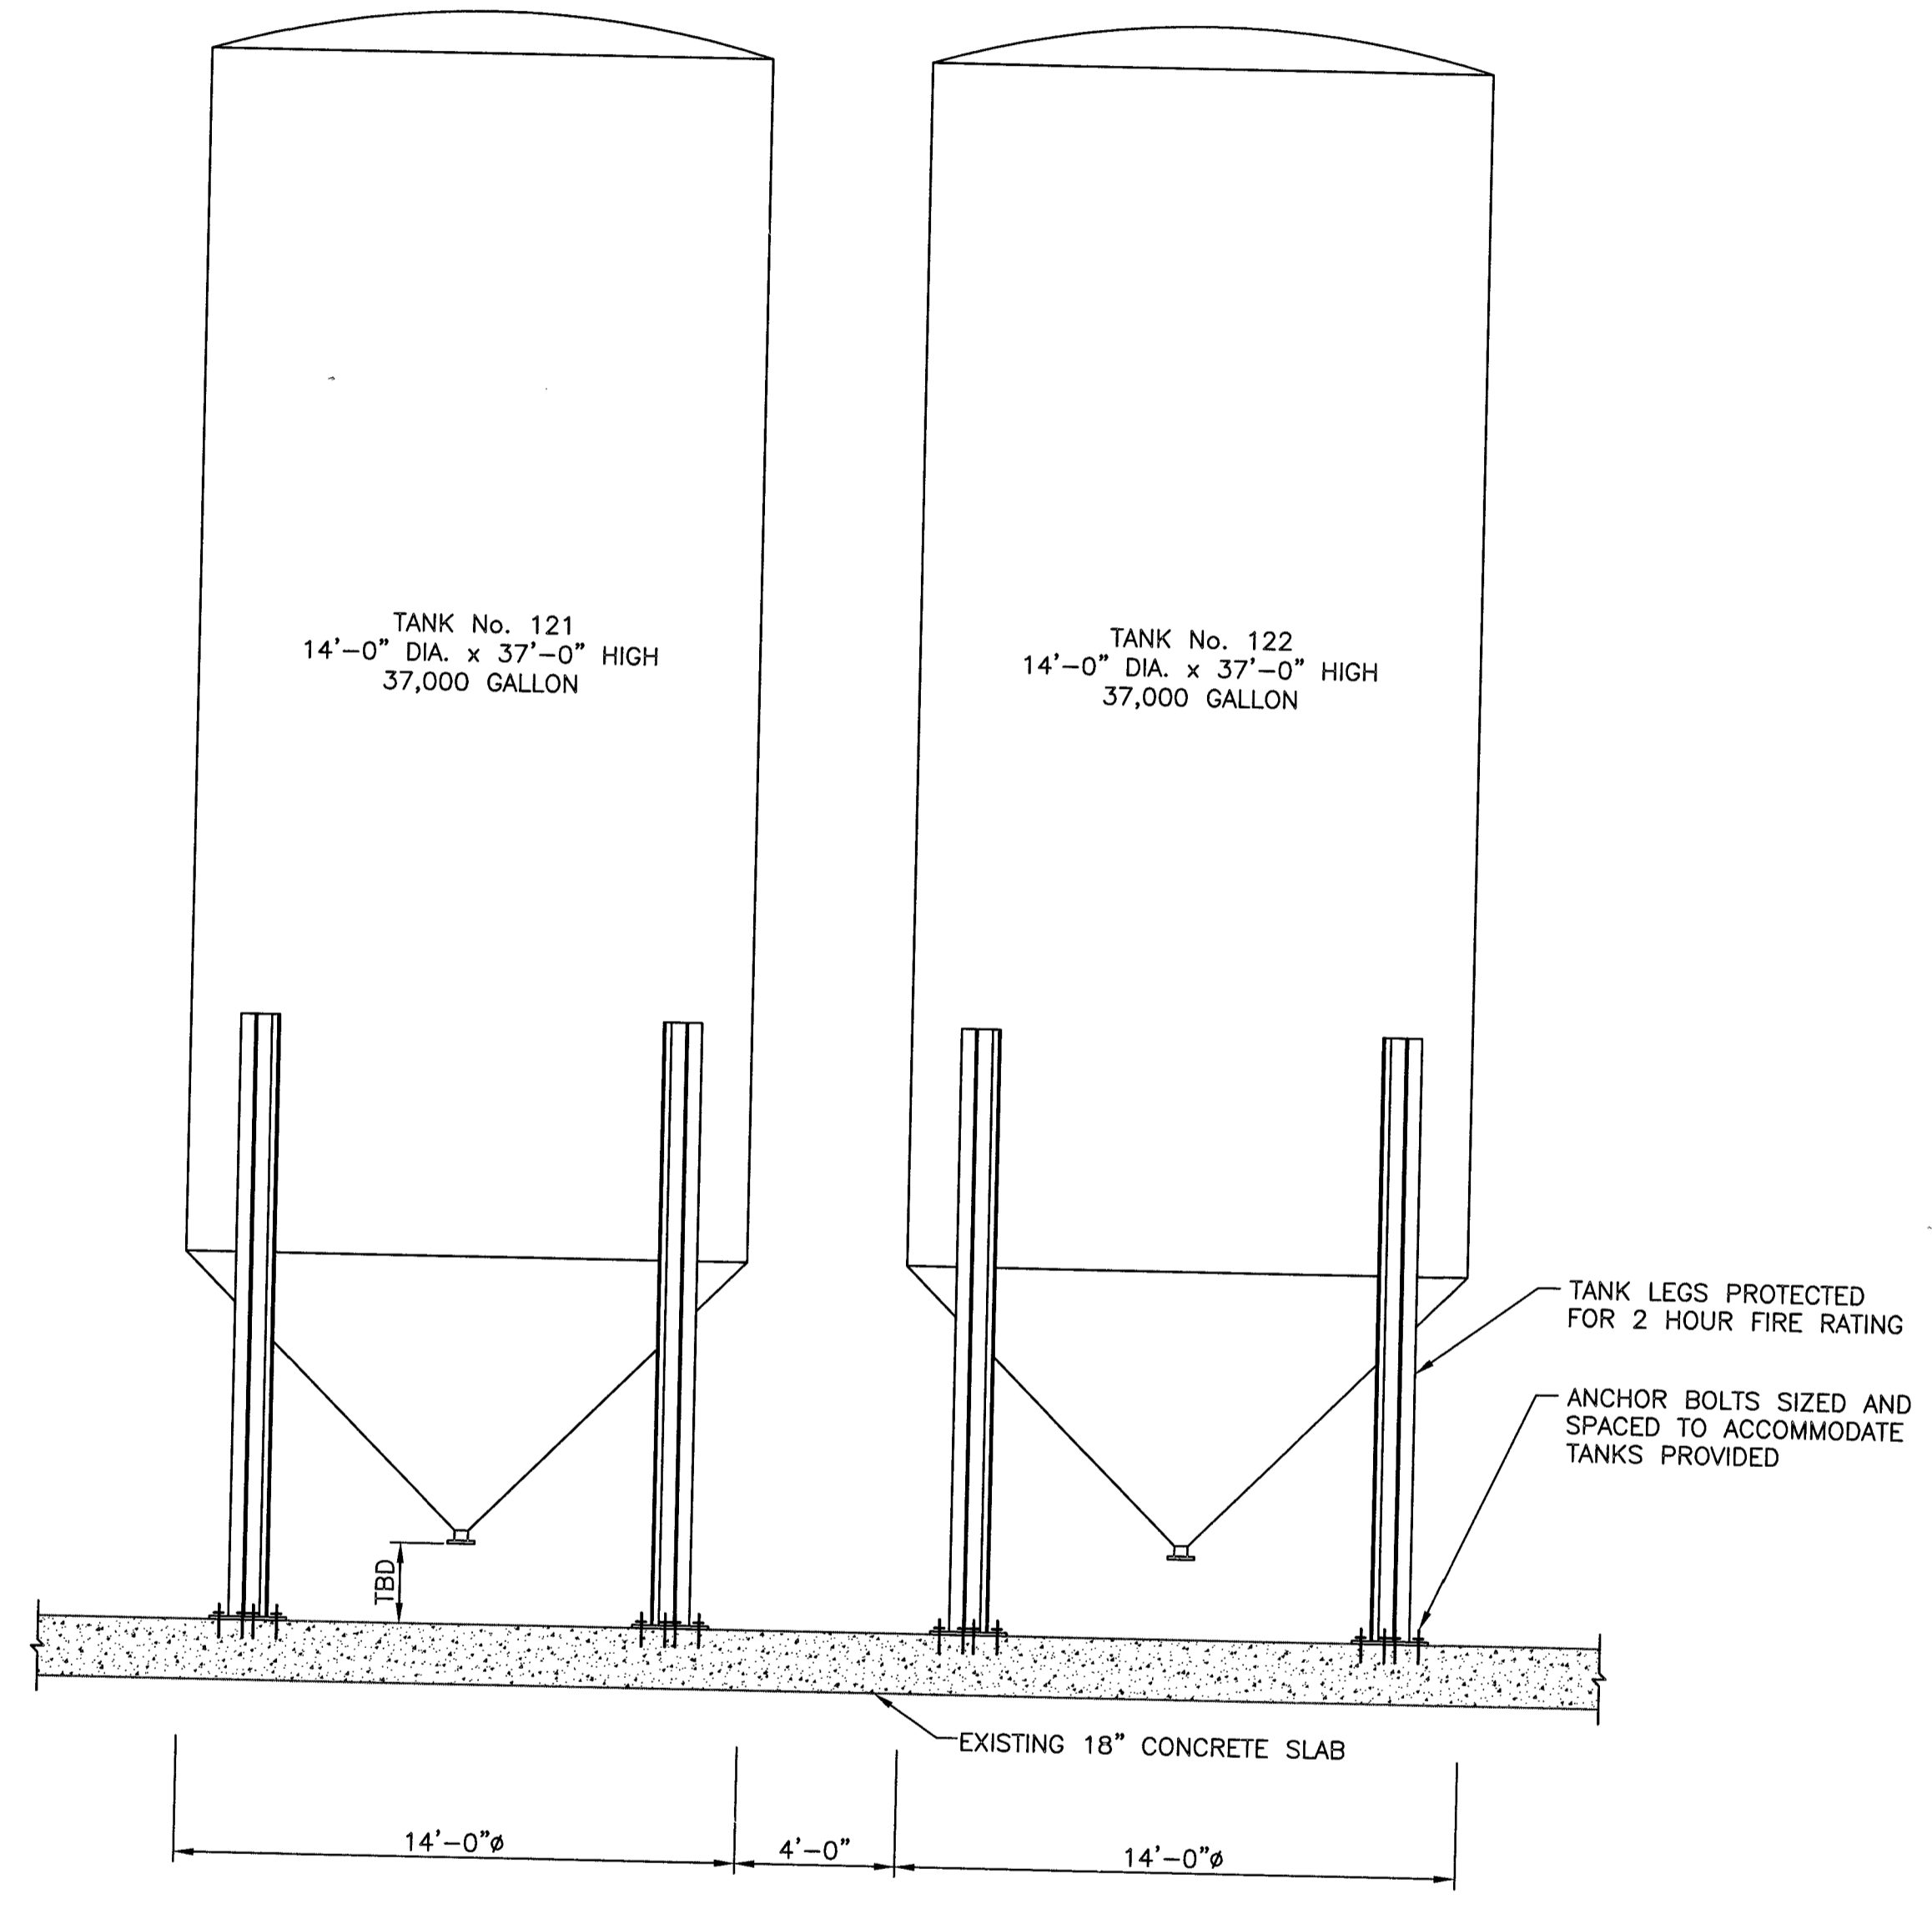

TYPICAL SECTIONS
1/4" = 1'-0"

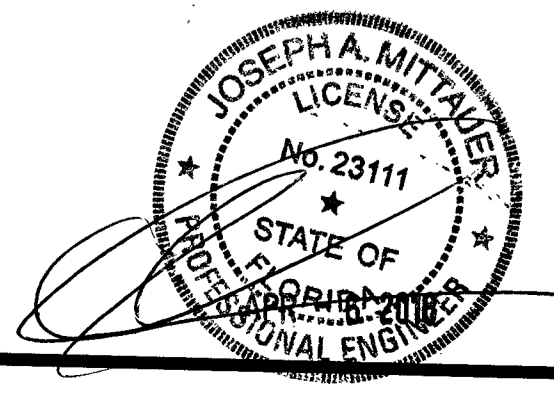

LIQUID ENVIRONMENTAL SOLUTIONS
Permit Modification for Tanks 121 & 122
Tank 121 & 122 Asbuilt
Jacksonville, FL

JOB NO.
9122-43-1
SHEET NO.

MITTALJER & ASSOCIATES, INC.
CONSULTING ENGINEERS
580-1 WELLS ROAD, ORANGE PARK, FLORIDA 32073
TEL. (904) 278-0030 FAX. (904) 278-0640 FLORIDA CA NO. 6569

DESG	JAM
DRWN	DSH
PROJ	JAM
MR.	
DATE	4/9/18

1 INCH

NO	DATE	BY

REVISION DESCRIPTION