

PROBE TAG NUMBERS:


AE 0664 B	BOILER #2 ECONO. DUCT	AE 0663 B	BOILER #2 STACK
AE 0664 A	BOILER #1 ECONO. DUCT	AE 0663 A	BOILER #1 STACK

REVISIONS

1	INITIAL ISSUE	PR	05-03-93
2	REV. PER. UEAC 5-3-93 COMMENTS	PR	6-15-93

TERMINATION STRIP

BLK	12AWG BLK	POWER
BRN	12AWG BLK	TO
GRN	16AWG GRN	HW PROBE HEATER
SW		PT-100

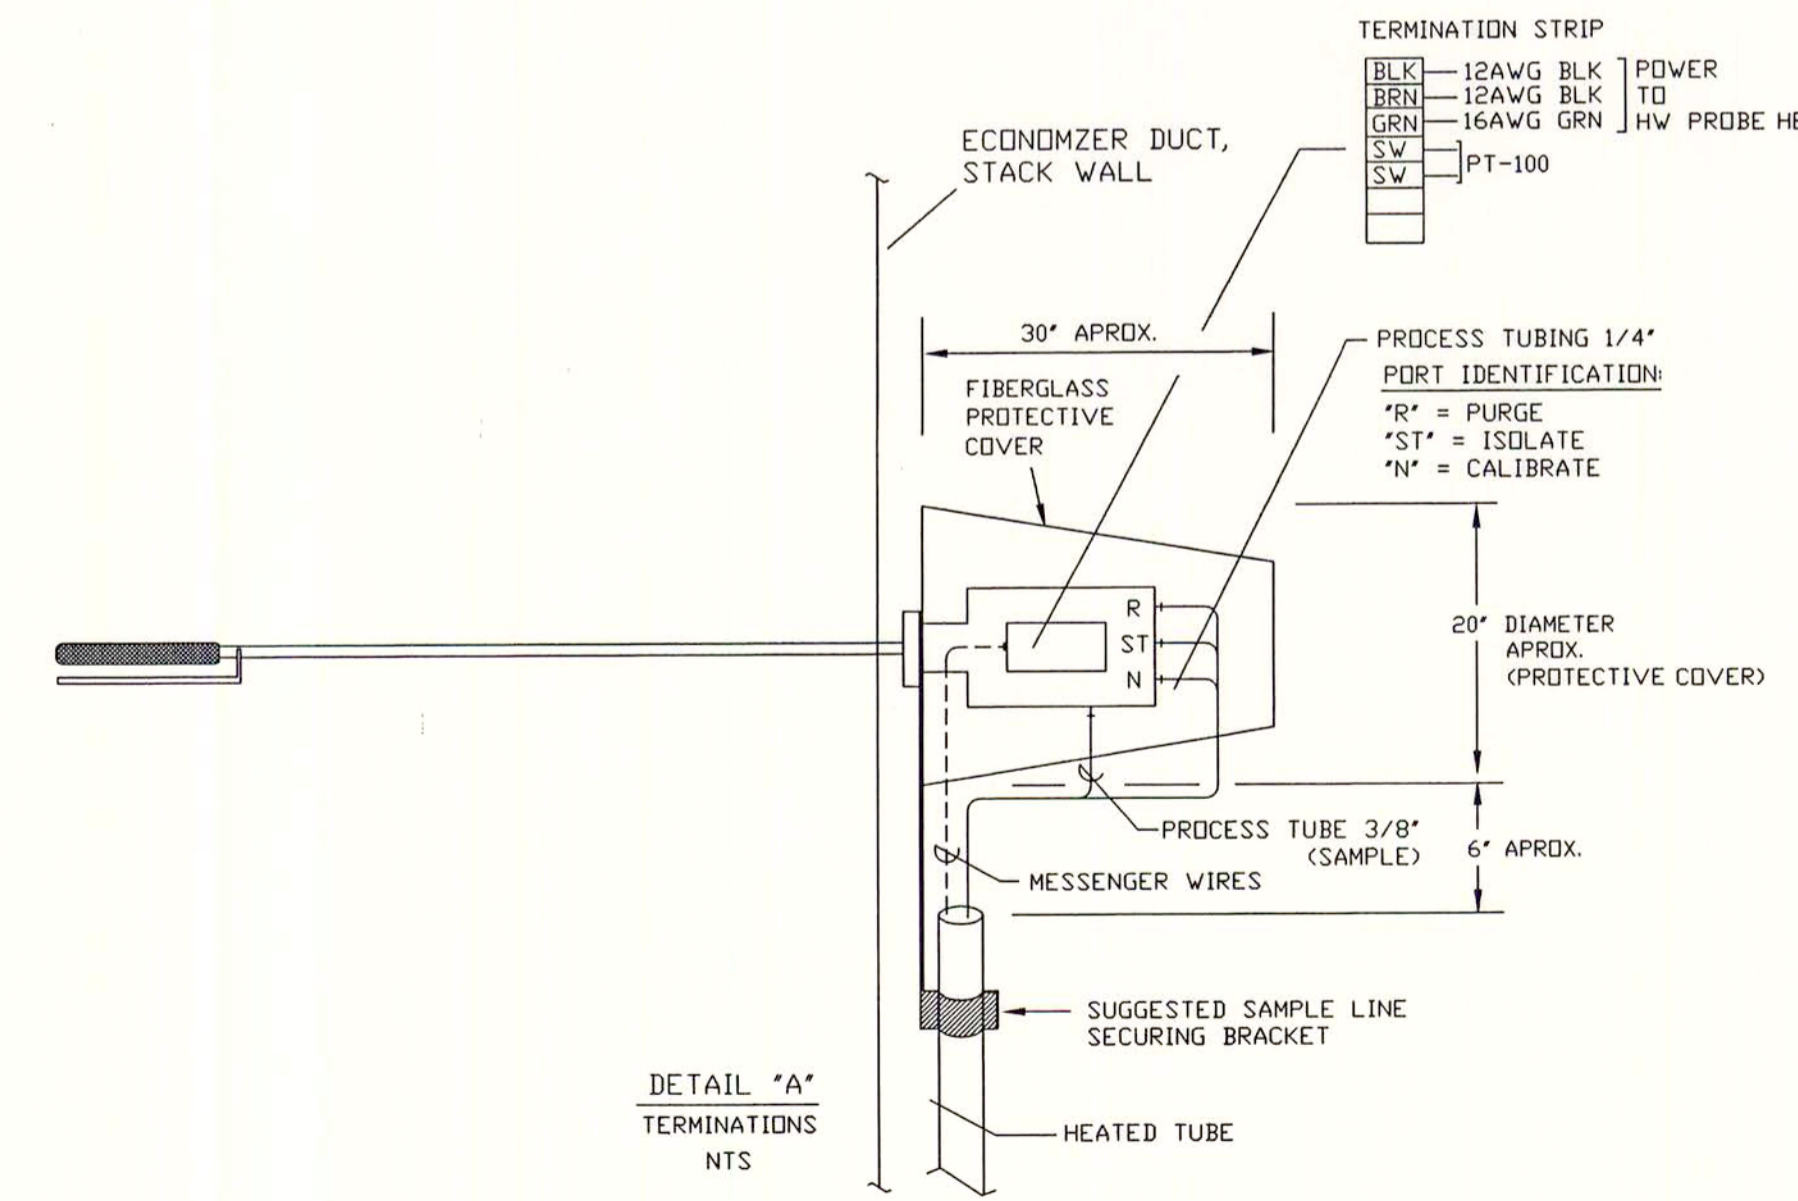

NOTE:
 SUGGESTED CLEARANCES FOR SERVICE
 -PROVIDE 6'-ACCESS FROM MOUNTING FLANGE FOR PROBE EXTRACTION
 -PROVIDE 3'-DIAMETER AROUND PROBE

REFERENCE DRAWINGS:
 STD-CEM-SL1 INSTALLATION DETAILS
 ELECTRIC TRACE BUNDLES
 220103 P&ID
 LE-1033-00 SH1 CEM FUNCTIONAL BLOCK DIAGRAM



OGDEN MARTIN SYSTEMS OF LEE, INC.
 PROBE DETAIL

OGDEN PROJECTS, INC.		LEE	
DRAWN	DATE	DESIGNED	DATE
PR	05/03/93	PR	05/03/93
CHECKED	DATE	PROJECT NO.	SCALE
/ /	/ /		1 = 1
APPROVED	DATE	DRAWING NO.	SHT. OF REV.
/ /	/ /	LE-1033-12	1 OF 2

...COMPANY CONFIDENTIAL...
 This drawing and all information contained herein are the property of OGDEN MARTIN SYSTEMS OF LEE, INC. and are not to be used except as expressly authorized in writing by said company.

LE121-2 06-15-93 P11=1 70"