

CITRUS COUNTY BOARD OF COUNTY COMMISSIONERS
CITRUS COUNTY, FLORIDA

WACS ID# 39859
REVISED
CL 1


CITRUS COUNTY CENTRAL SANITARY LANDFILL EXPANSION
LEACHATE TREATMENT FACILITY

D.E.R.
OCT 18 1988
SOUTH WEST DISTRICT
TAMPA

D.E.R.
OCT 18 1988
SOUTH WEST DISTRICT
TAMPA


LIST OF SHEETS

SHEET NO.	TITLE
G-1	COVER SHEET
G-2	LEGEND, SYMBOLS AND ABBREVIATIONS
C-1	GENERAL AREA MAP
C-2	OVERALL SITE PLAN
C-3	LEACHATE TREATMENT PLANT SITE PLANS
C-4	PERCOLATION POND SITE PLANS
M-1	SEQUENCING BATCH REACTOR
M-2	AEROBIC DIGESTOR AND CHLORINE CONTACT TANK
M-3	SEQUENCING BATCH REACTORS-SECTION
M-4	EFFLUENT FILTER PLAN AND ELEVATIONS
M-5	SLUDGE DRYING BEDS
M-6	SLUDGE DRYING BEDS-SECTIONS
M-7	LEACHATE PUMP STATION
M-8	CHEMICAL AND CHLORINATION SYSTEMS
M-9	PLANT DRAIN PUMP STATION
D-1	MISCELLANEOUS DETAILS

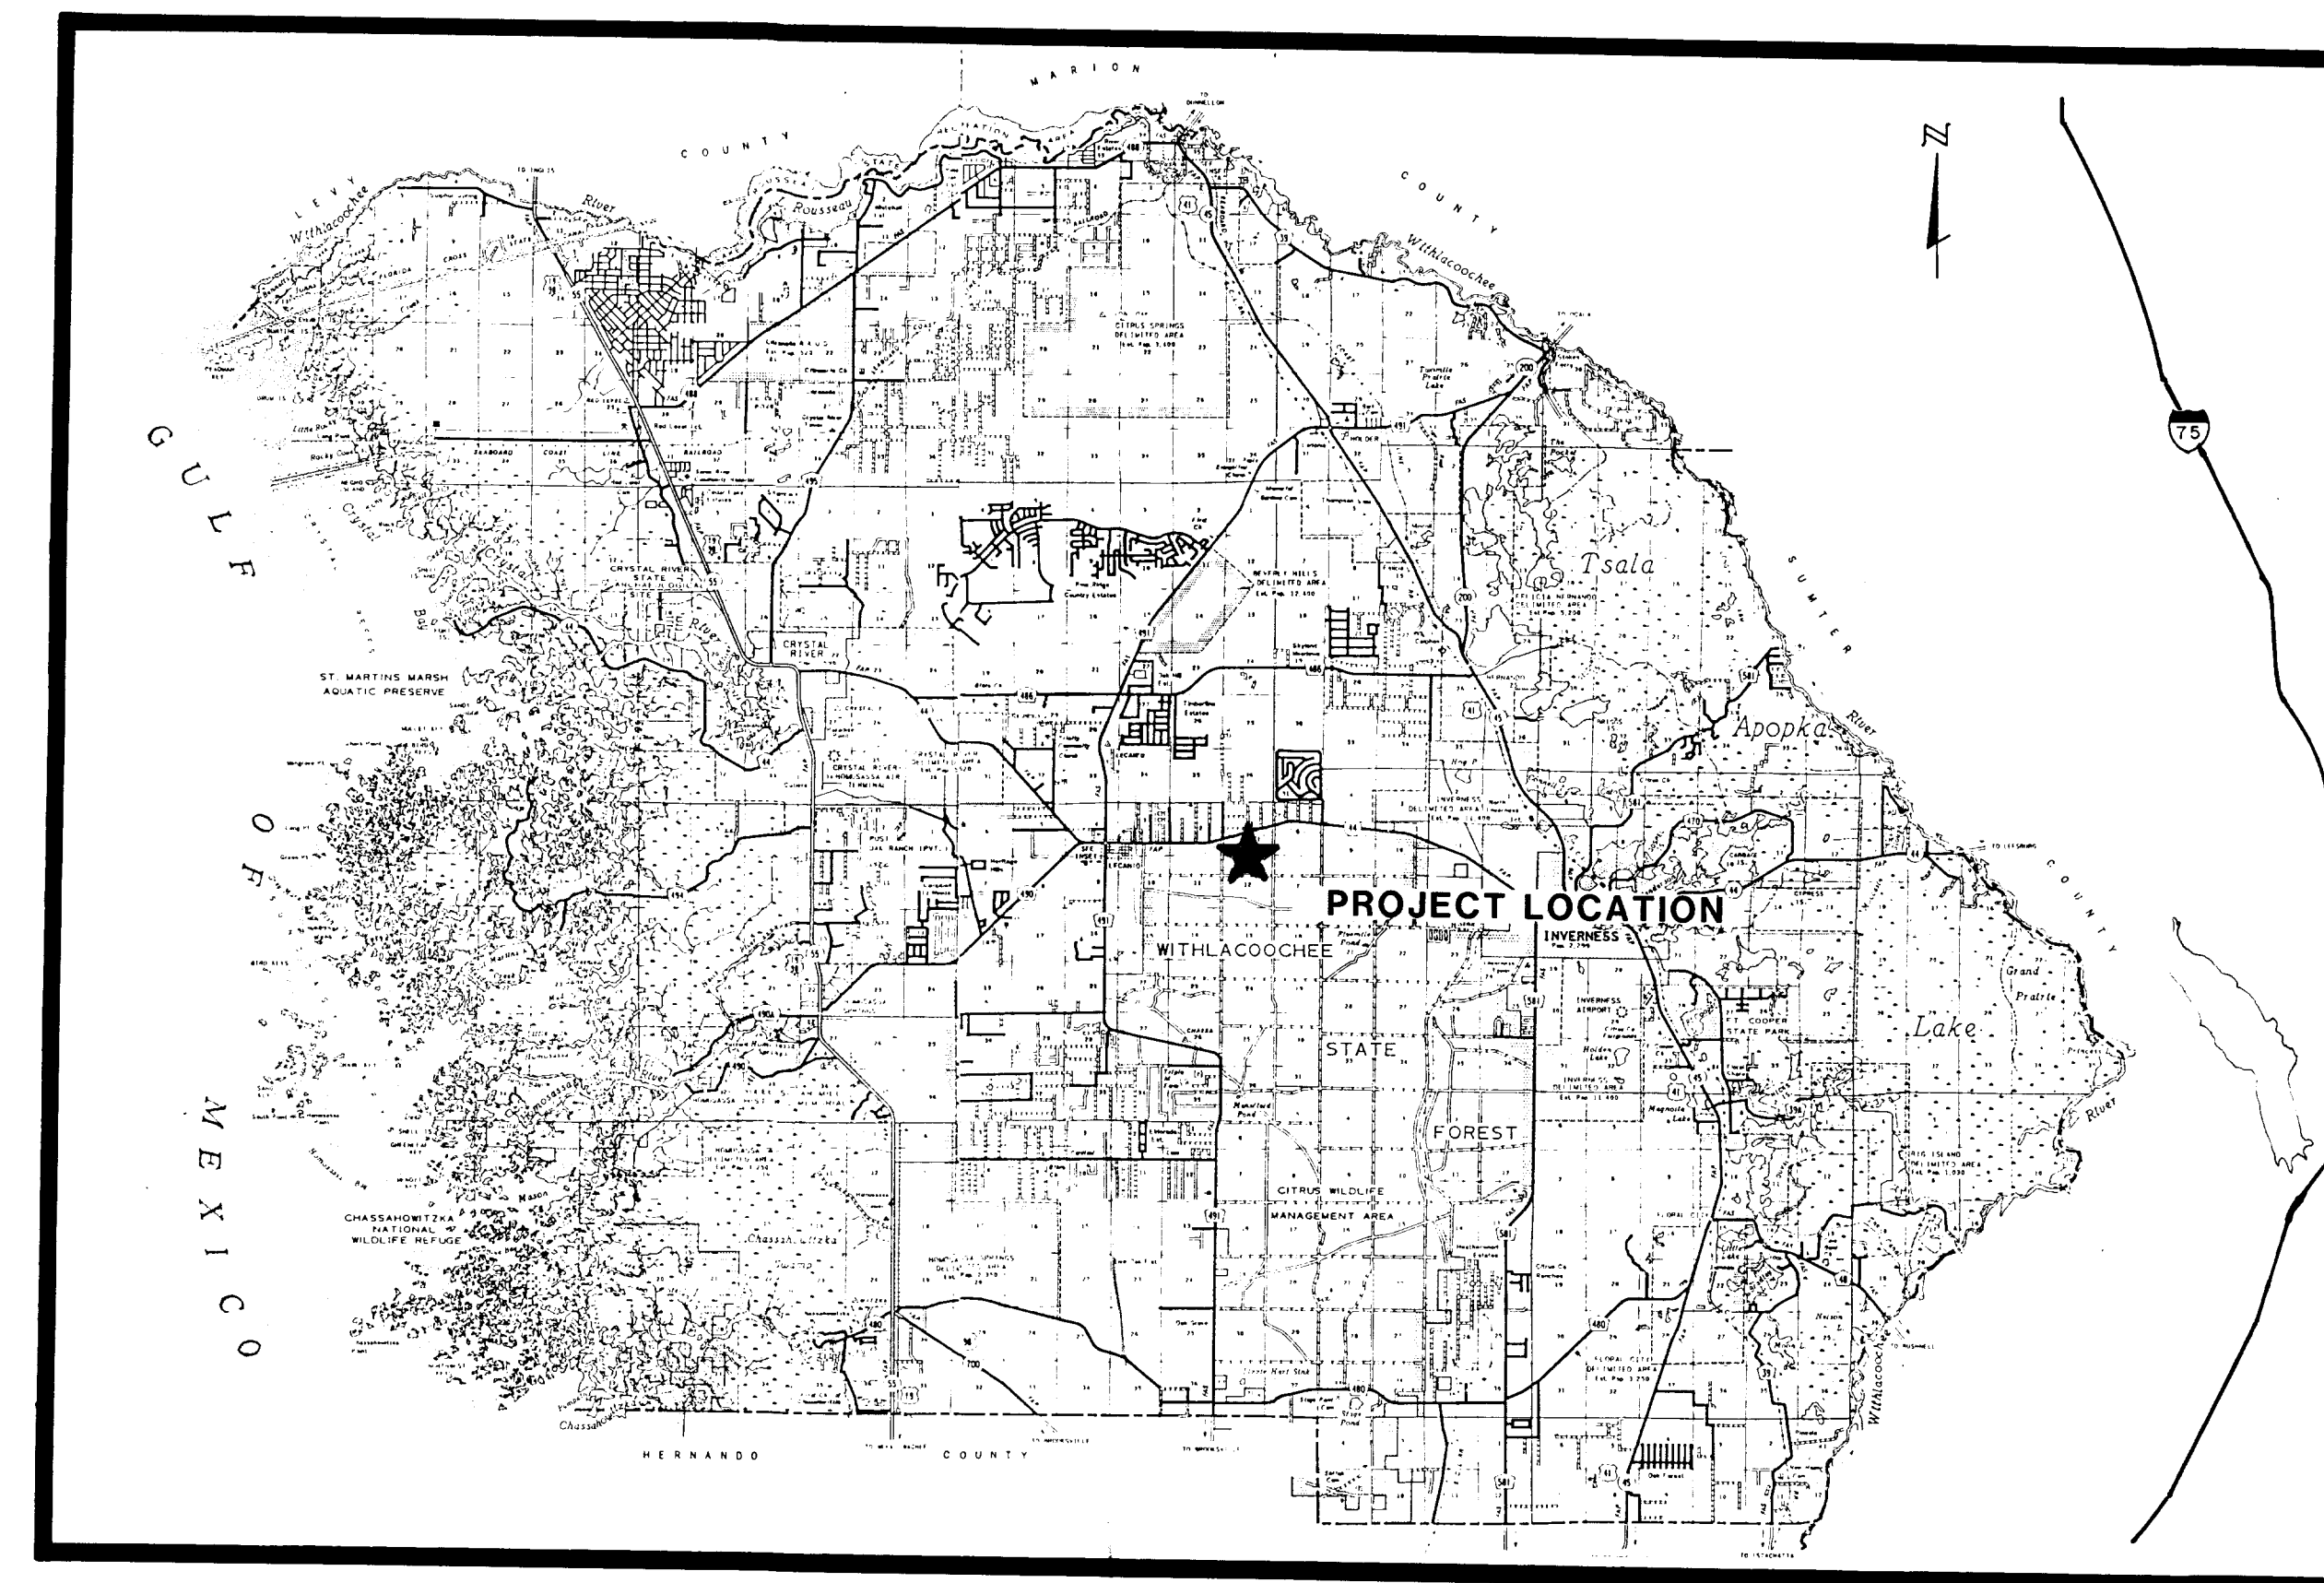

COMMISSIONERS

NICK BRYANT, CHAIRMAN
WILLIAM J. (SKIP) HUDSON, 1st VICE CHAIRMAN
WILLIAM FRANK BROSKA, 2nd VICE CHAIRMAN
HANK COHEN
F. ALEX GRIFFIN

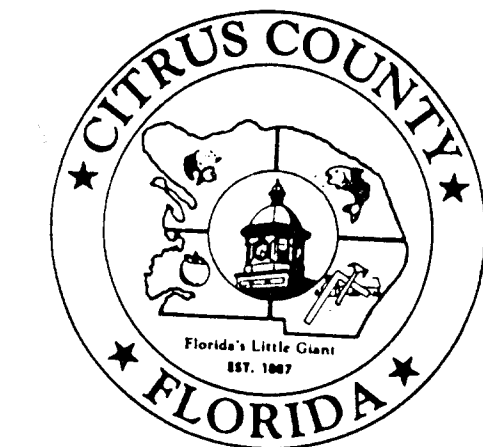

PREPARED BY

POST, BUCKLEY, SCHUH & JERNIGAN INC.
CONSULTING ENGINEERS
TAMPA, FLORIDA

D.E.R.
OCT 18 1988
SOUTH WEST DISTRICT
TAMPA

SEPTEMBER 1988

ENGINEERS PROJECT NUMBER 22-081.30

ABBREVIATIONS

MECHANICAL

Designation	Abbrev.	Designation	Abbrev.	Designation	Abbrev.	Designation	Abbrev.	Designation	Abbrev.
Acrylonitrile Butadiene	A.B.S.	Drain	Dr.	Left	Lat.	Pressure Relief Valve	P.R.V.	Transfer	Trans.
Adapter	Adpt.	Ductile Iron	D.I.	Length	Lgth.	Process	Proc.	Typical	Typ.
Alternate or Alternative	Alt.	Each	Ea.	Level	Lev.	Product	Prod.	Ultraviolet Polyvinyl	U.P.V.C.
Aluminum	Alum.	Eccentric	Ecc.	Linear Feet	L.F.	Proposed	Prop.	Chloride	Chl.
American Society for Testing Materials	A.S.T.M.	Effluent	Eff.	Low Water Level	L.W.L.	Quantity	Qty.	Volume	Vol.
American Water Works Association	A.W.W.A.	Elbow	Elb.	Lubricate	Lub.	Raw Sewage	R.S.	Variable	Var.
Angle	Ang.	Elevation	Elev.	Manhole	Man.	Reference	Ref.	Volume	Vol.
Approximate	Approx.	Engineer	Engr.	Manufacture	Mfr.	Reinforced Concrete	R.C.P.	Water Level	W.L.
Asphalt	Asph.	Equipment	Equip.	Manufacturing	Mfg.	Pipe	Pipe	Water Main	W.M.
Assembly	Ass'y.	Exhaust	Exh.	Material	Mat'l.	Required	Req'd.	Waterproof	W.P.
Automatic	Auto.	Existing	Exist.	Maximum	Max.	Restrained	Restr.	Weight	Wt.
Auxiliary	Aux.	Expansion	Exp.	Mechanical Joint	M.C.J.	Return Activated Sludge	R.A.S.	Without	W/O
Ball Valve	B.V.	Fabricate	Fab.	Revolutions Per Minute	R.P.M.	Reverse	Rev.		
Bench Mark	B.M.	Feet or Foot	Ft. or ' '						
Bevel	Bevl.	Figure	Fig.	Million Gallons Per Day	M.G.D.				
Bituminous	Bit.	Fitting	Ftg.	Minimum	Min.				
Boiler	Boilr.	Force Main	F.M.	Miscellaneous	Misc.	Sanitary Sewer	San. Sew.		
Boiler Feed	B.F.	Gallon	Gal.	Motor Control Center	M.C.C.	Schedule	Sch.		
Bottom	Bot.	Gallons Per Minute	G.P.M.	Mounted	Mtd.	Schematic	Schem.		
Bracket	Brkt.	Galvanized Gate Valve	G.V.	Mounting	Mntg.	Section	Sect.		
Brass	Brss.	Gauge (or gage)	Ga.	National Pipe Thread	N.P.T.	Service	Serv.		
Butterfly Valve	B.V.V.	Grade	Gr.	Not in Contract	N.I.C.	Sheet	Shet.		
Cable Television	CATV	Grating	Grtg.	Not to Scale	N.T.S.	Sleeve	Slv.		
Capacity	Cap.	Handle	Hdl.	Number	No.	Slotted	Slot.		
Casing	Csg.	Hardware	Hdw.	Opening	Op'ng.	Solenoid Valve	S.V.		
Cast Iron	C.I.	Height	Ht.	Openings	Op'gs.	Specifications	Specs.		
Center Line	C.L. or C.V.	High Water Level	H.W.L.	Or Equal	Or Eq.	Square	Sq.		
Check Valve	Chk. V.	Horizontal	Hrzt.	Original	Orig.	Stainless Steel	St. Stl.		
Concentric	Conc.	Horse Power	H.P.	Outside Diameter	O.D.	Standard	Std.		
Concrete	Conc.	Horse Bib	H.B.	Painted	Pnt.	Steel	Stk.		
Connection	Conn.	Hour	Hr.	Panel	Pnl.	Storm Sewer	S.S.		
Construction	Const.	Hydraulic	Hyd.	Phase	Phs.	Symbol	Sym.		
Copper	Cop.	Imperial	Imp.	Plain End	P.E.	System	Sys.		
Coupling	Cplg.	Inch	In.	Plug Valve	P.V.	Temperature	Temp.		
Deflection	Defl.	In. or (")	In. or (")	Plywood	Ply.	Thick	Thk.		
Degree	Deg.	Int. or (")	Int. or (")	Point	Pt.	Top of Slab	T.O.S.		
Department	Dept.	Inside Diameter	I.D.	Polyvinyl Chloride	P.V.C.	Top of Wall	T.O.W.		
Diameter	Dia.	Instrument	Inst.	Pounds Per Square Inch	P.S.I.	Pressure	Press.		
Dimension	Dim.	Invert	Inv.						
Discharge	Disch.	Joint	Jt.						

CIVIL

Designation	Abbrev.	Designation	Abbrev.	Designation	Abbrev.	Designation	Abbrev.	Designation	Abbrev.
Abutment	Abut.	Culvert	Culv.	Hour	Hr.	Product	Prod.	Television	T.V.
Acres	Ac.	Curb and Gutter	C & G.	Hydraulic Grade Line	H.G.L.	Profile	Pf.	Terminal	Term.
Alternate or Alternative	Alt.	Decal	Dec.	Inch	In.	Profile Grade	P.G.	Thick	Thk.
Angle	Ang.	Department	Dept.	Inlet	Inl.	Property Line	P.L. or P.	Thousand	M.
Apartment	Apt.	Detour	Det.	Inside Diameter	I.D.	Proposed	Prop.	Toe of Slope	T.O.S.
Approximate	Approx.	Diagonal	Diag.	Invert	Inv.	Quadrant	Quad.	Top of Blank	T.O.B.
Asbestos Cement	A.C.	Diameter	Diam.	Irrigation	Irrig.	Radial	Rad.	Township	Twp.
Asphalt	Asph.	Dimension	Dim.	Joint	Jt.	Radius	R.	Typical	Typ.
Assembly	Assm.	Distance	Dist.	Lateral	Lat.	Railroad	R.R.	U.S. Geological Survey	U.S.G.S.
Auxiliary	Aux.	Ditch	Ditch	Left	Left	Range	R.	Valve	V.
Avenue	Ave.	Drawing	Dwg.	Length	Lgth.	Record	Rec.	Vertical	Vert.
Axis	Ax.	Ductile Iron	D.I.	Linear Feet	L.F.	Reference	Ref.	Vitrified Clay Pipe	V.C.P.
Baseline	B.L.	Each	Ea.	Littoral Shelf	L.S.	Reinforced Concrete Pipe	R.C.P.	Volume	Vol.
Bearing	Brg.	Easement	Easmt.	Low Water Level	L.W.L.	Required	Req'd.	Water Level	W.L.
Bench Mark	B.M.	East	Easmt.	Manhole	M.H.	Right	Rt.	Water Main	W.M.
Bituminous	Bit.	Edge of Pavement	EOP	Material	Mat'l.	Right-of-Way	R/W	Waterproof	W.P.
Block	Blk.	Elevation	Elev.	Maximum	Max.	Road	Rd.	West	W.
Blow Off	B.O.	Elbow	Elb.	Mean High Water	M.H.W.	Sanitary Sewer	S.S.	Without	W/O
Bottom	Bot.	ETL	ETL	Mechanical Joint	M.C.J.	Schedule	Sch.		
Boulevard	Bvld.	Elliptical Reinforced	ERCP	Minimum	Min.	Seasonal High Waterline	SHWL		
Building	Bldg.	Engineer	Eng.	Minute	Min.	Second	Sec.		
Cable Television	CATV	Excavate	Exc.	Miscellaneous	Misc.	Section	Sect.		
Capacity	Cap.	Existing	Exist.	Monument	Mon.	Service	Svc.		
Cast Iron	C.I.	Feet or Foot	Ft. or ' '	North	N.	Sheet	Shet.		
Catch Basin	C.B.	Figure	Fig.	Not in Contract	N.I.C.	Shoulder	Shldr.		
Center Line	C.L. or C.V.	Fire Hydrant Assembly	F.H.A.	Not to Scale	N.T.S.	Sidewalk	S.W.		
Chord	Chd.	Fitting	Ftg.	Number	No.	Soil Pipe	S.P.		
Circle	Cir.	Flange	Flg.	Outside Diameter	O.D.	South	S.		
Circumference	Circ.	Gallon	Gal.	Parallel	Par.	Specifications	Specs.		
Clean Out	C.O.	Gallons Per Minute	G.P.M.	Parking	Pkng.	Square	Sq.		
Company	Co.	Gate Valve	G.V.	Pavement	Pkwy.	Square Feet	Sq. Ft.		
Concrete	Conc.	Gauge or Gage	Ga.	Phase	Phs.	Standard	Std.		
Construction	Const.	Grade	Gr.	Point	Pt.	Station	Sta.		
Corner	Cor.	Grade Break	G.B.	Point of Curvature	P.C.	Storm Sewer	S.S.		
Corrugated Metal Pipe	CMP	Gutter	Gutter	Point of Intersection	P.I.	Street	Strt.		
Corrugated Metal Pipe	CMP	Headwall	Hdw.	Point of Tangency	P.T.	Surface	Surf.		
Arch	Arch	High Point	H.P.	Point of Vertical Curve	P.V.C.	Symbol	Sym.		
Cover	Cov.	High Water Level	H.W.L.	Intersection	Int.	System	Sys.		
Cross Section	C.S.	Highway	Hwy.	Point of Vertical Tangent	P.V.T.	Taper	Tpr.		
Cubic Feet (Foot)	CF	Horizontal	Hrzt.	Polyvinyl Chloride	P.V.C.	Telephone	Tel.		
Cubic Yard	CY	Horse Bib	H.B.						

SYMBOL AND DESCRIPTION

MECHANICAL

SINGLE LINE PIPING:

JOINT CONVENTIONS:

EQUIPMENT SYMBOLS:

PIPE CONVENTIONS:

SECTION INDICATOR:

TITLE FOR SECTIONAL VIEW:

SECTION

REVISIONS:

1

2

3

131


132

133


134

135

136

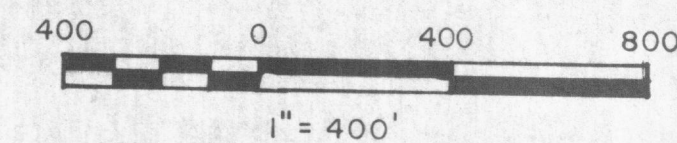



FLIGHT DATE: MAY 27, 1988
ZONED GOVERNMENTAL USE

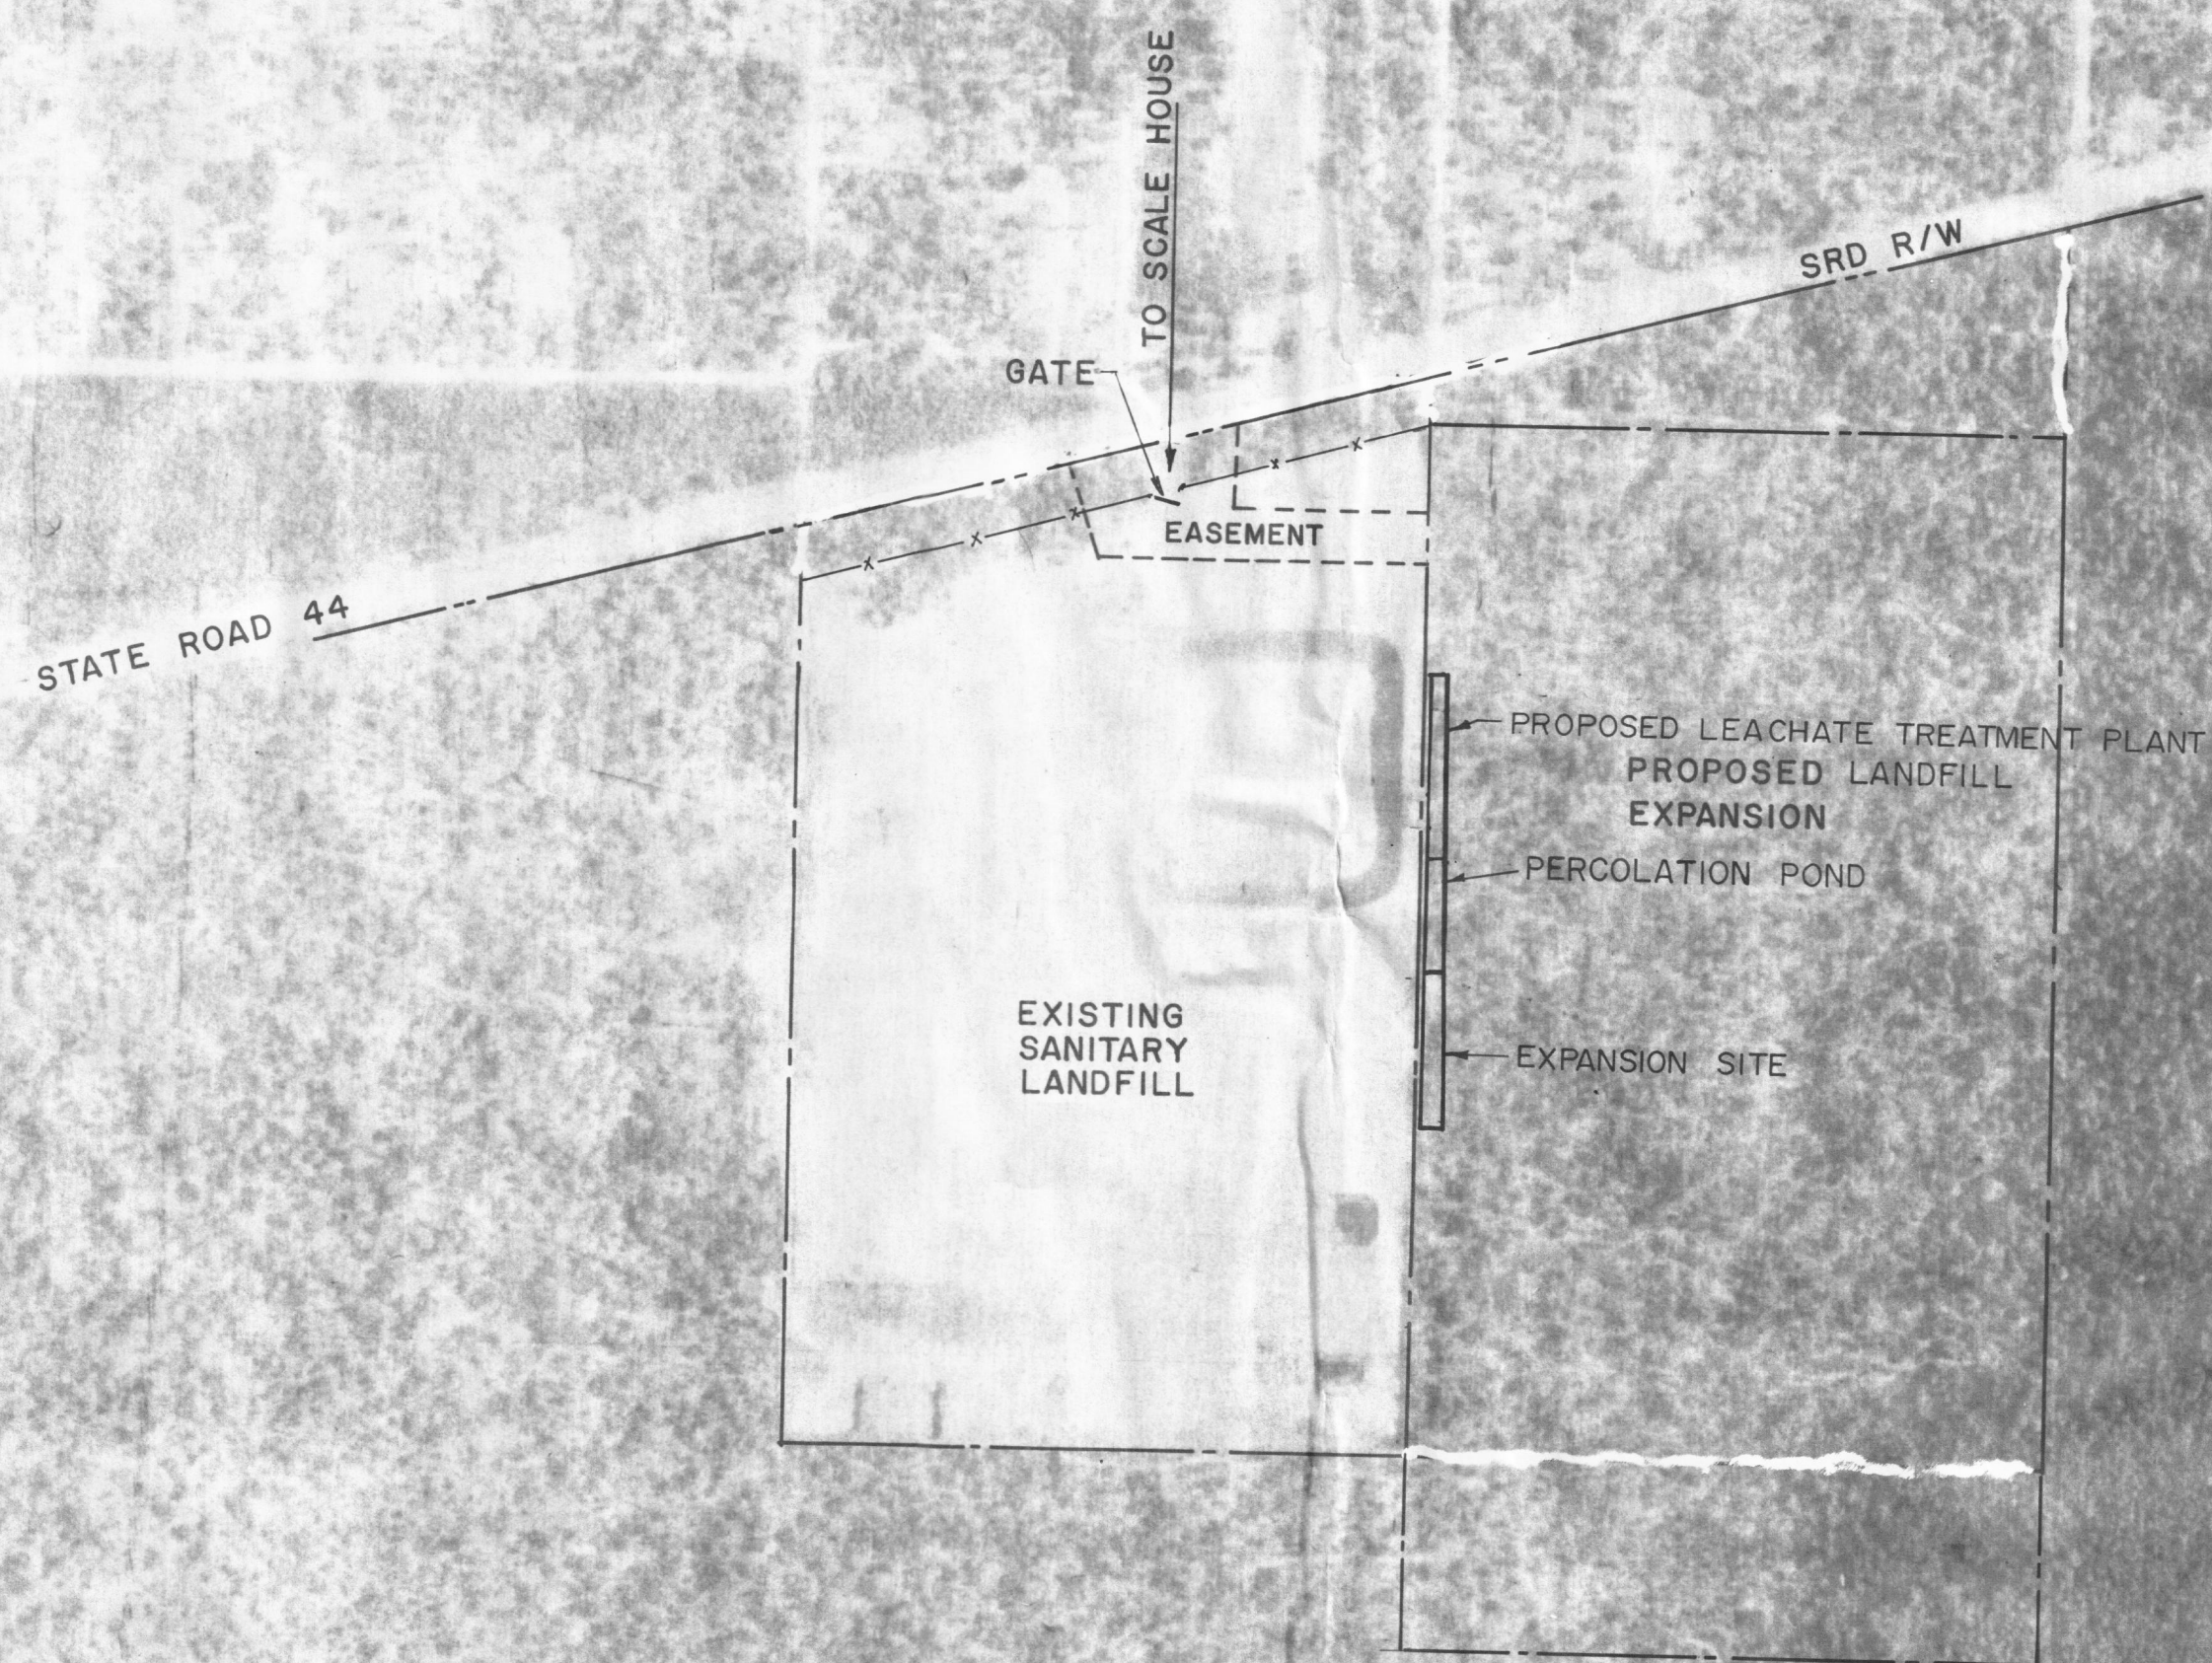


REVISED
OCT 10 1988
SOUTH WEST DISTRICT
TAMPA

[Signature]
9-30-88


	CLIENT CITRUS COUNTY, FLORIDA DEPARTMENT OF TECHNICAL SERVICES	PROJECT CITRUS COUNTY CENTRAL LANDFILL EXPANSION LEACHATE TREATMENT FACILITY	TASK GENERAL AREA MAP	ORIGINAL AUGUST 1988 REVISIONS: 1 2 3 4 5	6 7 8 9 10 11 12	JOB NO. 22-081.30 DRAWN D.D. DESIGNED TEI CHECKED <i>DAV</i> QC NOT VALID FOR CONSTRUCTION UNLESS SIGNED IN THIS BLOCK SHEET C-1
---	--	--	---------------------------------	---	------------------------------------	--

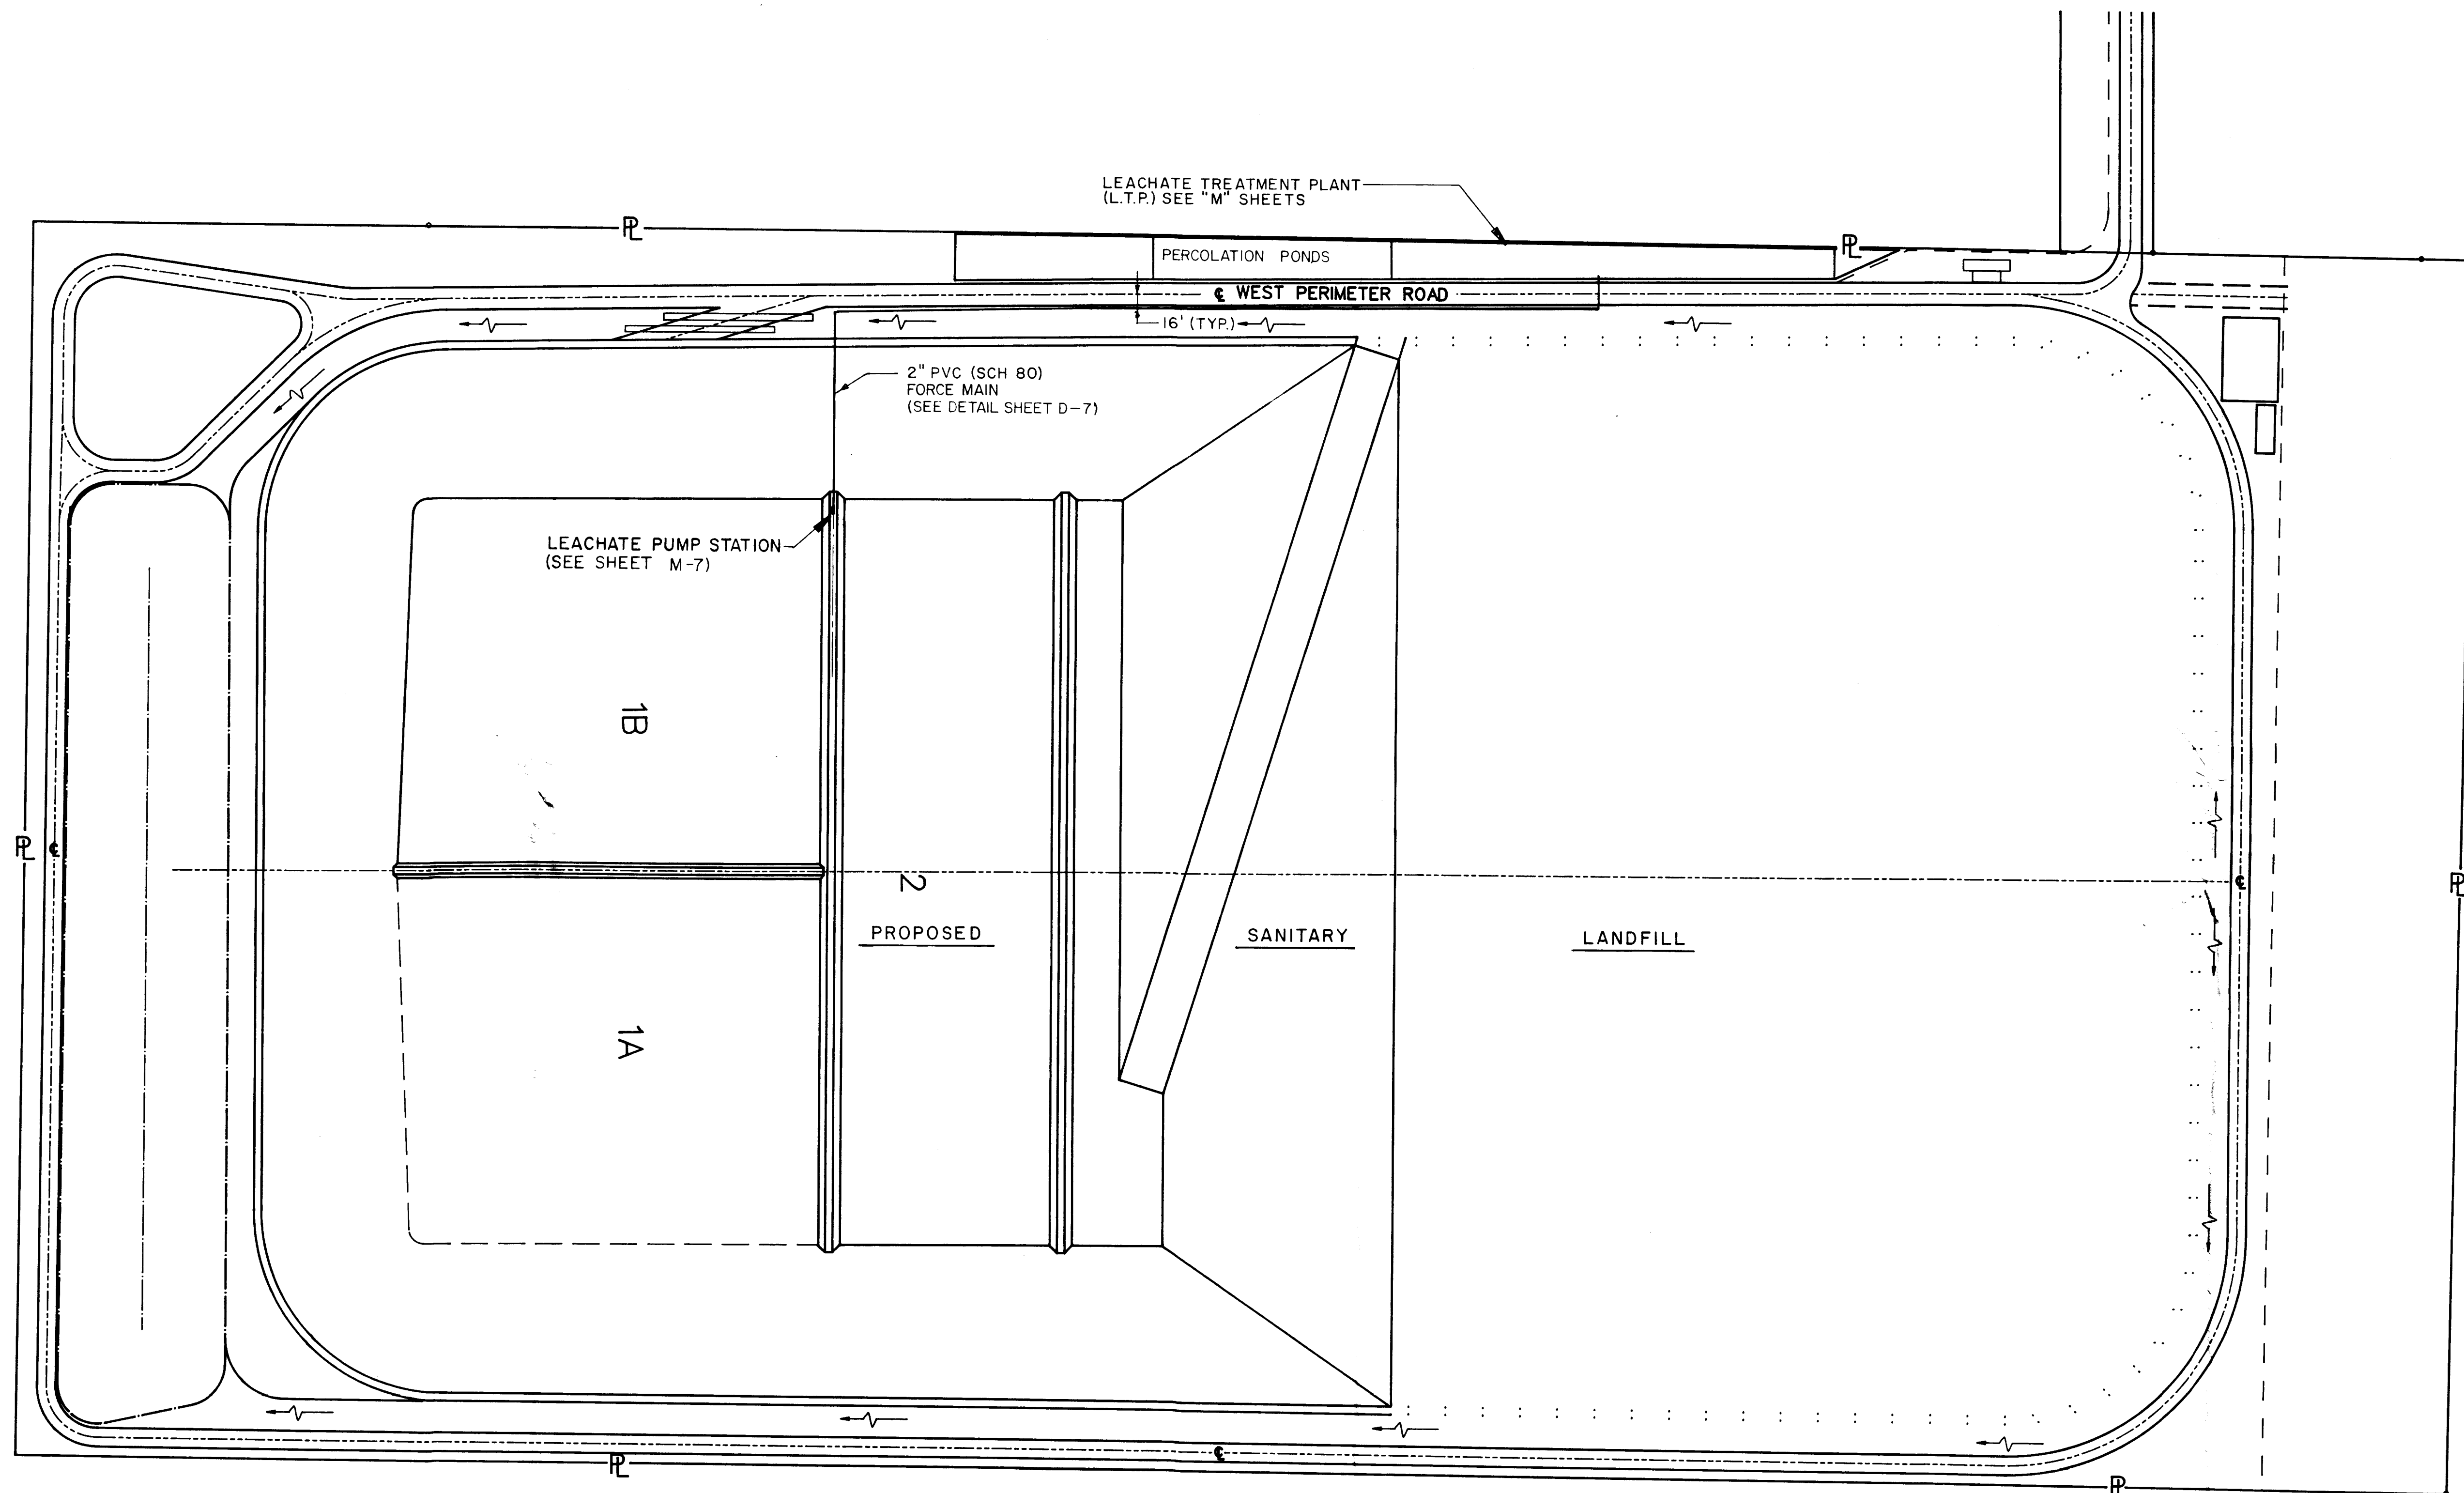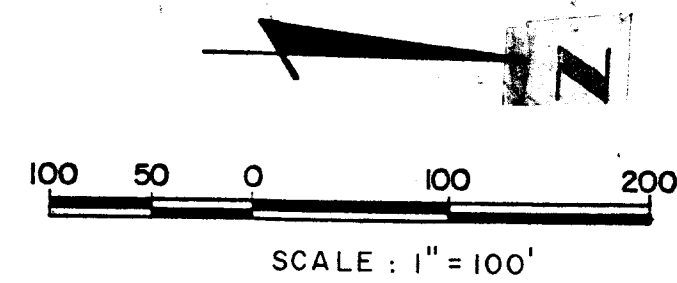


NOTE: LEACHATE PUMP STATION AND FORCE MAIN SHALL BE PART OF THIS CONTRACT AND COORDINATED WITH LANDFILL CONTRACT.

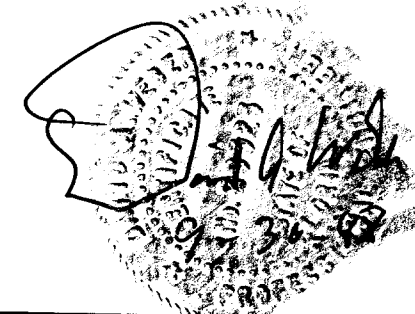


	CLIENT CITRUS COUNTY, FLORIDA DEPARTMENT OF TECHNICAL SERVICES	PROJECT CITRUS COUNTY CENTRAL LANDFILL EXPANSION LEACHATE TREATMENT FACILITY	TASK OVERALL SITE PLAN	ORIGINAL AUGUST 1988 REVISIONS: 1. _____ 2. _____ 3. _____ 4. _____ 5. _____	6. _____ 7. _____ 8. _____ 9. _____ 10. _____ 11. _____ 12. _____	NOT VALID FOR CONSTRUCTION UNLESS SIGNED IN THIS BLOCK	JOB NO. 22-081.30 DRAWN FS DESIGNED DS CHECKED DA QC SHEET C-2

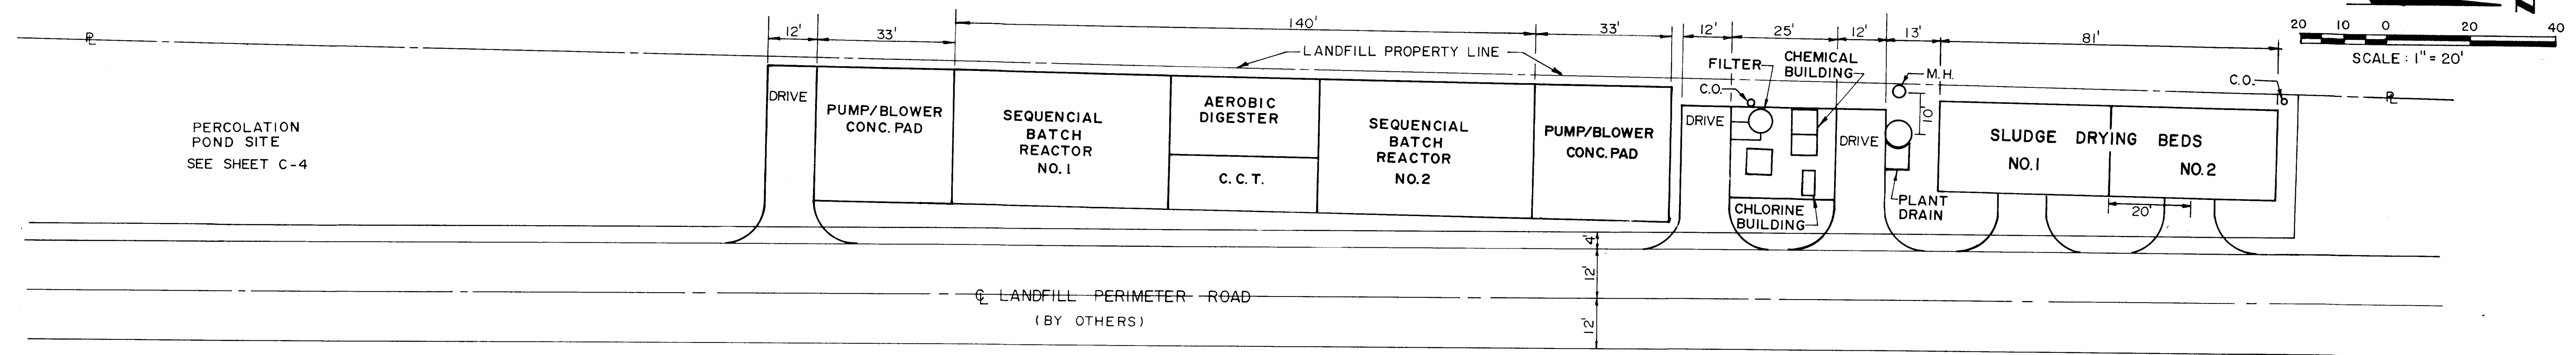


HORIZONTAL PROJECT CONTROL

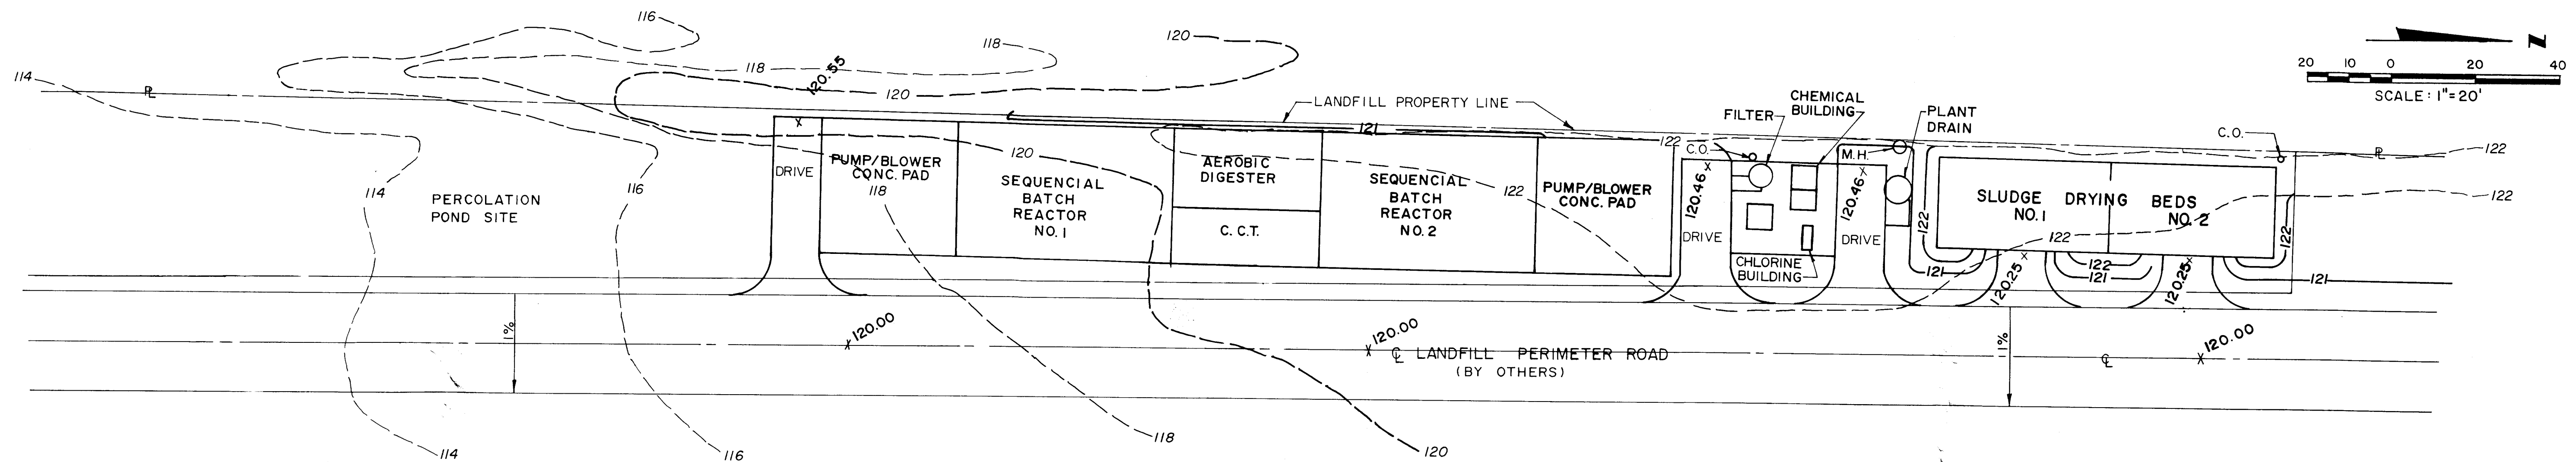

DRAINAGE & GRADING

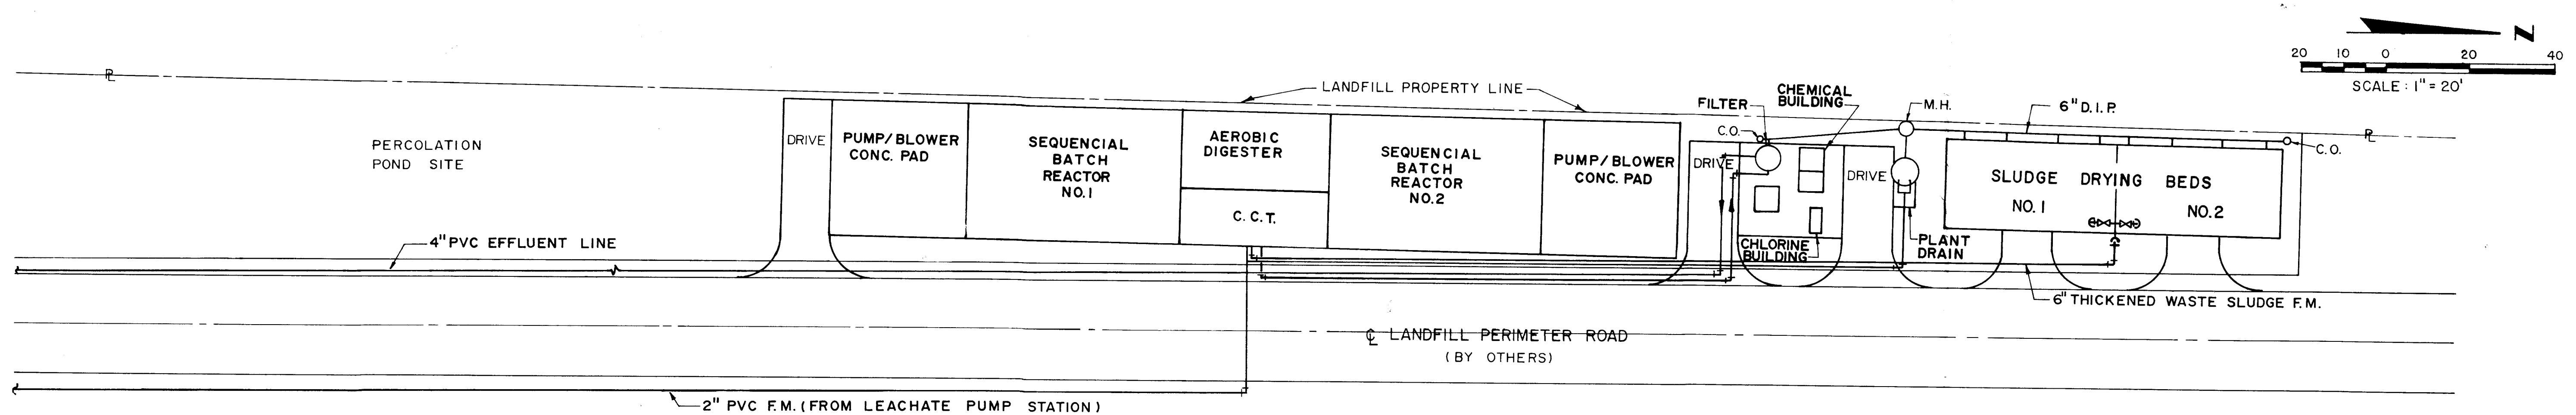

YARD PIPING

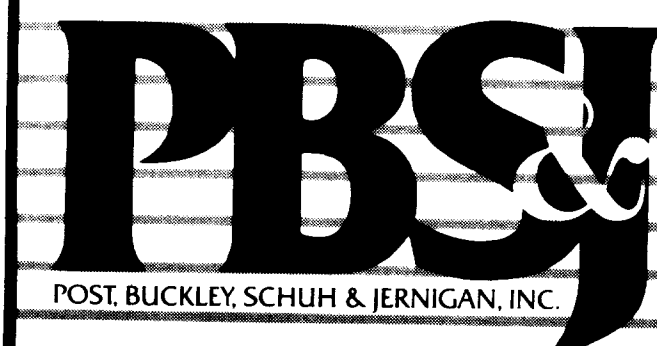

CLIENT

CITRUS COUNTY, FLORIDA
DEPARTMENT OF
TECHNICAL SERVICES

PROJECT

CITRUS COUNTY
CENTRAL LANDFILL EXPANSION
LEACHATE TREATMENT FACILITY

TASK

LEACHATE TREATMENT PLANT
SITE PLANS

ORIGINAL AUGUST 1988
REVISIONS:




1
2
3
4
5

6
7
8
9
10
11
12


NOT VALID FOR CONSTRUCTION
UNLESS SIGNED IN THIS BLOCK

JOB NO. 22-081.30
DRAWN R. Kelly
DESIGNED G. Kelly
CHECKED B. Kelly
QC

SHEET C-3

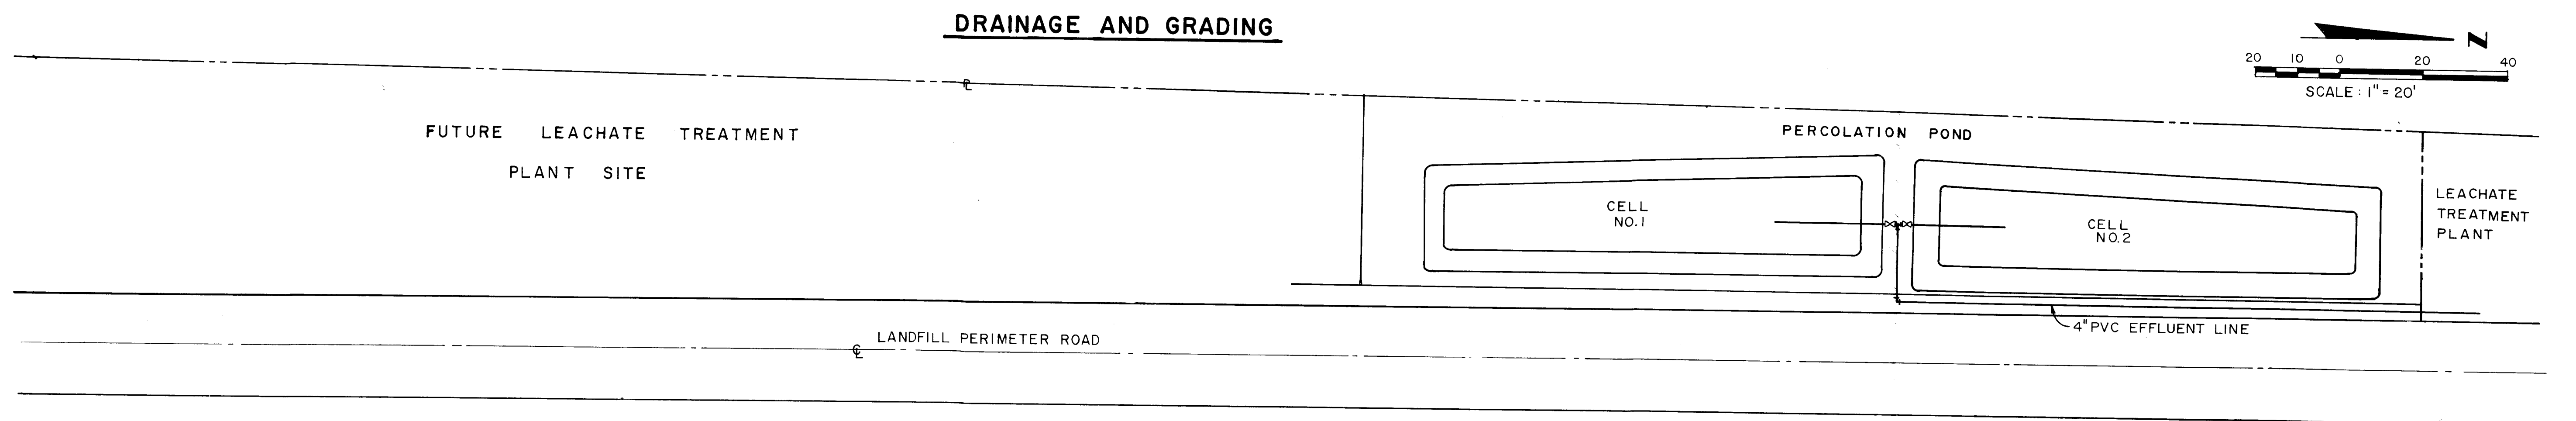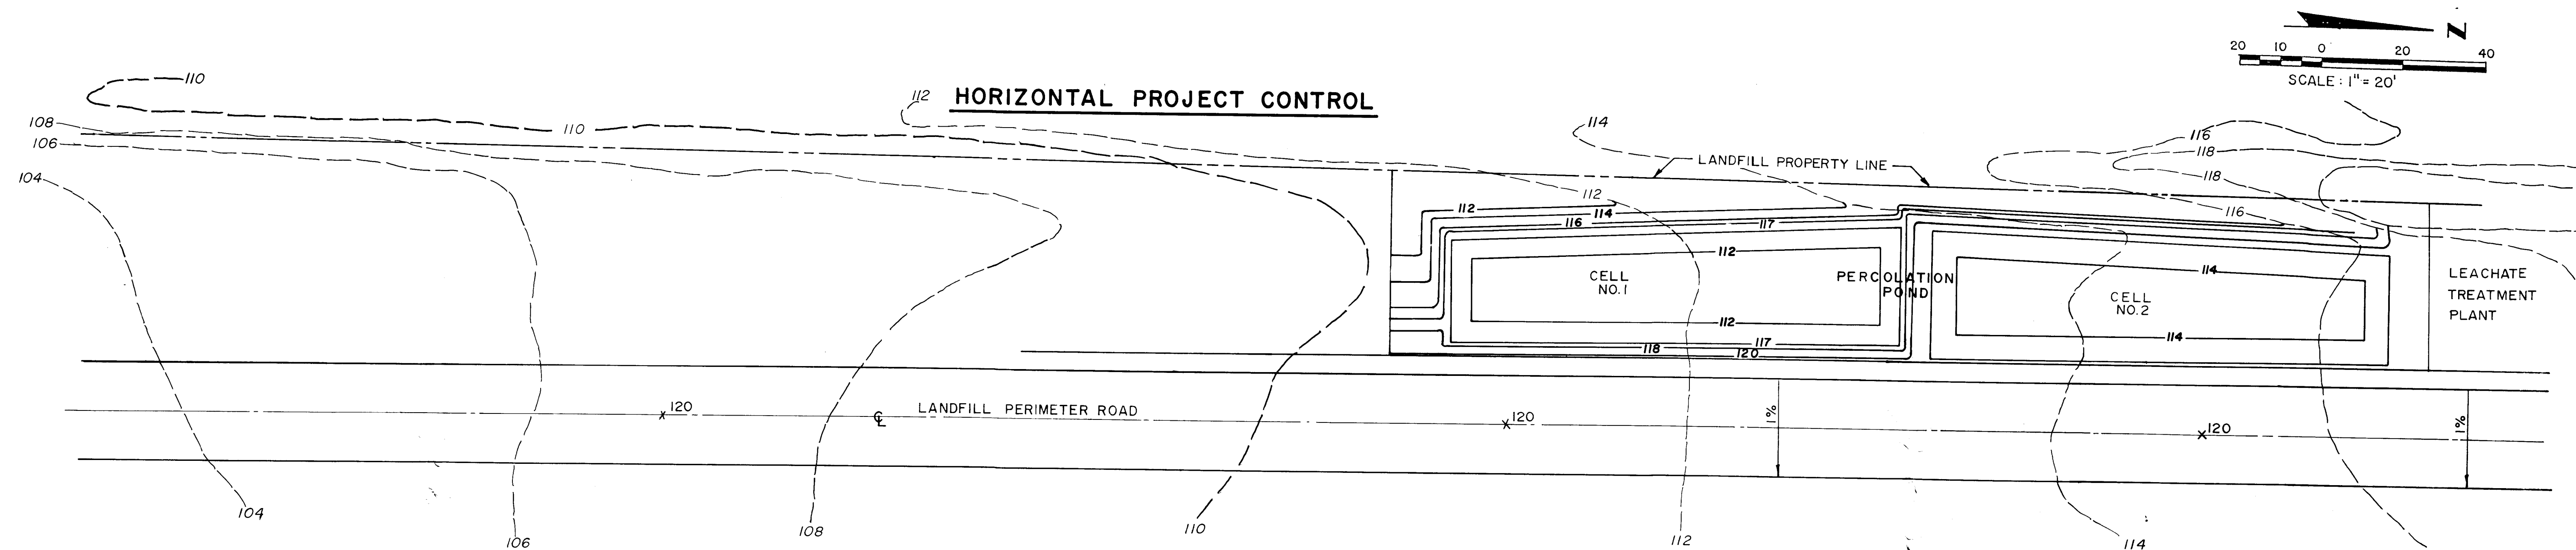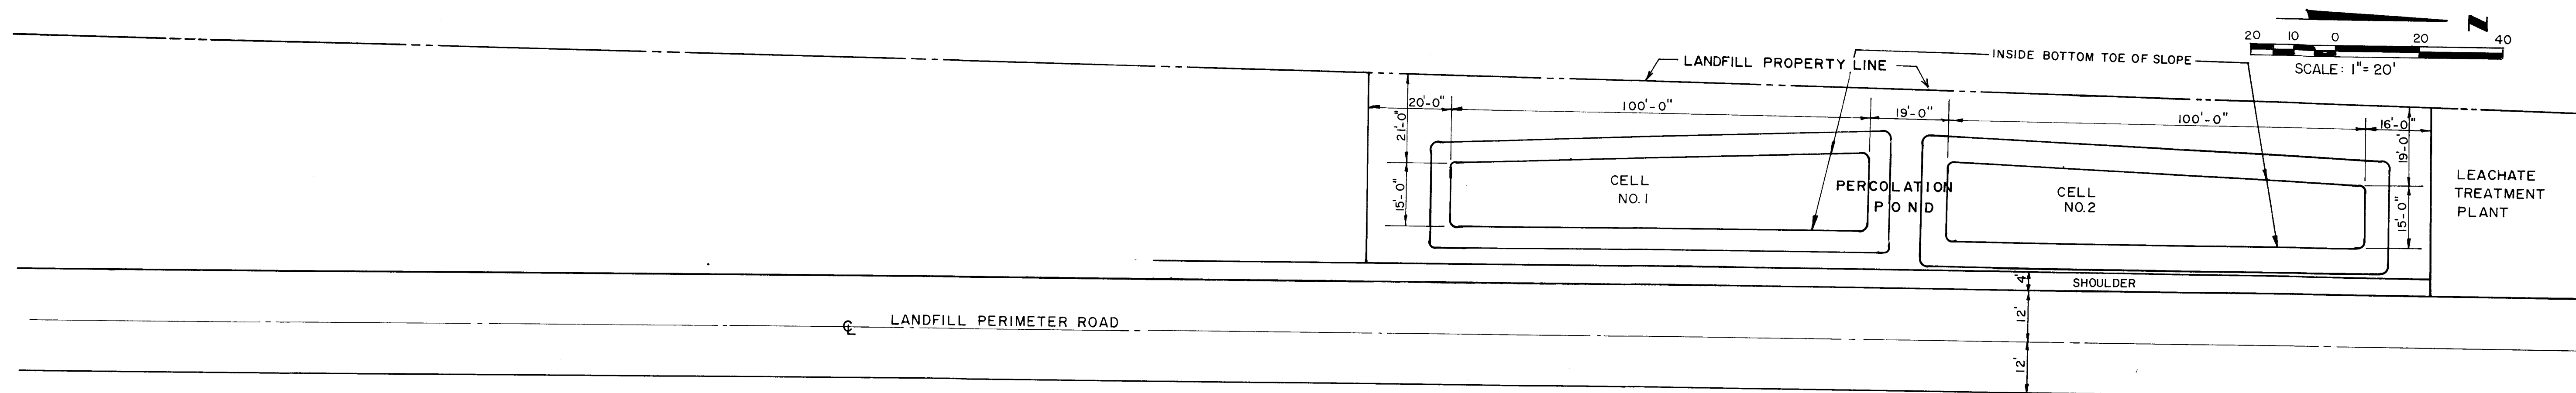

YARD PIPING

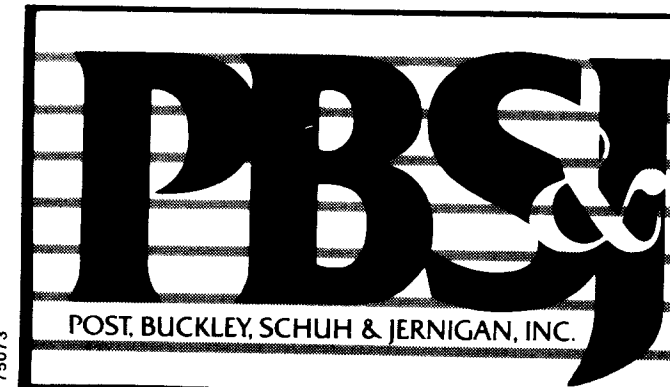

CLIENT

CITRUS COUNTY, FLORIDA
DEPARTMENT OF
TECHNICAL SERVICES

PROJECT

CITRUS COUNTY
CENTRAL LANDFILL EXPANSION
LEACHATE TREATMENT FACILITY

TASK

PERCOLATION POND
SITE PLANS

ORIGINAL AUGUST 1988
REVISIONS:

1
2
3
4
5


6
7
8
9
10
11
12

NOT VALID FOR CONSTRUCTION
UNLESS SIGNED IN THIS BLOCK

JOB NO. 22-08130


DRAWN *R. Kelly*
DESIGNED *R. Kelly*
CHECKED *R. Kelly*
QC

SHEET C-4

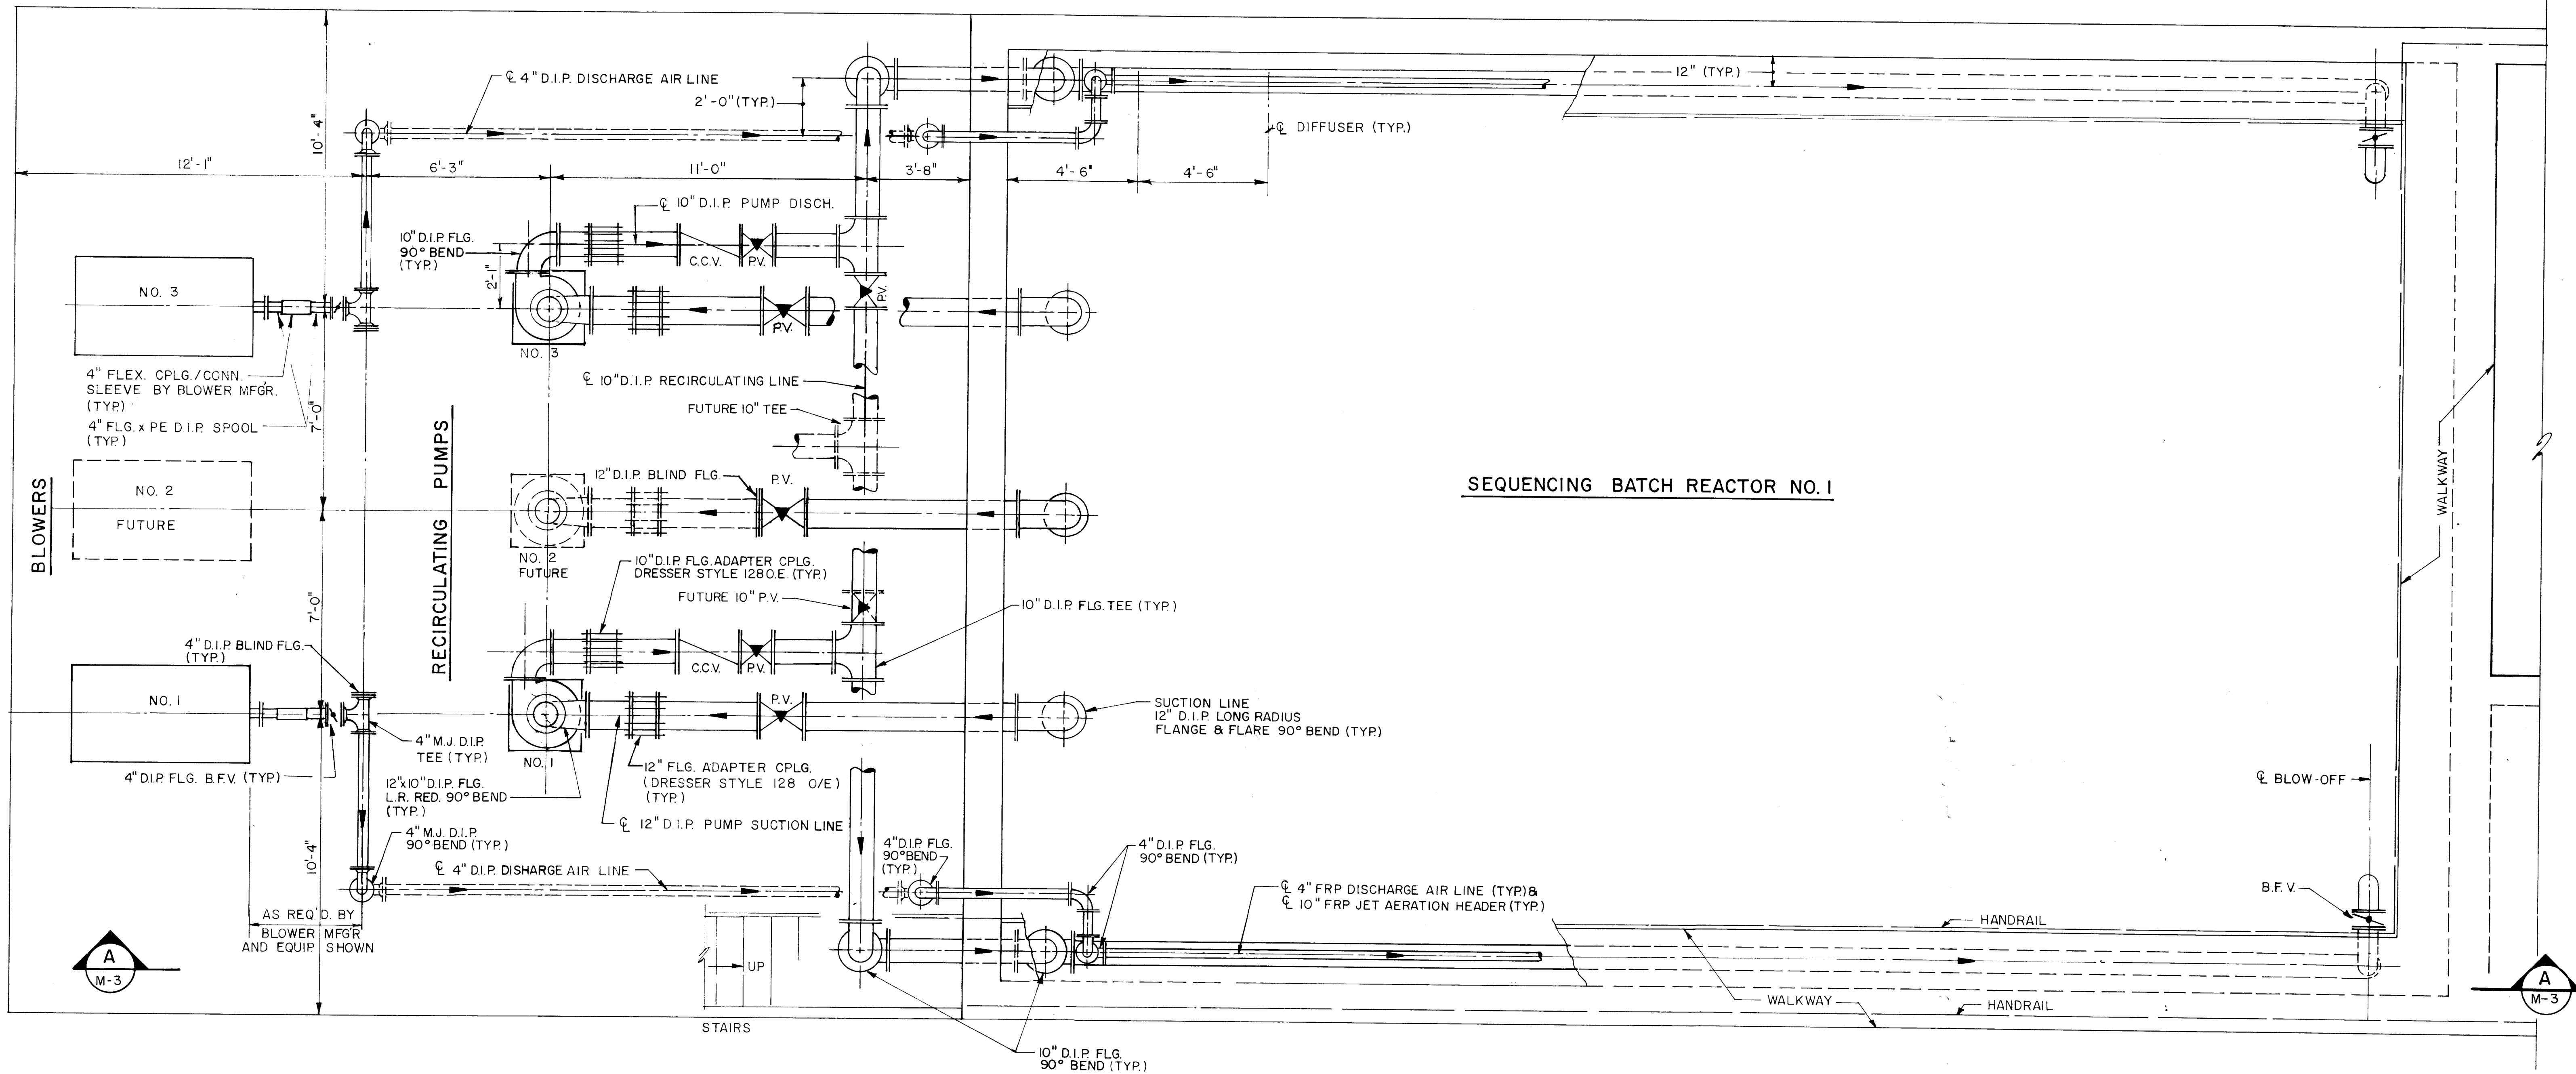

PLAN

NOTE:
1. EQUIPMENT ARRANGEMENT TO BE SIMILAR BUT OPPOSITE FOR SEQUENCING BATCH REACTOR NO. 2.

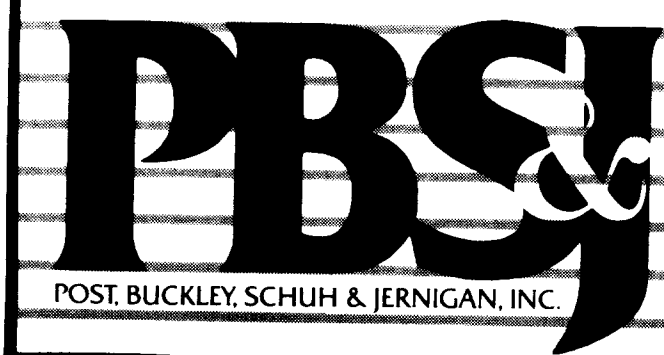

CLIENT
CITRUS COUNTY, FLORIDA
DEPARTMENT OF
TECHNICAL SERVICES

PROJECT
CITRUS COUNTY
CENTRAL LANDFILL EXPANSION
LEACHATE TREATMENT FACILITY


TASK
SEQUENCING BATCH REACTOR

ORIGINAL AUGUST 1988
REVISIONS:
1
2
3
4
5


6
7
8
9
10
11
12

NOT VALID FOR CONSTRUCTION
UNLESS SIGNED IN THIS BLOCK

JOB NO. 22-081.37
DRAWN *R. Kelly*
DESIGNED *D. Kelly*
CHECKED *D. Kelly*
QC
SHEET M-1

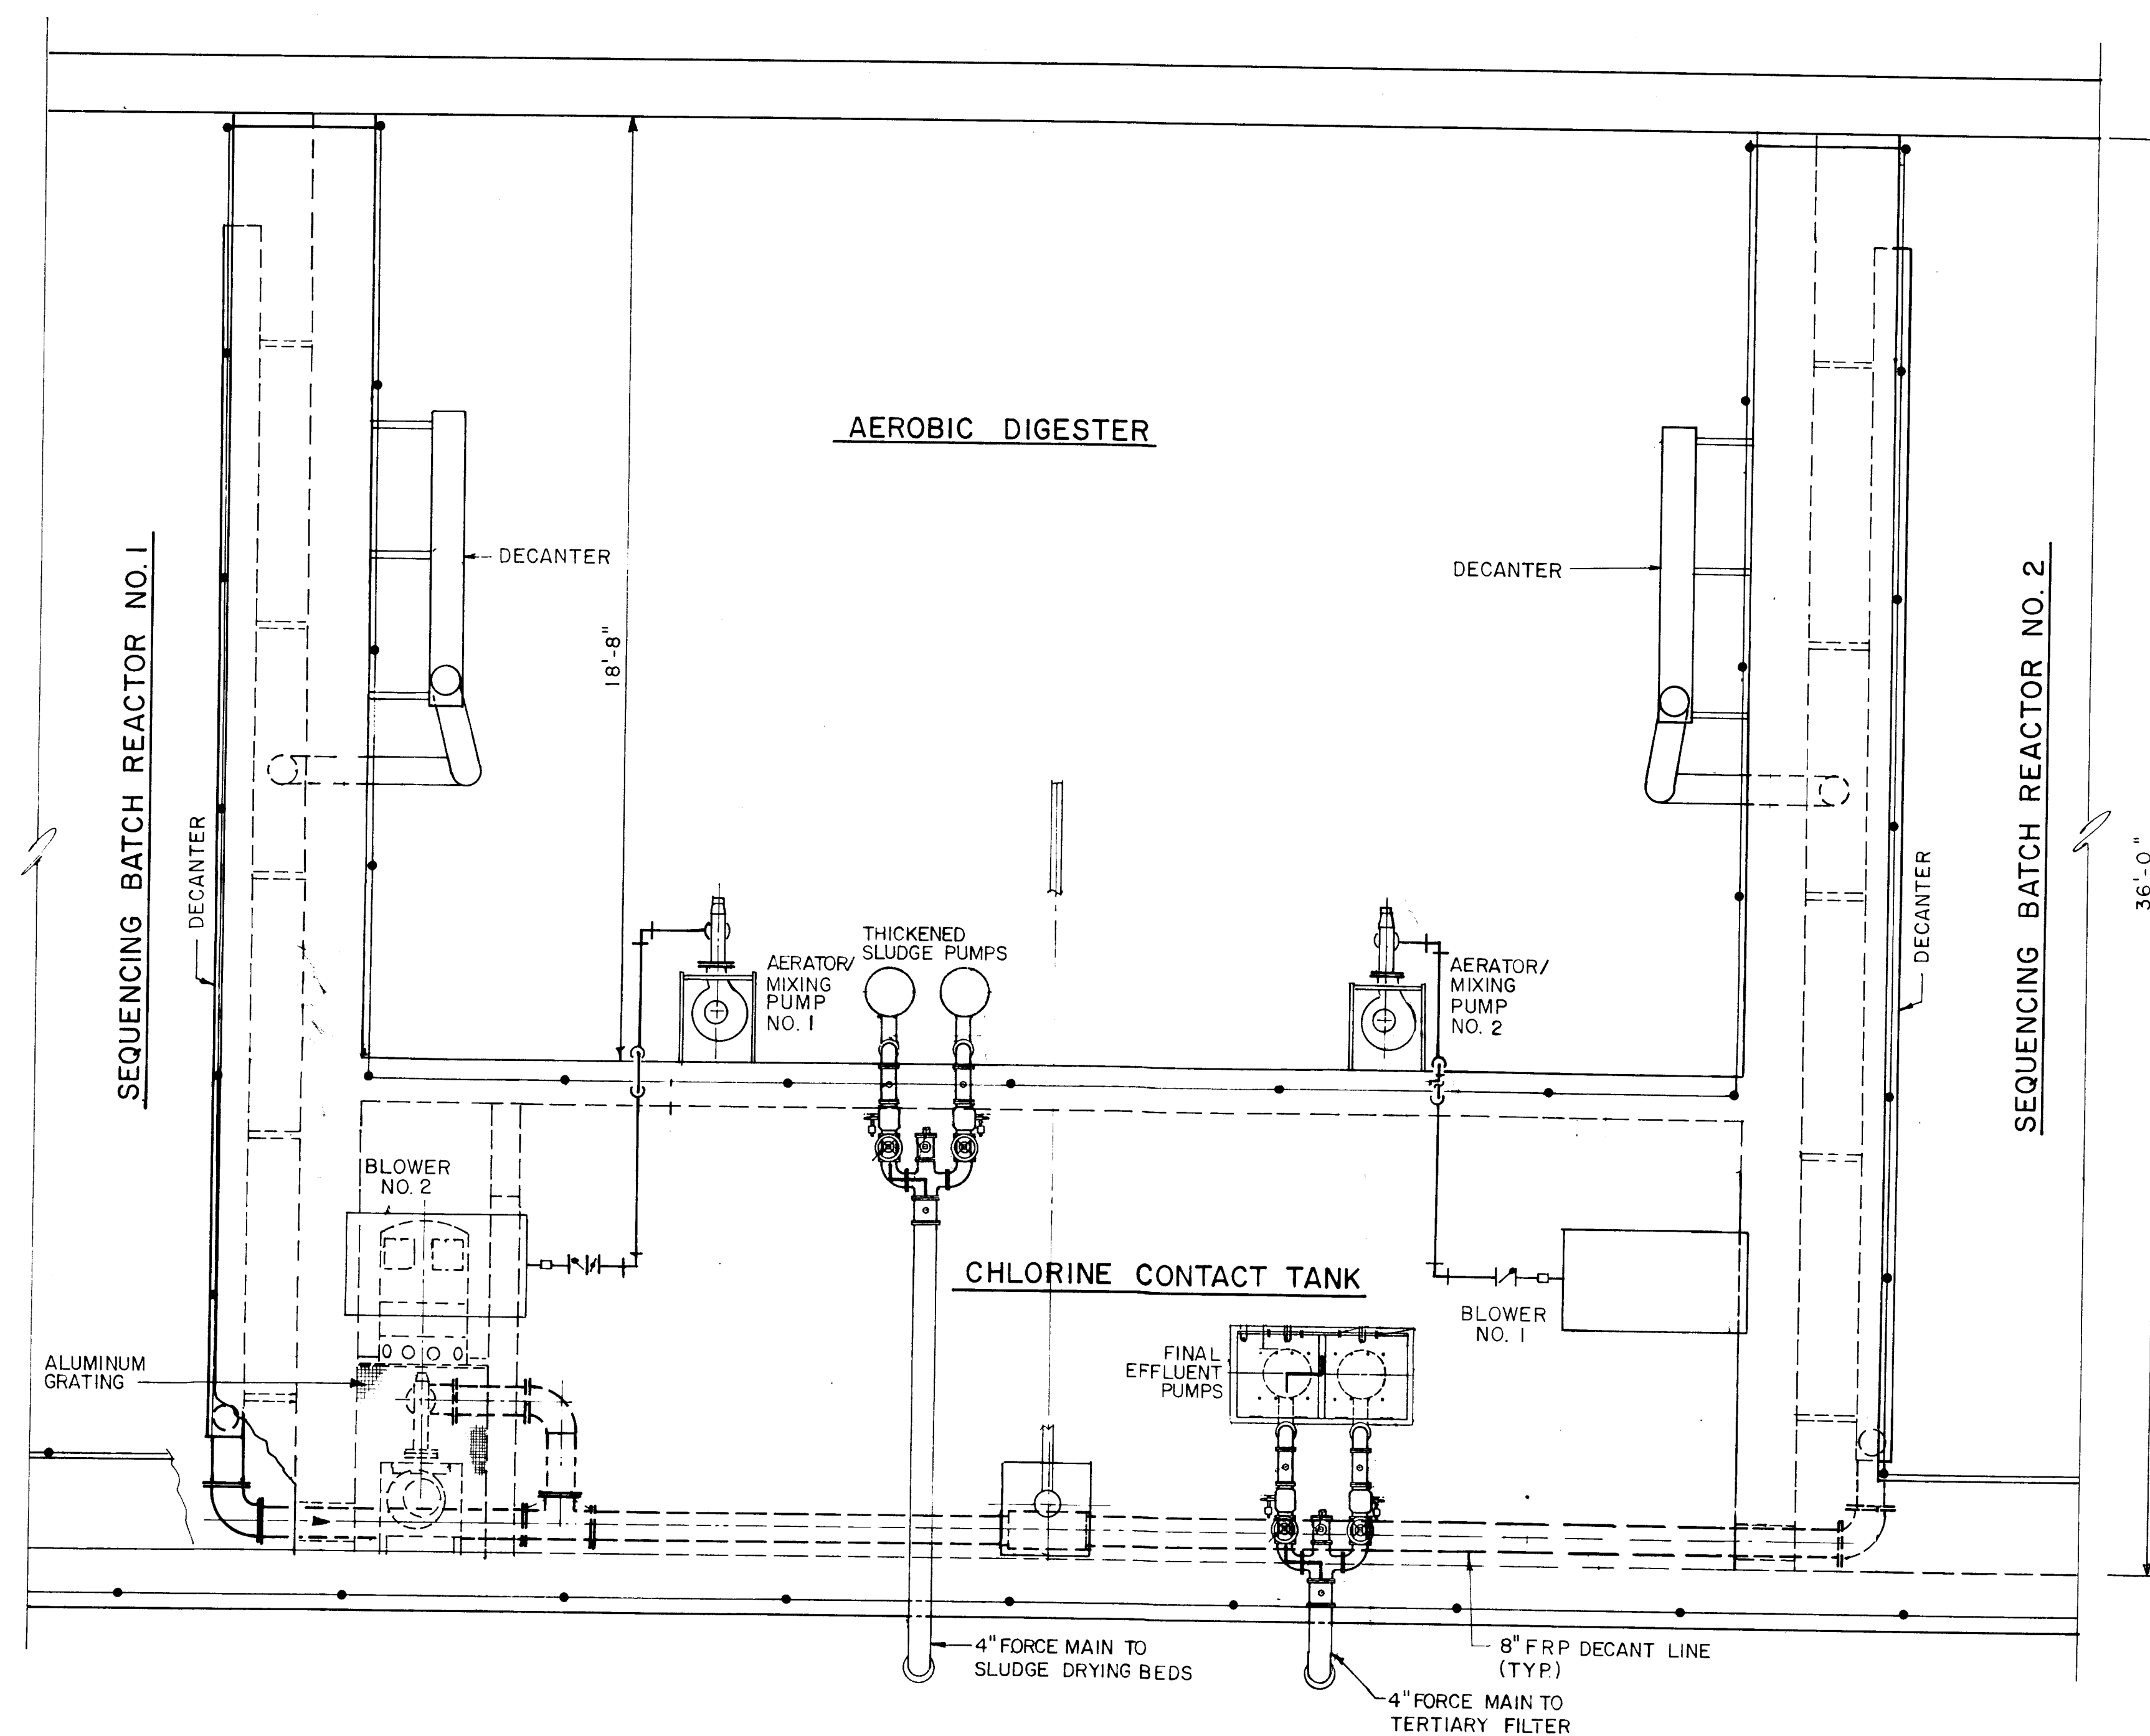


PLAN

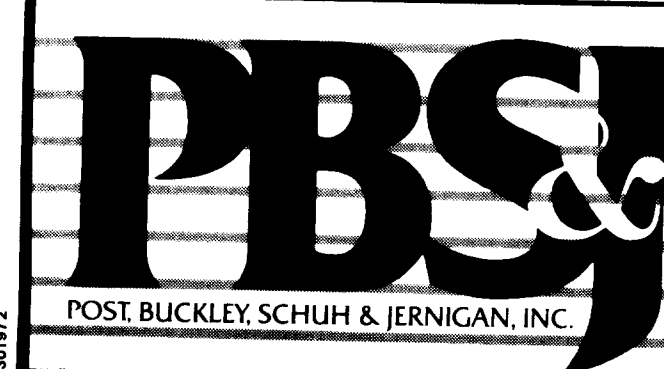

CLIENT	PROJECT	TASK	ORIGINAL AUGUST 1988	6	JOB NO. 22-081.30
CITRUS COUNTY, FLORIDA	CITRUS COUNTY	AEROBIC DIGESTOR	REVISIONS:	7	DRAWN <i>D. Dwyer</i>
DEPARTMENT OF	CENTRAL LANDFILL EXPANSION	AND CHLORINE TANK	1	8	DESIGNED <i>D. Dwyer</i>
TECHNICAL SERVICES	LEACHATE TREATMENT FACILITY		2	9	CHECKED <i>D. Dwyer</i>
			3	10	QC
			4	11	
			5	12	


NOT VALID FOR CONSTRUCTION
UNLESS SIGNED IN THIS BLOCK

SHEET M-2

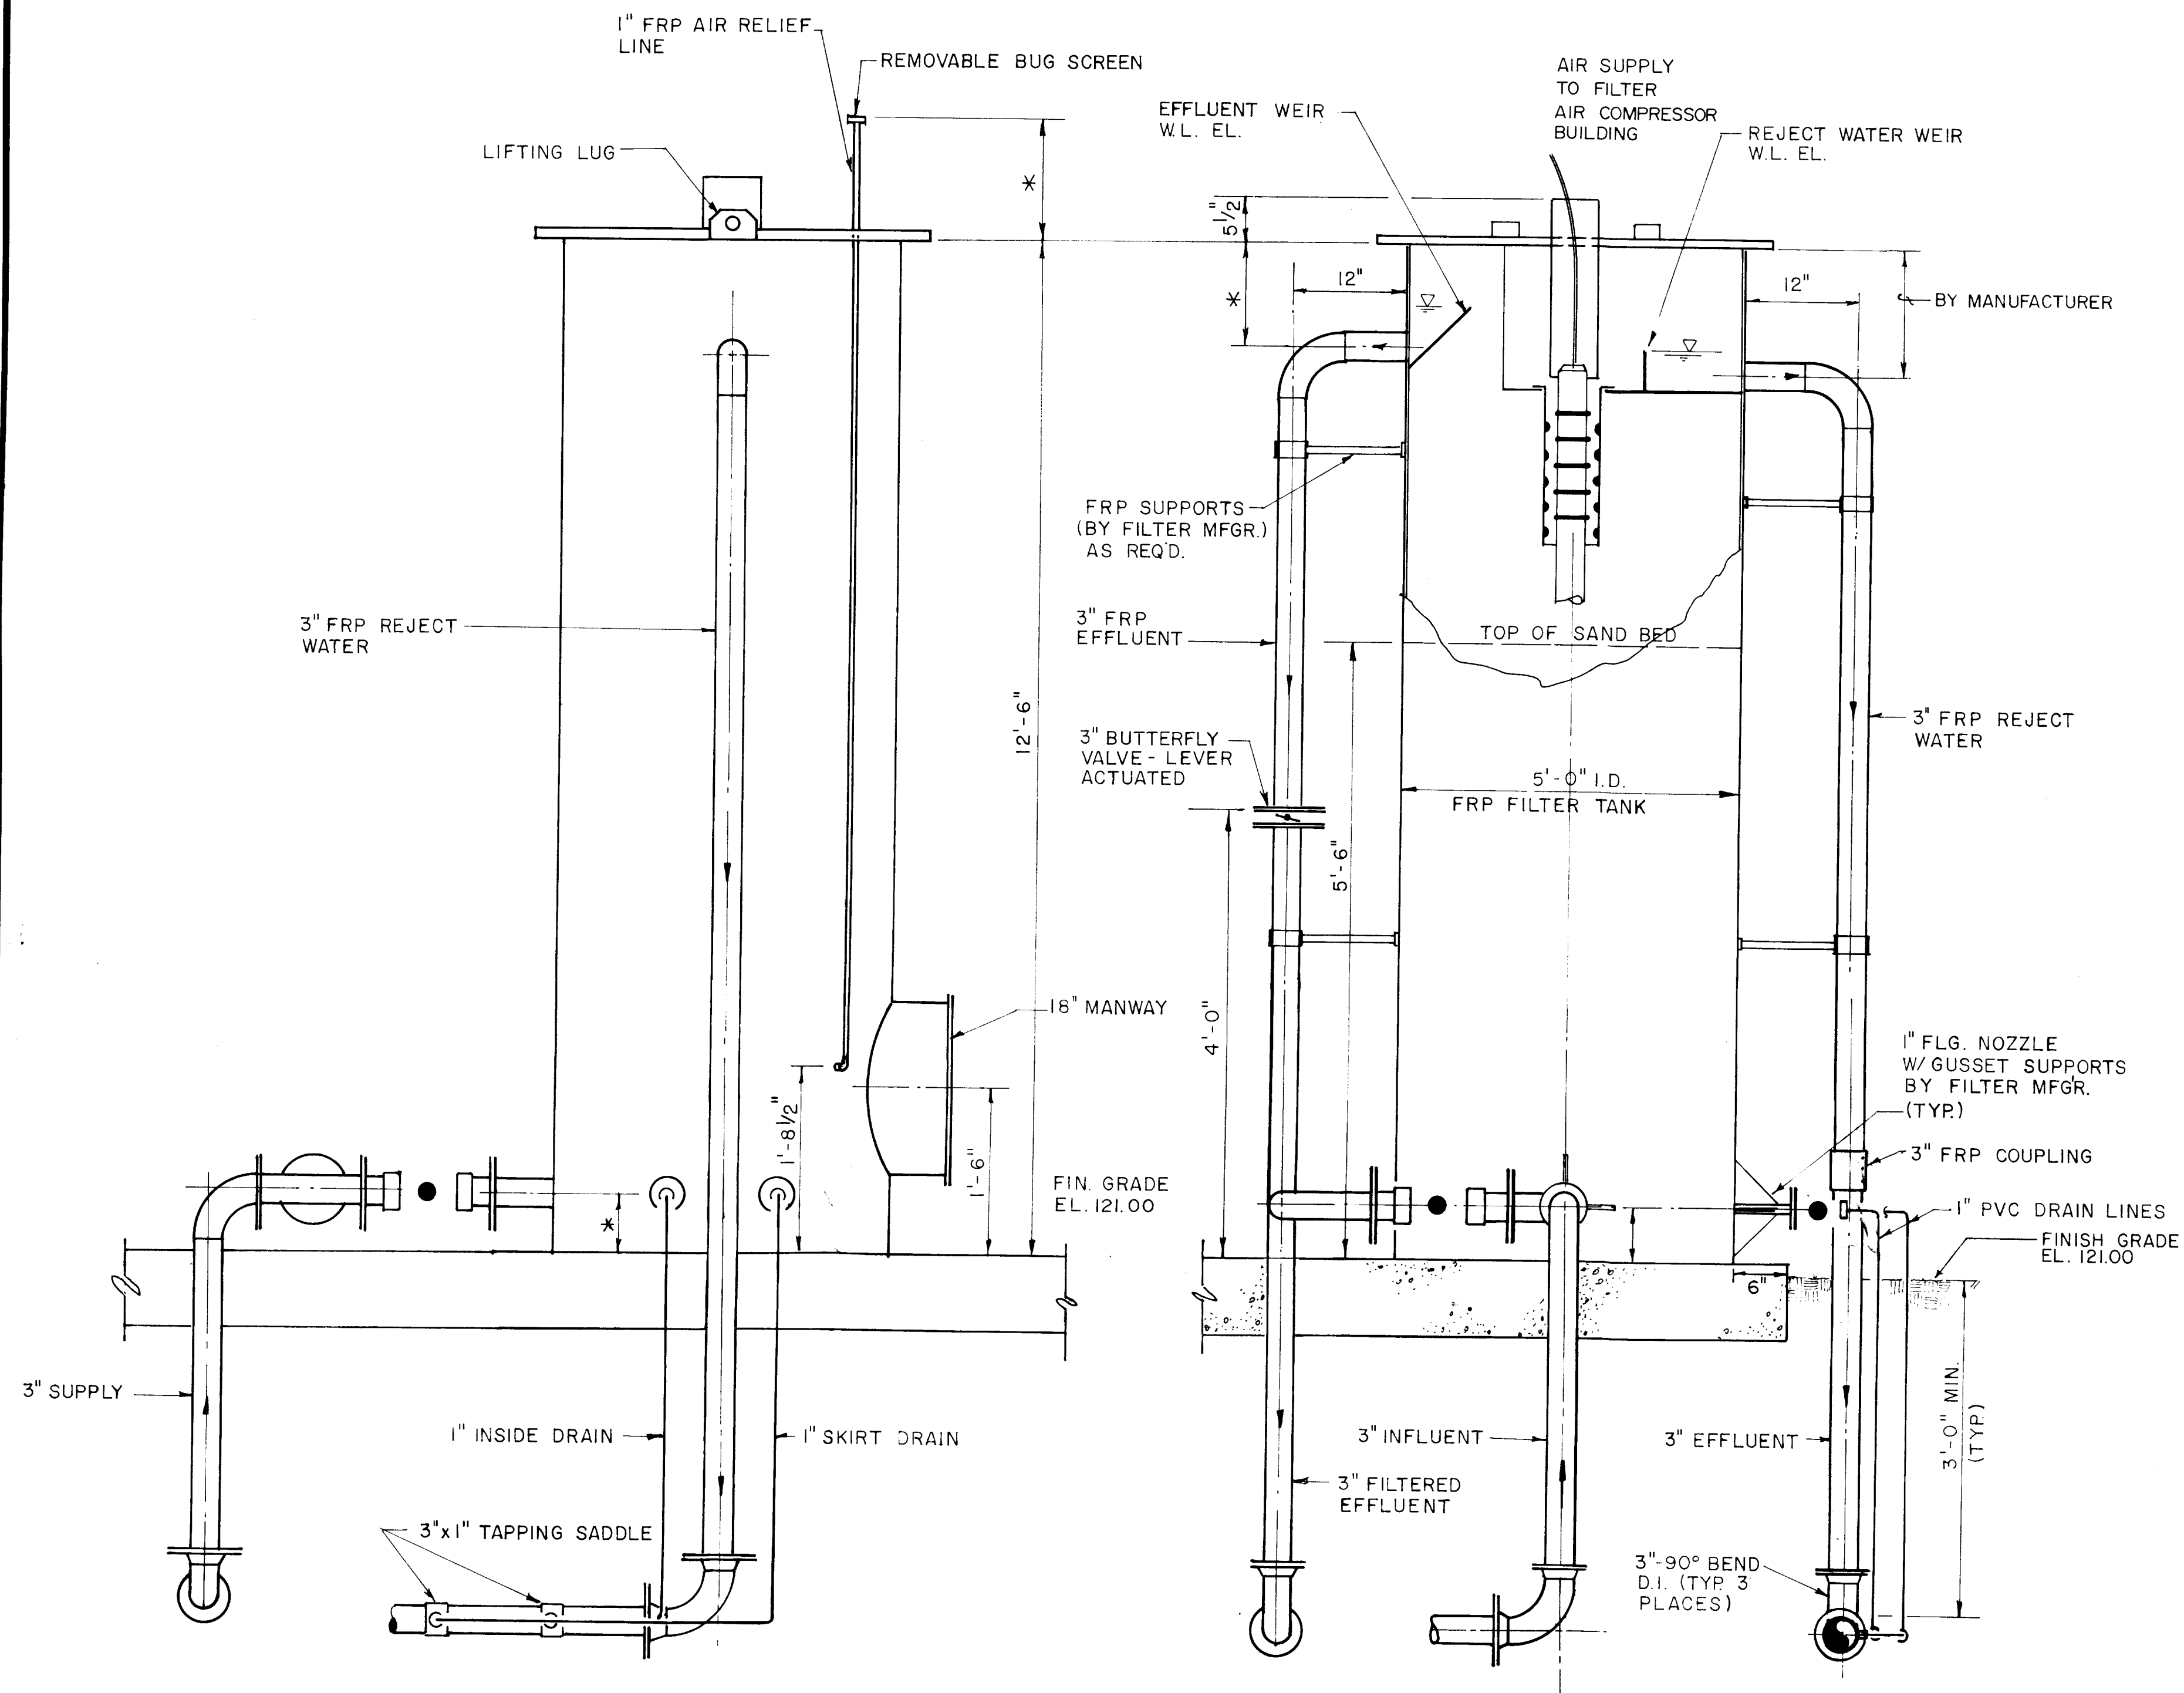


SECTION A
SCALE: 1" = 1'-0" M-4

SECTION B
SCALE: 1" = 1'-0" M-4

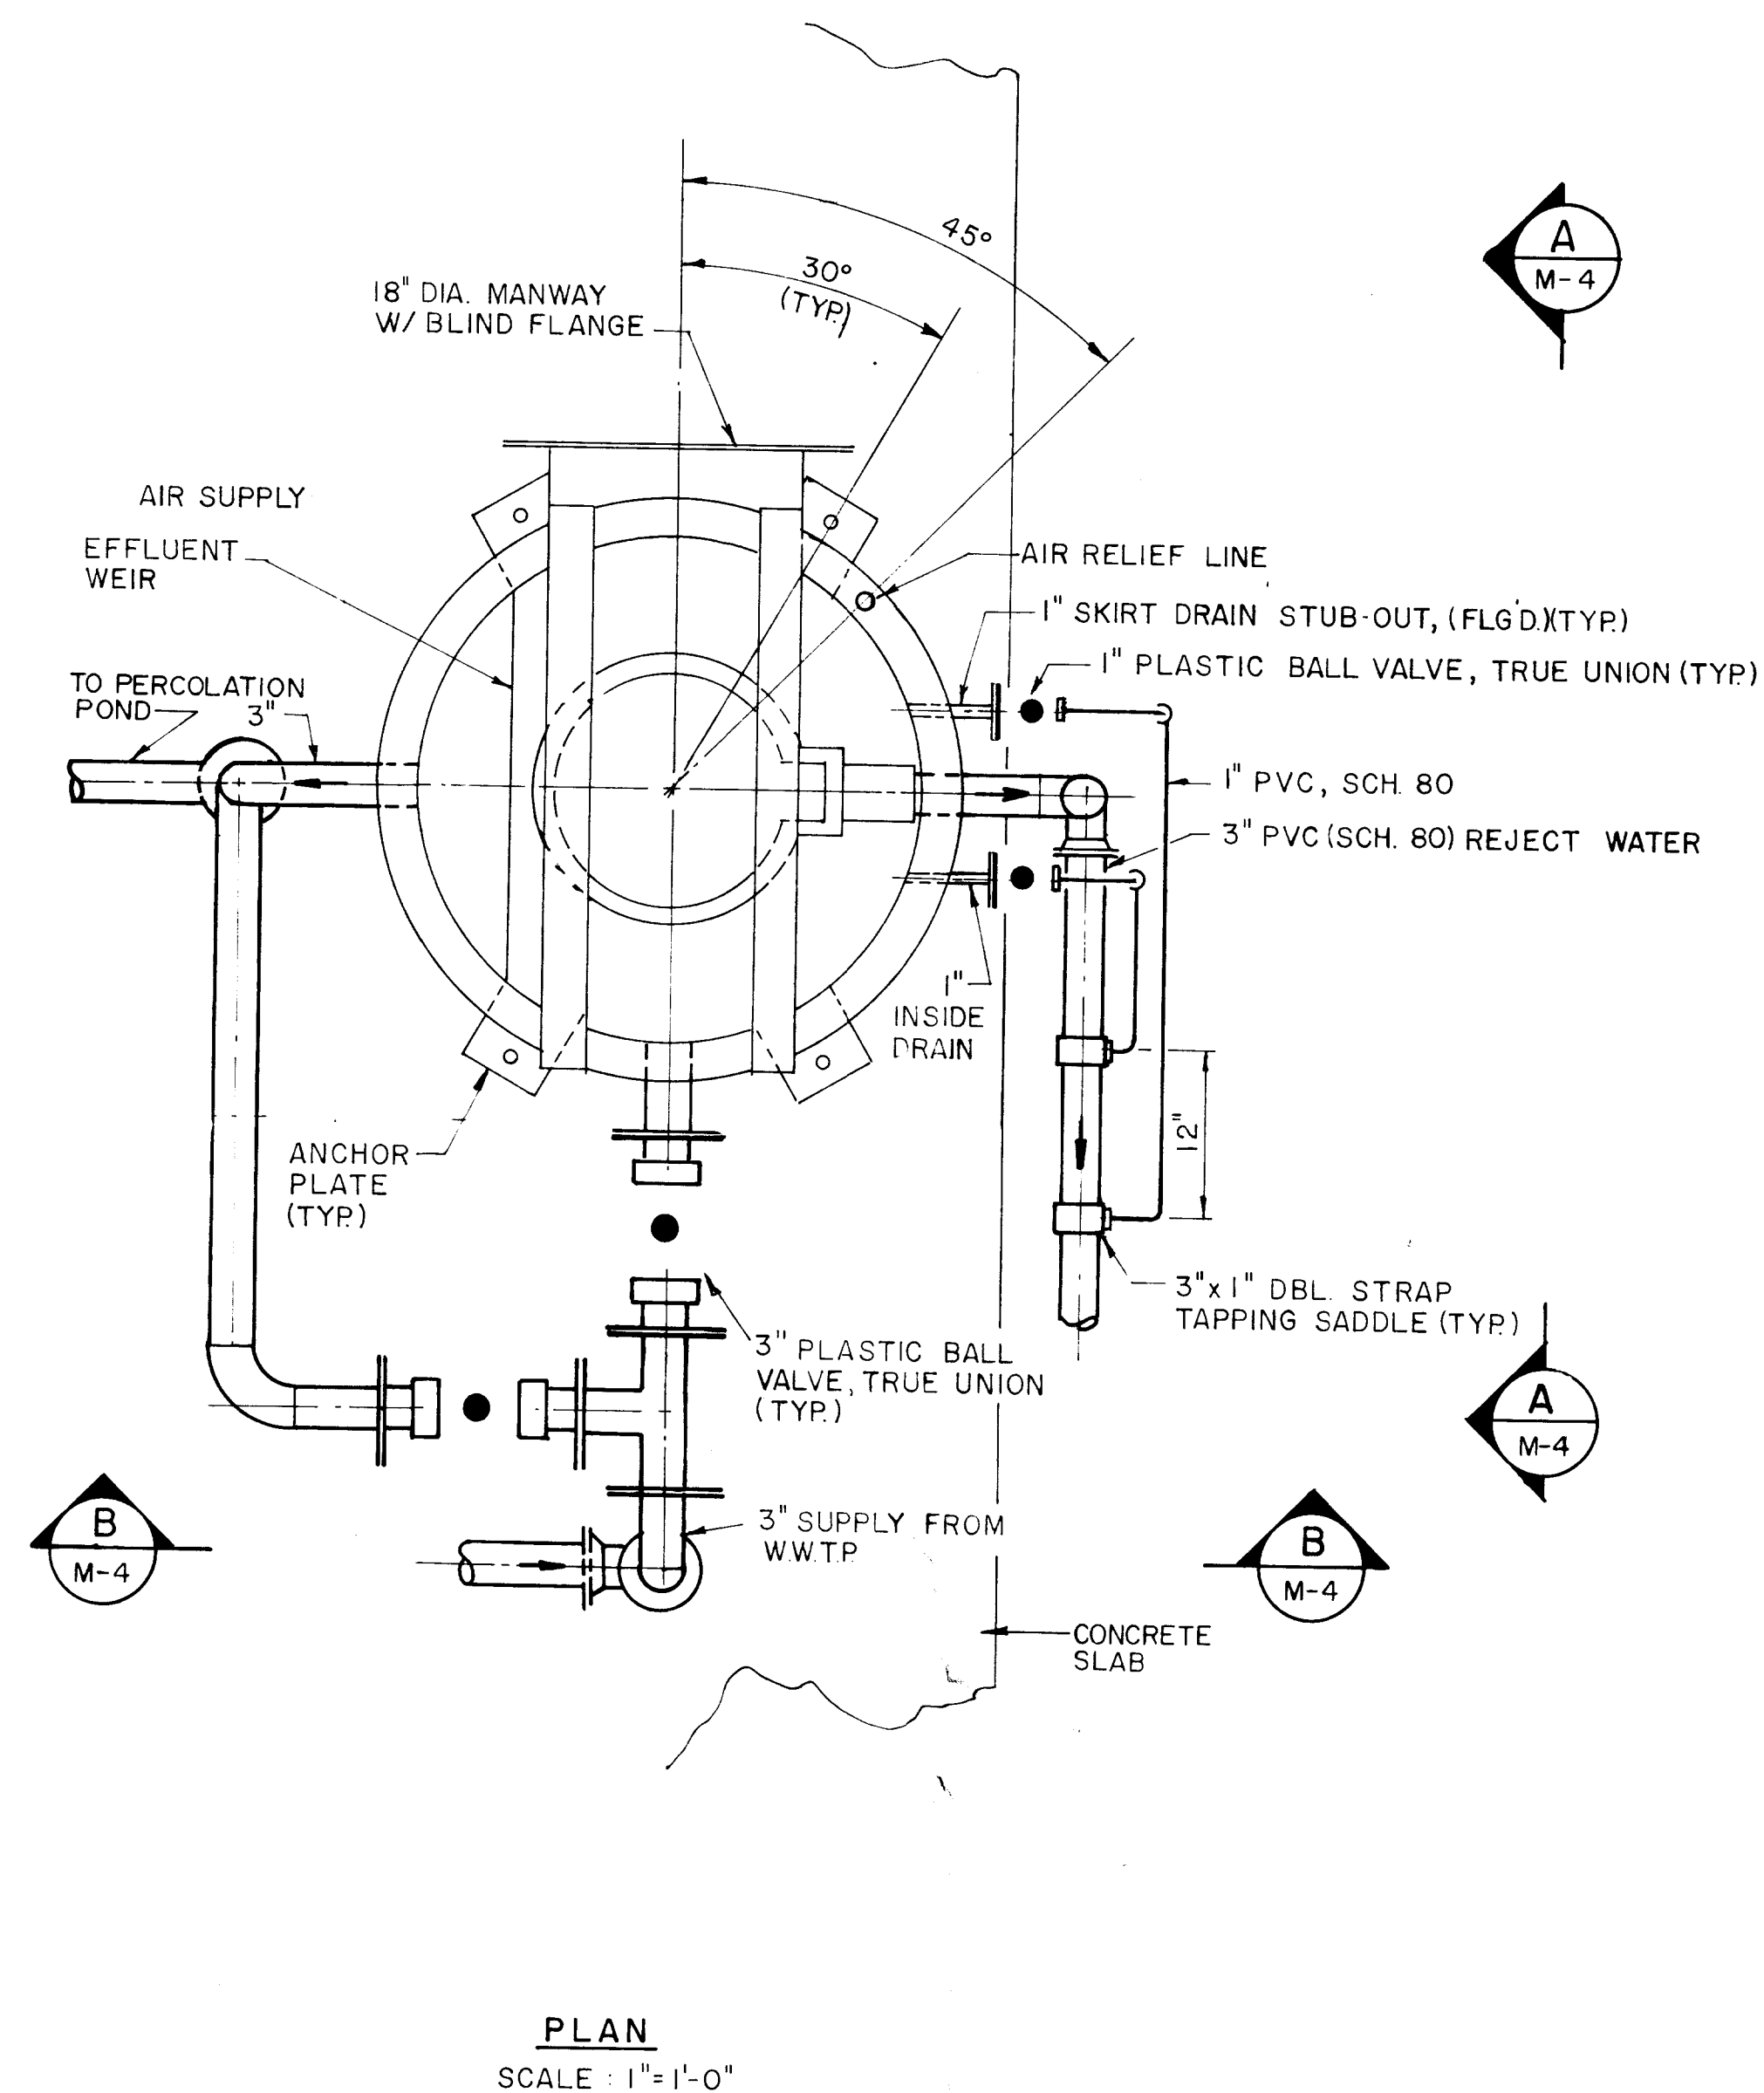

PLAN
SCALE: 1" = 1'-0"

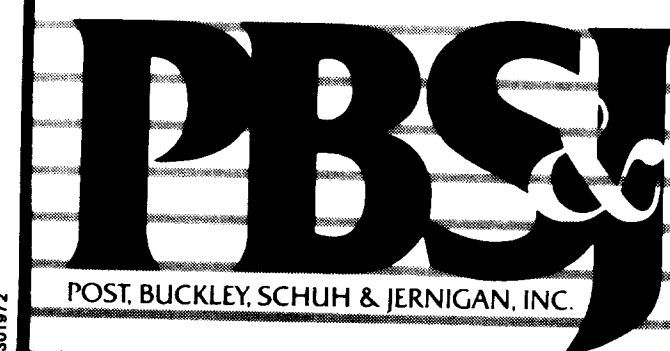

CLIENT
CITRUS COUNTY, FLORIDA
DEPARTMENT OF
TECHNICAL SERVICES

PROJECT
CITRUS COUNTY
CENTRAL LANDFILL EXPANSION
LEACHATE TREATMENT FACILITY





TASK
EFFLUENT FILTER
PLAN AND ELEVATIONS

ORIGINAL AUGUST 1988
REVISIONS:
1 _____
2 _____
3 _____
4 _____
5 _____

6 _____
7 _____
8 _____
9 _____
10 _____
11 _____
12 _____

NOT VALID FOR CONSTRUCTION
UNLESS SIGNED IN THIS BLOCK

JOB NO. 22-081.30
DRAWN *Drady*
DESIGNED *Drady*
CHECKED *Drady*
QC _____
SHEET M-4

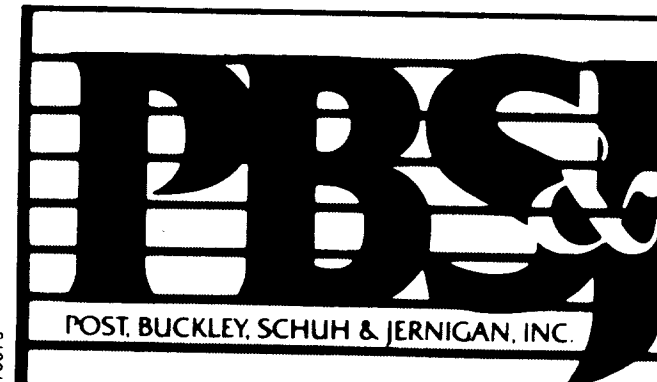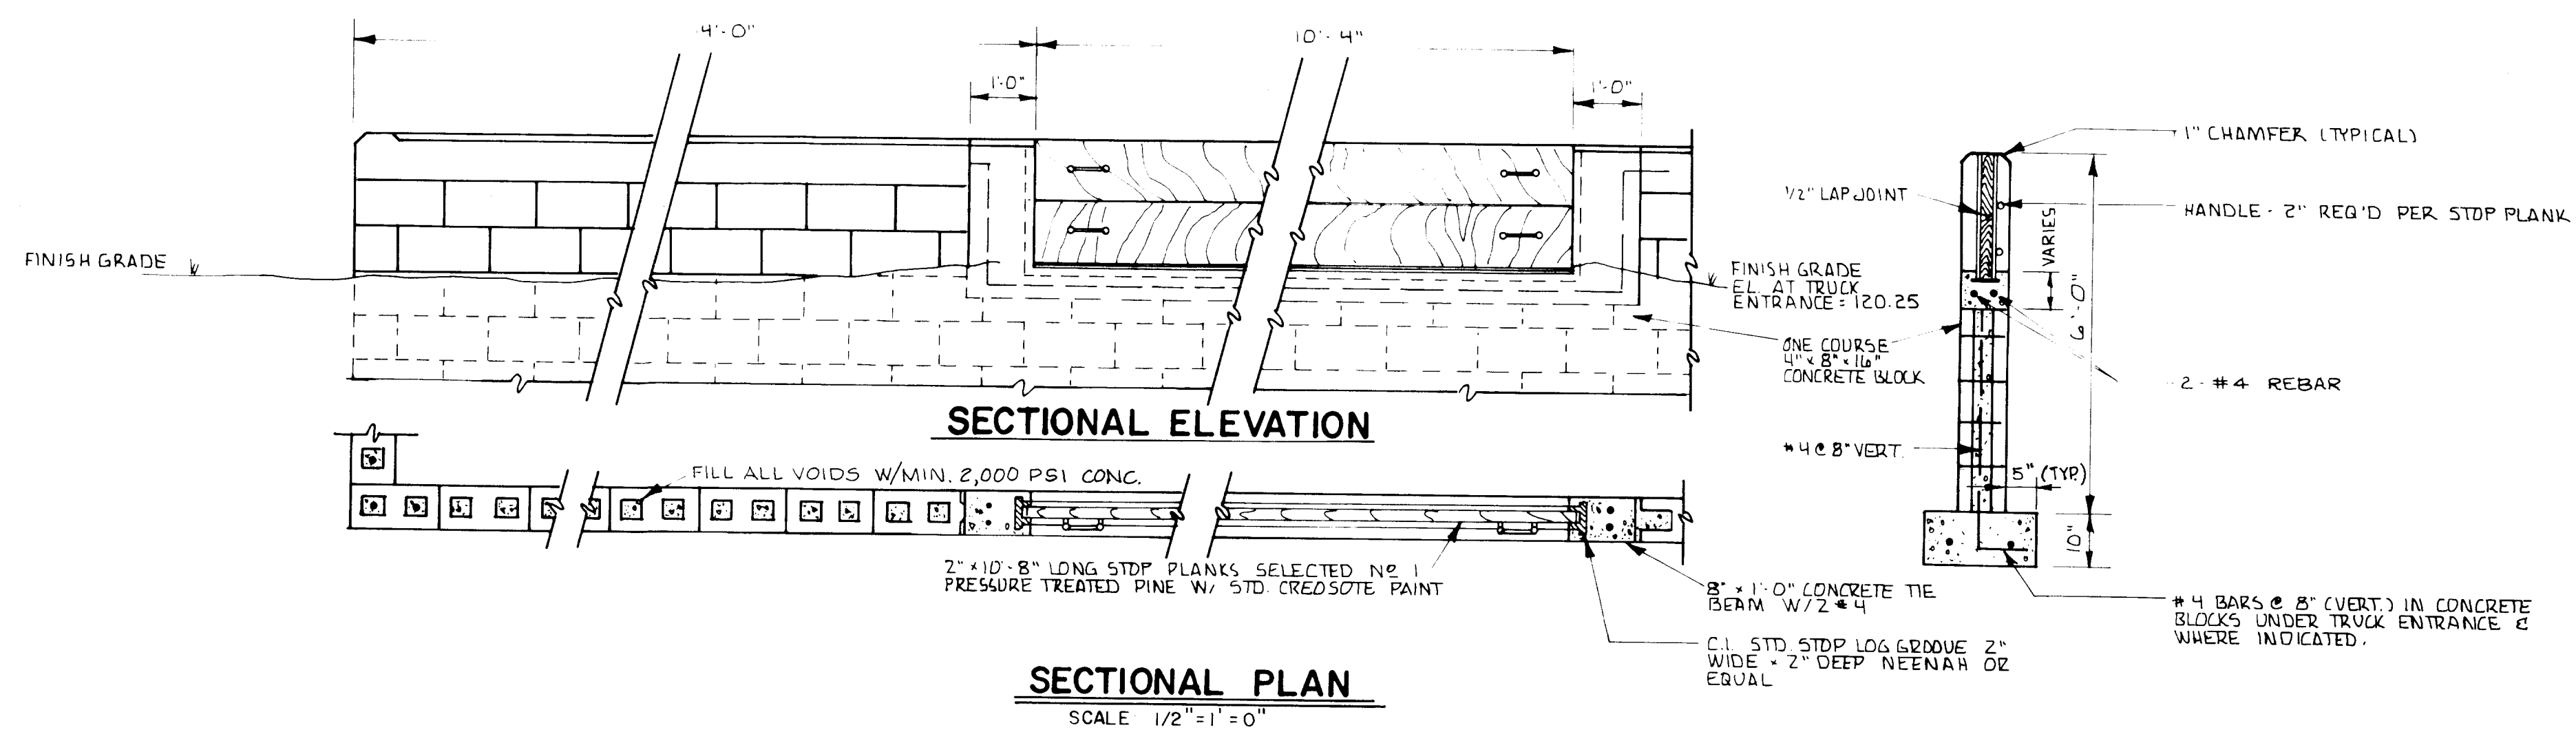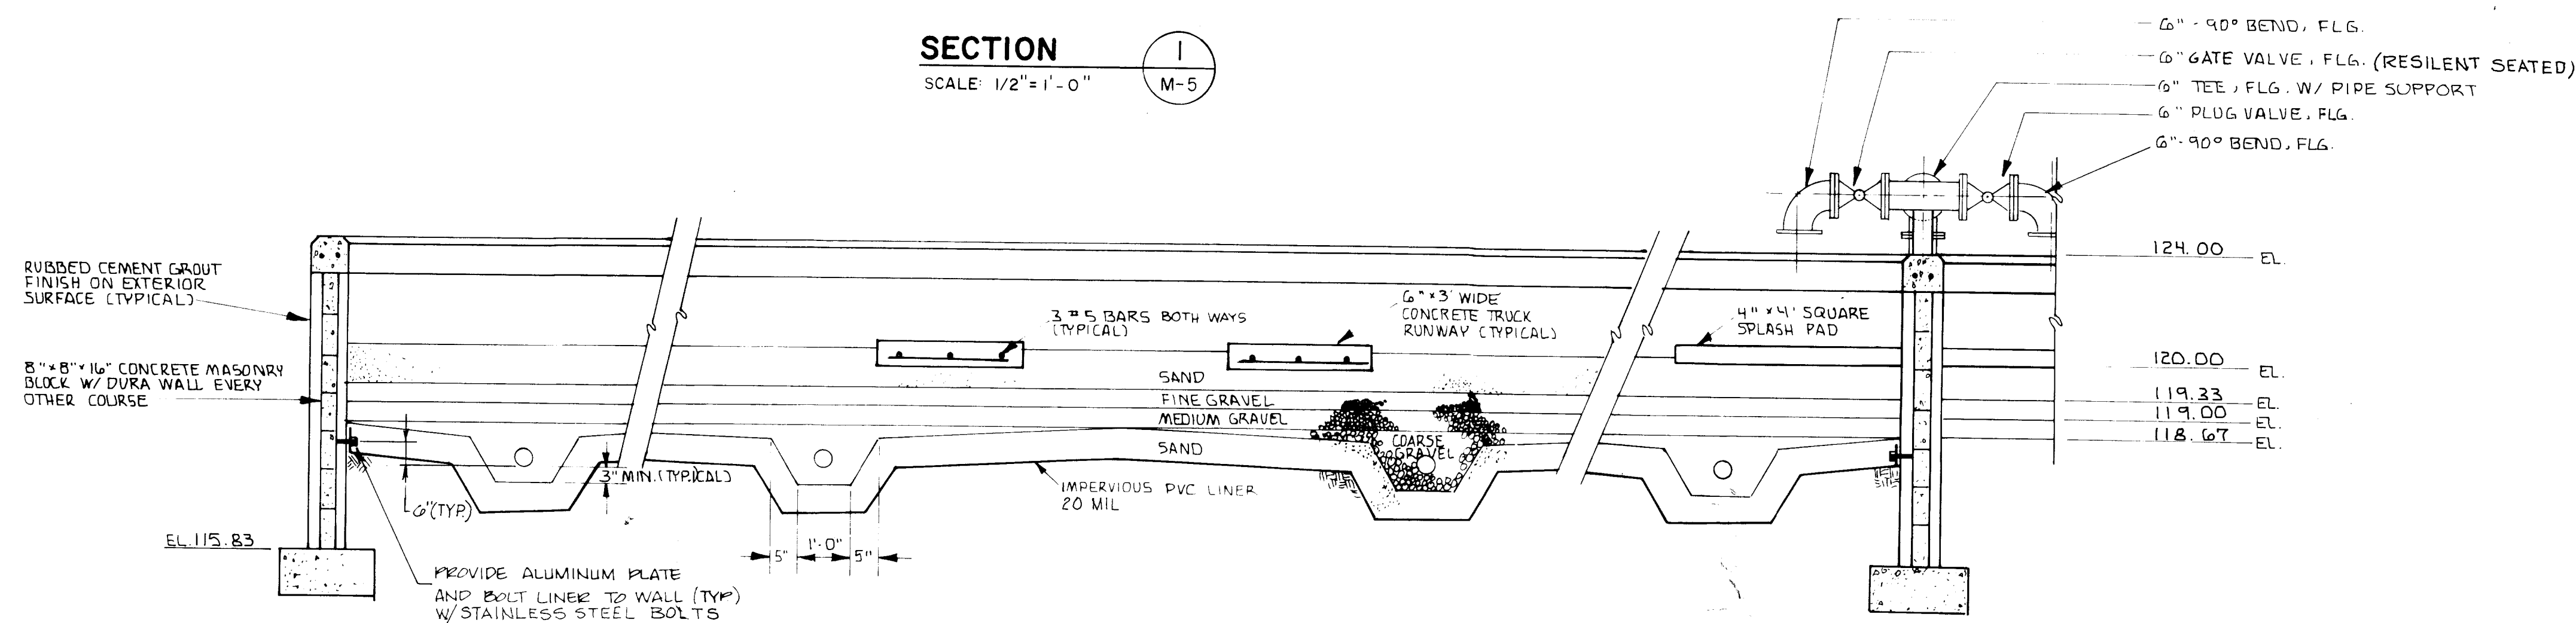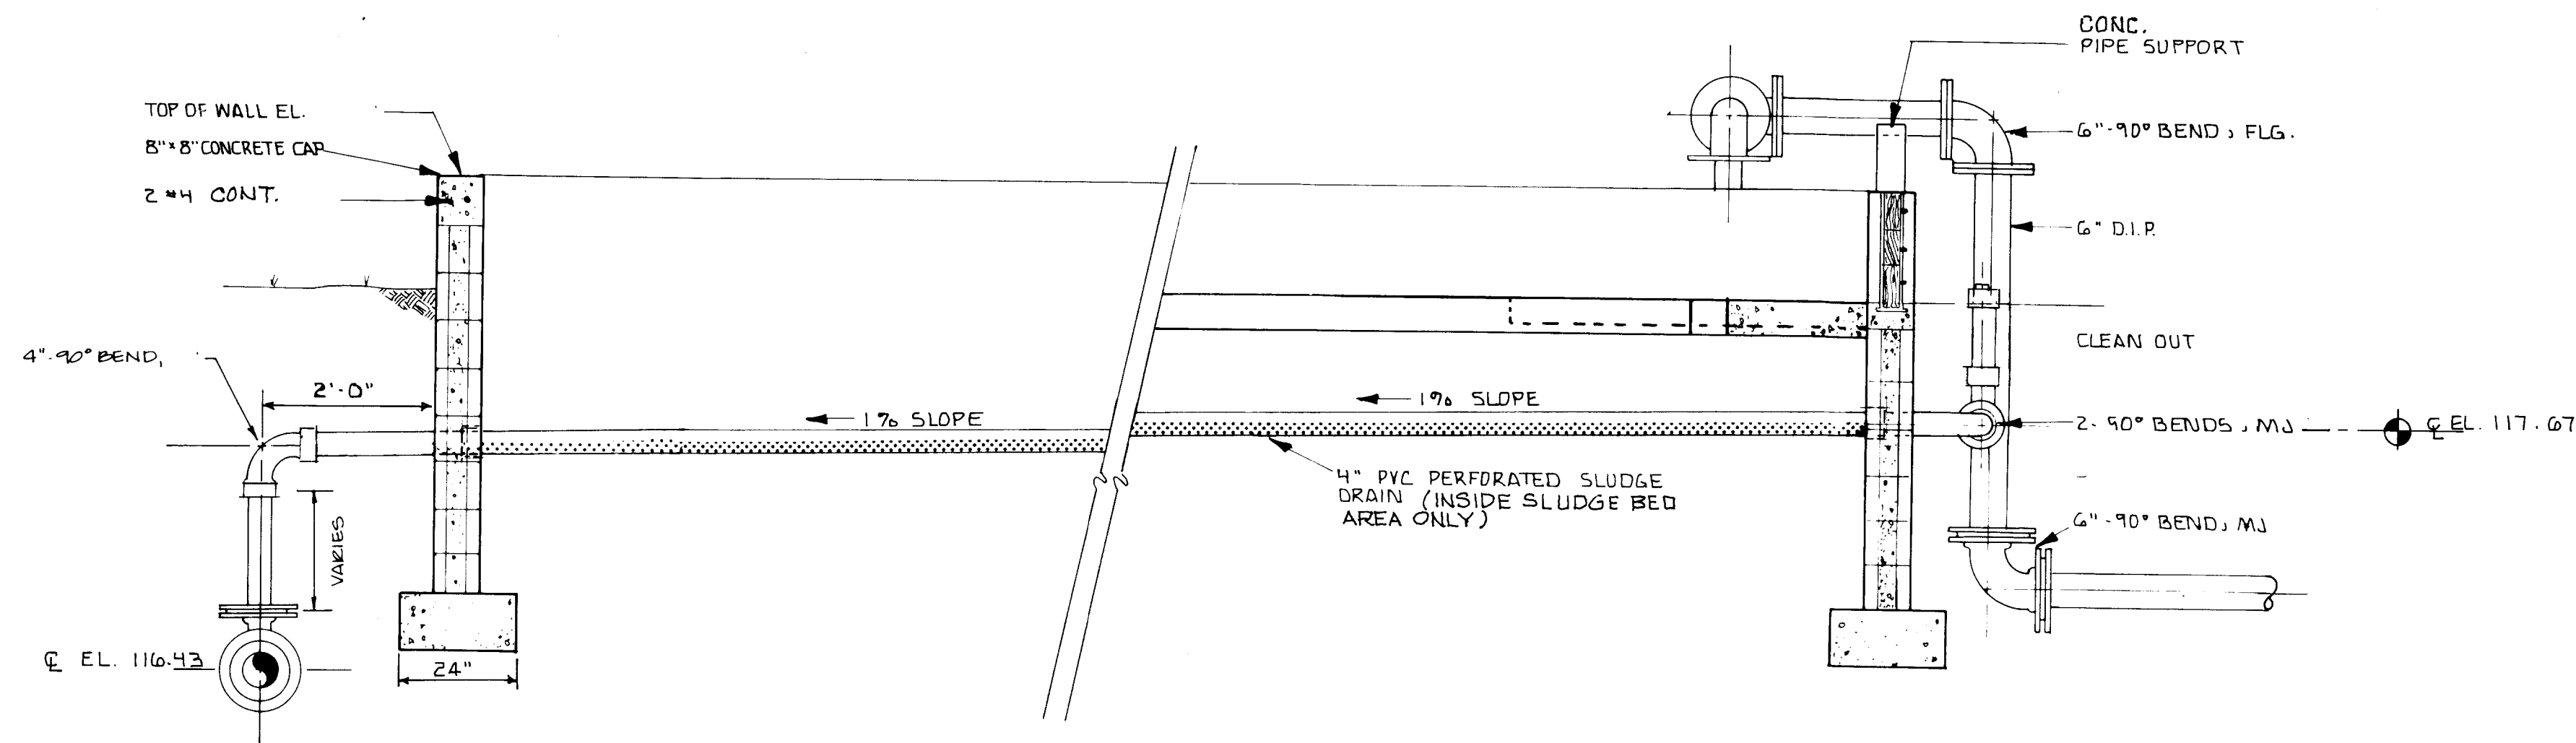

CLIENT
CITRUS COUNTY, FLORIDA
DEPARTMENT OF
TECHNICAL SERVICES

PROJECT
CITRUS COUNTY
CENTRAL LANDFILL EXPANSION
LEACHATE TREATMENT FACILITY

TASK
SLUDGE DRYING BED - SECTIONS

ORIGINAL: AUGUST 1988
REVISIONS:
1
2
3
4
5

6
7
8
9
10
11
12



NOT VALID FOR CONSTRUCTION
UNLESS SIGNED IN THIS BLOCK


JOB NO. 22-081.30
DRAWN: K. Strain
DESIGNED: JAV
CHECKED: JAV
QC: DAW

SHEET M-6




F.D.O.T. PRECAST DITCH BOTTOM INLET
TYPE 'H' MODIFIED
(INDEX NO. 232)

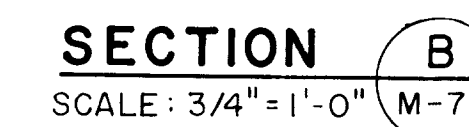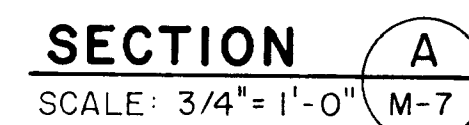

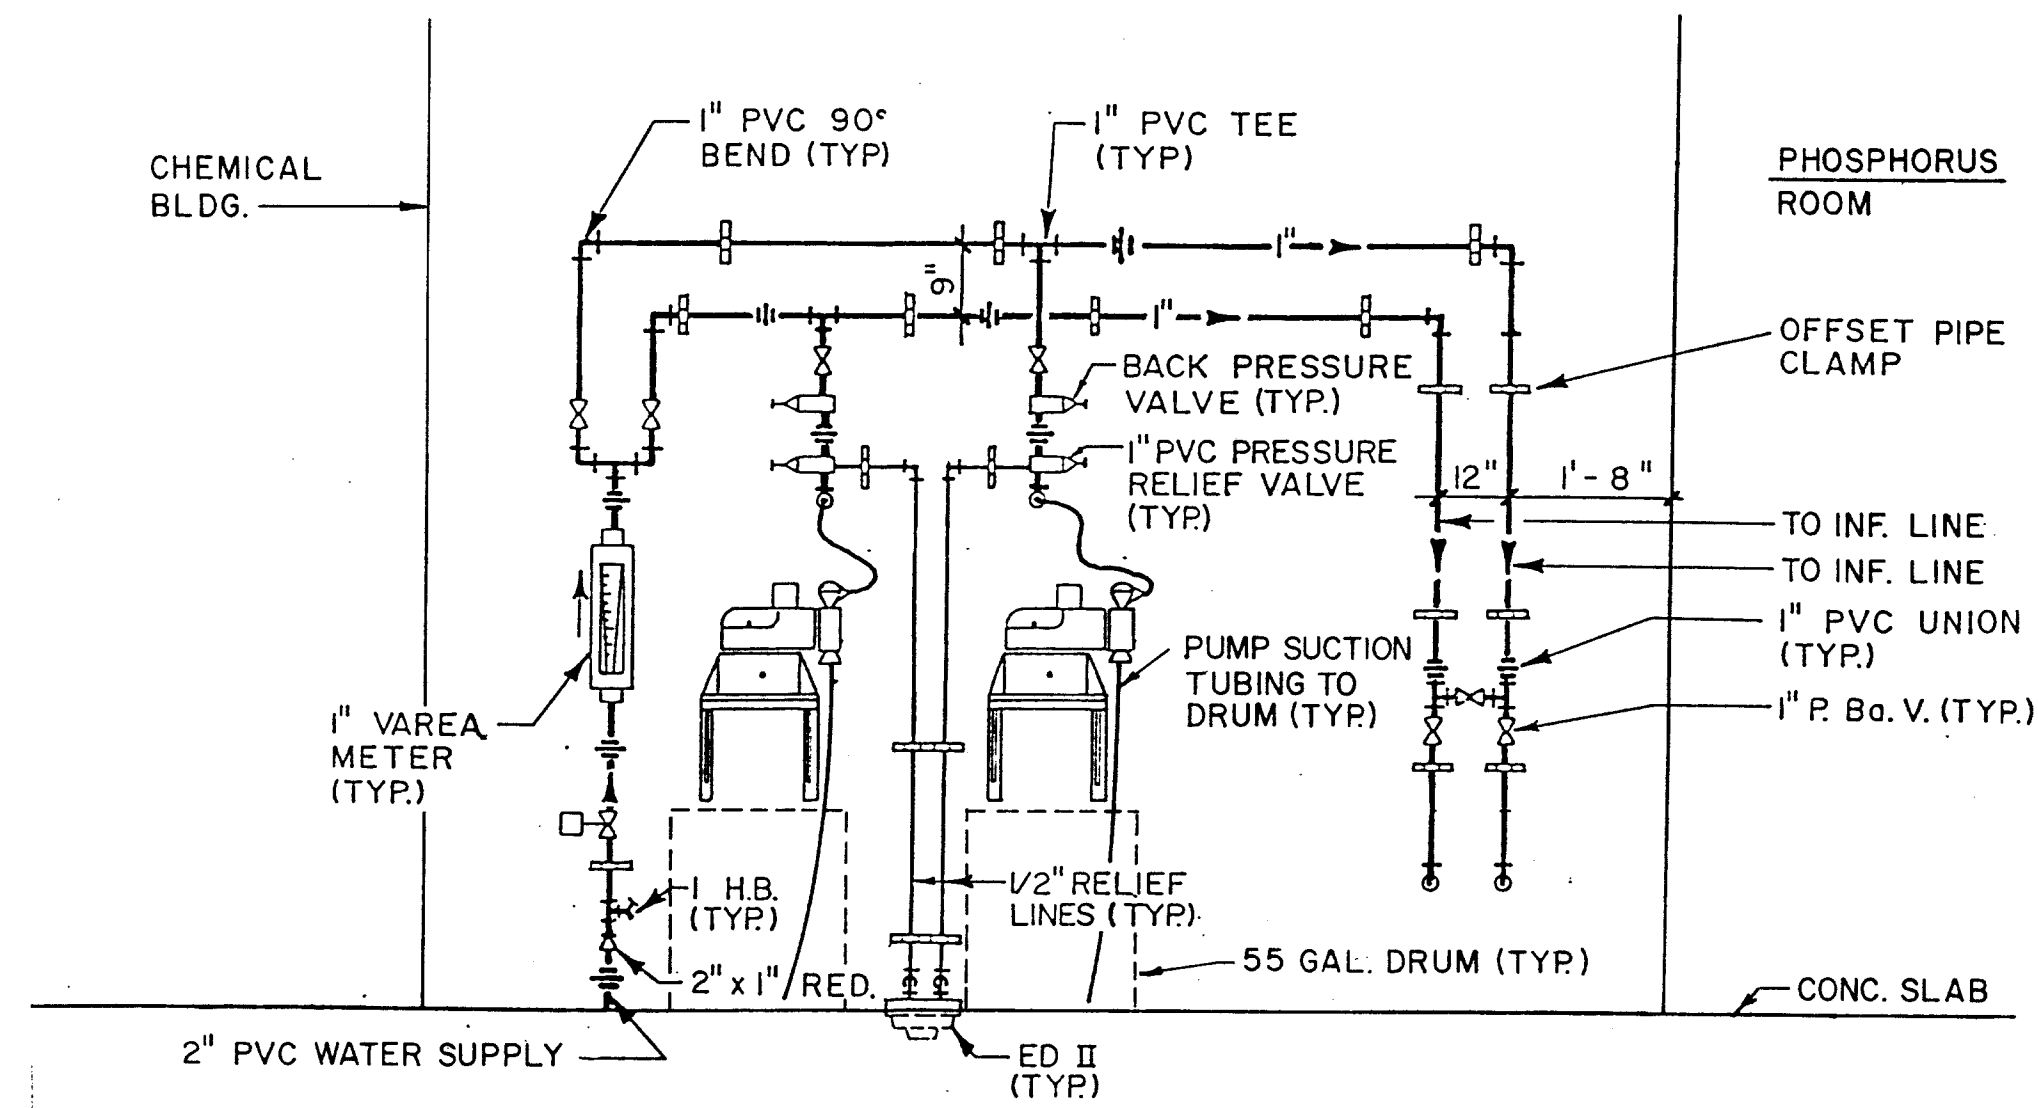


**CHEMICAL ROOM
pH ADJUSTMENT**

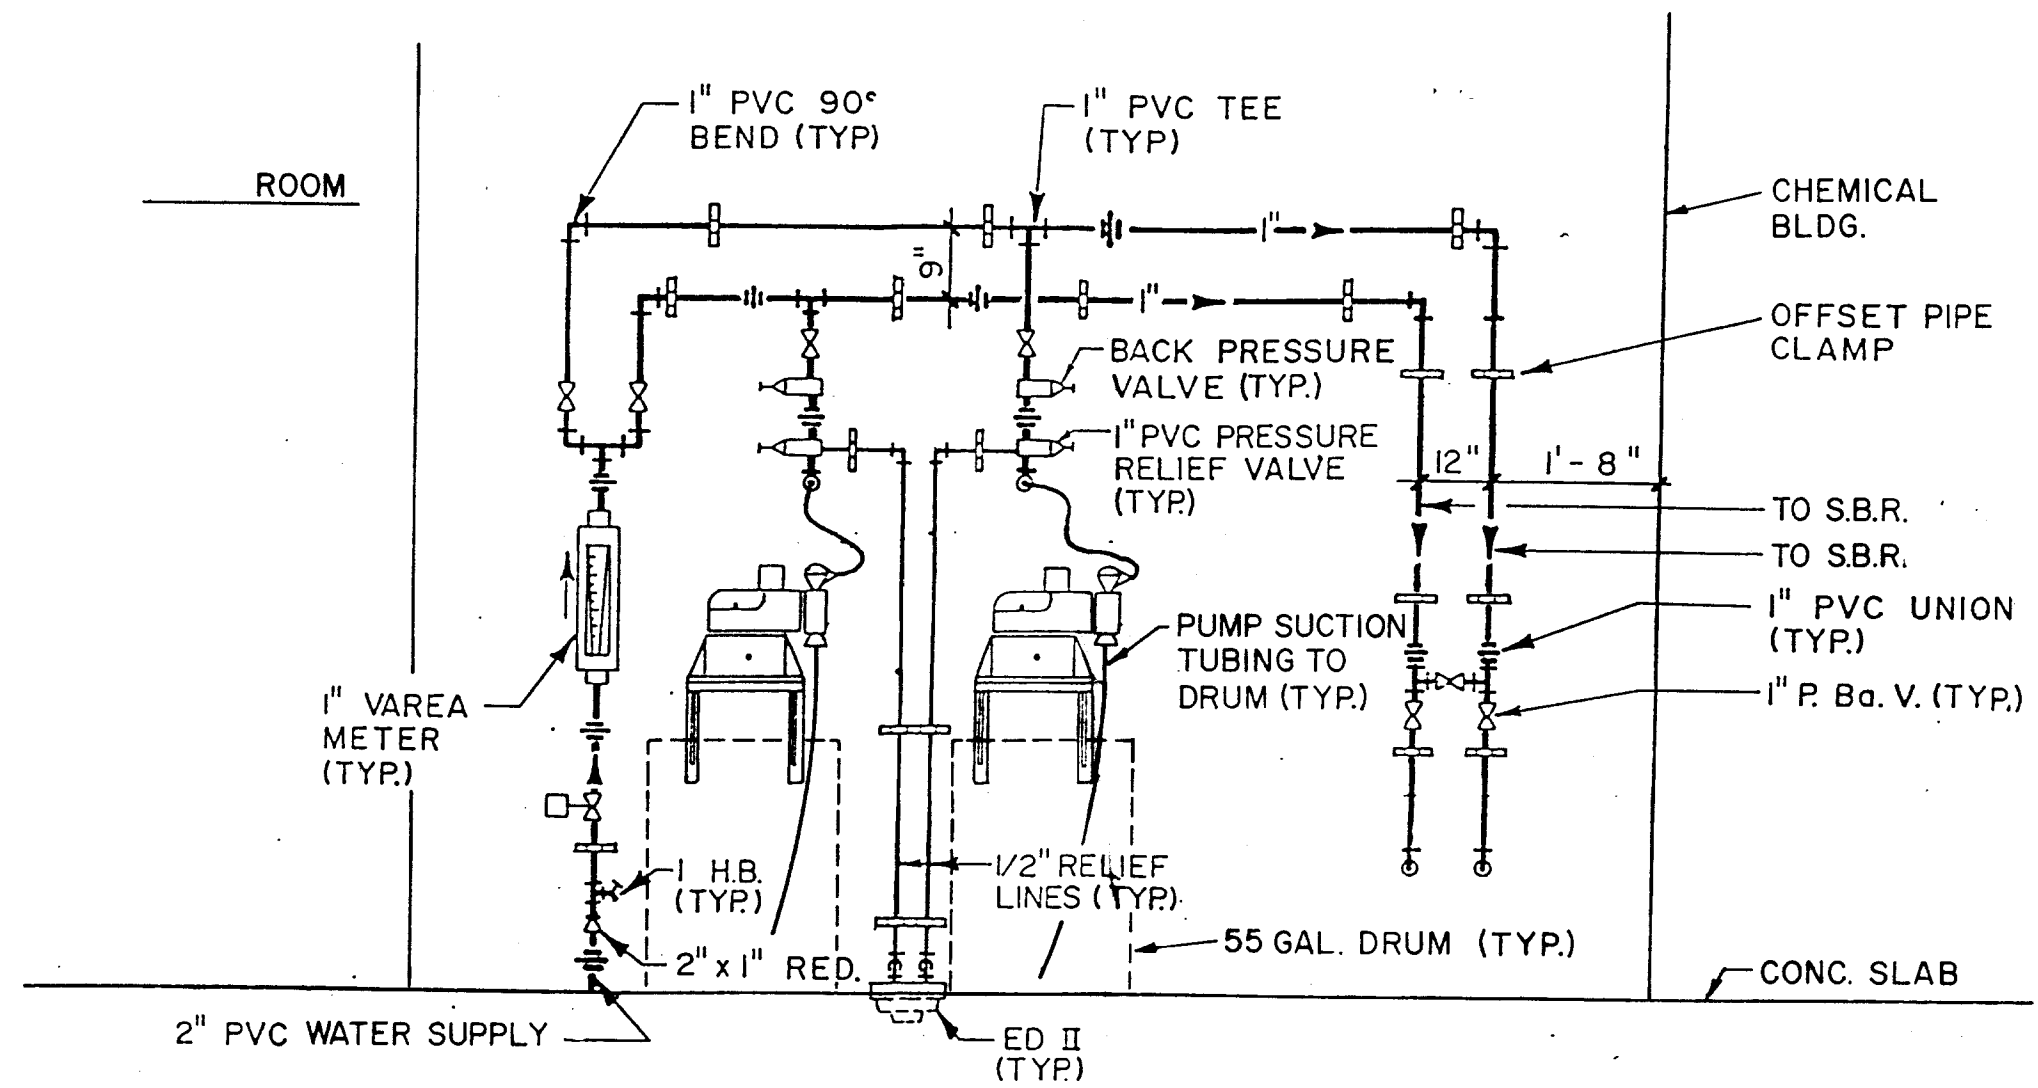


**CHEMICAL ROOM
NUTRIENT SUPPLEMENT**

NOTES:


1. FAN TO BLOW INWARD AND BE LOCATED NEAR THE BOTTOM OF BUILDING.
2. AUTOMATIC SWITCHOVER MODULE AND RATE VALVE TO BE WALL MOUNTED IN FIBERGLASS CHLORINE BUILDING.
3. CHEMICAL BUILDING SIMILAR IN CONSTRUCTION, EXCEPT SIZE AS NOTED.

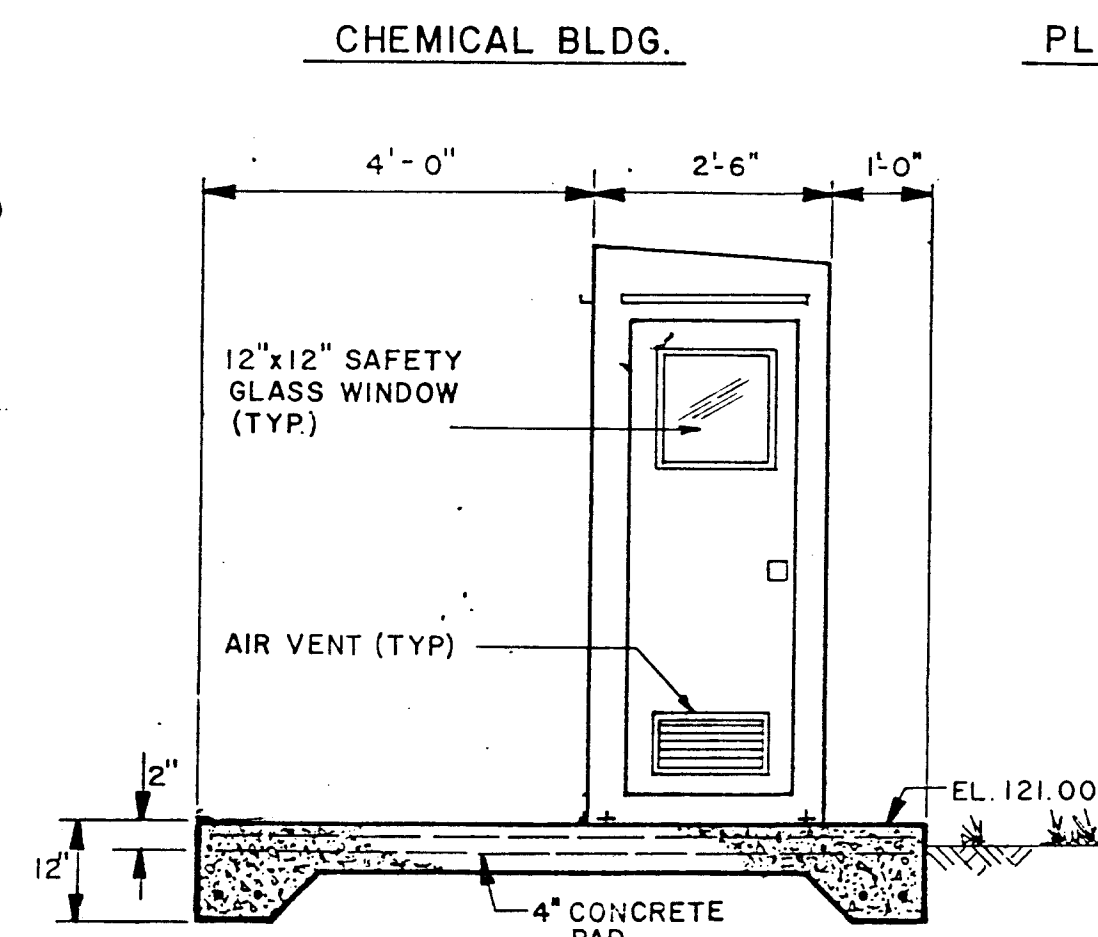



WEST ELEVATION

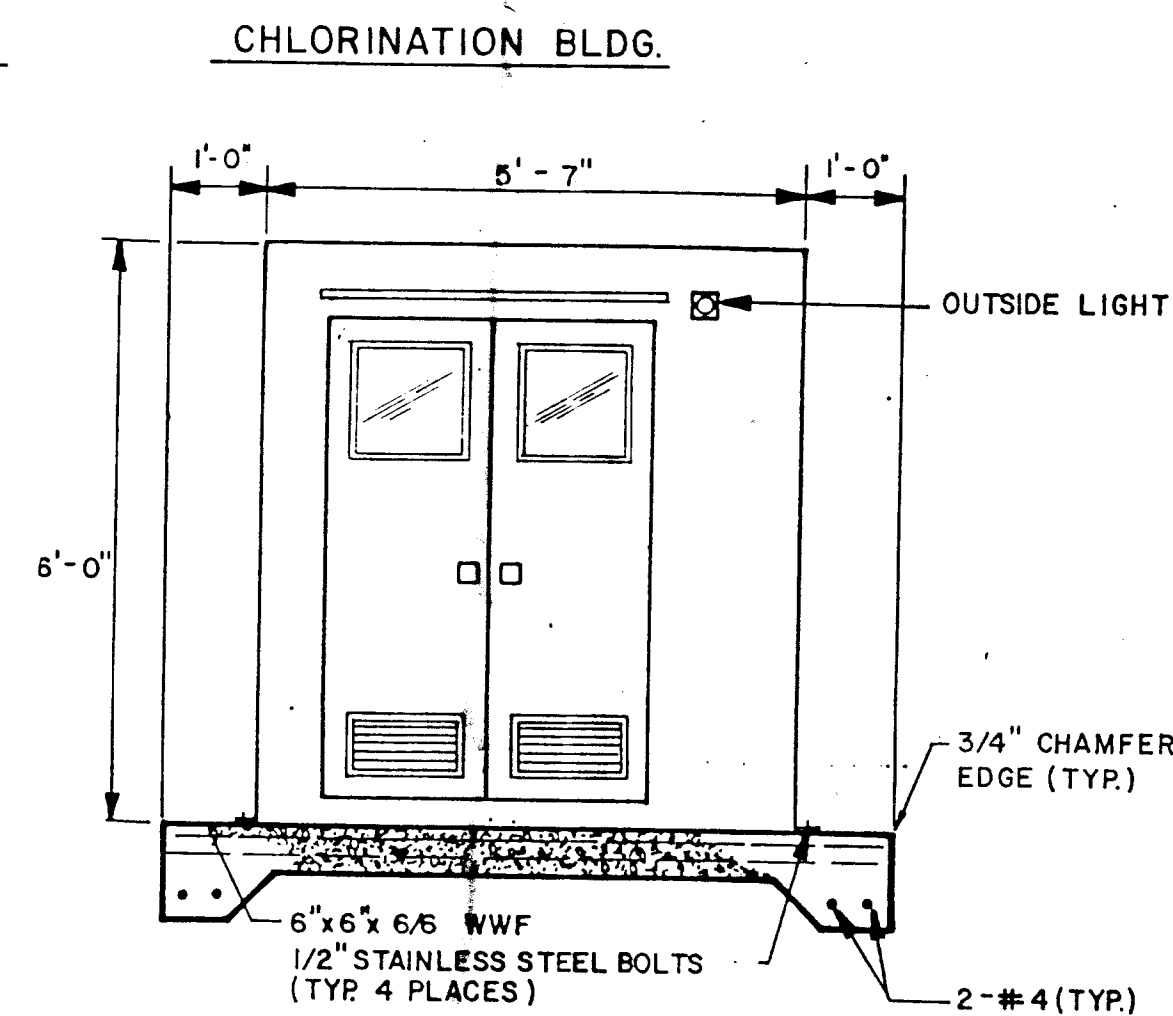

NORTH ELEVATION

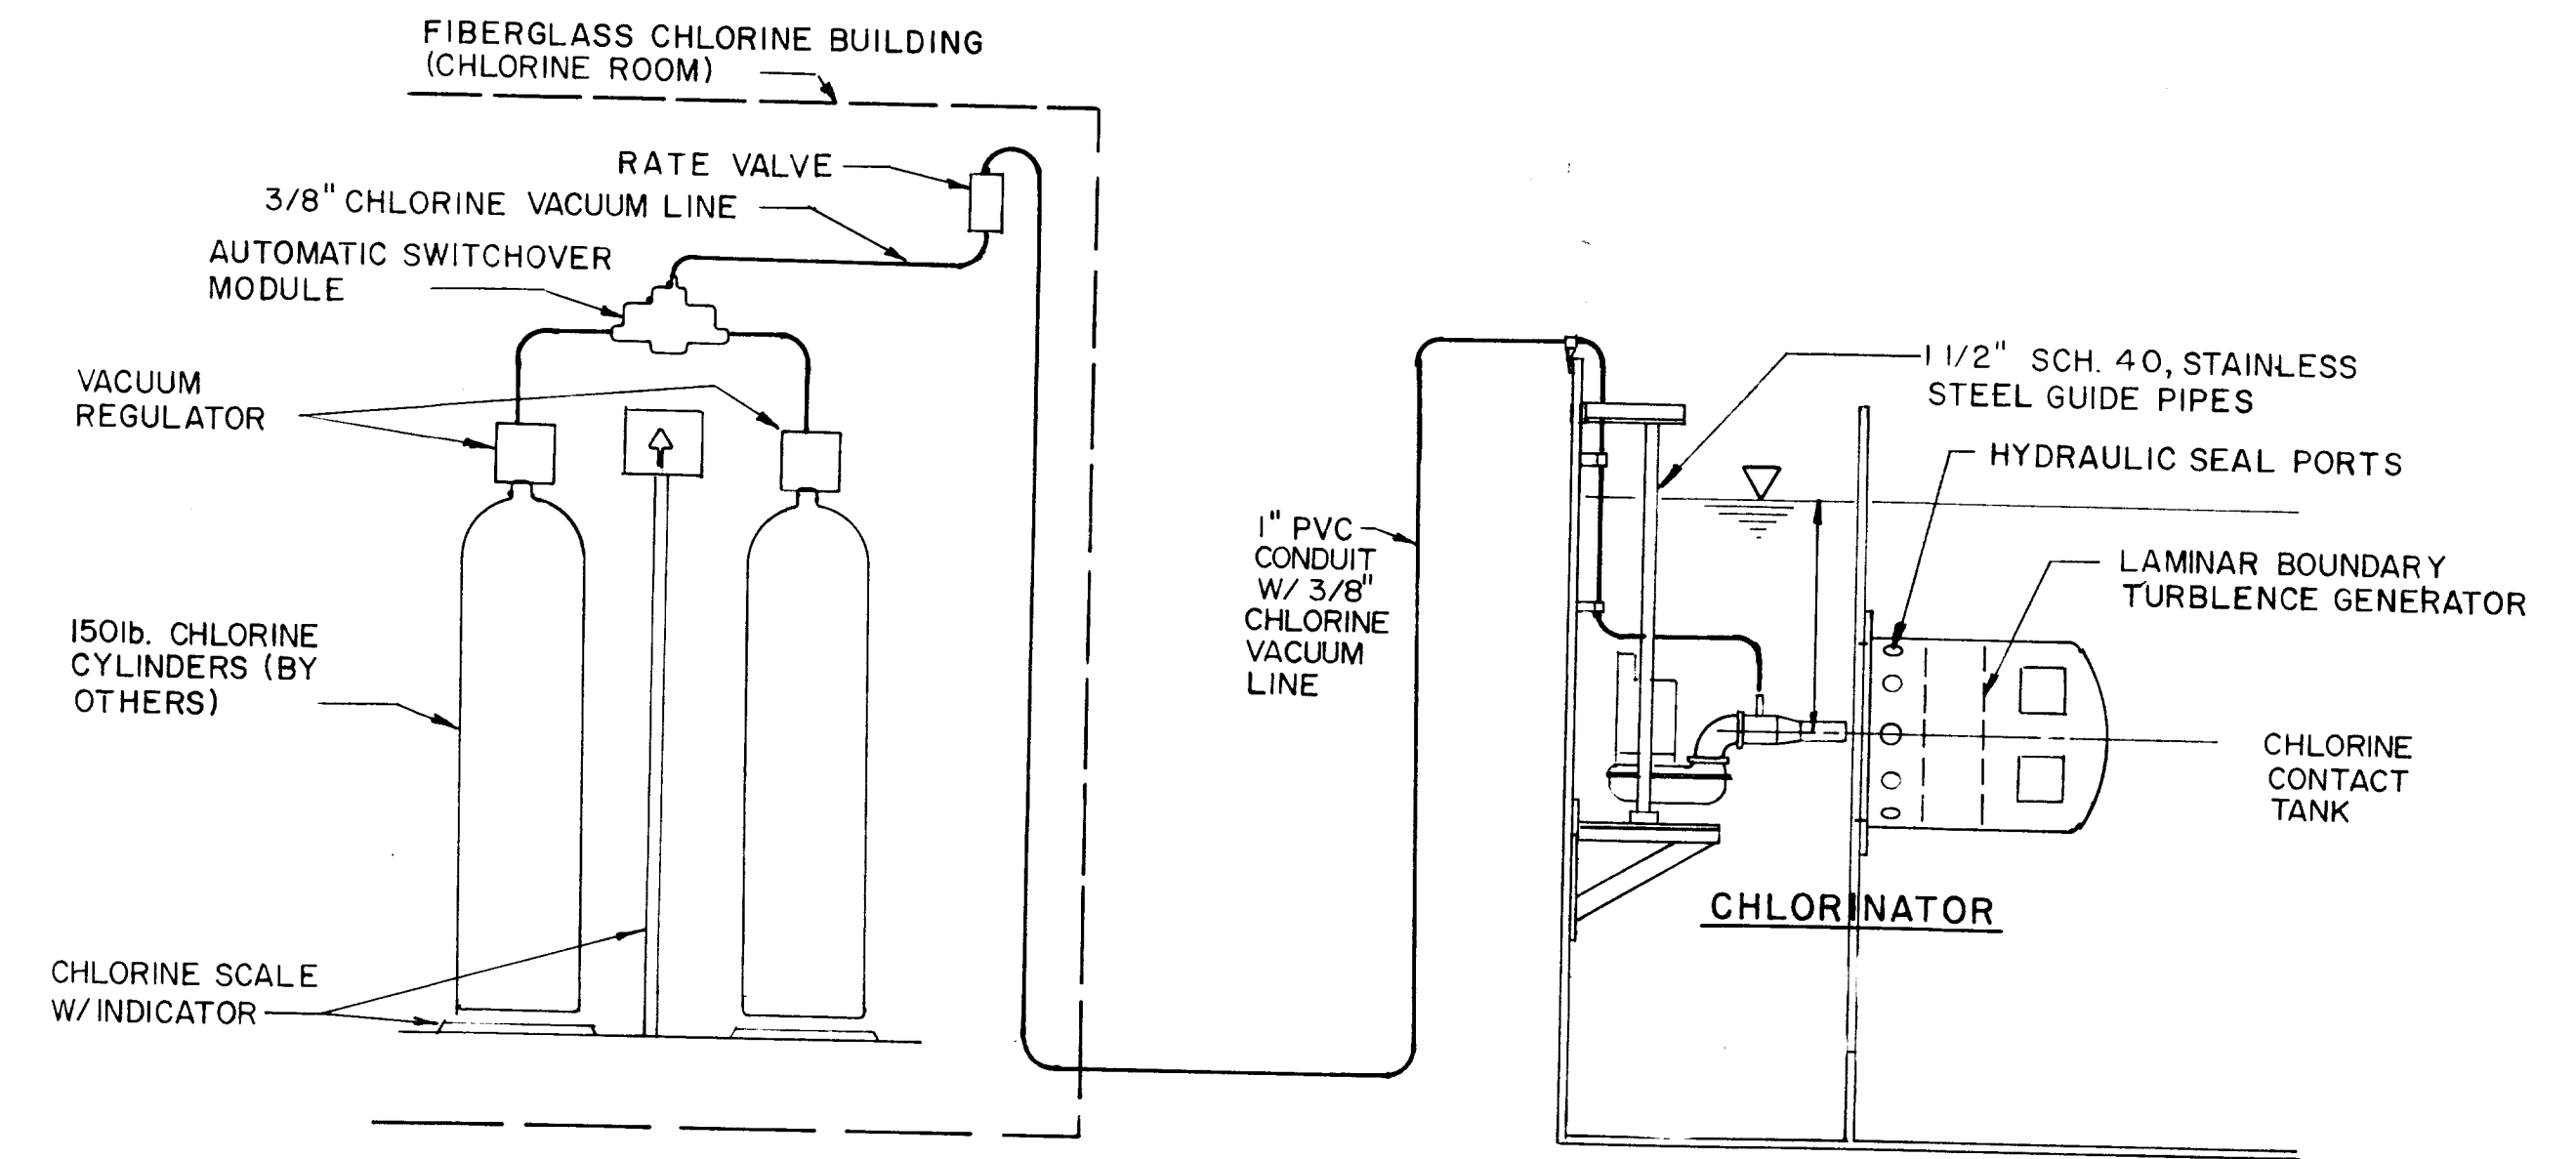

**CHLORINATION SCHEMATIC
NTS**

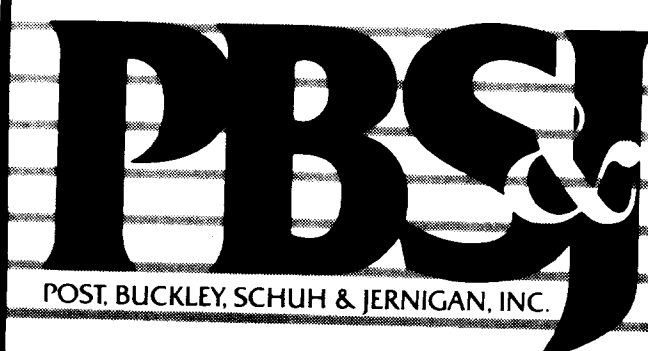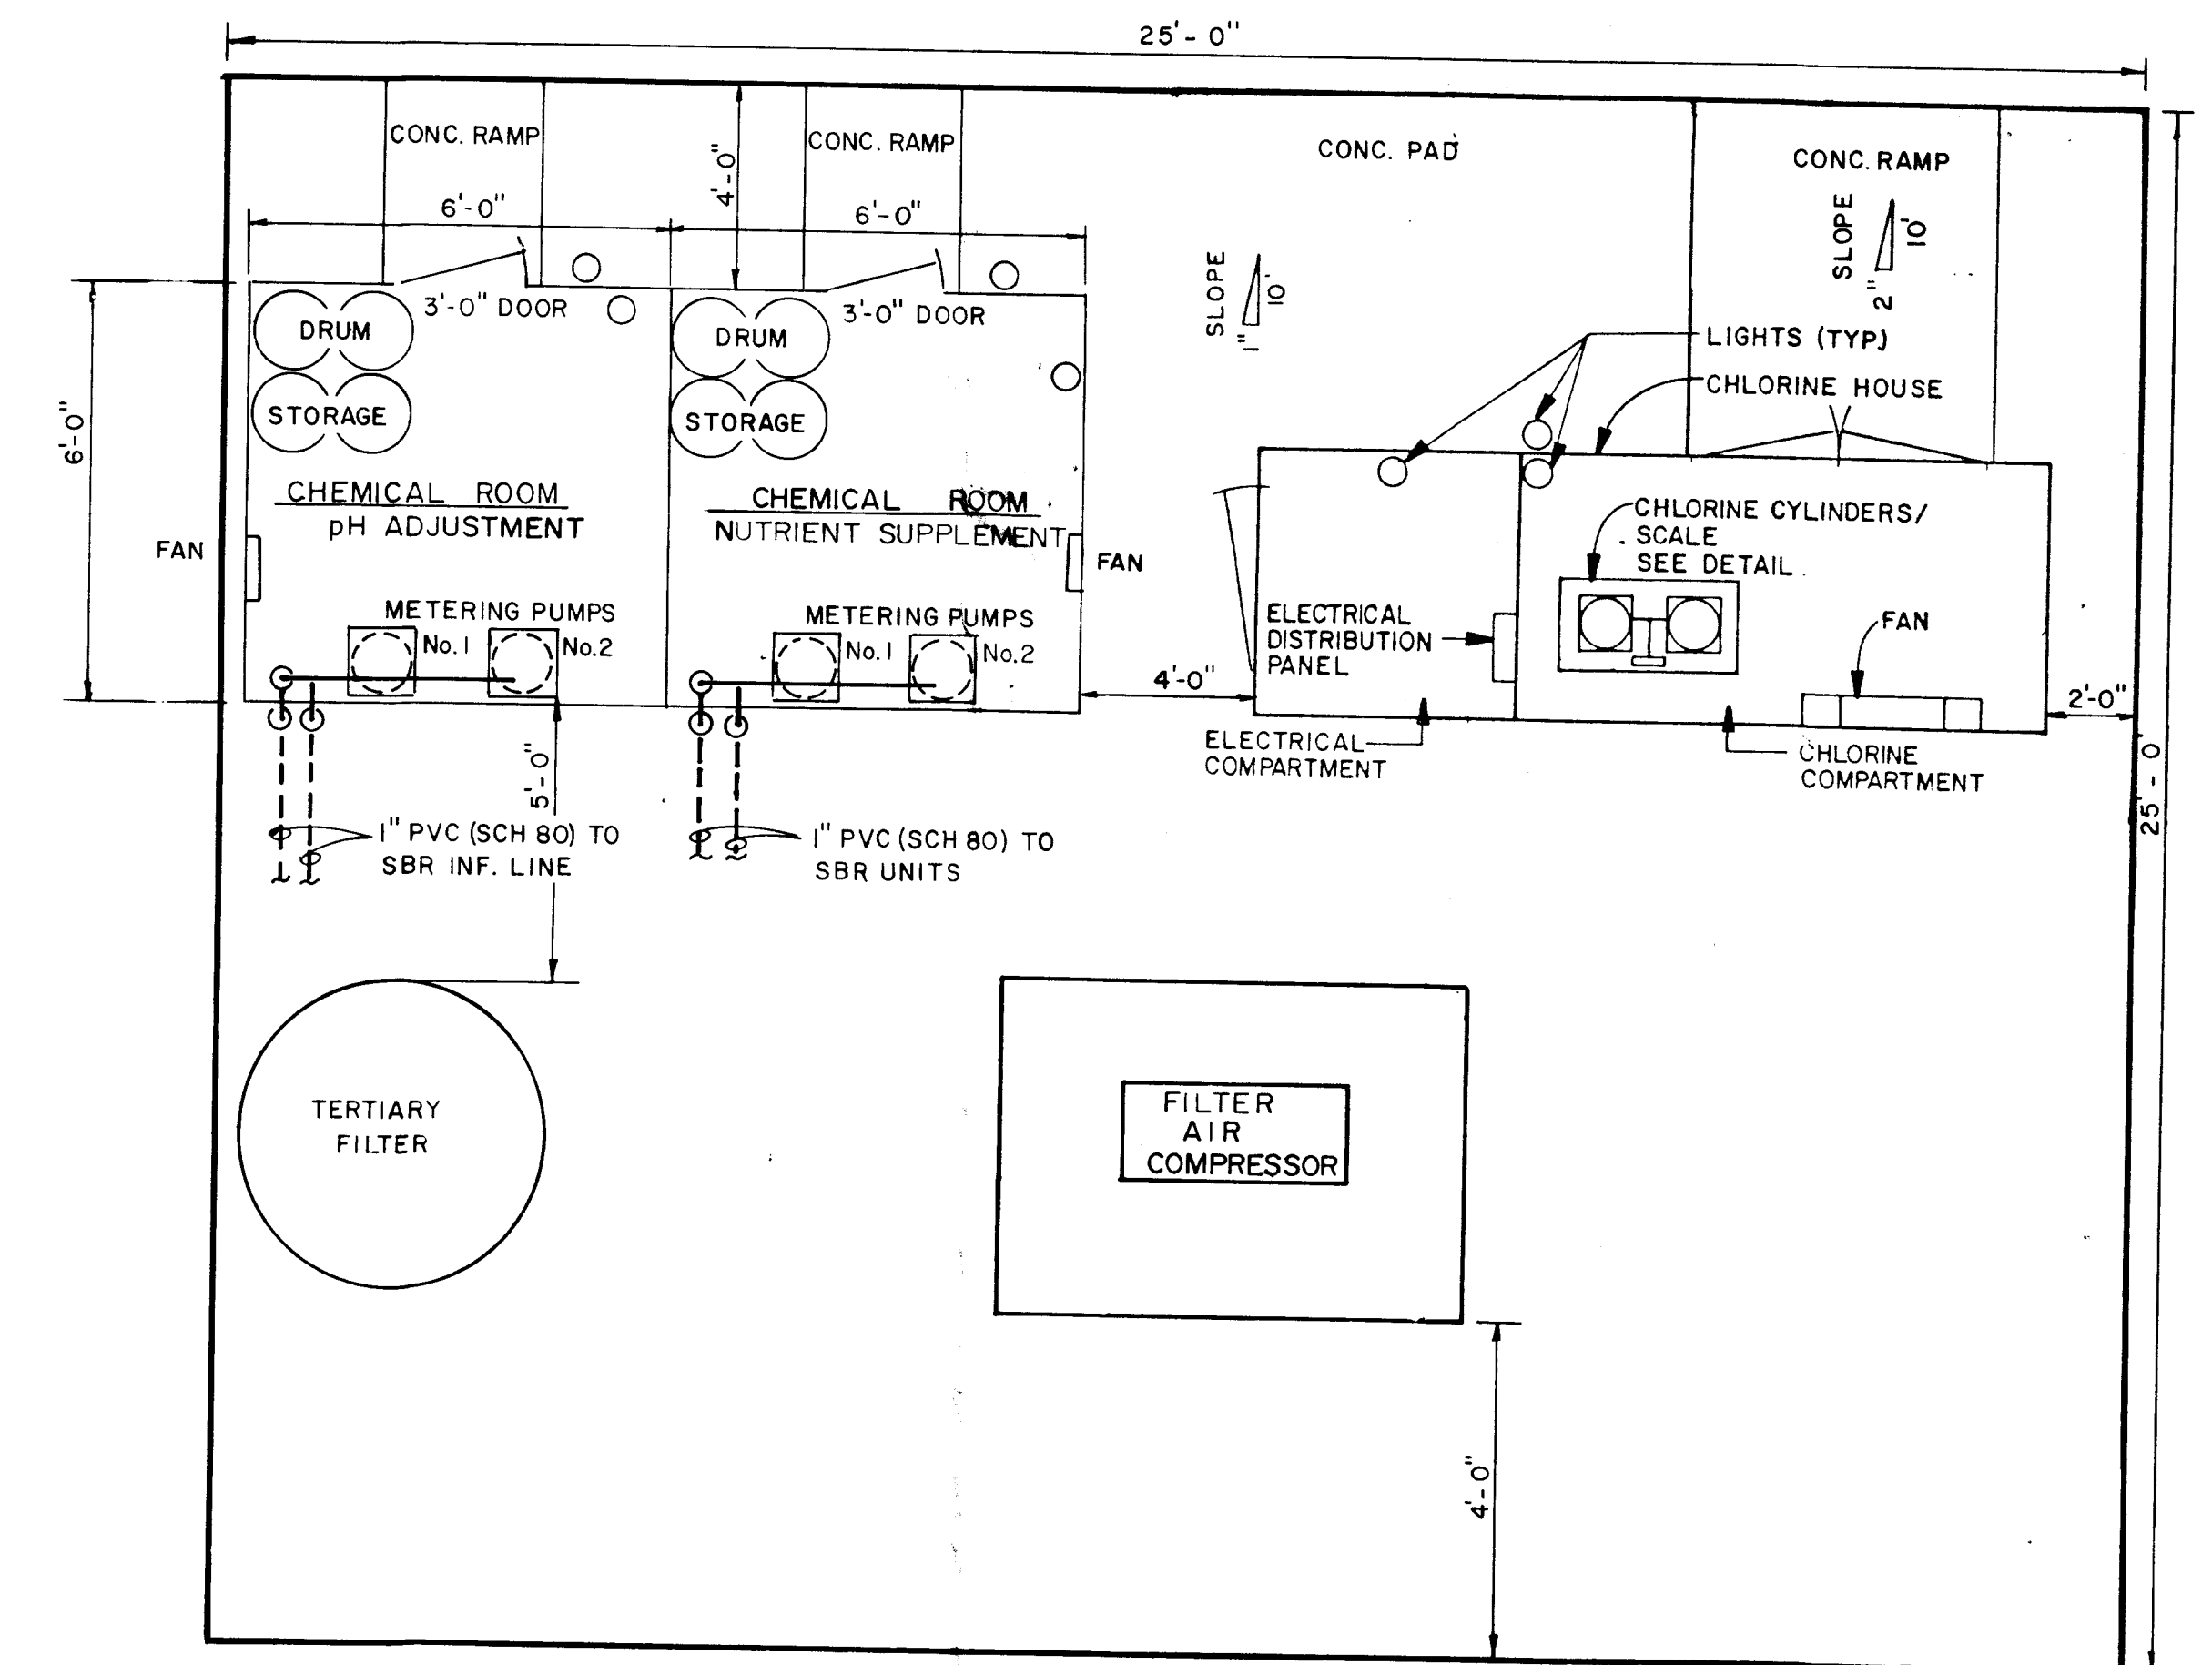


CLIENT
**CITRUS COUNTY, FLORIDA
DEPARTMENT OF
TECHNICAL SERVICES**

PROJECT
**CITRUS COUNTY
CENTRAL LANDFILL EXPANSION
LEACHATE TREATMENT FACILITY**

TASK
**CHEMICAL AND
CHLORINATION SYSTEMS**

ORIGINAL - AUGUST 1988	6
REVISIONS:	7
1	8
2	9
3	10
4	11
5	12


JOB NO. 22-081.30
DRAWN *ms*
DESIGNED *ms*
CHECKED *ms*
QC
NOT VALID FOR CONSTRUCTION
UNLESS SIGNED IN THIS BLOCK
SHEET M-8

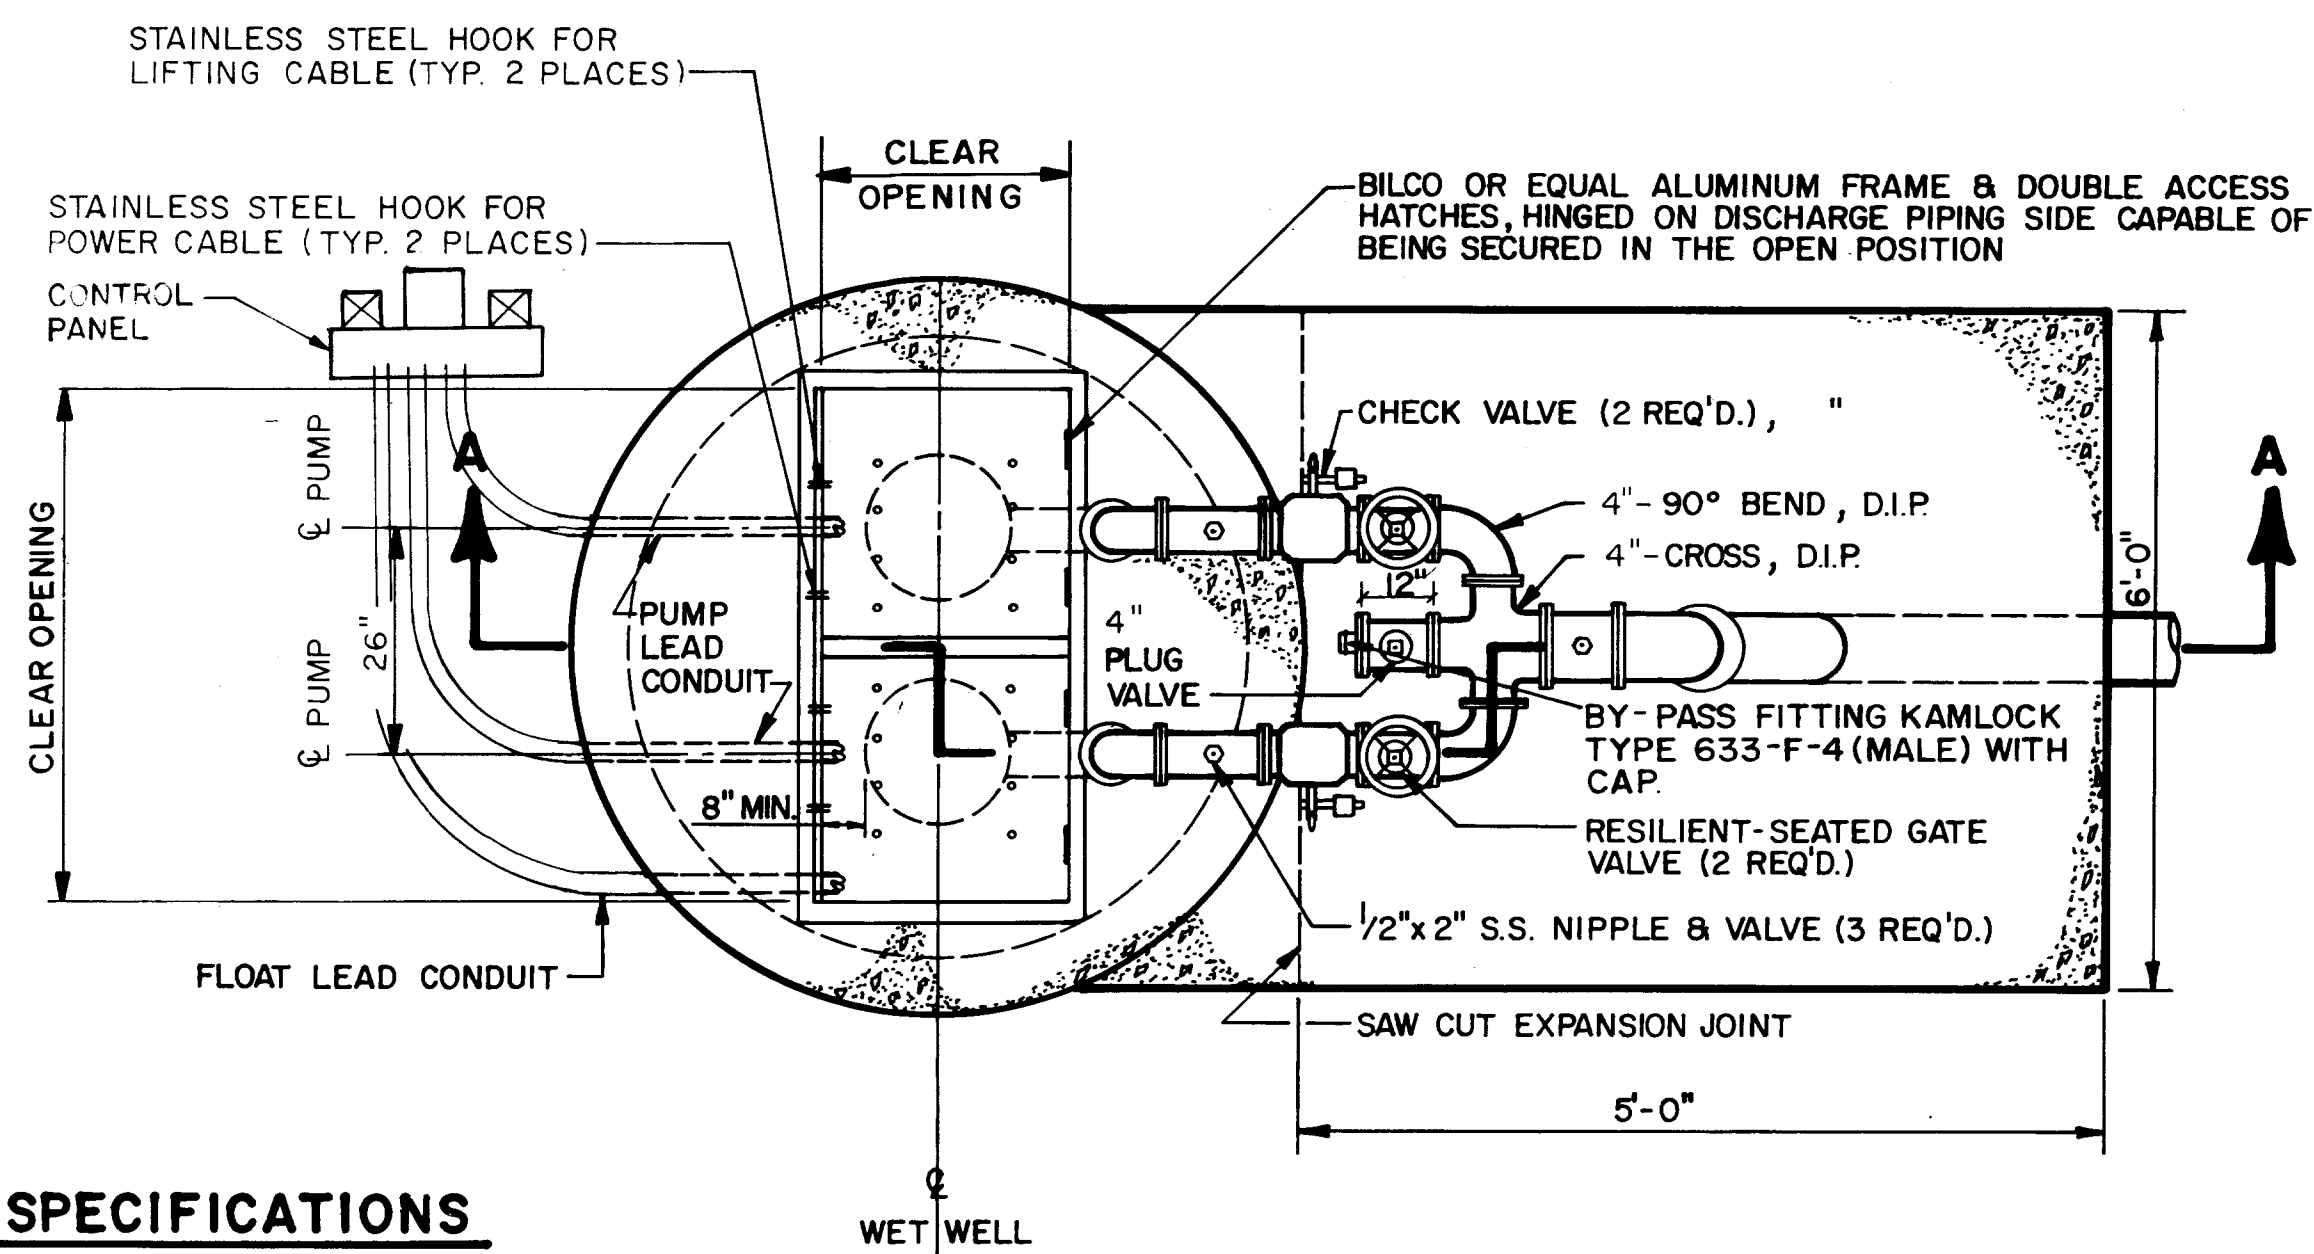

PUMP SPECIFICATIONS

PUMPS REQUIRED	2
MANUFACTURER & MODEL NO.	FLYGT, CP 3060
PUMP SIZE:	
CAPACITY (GPM)	160
TOTAL HEAD (FEET)	27
IMPELLER NO.	8
MOTOR REQUIREMENTS	3 HP, 230 VOLTS, 3 PHASE
SPEED	1150 RPM

PLAN
N.T.S.

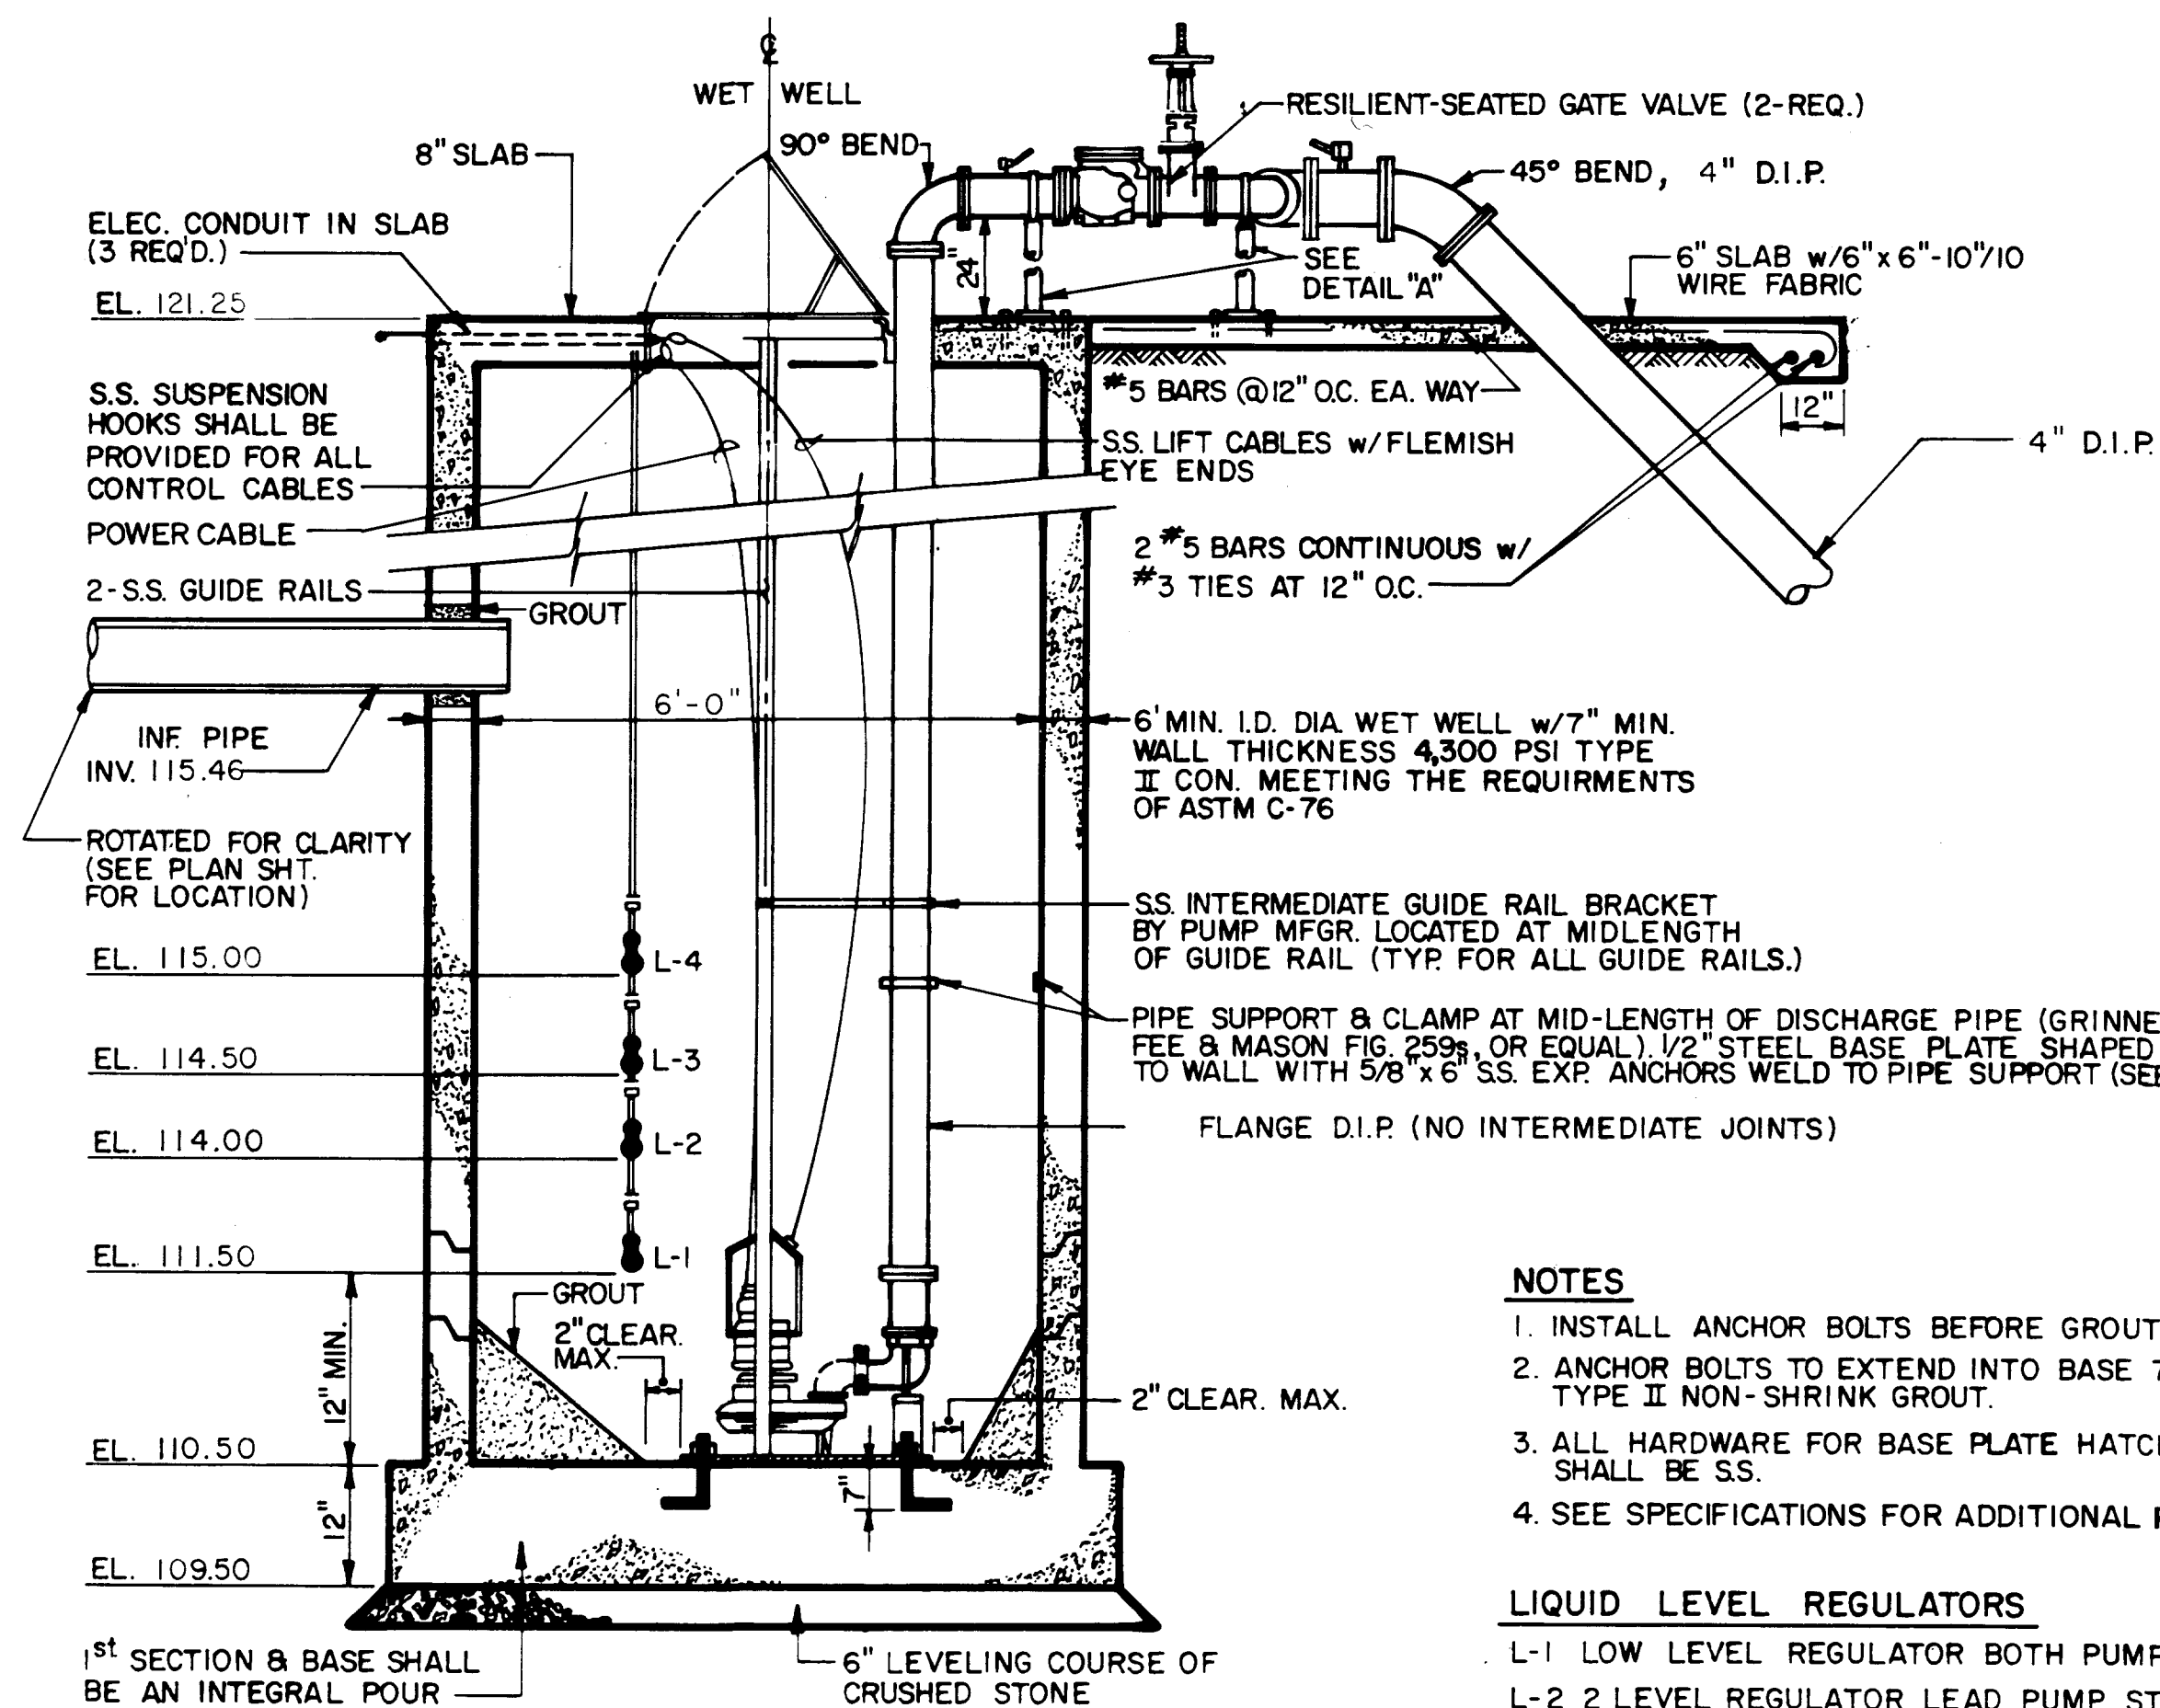


SECTION A-A
N.T.S.

NOTES


1. INSTALL ANCHOR BOLTS BEFORE GROUT IS POURED.
2. ANCHOR BOLTS TO EXTEND INTO BASE 7" & SET W/ TYPE II NON-SHRINK GROUT.
3. ALL HARDWARE FOR BASE PLATE HATCH COVER SHALL BE SS.
4. SEE SPECIFICATIONS FOR ADDITIONAL REQUIREMENTS.

LIQUID LEVEL REGULATORS


- L-1 LOW LEVEL REGULATOR BOTH PUMPS OFF
- L-2 2 LEVEL REGULATOR LEAD PUMP STARTS
- L-3 3rd LEVEL REGULATOR BOTH PUMPS ON (LAG PUMP STARTS)
- L-4 4th LEVEL REGULATOR HIGH LEVEL ALARM ON

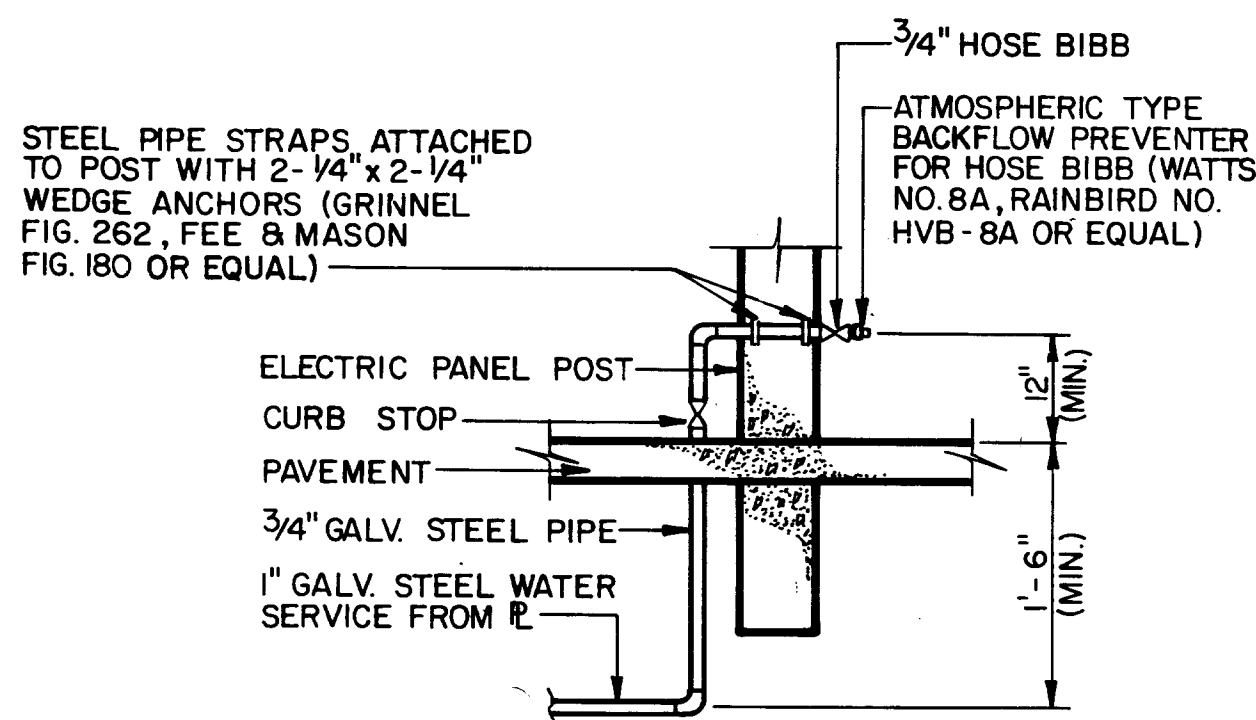


WATER SERVICE RISER
N.T.S.

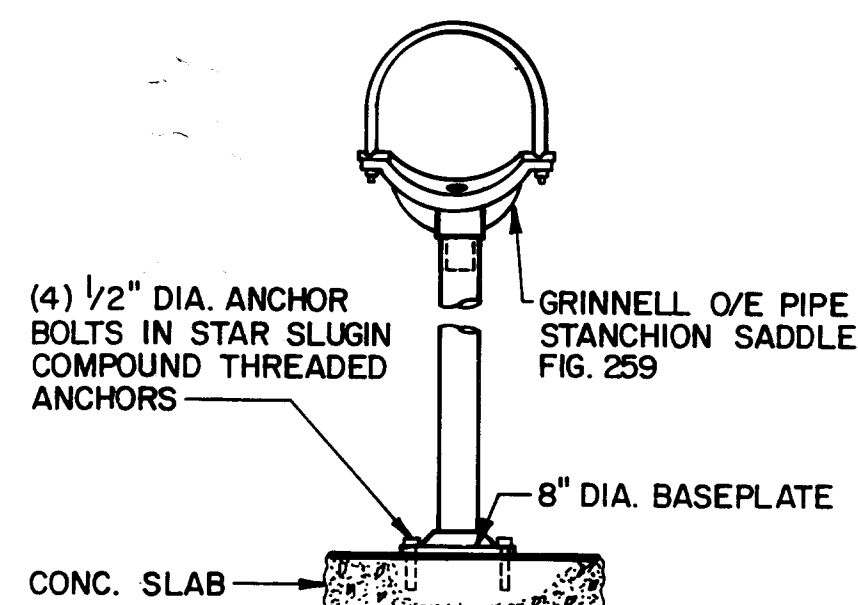


PIPE SUPPORT DETAIL "A"
N.T.S.




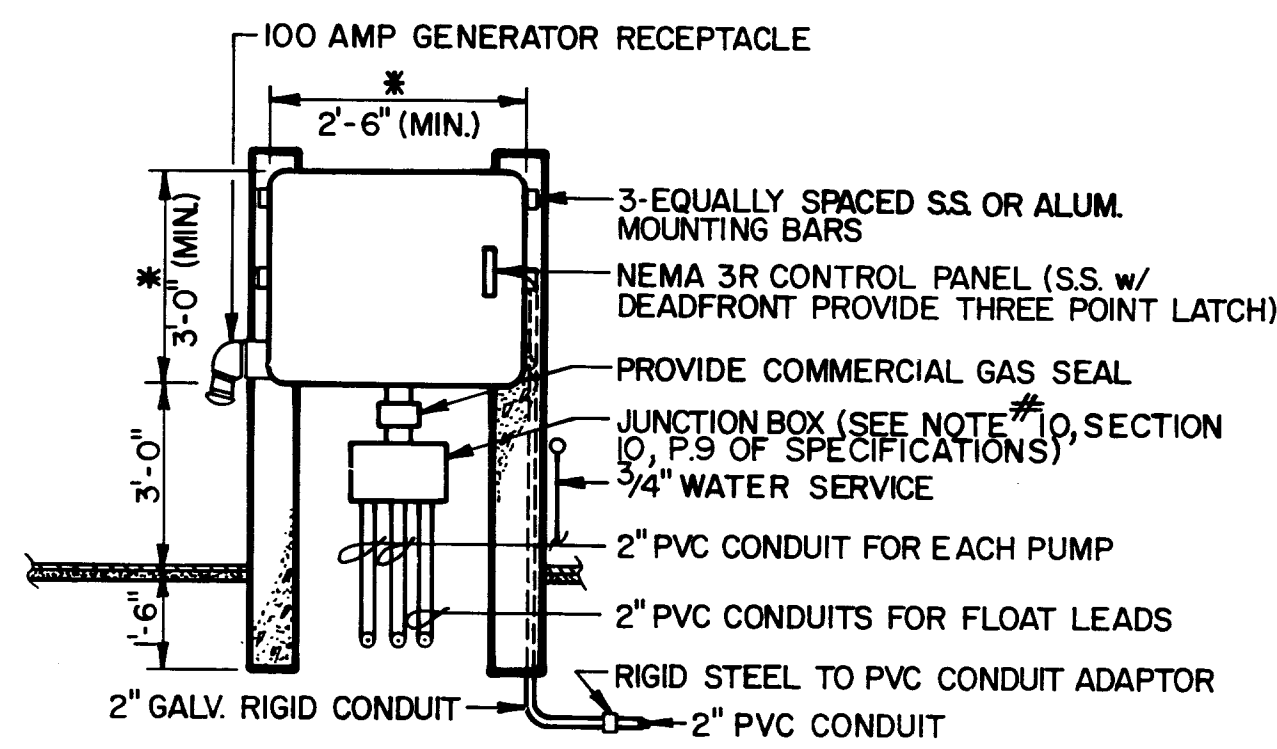


FRONT VIEW

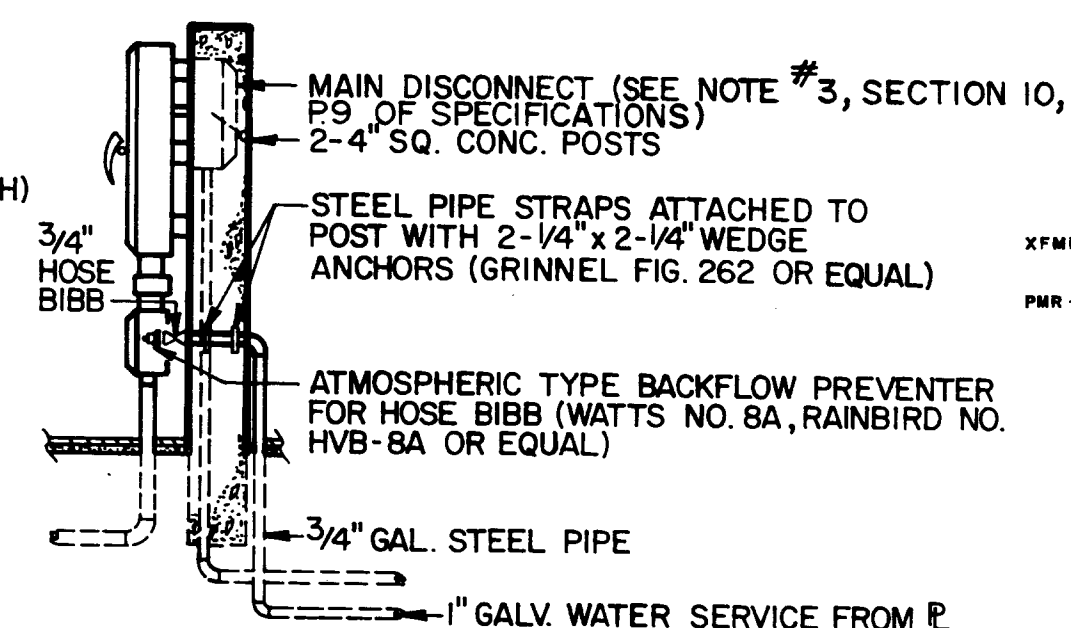

SIDE VIEW

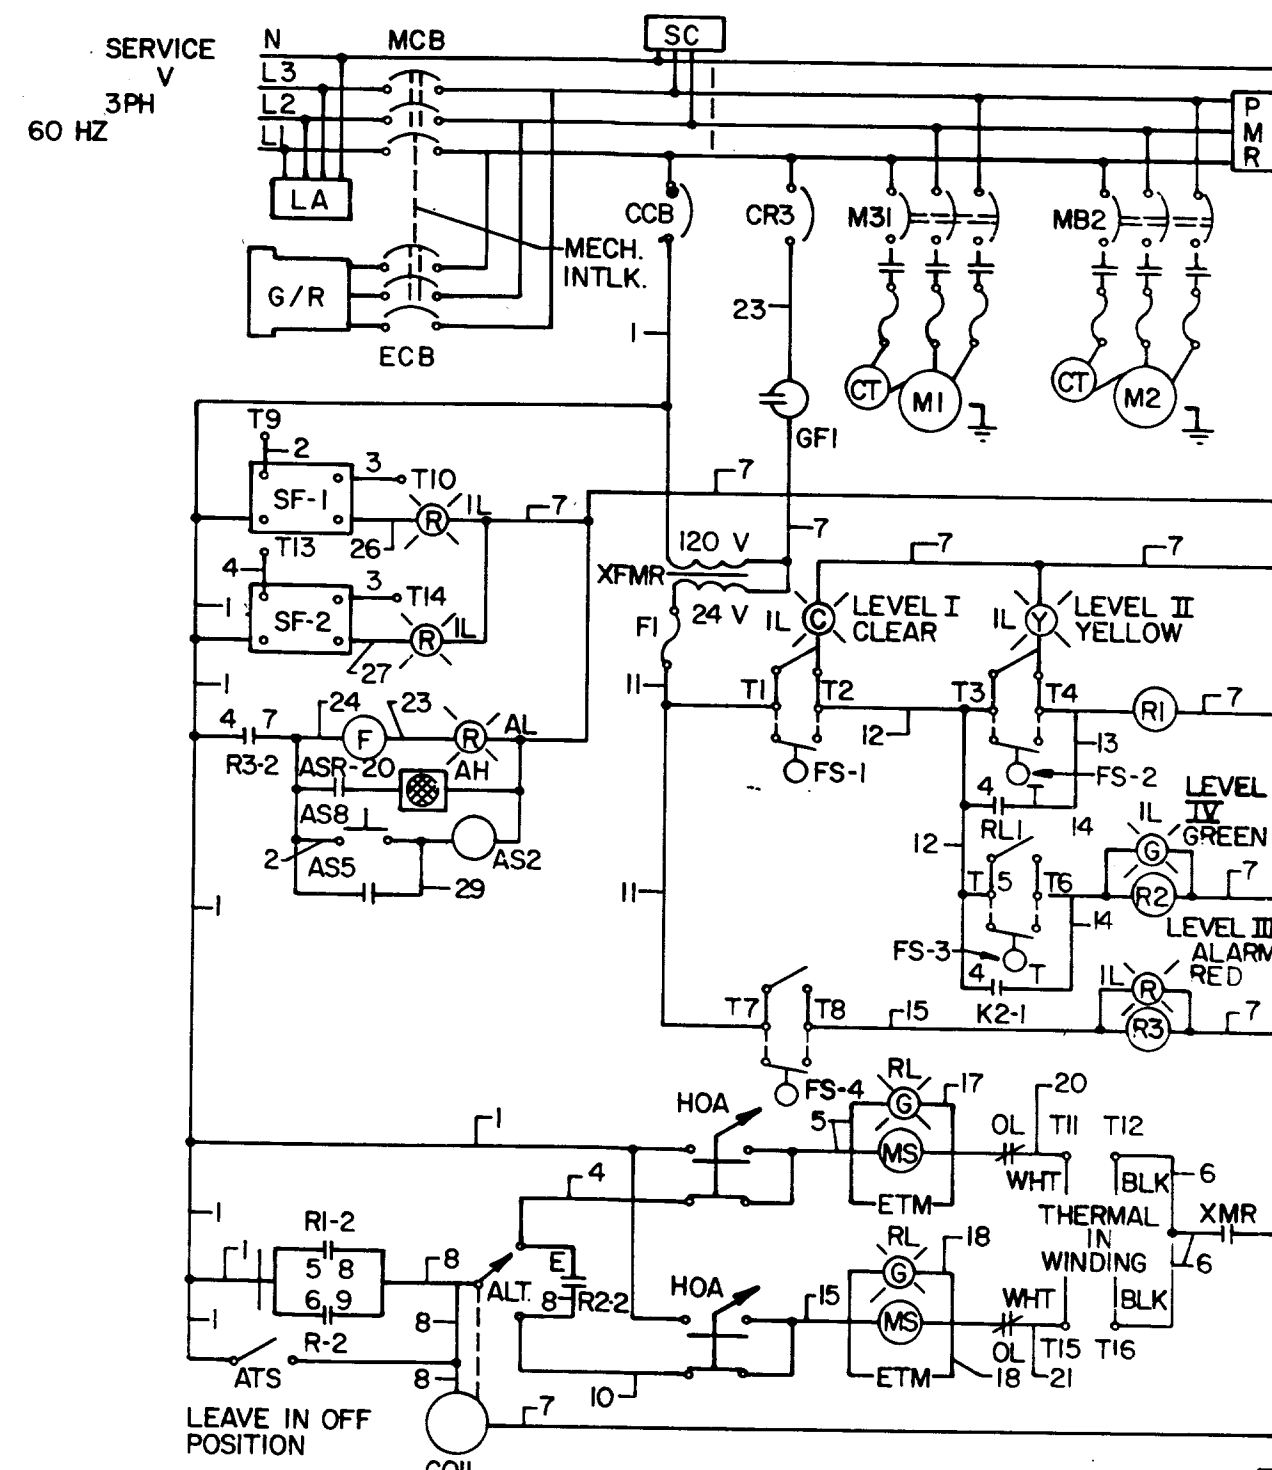


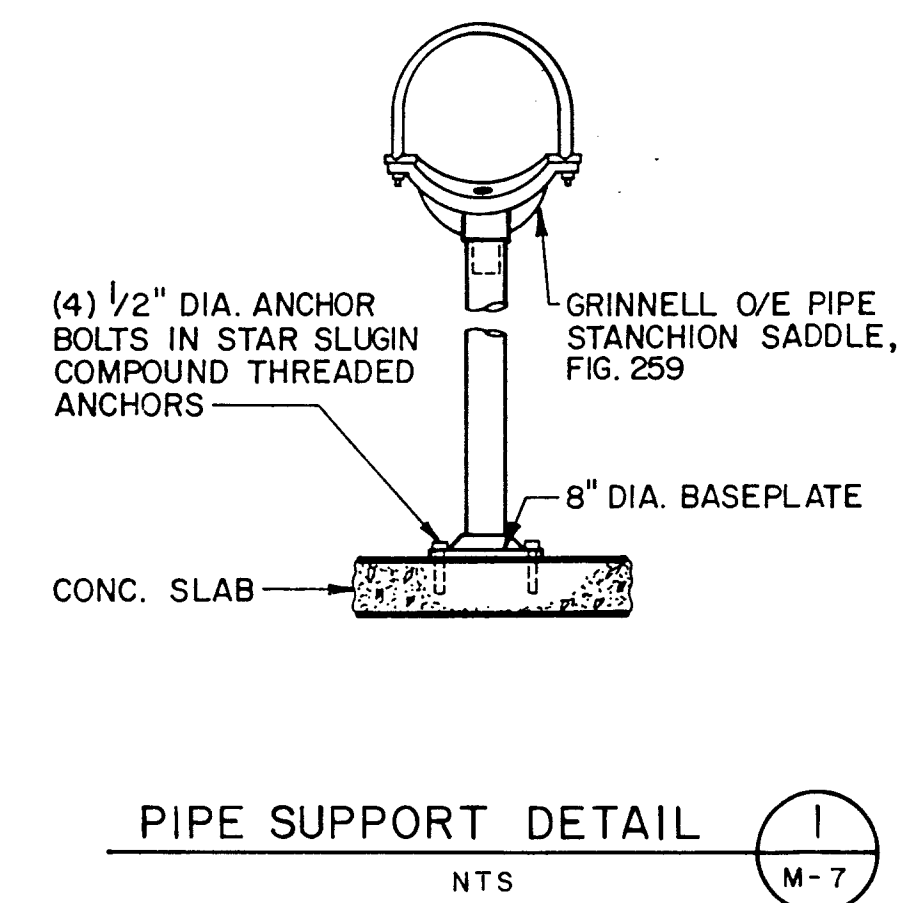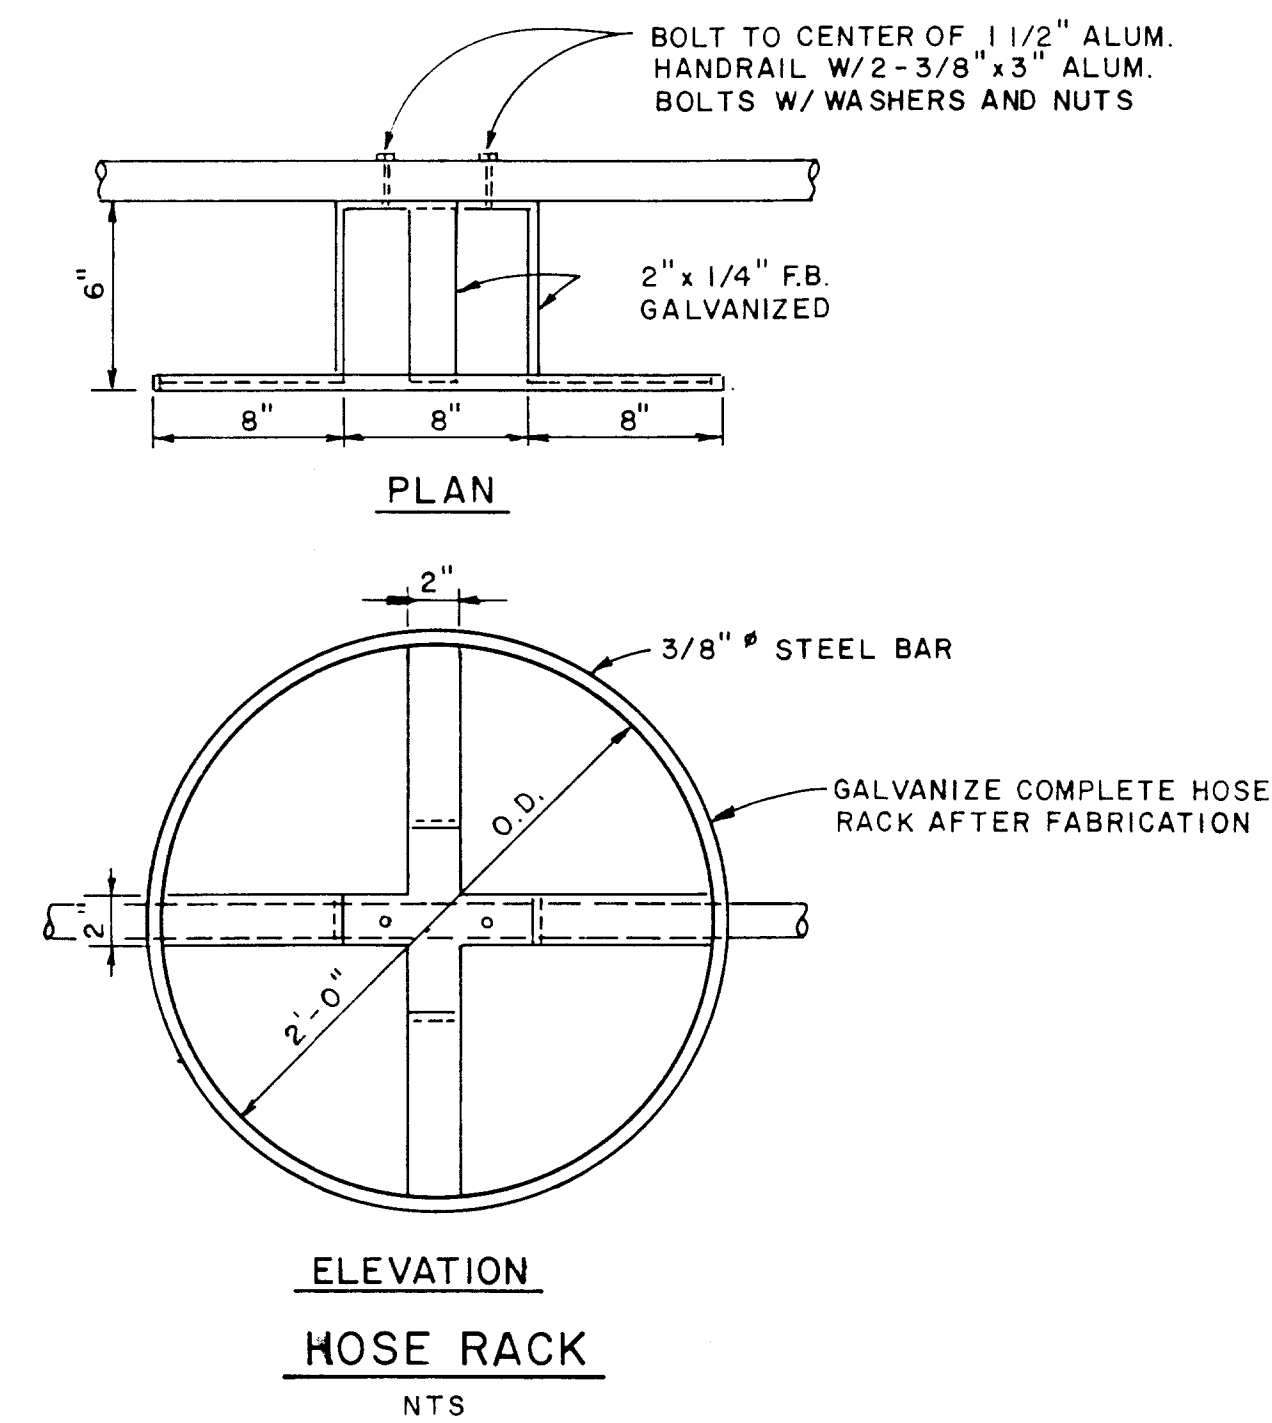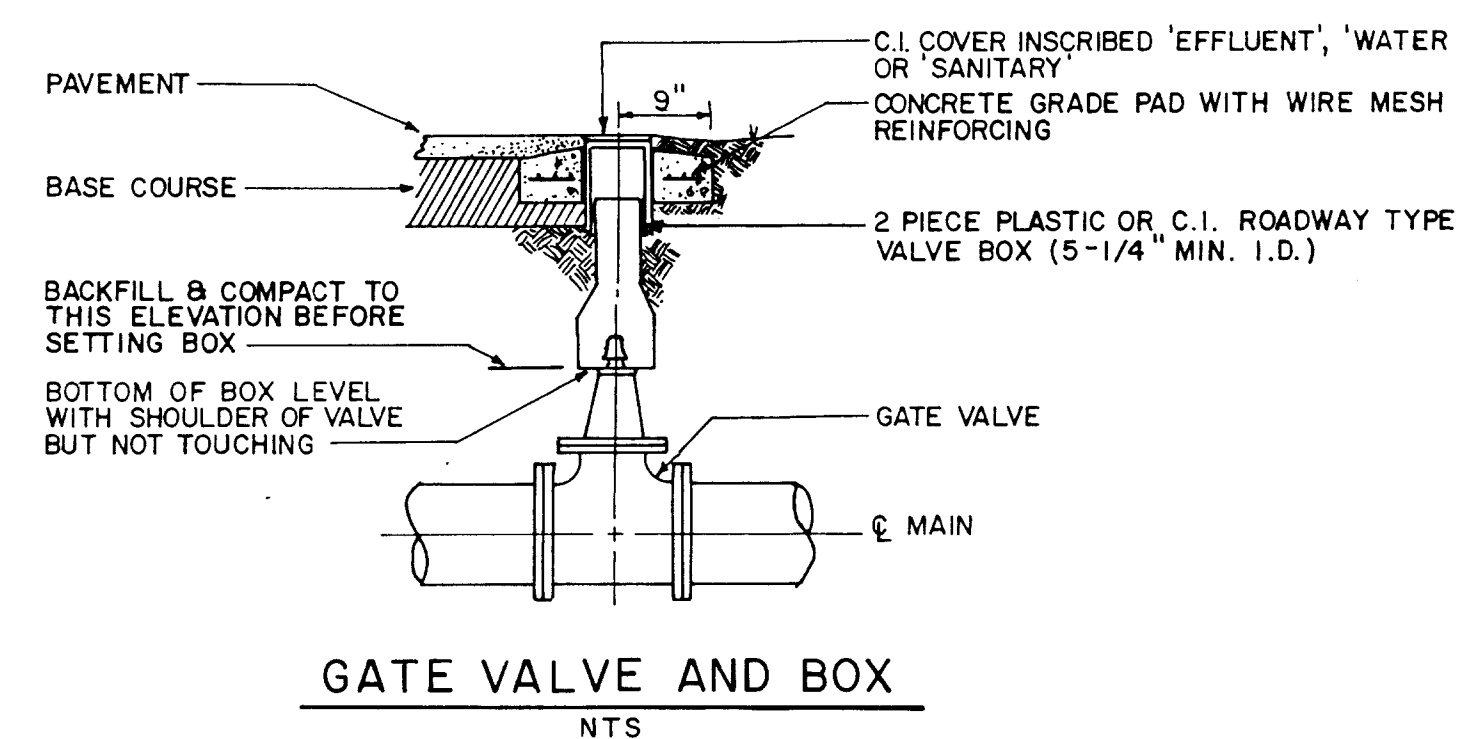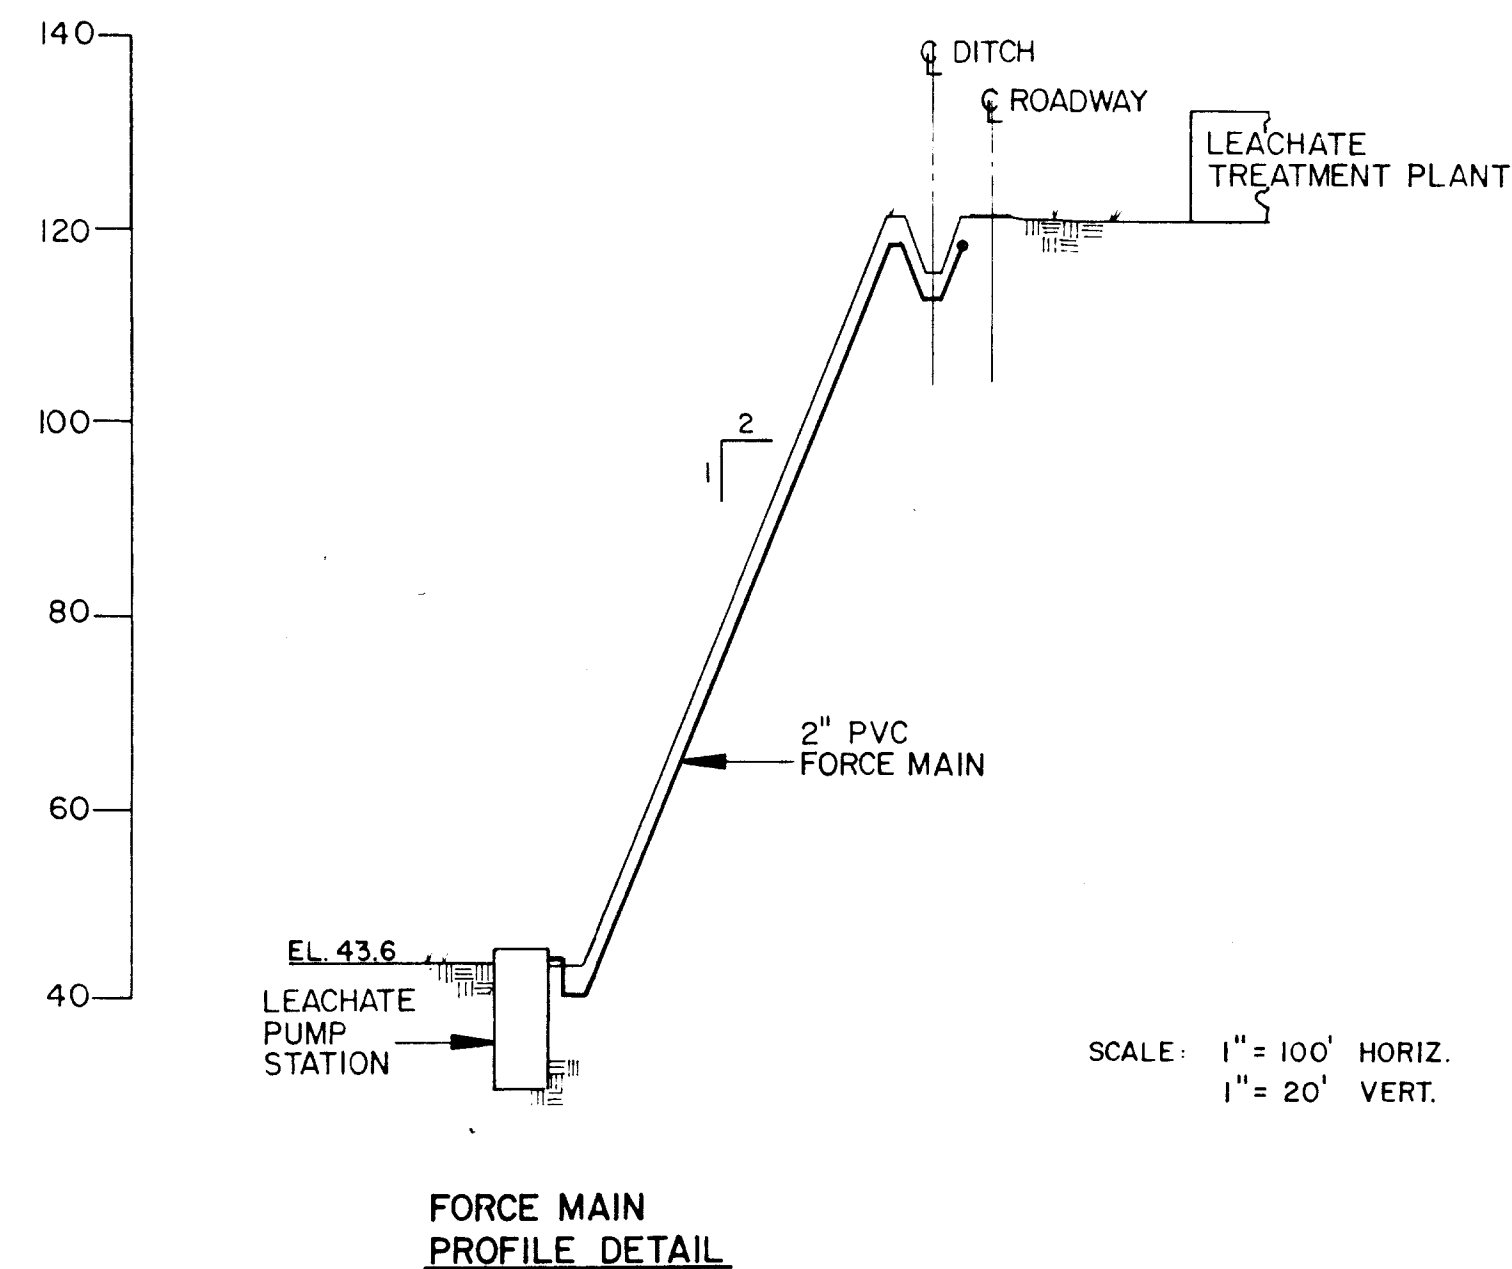

PLAN
BENDS
SECTION X-X
BENDS & TEES
PLAN & ELEV.
PLUGS

SOIL	SIZE	1/4 BEND		1/8 BEND		1/16 BEND		TEE		PLUG	
		A	B	A	B	A	B	A	B	C	D
4000 PSF	6"	8"	10"	6"	8"	3"	8"	8"	8"	10"	15"
	8"	12"	12"	8"	10"	5"	9"	9"	12"	12"	20"
	10"	16"	14"	10"	12"	6"	10"	11"	14"	14"	25"
	12"	19"	16"	12"	14"	8"	11"	14"	16"	16"	30"
	14"	23"	18"	14"	16"	10"	12"	16"	18"	18"	34"
2000 PSF	16"	26"	20"	16"	18"	11"	13"	18"	20"	20"	38"
	6"	16"	10"	9"	10"	6"	8"	8"	10"	12"	21"
	8"	22"	13"	12"	13"	8"	10"	13"	16"	12"	29"
	10"	26"	17"	14"	17"	10"	13"	16"	20"	14"	36"
	12"	29"	21"	16"	21"	11"	16"	18"	24"	16"	41"
	14"	35"	24"	19"	24"	12"	20"	22"	27"	18"	48"
	16"	38"	27"	21"	27"	12"	24"	24"	30"	20"	54"

TYPICAL THRUST BLOCKS
FOR WATER MAINS
NTS

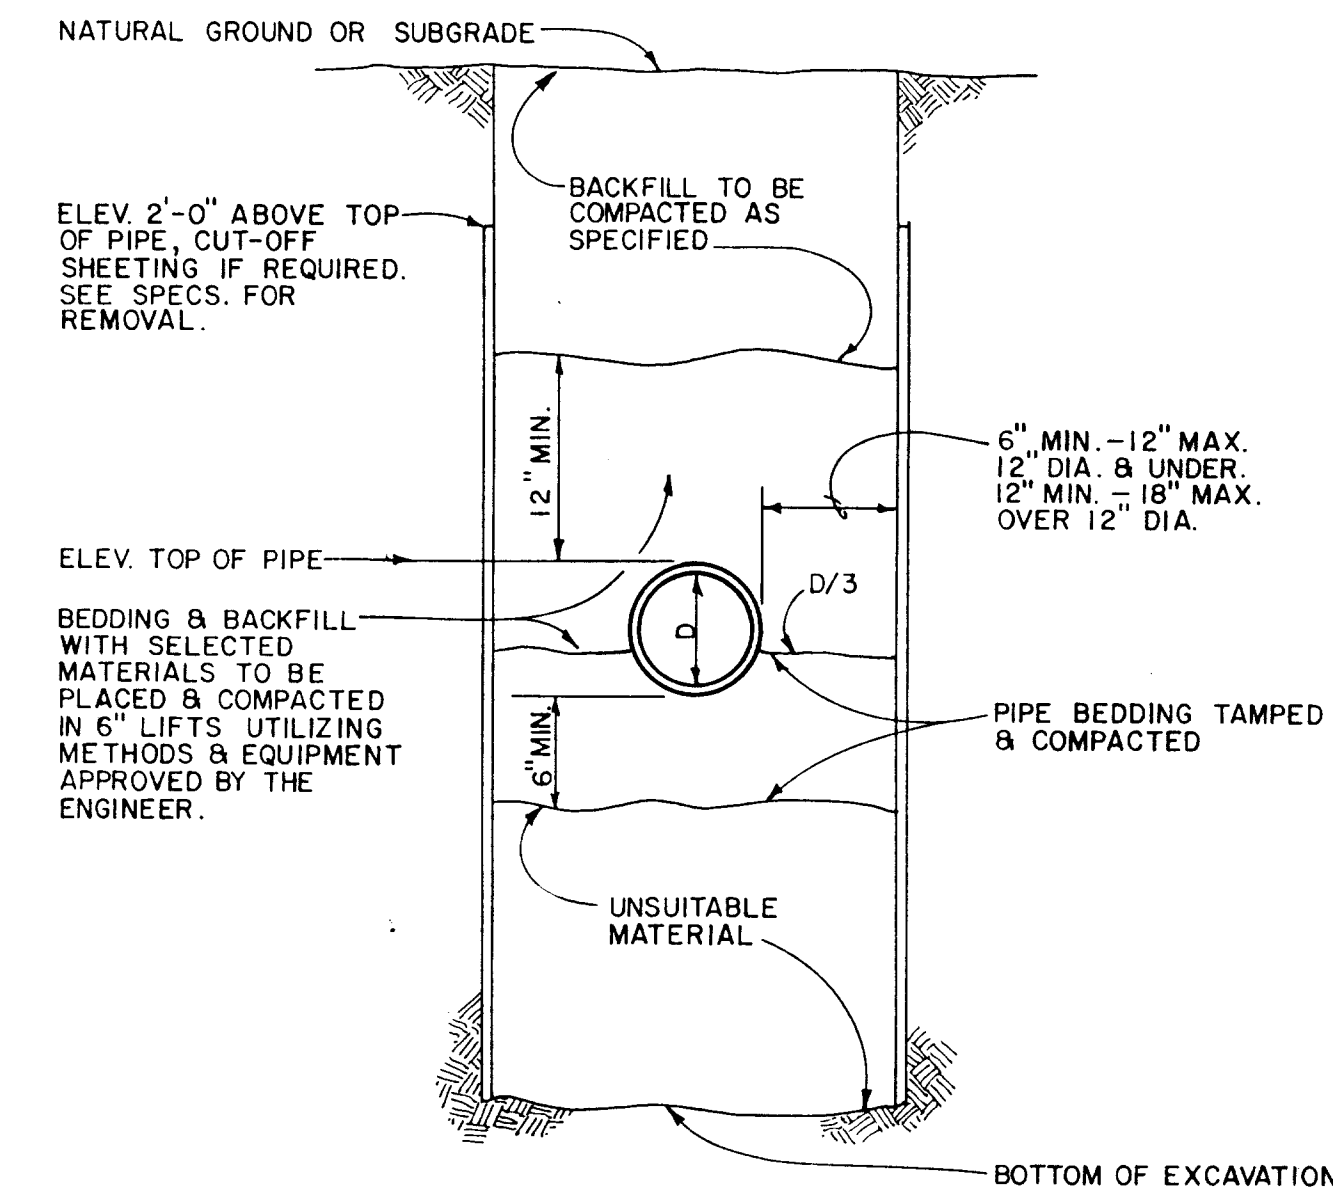

- NOTES:
- FOR TRENCHES IN PAVED AREAS OR AREAS TO RECEIVE NEW PAVEMENT, SEE PAVEMENT SPECIFICATIONS, THIS SHEET.
 - WHERE BACKFILL IS PLACED BELOW WATER LEVEL IN THE TRENCH, THE BACKFILL MATERIAL SHALL BE CAREFULLY AND UNIFORMLY RAMMED AROUND BOTH SIDES OF THE PIPE TO PROPERLY BED AND SUPPORT THE PIPE. NO SPECIFIC DENSITY REQUIRED UNTIL THE FILL HAS REACHED A LEVEL 12 INCHES ABOVE WATER TABLE AT WHICH ELEVATION AND ABOVE, ALL BACKFILL SHALL BE COMPACTED AS SPECIFIED.