



SPECIALTIES

725 SOUTH FRIENDSHIP DRIVE
NEW CONCORD, OHIO 43762
(740) 826-7686
FAX: (740) 826-4948

DWG No.

1546TITL
1546-M1
1546-M2
1546-M3
1546-M4
1546-E1
1546-E2
1546-E3
1546-E4
1546-E5
1546-E6

LIST OF DRAWINGS


Title Sheet
Piping & Instrumentation Diagram
Utility Flare Model PCF1025/10 Plan, Elevation And Details
Recommended Utility Flare Foundation - Plan And Elevation
Electrical Control Rack Plan, Section & Detail
Motor Control Panel, Layout & Electrical Schematic
Flame-Trol I - Cabinet And Panel Layout
Flame-Trol I - Electrical Schematic
Flame-Trol I - Electrical Schematic
Flame-Trol I - Electrical Schematic
Flame-Trol I - Cabling Diagram

LANDFILL GAS UTILITY FLARE SYSTEM TRAIL RIDGE LANDFILL FLORIDA


AS BUILT

LEGEND

PIPING & INSTRUMENT LINE SYMBOLS

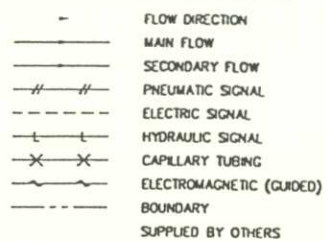

INSTRUMENT OR FUNCTION SYMBOLS

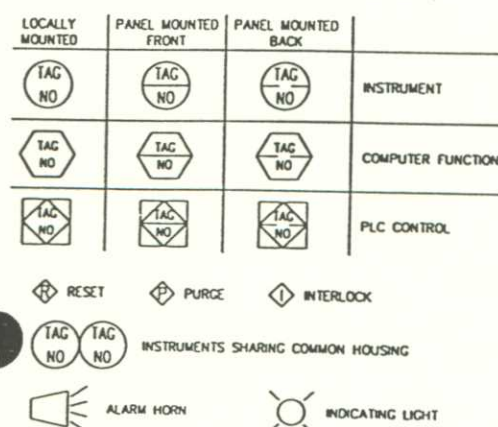

VALVES, REGULATORS, AND OTHER DEVICES




TABLE OF STANDARD IDENTIFICATION LETTERS

	FIRST LETTER	SECOND LETTER	THIRD LETTER	FOURTH LETTER
A	ANALYSIS	ALARM	ALARM	
B	BURNER, COMBUSTION	USER'S CHOICE	CONTROL	
C	CONNECTION	CONTROL	CONTROL	
D	DIFFERENTIAL	DIFFERENTIAL	SENSOR	
E	VOLTAGE	USER'S CHOICE		
F	FLOW RATE	GAUGE		
G	GAUGE	GLASS, VIEWING DEVICE		
H	HAND	USER'S CHOICE	HIGH	HIGH
I	CURRENT (ELECTRICAL)	INDICATOR		
J	POWER	USER'S CHOICE		
K	TIME	CONTROL STATION		
L	LEVEL	LIGHT	LOW	LOW
M	USER'S CHOICE	USER'S CHOICE		
N	USER'S CHOICE	USER'S CHOICE		
O	USER'S CHOICE	ORIFICE, RESTRICTION		
P	PRESSURE, VACUUM	POINT (TEST) CONNECTION		
Q	QUANTITY	INTEGRATE, TOTALIZE		
R	RADIATION	RECORDER		
S	SPEED, FREQUENCY	SAFETY	SWITCH	SWITCH
T	TEMPERATURE	TRANSMIT		
U	MULTIVARIABLE	MULTIFUNCTION	MULTIFUNCTION	MULTIFUNCTION
V	VIBRATION	VALVE, DAMPER, LOUVER		
W	WEIGHT, FORCE	WELL		
X	UNCLASSIFIED	X AXIS	UNCLASSIFIED	UNCLASSIFIED
Y	EVENT, STATE	Y AXIS		
Z	POSITION, DIMENSION	Z AXIS		

ABBREVIATIONS

AS	AIR SUPPLY	LFG	LANDFILL GAS
COND	CONDENSATE	MCC	MOTOR CONTROL CENTER
CPFG	COUPLING	MS	MOTOR STARTER
CS	CARBON STEEL	PS	PIPE STAND/SUPPORT
ES	ELECTRICAL SUPPLY	PVC	POLYVINYL CHLORIDE
ESD	EMERGENCY SHUT DOWN	SC	SAMPLE CONNECTION
GS	GAS SUPPLY	SS	STAINLESS STEEL
HDPE	HIGH DENSITY POLYETHYLENE	WS	WATER SUPPLY
IAS	INSTRUMENT AIR SUPPLY		
KOP	KNOCK-OUT TANK		

**SPECIFIC PURPOSE
“AS - BUILT” SURVEY
OF
TRAIL RIDGE LANDFILL
INCREMENTAL CLOSURE
FOR
TRAIL RIDGE LANDFILL, INC.
AND
CITY OF JACKSONVILLE,
FLORIDA**

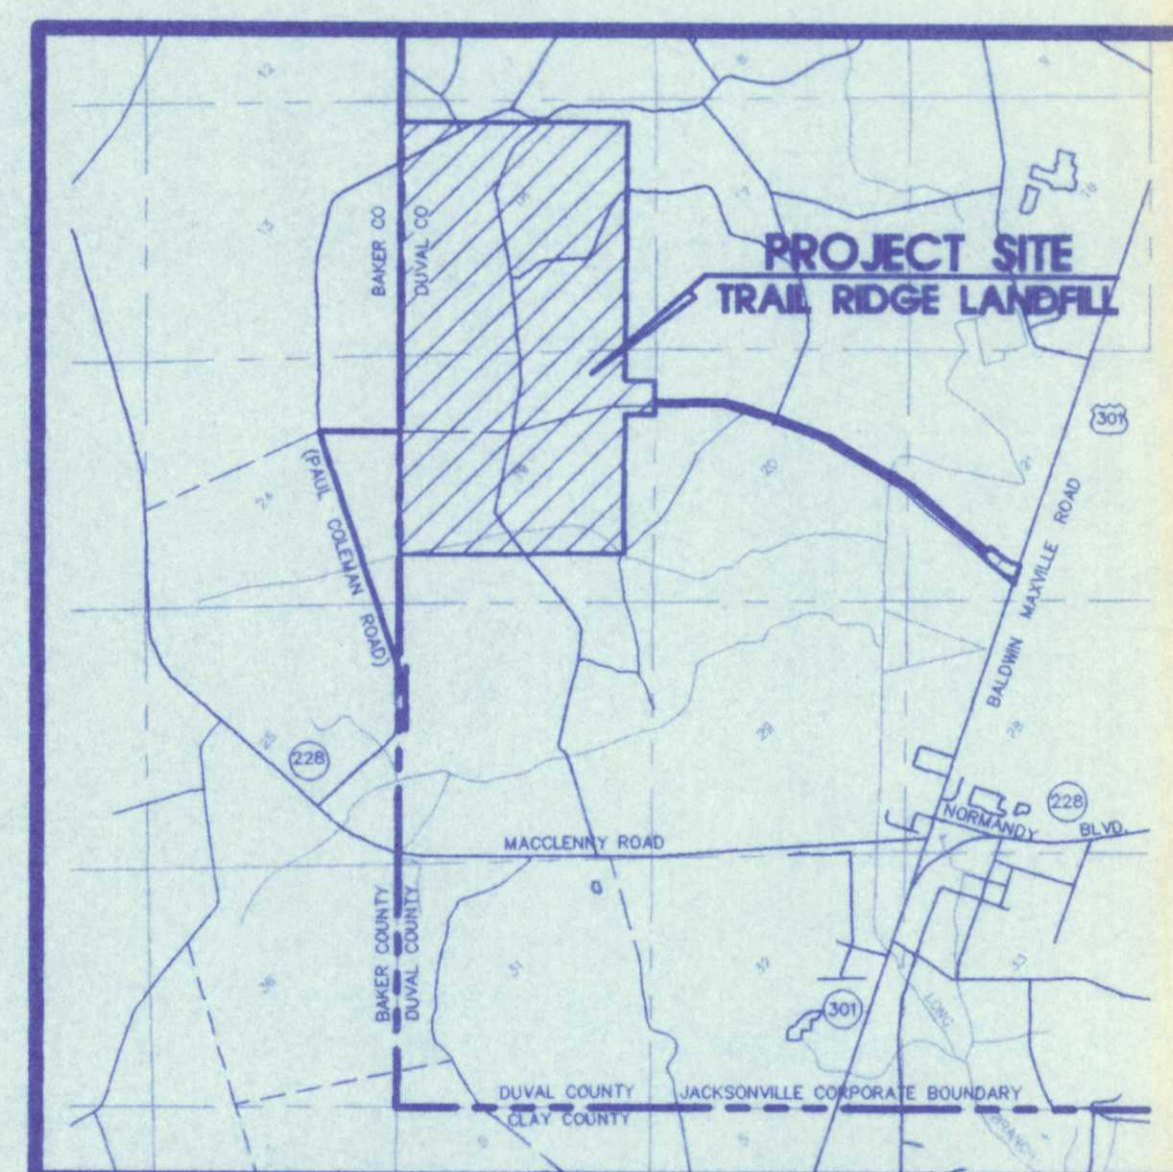

VICINITY MAP



SUNSHINE STATE SURVEYORS INC.

SURVEYORS & LAND PLANNERS 3131 ST. JOHNS BLUFF RD. SOUTH
JACKSONVILLE, FLORIDA 32216
(904) 642-8550

UPDATED: DECEMBER, 1997
UPDATED: AUGUST, 1994
DATE: SEPTEMBER, 1993

INDEX OF DRAWINGS

SHEET NO.	DESCRIPTION
SHEET NUMBER 1	COVER SHEET
SHEET NUMBER 2	KEY MAP

INCREMENTAL CLOSURES

CL-1	SIDE SLOPE UNITS 5 - 8
CL-2	SIDE SLOPE UNITS 5 - 11
CL-3	SIDE SLOPE UNITS 1 - 4
CL-4	SIDE SLOPE UNITS 12 - 17
CL-5	SIDE SLOPE UNITS 18 - 20


INDEX OF DRAWINGS

SHEET NO.	DESCRIPTION
SHEET NUMBER 1	COVER SHEET
SHEET NUMBER 2	KEY MAP

INCREMENTAL CLOSURES

CL-1	SIDE SLOPE UNITS 5 - 8
CL-2	SIDE SLOPE UNITS 5 - 11
CL-3	SIDE SLOPE UNITS 1 - 4
CL-4	SIDE SLOPE UNITS 12 - 17
CL-5	SIDE SLOPE UNITS 18 - 20

I: \LANDFILL\TRAIL\CLOSE\AS-BUILT\keymap Mon Dec 08 15:33:36 1997

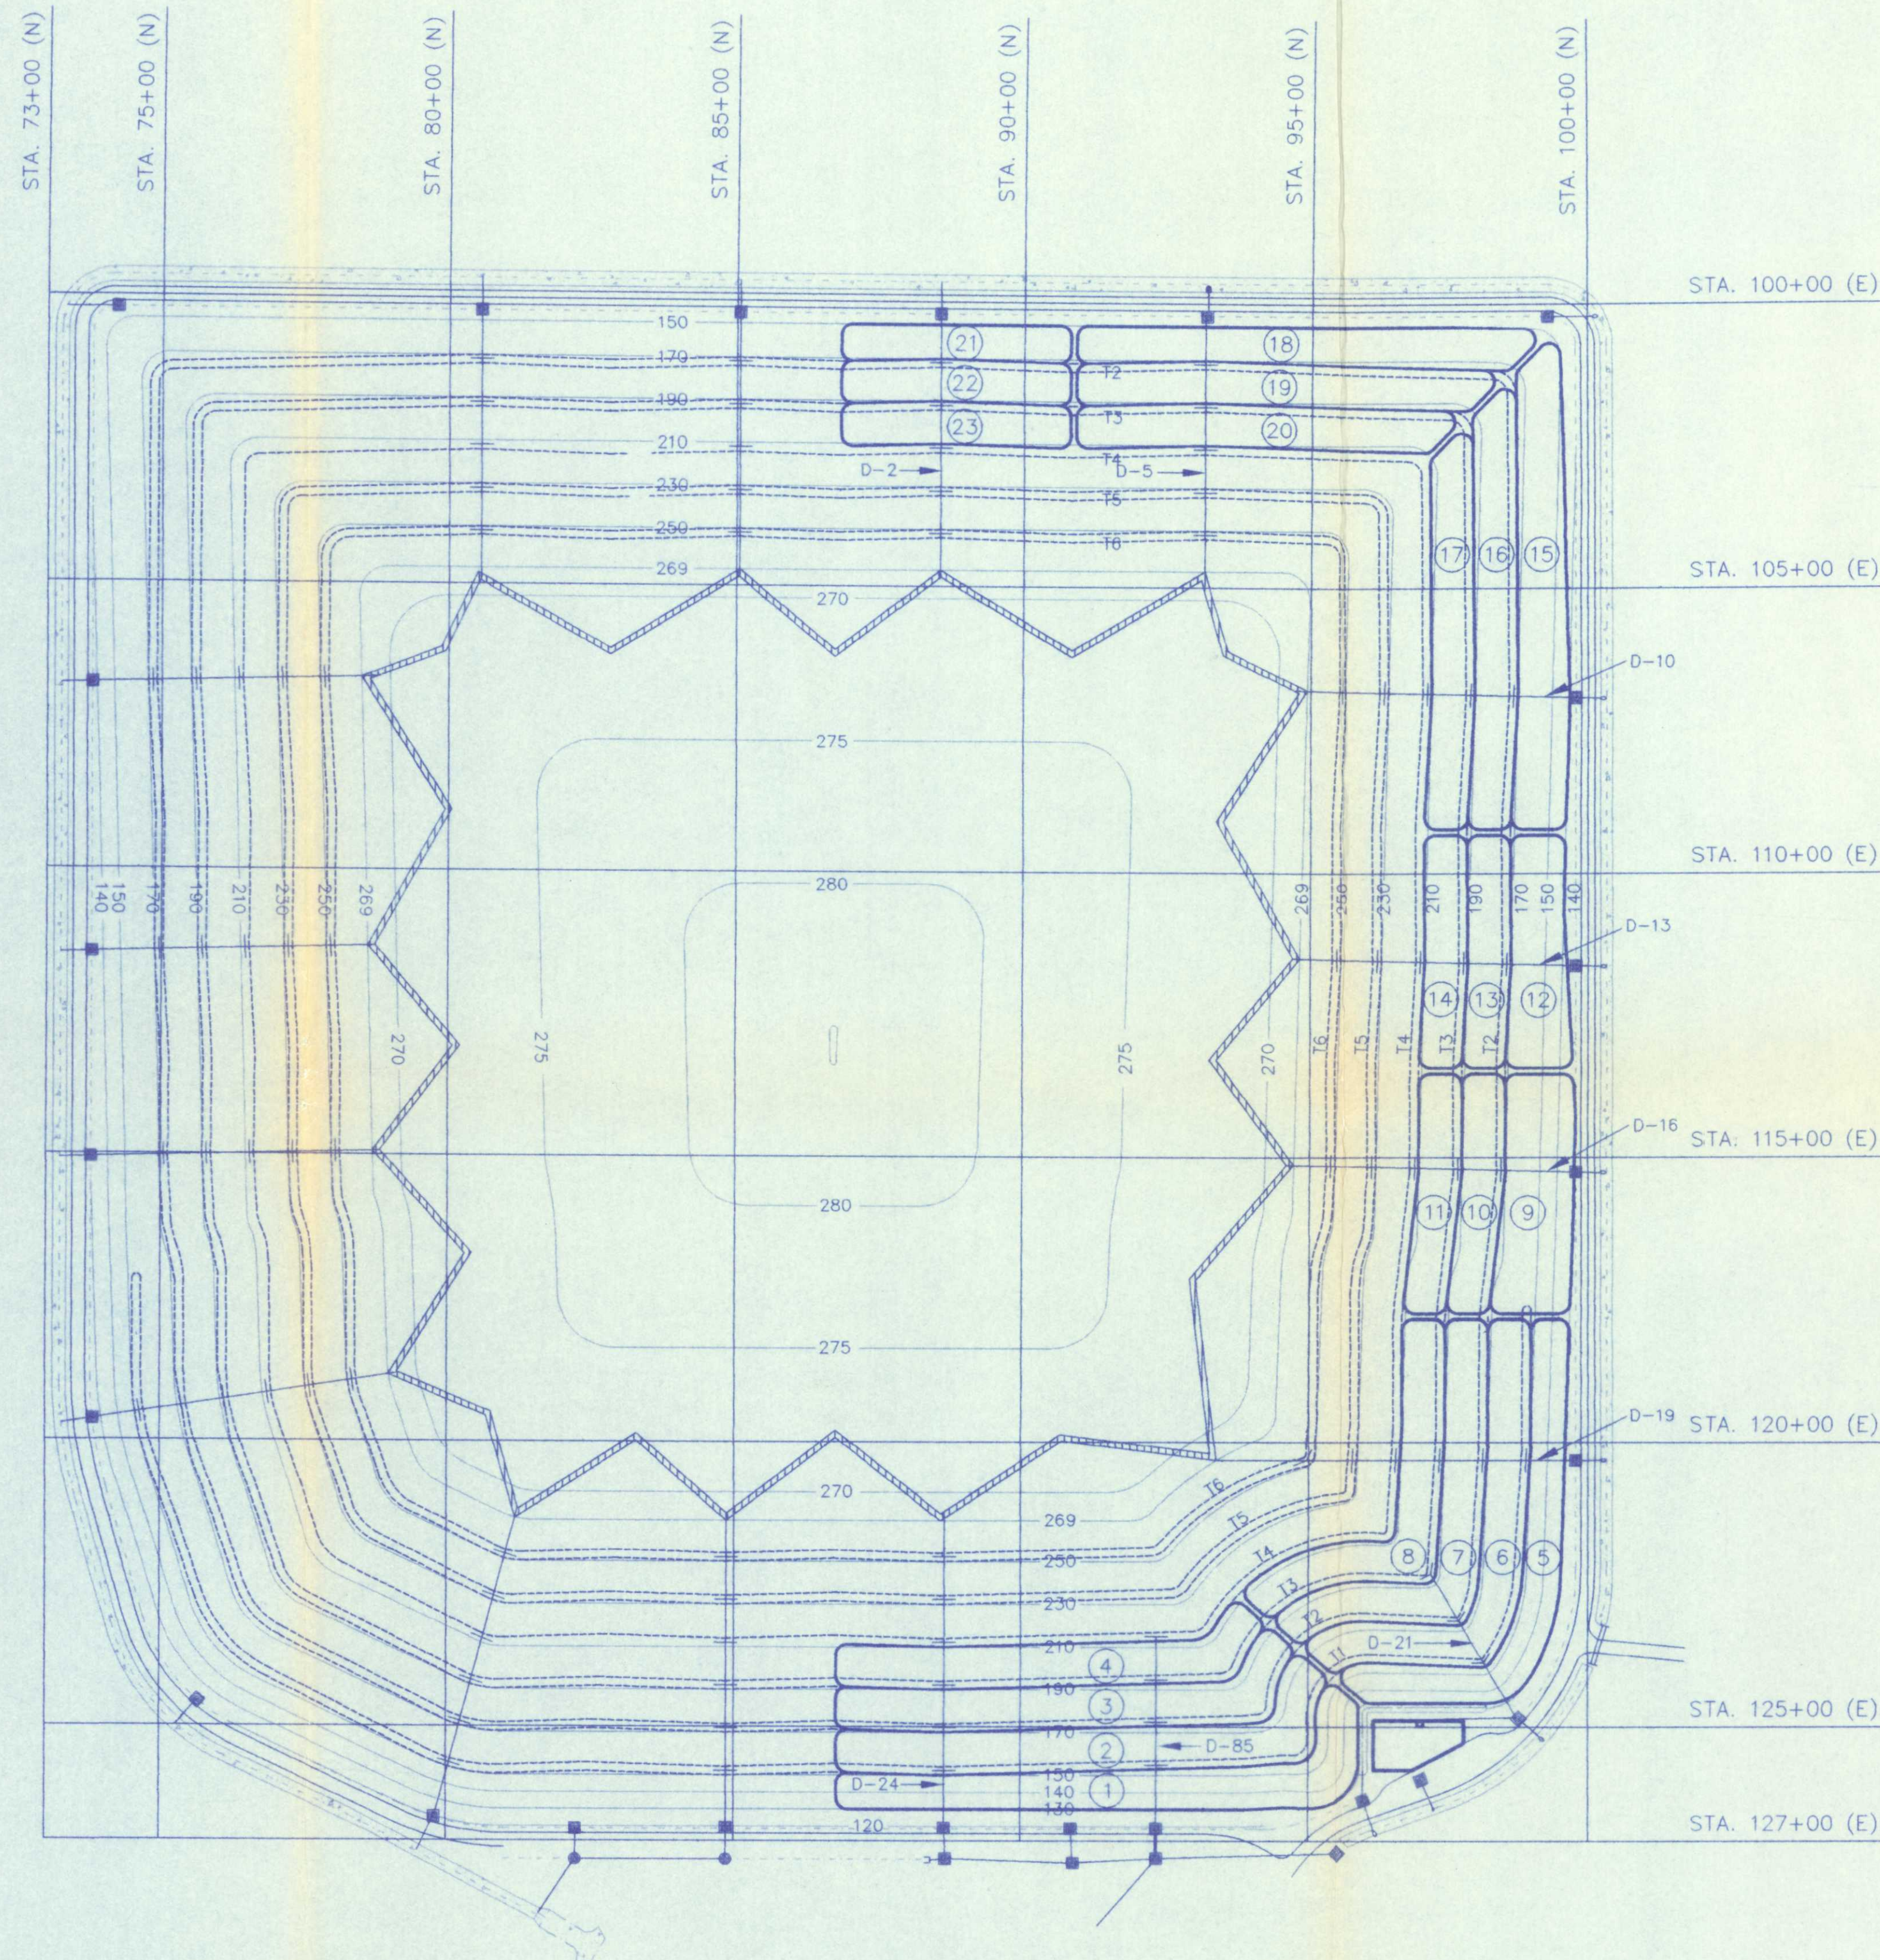

KEY MAP

(NOT TO SCALE)



GENERAL NOTES

- 1.) STATIONING BASED UPON LOCAL GRID AS ESTABLISHED IN ENGINEERING PLANS FOR TRAIL RIDGE LANDFILL BY ENGLAND, THIMS, AND MILLER, INC., FILE NUMBER 91-126-2, DATED JULY 27, 1990.
- 2.) ELEVATIONS BASED ON U.S.C. & G. BENCHMARK AJ-59, LOCATED NEAR THE INTERSECTION OF U.S. HIGHWAY No. 301 AND STATE ROAD No. 228. BENCHMARK ELEVATION: 88.412'.
- 3.) AS-BUILT SURVEYS PERFORMED BY SUNSHINE STATE SURVEYORS INC. PER DATE SHOWN HEREON.
- 4.) HORIZONTAL LOCATION OF EXISTING ROADS, DITCHES, CATCH BASINS, ENDWALLS, RCP PIPES, ACCESS ROADS, UNDERGROUND UTILITIES, 16' SLAG ROAD, AND CONTAINMENT AREA ARE GRAPHIC DEPICTIONS ONLY, TAKEN FROM ENGINEERING PLANS BY ENGLAND, THIMS, AND MILLER, INC., (SEE NOTE #1), AND DO NOT REPRESENT FIELD MEASUREMENTS.
- 5.) DATE OF LAST FIELD WORK: OCTOBER 3, 1997.

LEGEND			
— 25.0 —	FINAL CONTOURS	-----	TERRACE
— D-24 —	DOWNCOMER PIPE (HDPE)	①	SIDE SLOPE UNIT
— D-24 —	DOWNCOMER PIPE NUMBER	T1	TERRACE NUMBER
— —	EXISTING DRAINAGE STRUCTURE	— — — — —	EXISTING PAVED DITCH
— — — — —	DITCH		

SHEET NO. 2

SPECIFIC PURPOSE "AS-BUILT"

SUNSHINE STATE
SURVEYORS, INC.
SURVEYORS & LAND PLANNERS
3131 ST. JOHN BLVD. SUITE 200
JACKSONVILLE, FLORIDA 32206
PHONE: (904) 444-2400
FAX: (904) 444-2401




RECORD
ORDER NO.
CAD FILE: CLOSURE.DWG
DRAWN BY: J.B.C.
CHECKED BY: J.B.C.
SCALE: NOT TO SCALE
RANGE:
COUNTY: DUVAL
FIELD BOOK: 859 & 574
FILE NUMBER: 920-5249

KEY MAP FOR
INCREMENTAL CLOSURE
TRAIL RIDGE LANDFILL
FOR TRAIL RIDGE LANDFILL, INC. AND
CITY OF JACKSONVILLE, FLORIDA

NOT VALID WITHOUT THE SIGNATURE AND THE ORIGINAL RAISED SEAL OF A FLORIDA PROFESSIONAL SURVEYOR AND ENGINEER.

DATE: OCTOBER 3, 1997
JOSEPH L. REYNOLDS, III
FLA REG SURVEYOR NO. 6617

REVISIONS:

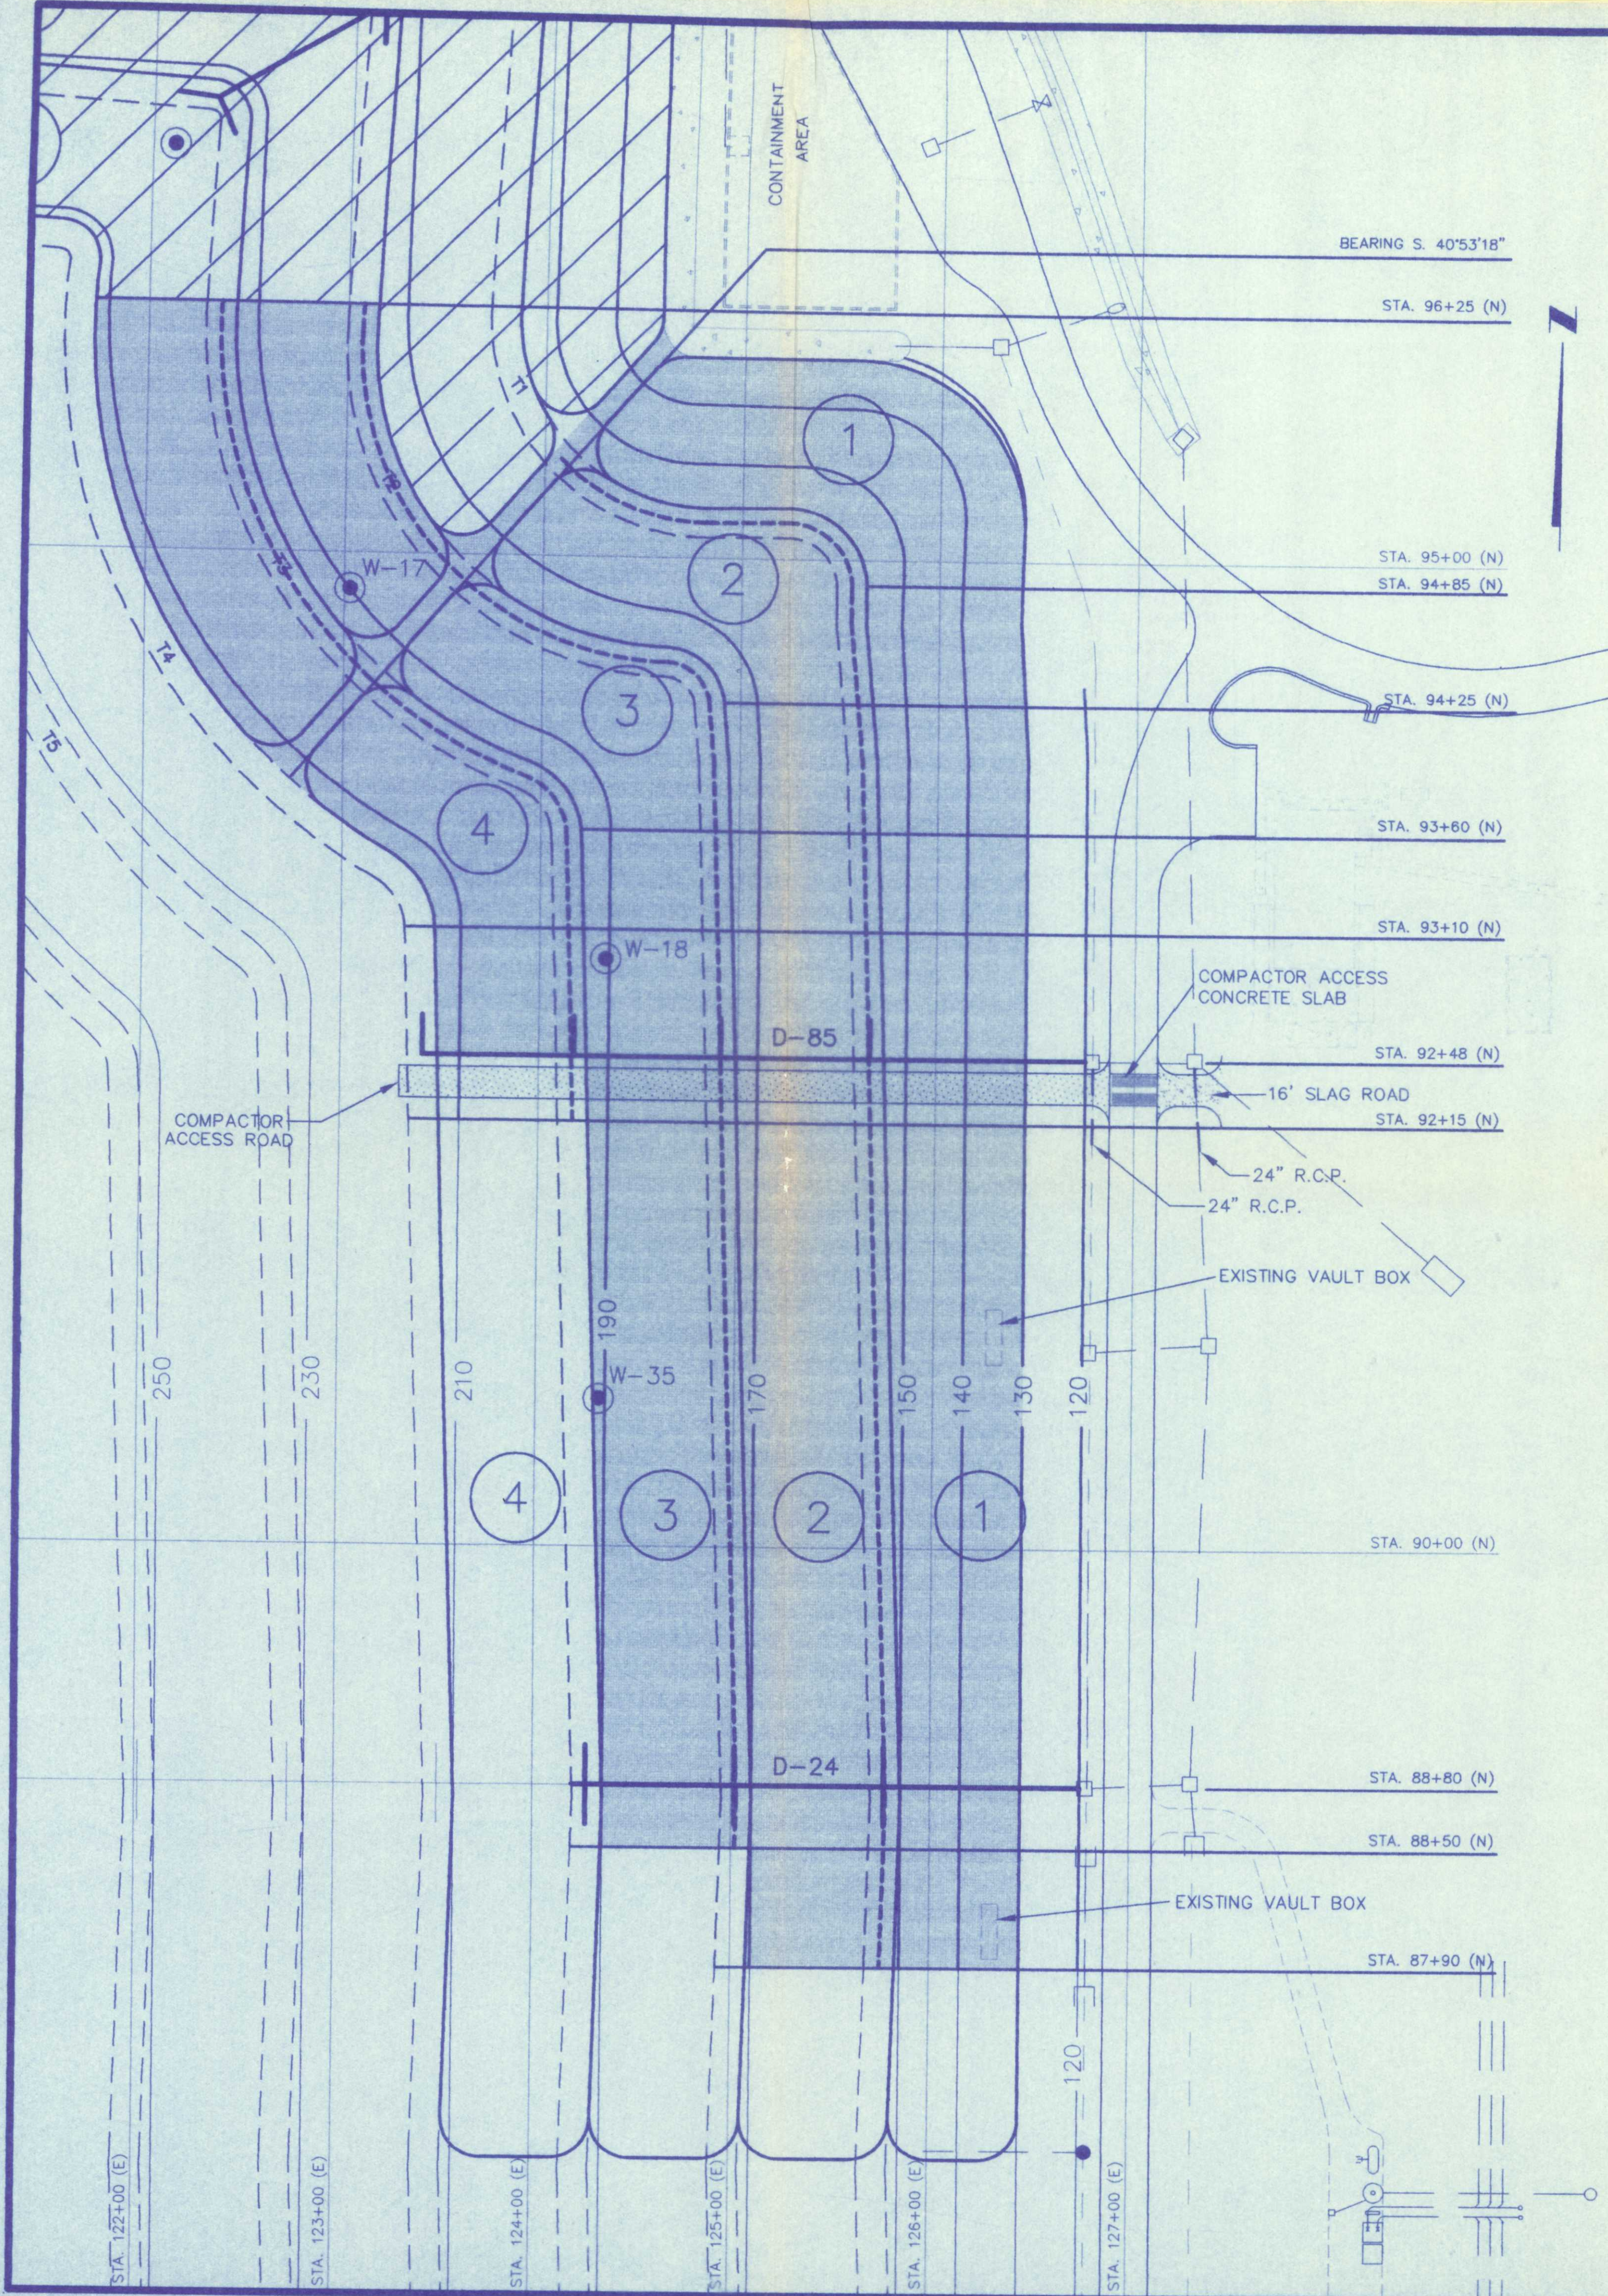

EASTERN SLOPE

LOCATION STATION	INITIAL COVER			FINAL COVER		
	DESIGN	AS-BUILT	DATE	DESIGN	AS-BUILT	DATE
STA. 87+70 N						
ANCHOR BERM						
STA. 126+19.1E	135.68	135.47	6-26-97	138.84	138.87	7-21-97
TERRACE 1				FINAL GRADE ADJUSTED -0.30'		
STA. 125+82.3E	147.94	147.61*	6-26-97	150.60	150.57	7-21-97
STA. 125+74.8E	145.44	145.39	6-26-97	148.10	148.14	7-22-97
TERRACE 2				FINAL GRADE ADJUSTED -0.50'		
STA. 125+07.3E	167.94	167.80	6-26-97	170.40	170.37	7-25-97
STA. 124+99.8E	165.44	165.35	6-26-97	167.90	167.99	9-5-97
STA. 88+50 N						
ANCHOR BERM						
STA. 126+18.7E	135.63	135.34*	6-26-97	138.79	138.84	7-21-97
TERRACE 1				FINAL GRADE ADJUSTED -0.30'		
STA. 125+84.2E	147.14	146.79*	6-26-97	150.00	149.87	7-21-97
STA. 125+76.7E	144.64	144.55	6-26-97	147.50	147.44	7-22-97
TERRACE 2				FINAL GRADE ADJUSTED -0.50'		
STA. 125+09.2E	167.14	167.11	6-26-97	169.80	169.86	7-25-97
STA. 125+01.7E	164.64	164.59	6-26-97	167.30	167.42	9-5-97
TERRACE 3				FINAL GRADE ADJUSTED -0.75'		
STA. 124+34.2E	187.14	186.74*	6-26-97	189.55	189.59	9-5-97
STA. 124+26.7E	184.64	184.16*	7-25-97	187.05	186.95	10-3-97
STA. 88+80 N						
ANCHOR BERM						
STA. 126+18.9E	135.57	133.91*	6-13-97	138.73	138.87	7-21-97
TERRACE 1				FINAL GRADE ADJUSTED -0.30'		
NORTHERN INLET @ STA. 88+95N						
STA. 125+85.1E	146.99	146.99	6-18-97	149.85	149.73	7-21-97
STA. 125+77.6E	144.49	144.43	6-18-97	147.35	147.37	7-21-97
SOUTHERN INLET @ STA. 88+65N						
STA. 125+85.1E	146.99	146.77	6-26-97	149.85	149.75	7-21-97
STA. 125+77.6E	144.49	144.27	6-26-97	147.35	147.36	7-22-97
TERRACE 2				FINAL GRADE ADJUSTED -0.50'		
NORTHERN INLET @ STA. 88+95N						
STA. 125+10.1E	166.99	166.88	6-13-97	169.65	169.70	7-22-97
STA. 125+02.6E	164.49	164.47	6-13-97	167.15	167.04	9-5-97
SOUTHERN INLET @ STA. 88+65N						
STA. 125+10.1E	166.99	166.93	6-26-97	169.65	169.66	7-25-97
STA. 125+02.6E	164.49	164.46	6-26-97	167.15	167.08	9-5-97
TERRACE 3				FINAL GRADE ADJUSTED -0.75'		
NORTHERN INLET @ STA. 88+95N						
STA. 124+35.1E	186.99	186.79	6-13-97	189.40	189.50	9-5-97
STA. 124+27.6E	184.49	184.40	7-25-97	186.90	186.90	9-5-97
SOUTHERN INLET @ STA. 88+65N						
STA. 124+35.1E	186.99	186.69*	6-26-97	189.40	189.34	9-5-97
STA. 124+27.6E	184.49	184.40	7-25-97	186.90	186.91	9-5-97
STA. 92+15 N						
ANCHOR BERM						
STA. 126+19.0E	135.51	135.45	6-18-97	138.67	138.70	7-18-97
TERRACE 1				FINAL GRADE ADJUSTED -0.30'		
STA. 125+74.9E	150.21	149.72*	6-18-97	153.07	153.06	7-18-97
STA. 125+67.4E	147.71	147.58	6-18-97	150.57	150.69	7-22-97
TERRACE 2				FINAL GRADE ADJUSTED -0.50'		
STA. 125+00.2E	170.12	170.09	6-13-97	172.78	172.64	7-22-97
STA. 124+92.7E	167.62	167.59	6-13-97	170.28	170.28	9-5-97
TERRACE 3				FINAL GRADE ADJUSTED -0.75'		
STA. 124+25.7E	190.12	189.89	6-12-97	192.53	192.46	9-5-97
STA. 124+17.7E	187.62	187.31*	6-12-97	190.03	190.00	9-5-97
TERRACE 4				FINAL GRADE ADJUSTED -1.60'		
STA. 123+50.2E	210.12	209.80*	6-12-97	211.68	211.65	10-17-97
STA. 123+42.7E	207.62	207.49	7-9-97	209.18	209.27	10-17-97
STA. 92+48 N - DOWNCOMER						
ANCHOR BERM						
STA. 126+19.5E	135.59	134.31*	6-4-97	138.75	138.84	7-18-97
TERRACE 1				FINAL GRADE ADJUSTED -0.30'		
NORTHERN INLET @ STA. 92+63N						
STA. 125+74.7E	150.69	150.41*	6-4-97	153.55	153.48	7-18-97
STA. 125+67.2E	148.19	147.82*	6-4-97	151.05	151.07	7-21-97
TERRACE 2				FINAL GRADE ADJUSTED -0.50'		
NORTHERN INLET @ STA. 92+63N						
STA. 125+00.0E	170.59	170.49	5-23-97	173.25	173.33	7-21-97
STA. 124+92.5E	168.09	168.04	5-23-97	170.75	170.61	7-25-97
TERRACE 3				FINAL GRADE ADJUSTED -1.00'		
NORTHERN INLET @ STA. 92+63N						
STA. 124+25.0E	190.59	190.20*	6-4-97	192.75	193.09	7-25-97
STA. 124+17.5E	188.09	187.87	5-23-97	190.25	190.17**	8-12-97
TERRACE 4				FINAL GRADE ADJUSTED -1.60'		
NORTHERN INLET @ STA. 92+63N						
STA. 123+50.0E	210.59	210.10*	6-4-97	212.15	212.10	8-12-97
STA. 123+42.5E	208.09	207.89	7-9-97	209.65	209.58	8-12-97

GAS WELLS			
GAS WELL NUMBER	WELL COORDINATES		SURFACE ELEVATION
	NORTH	EAST	
W-17	94+79.89	123+01.40	188.99
W-18	92+96.85	124+33.75	190.34
W-35	90+73.85	124+33.01	189.88

EASTERN SLOPE

LOCATION STATION	INITIAL COVER			FINAL COVER		
	DESIGN	AS-BUILT	DATE	DESIGN	AS-BUILT	DATE
STA. 93+10 N						
ANCHOR BERM						
STA. 126+18.9E	135.86	135.80	6-12-97	138.82	138.86	7-18-97
TERRACE 1				FINAL GRADE ADJUSTED -0.30'		
STA. 125+72.4E	151.15	151.01	6-4-97	154.01	154.05	7-18-97
STA. 125+64.9E	148.61	148.50	6-4-97	151.51	151.65	7-21-97
TERRACE 2				FINAL GRADE ADJUSTED -0.50'		
STA. 124+97.7E	171.05	170.72*	5-23-97	173.71	173.62	7-21-97
STA. 124+90.2E	168.51	168.32	5-23-97	171.21	171.29	7-25-97
TERRACE 3				FINAL GRADE ADJUSTED -1.00'		
STA. 124+22.7E	191.04	190.77*	5-23-97	193.20	193.42	7-25-97
STA. 124+15.2E	188.54	188.50	5-23-97	190.70	190.53**	8-12-97
TERRACE 4				FINAL GRADE ADJUSTED -1.60'		
STA. 123+47.7E	211.04	210.80	5-23-97	212.60	212.20**	8-12-97
STA. 123+40.2E	208.51	208.32	7-9-97	210.10	210.22	8-12-97
STA. 93+60 N						
ANCHOR BERM						
STA. 126+20.4E	135.21	135.18	6-12-97	138.43	138.43	7-18-97
TERRACE 1				FINAL GRADE ADJUSTED -0.30'		
STA. 125+71.3E	151.64	151.43	6-4-97	154.50	154.45	7-18-97
STA. 125+63.8E	149.14	148.88*	6-4-97	152.00	152.12	7-21-97
TERRACE 2				FINAL GRADE ADJUSTED -0.50'		
STA. 124+96.6E	171.55	171.26*	5-23-97	174.21	174.24	7-21-97
STA. 124+89.1E	169.05	168.83	5-23-97	171.71	171.80	7-25-97
TERRACE 3				FINAL GRADE ADJUSTED -1.00'		
STA. 124+21.7E	191.52	191.38	5-23-97	193.68	193.98	7-25-97
STA. 124+14.2E	189.02	188.95	5-23-97	191.18	190.96**	8-12-97
STA. 94+25 N						
ANCHOR BERM						
STA. 126+21.4E	135.07	134.88	6-12-97	139.29	138.59	7-18-97
TERRACE 1				FINAL GRADE ADJUSTED -0.30'		
STA. 125+73.0E	152.28	152.18	6-4-97	155.14	155.24	7-18-97
STA. 125+65.5E	149.78	149.56	6-4-97	152.64	152.73	7-21-97
TERRACE 2				FINAL GRADE ADJUSTED -0.50'		
STA. 124+98.1E	172.24	171.85*	5-23-97	174.90	174.79	7-21-97
STA. 124+90.6E	169.74	169.52	5-23-97	172.40	172.33	7-25-97
STA. 94+85 N						
ANCHOR BERM						
STA. 126+12.4E	136.41	134.76*	6-12-97	139.57	139.59	7-18-97
TERRACE 1				FINAL GRADE ADJUSTED -0.30'		
STA. 125+63.0E	152.87	152.76	6-4-97	155.73	155.83	7-18-97
STA. 125+55.5E	150.37	149.81*	6-4-97	153.23	153.25	7-21-97
BEARING S. 40° 53' 18" W						
TERRACE 1				FINAL GRADE ADJUSTED -0.30'		
STA. 124+11.0E & STA. 95+43.9N	154.54	154.46	6-4-97	157.40	157.40	7-18-97
STA. 124+06.0E & STA. 95+38.2N	152.04	151.81	6-4-97	154.90	155.02	7-21-97
TERRACE 2				FINAL GRADE ADJUSTED -0.50'		
STA. 123+63.5E & STA. 94+89.3N	173.64	173.43	5-23-97	176.30	176.22	7-21-97
STA. 123+58.6E & STA. 94+83.6N	171.14	171.09	6-4-97	173.80	173.79	7-25-97
TERRACE 3				FINAL GRADE ADJUSTED -1.00'		
STA. 123+20.7E & STA. 94+40.0N	192.74	192.53	5-22-97	194.90	195.14	7-25-97
STA. 123+15.7E & STA. 94+34.4N	190.24	190.22	5-22-97	192.40	192.20	8-12-97
TERRACE 4				FINAL GRADE ADJUSTED -1.60'		
STA. 122+73.4E & STA. 93+85.6N	212.04	211.75*	5-22-97	213.60	213.19**	8-12-97
STA. 122+68.4E & STA. 93+79.9N	209.54	209.33	7-9-97	211.10	211.08	8-12-97
STA. 96+25 N						
TERRACE 2				FINAL GRADE ADJUSTED -0.50'		
STA. 123+16.5E	171.84	169.39***	6-18-97	174.70	174.46	7-25-97
STA. 123+09.0E	169.34	167.80***	6-18-97	172.20	172.12	7-25-97
TERRACE 3				FINAL GRADE ADJUSTED -1.00'		
STA. 122+46.0E	190.34	186.82***	6-18-97	192.70	193.07	7-25-97
STA. 122+38.5E	187.84	184.92***	6-18-97	190.20	190.10	8-12-97
TERRACE 4				FINAL GRADE ADJUSTED -1.60'		
STA. 121+75.8E	208.74	203.58***	6-18-97	210.50	210.51	8-12-97
STA. 121+68.3E	206.24	201.42***	6-18-97	208.00	208.05	8-12-97

NOTES:
* ADDITIONAL CLAY WAS ADDED TO AMEND INITIAL COVER. CLAY THICKNESS WAS CHECKED BY ETM OR LAW AND MET OR EXCEEDED 12 INCH THICKNESS.
** TOP SOIL THICKNESS WAS CHECKED BY ETM OR LAW AND MET OR EXCEEDED 24 INCH THICKNESS.
*** THIS IS A TIE-IN SECTION WITH EXISTING CLOSURE. DUE TO SETTLEMENT, THE GRADE WAS LOWERED TO MEET EXISTING CONDITIONS.

LEGEND

—25.0—	FINAL CONTOURS	----	TERRACE
D-24	DOWNCOMER PIPE (HDPE)	---	TERRACE UNDERDRAIN
—□—	DOWNCOMER PIPE NUMBER	①	SIDE SLOPE UNIT
—□—	EXISTING DRAINAGE STRUCTURE	T1	TERRACE NUMBER
—□—	EXISTING PAVED DITCH		LIMITS OF SIDE SLOPE CLOSURE (THIS PROJECT)
—□—	DITCH		CLOSED SIDE SLOPE UNIT (NOT IN THIS PROJECT)
● W-25	GAS WELL		STA.
—□—	REINFORCED CONCRETE PIPE		STATION


SEE SHEET NO. 2 FOR GENERAL NOTES

SHEET NO. CL-3

SPECIFIC PURPOSE
"AS-BUILT"

INCREMENTAL CLOSURE
SIDE SLOPE UNITS 1 - 4
TRAIL RIDGE LANDFILL
FOR TRAIL RIDGE LANDFILL, INC. AND
CITY OF JACKSONVILLE, FLORIDA

SUNSHINE STATE SURVEYORS, INC.
SURVEYORS & LAND PLANNERS
3131 ST. JAMES BLVD. SUITE 200
JACKSONVILLE, FLORIDA 32246
PHONE: (904) 944-8800
FAX: (904) 944-8800

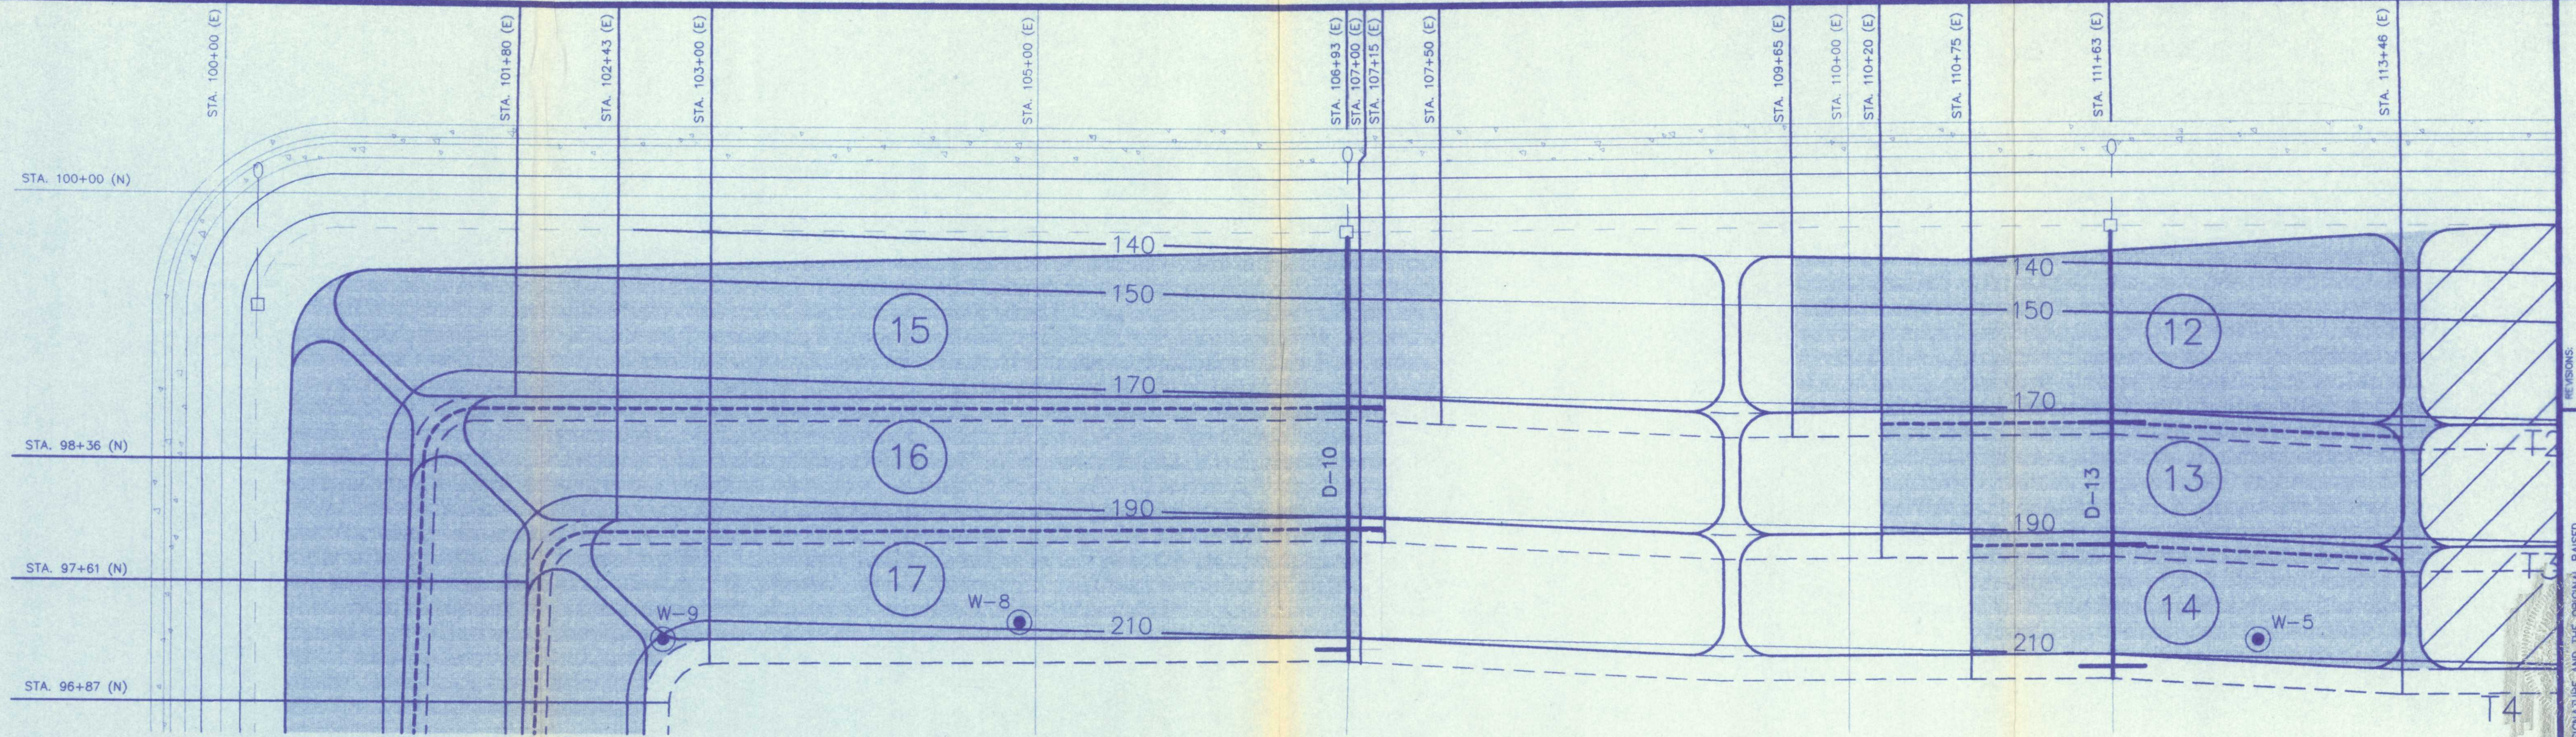

NORTHERN SLOPE

LOCATION STATION	INITIAL COVER			FINAL COVER		
	DESIGN	AS-BUILT	DATE	DESIGN**	AS-BUILT	DATE
STA. 113+26 E						
ANCHOR BERM						
STA. 99+17.8N	147.89	147.95	7-24-97	151.05	151.77	8-25-97
TERRACE 2						
FINAL GRADE ADJUSTED -0.40'						
STA. 98+55.6N	168.44	168.38	7-24-97	171.40	171.44	8-25-97
STA. 98+48.1N	165.94	165.92	7-24-97	168.90	168.98	9-2-97
TERRACE 3						
FINAL GRADE ADJUSTED -0.80'						
STA. 97+80.6N	188.44	188.01*	7-23-97	191.00	191.11	9-2-97
STA. 97+73.1N	185.94	185.81	7-23-97	188.50	188.44	9-8-97
TERRACE 4						
FINAL GRADE ADJUSTED -1.0'						
STA. 97+05.6N	208.44	208.35	7-23-97	210.80	210.85	9-8-97
STA. 96+98.1N	205.94	205.93	7-23-97	208.30	208.20	9-8-97
STA. 111+63 E - DOWNCOMER						
ANCHOR BERM						
STA. 99+17.8N	149.37	148.64*	7-24-97	152.53	153.27	8-25-97
TERRACE 2						
FINAL GRADE ADJUSTED -0.40'						
EASTERN INLET @ STA. 111+78±E						
STA. 98+65.4N	166.99	166.71*	7-24-97	169.75	169.76	8-28-97
STA. 98+57.9N	164.49	164.30	7-24-97	167.25	167.24	9-2-97
WESTERN INLET @ STA. 111+48±E						
STA. 98+65.4N	166.99	166.94	7-24-97	169.75	169.71	8-28-97
STA. 98+57.9N	164.49	164.32	7-24-97	167.25	167.27	9-2-97
TERRACE 3						
FINAL GRADE ADJUSTED -0.80'						
EASTERN INLET @ STA. 111+78±E						
STA. 97+90.4N	186.99	186.91	7-23-97	189.35	189.41	9-2-97
STA. 97+82.9N	184.49	184.43	7-23-97	186.85	186.88	9-8-97
WESTERN INLET @ STA. 111+48±E						
STA. 97+90.4N	186.99	186.87	7-23-97	189.35	189.46	9-2-97
STA. 97+82.9N	184.49	184.13*	7-23-97	186.85	186.80	9-8-97
TERRACE 4						
FINAL GRADE ADJUSTED -1.0'						
EASTERN INLET @ STA. 111+78±E						
STA. 97+15.4N	206.99	206.85	7-23-97	209.15	209.10	9-8-97
STA. 97+07.9N	204.49	204.39	7-23-97	206.65	206.75	9-8-97
WESTERN INLET @ STA. 111+48±E						
STA. 97+15.4N	206.99	206.79	7-23-97	209.15	209.20	9-8-97
STA. 97+07.9N	204.49	204.42	7-23-97	206.65	206.55	9-8-97
STA. 110+75 E						
ANCHOR BERM						
STA. 99+17.8N	150.13	149.85*	7-24-97	153.29	153.79	8-25-97
TERRACE 2						
FINAL GRADE ADJUSTED -0.40'						
STA. 98+65.1N	167.71	167.63	7-24-97	170.47	170.51	8-25-97
STA. 98+57.6N	165.21	165.02	7-24-97	167.97	167.98	9-2-97
TERRACE 3						
FINAL GRADE ADJUSTED -0.80'						
STA. 97+90.1N	187.71	187.57	7-23-97	190.07	190.10	9-2-97
STA. 97+82.6N	185.21	184.68*	7-23-97	187.57	187.47	9-8-97
TERRACE 4						
FINAL GRADE ADJUSTED -1.0'						
STA. 97+15.1N	207.71	207.58	7-23-97	209.87	209.86	9-8-97
STA. 97+07.6N	205.21	204.78*	7-23-97	207.37	207.48	9-8-97
STA. 110+20 E						
ANCHOR BERM						
STA. 99+17.9N	150.58	150.20*	7-24-97	153.74	154.66	8-25-97
TERRACE 2						
FINAL GRADE ADJUSTED -0.40'						
STA. 98+64.9N	168.25	168.18	7-24-97	171.01	170.96	8-25-97
STA. 98+57.4N	165.75	165.57	7-24-97	168.51	168.52	9-2-97
TERRACE 3						
FINAL GRADE ADJUSTED -0.80'						
STA. 97+89.9N	188.25	188.14	7-23-97	190.61	190.66	9-2-97
STA. 97+82.4N	185.75	185.72	7-23-97	188.11	188.04	9-8-97


NORTHERN SLOPE

LOCATION STATION	INITIAL COVER			FINAL COVER		
	DESIGN	AS-BUILT	DATE	DESIGN**	AS-BUILT	DATE
STA. 109+65 E						
ANCHOR BERM						
STA. 99+17.8N	151.09	150.50*	7-24-97	154.25	154.61	8-25-97
TERRACE 2						
FINAL GRADE ADJUSTED -0.40'						
STA. 98+64.6N	168.79	168.61	7-24-97	171.55	171.53	8-25-97
STA. 98+57.1N	166.29	166.16	7-24-97	169.05	168.96	10-2-97
STA. 107+50 E						
ANCHOR BERM						
STA. 99+17.1N	153.15	153.02	7-30-97	156.31	156.25	8-28-97
TERRACE 2						
STA. 98+74.2N	167.44	167.29	7-30-97	170.60	170.55	8-28-97
STA. 98+66.7N	164.94	164.79	7-30-97	168.10	168.03	9-18-97
STA. 107+15 E						
ANCHOR BERM						
STA. 99+17.3N	153.39	153.39	7-30-97	156.55	156.79	8-28-97
TERRACE 2						
STA. 98+76.3N	167.07	166.91	7-30-97	170.23	170.30	8-28-97
STA. 98+68.8N	164.57	164.46	7-30-97	167.73	167.83	9-2-97
TERRACE 3						
FINAL GRADE ADJUSTED -0.80'						
STA. 98+01.3N	187.07	186.72*	7-30-97	189.43	189.50	9-2-97
STA. 97+93.8N	184.57	184.39	7-30-97	186.93	186.97	9-18-97
STA. 106+93 E - DOWNCOMER						
ANCHOR BERM						
STA. 99+17.3N	153.54	151.23	7-30-97	156.70	157.48	8-28-97
TERRACE 2						
EASTERN INLET @ STA. 107+08E						
STA. 98+77.5N	166.99	166.88	7-30-97	170.15	170.28	8-28-97
STA. 98+70.0N	164.49	164.33	7-30-97	167.65	167.73	9-2-97
WESTERN INLET @ STA. 106+78E						
STA. 98+77.5N	166.99	166.97	7-30-97	170.15	170.24	8-28-97
STA. 98+70.0N	164.49	164.46	7-30-97	167.65	167.55	9-2-97
TERRACE 3						
FINAL GRADE ADJUSTED -0.80'						
EASTERN INLET @ STA. 107+08E						
STA. 98+02.5N	186.99	186.78	7-30-97	189.35	189.37	9-2-97
STA. 97+95.0N	184.49	184.49	7-30-97	186.85	186.67**	9-18-97
WESTERN INLET @ STA. 106+78E						
STA. 98+02.5N	186.99	186.88	7-30-97	189.35	189.44	9-2-97
STA. 97+95.0N	184.49	184.28	7-30-97	186.85	186.39**	9-18-97
TERRACE 4						
FINAL GRADE ADJUSTED -0.80'						
WESTERN INLET @ STA. 106+78E						
STA. 97+27.5N	206.99	206.78	7-30-97	209.35	209.30	9-18-97
STA. 97+20.0N	204.49	204.37	7-30-97	206.85	205.99**	9-18-97
STA. 103+00 E						
ANCHOR BERM						
STA. 99+17.4N	156.94	156.69*	7-30-97	160.10	160.24	8-28-97
TERRACE 2						
STA. 98+74.5N	171.24	171.22	7-30-97	174.40	174.53	8-28-97
STA. 98+67.0N	168.74	168.64	7-30-97	171.90	171.99	9-2-97
TERRACE 3						
FINAL GRADE ADJUSTED -0.80'						
STA. 97+99.5N	191.24	190.99*	7-30-97	193.60	193.65	9-2-97
STA. 97+92.0N	188.74	188.58	7-30-97	191.10	191.15	9-18-97
TERRACE 4						
FINAL GRADE ADJUSTED -0.80'						
STA. 97+25.4N	210.94	210.62	7-30-97	213.30	213.21	9-18-97
STA. 97+17.9N	208.44	208.26	7-30-97	210.80	210.73	9-18-97

NORTHERN SLOPE

LOCATION STATION	INITIAL COVER			FINAL COVER		
	DESIGN	AS-BUILT	DATE	DESIGN**	AS-BUILT	DATE
STA. 102+43 E						
ANCHOR BERM						
STA. 99+17.4N	157.40	157.15*	7-30-97	160.56	160.68	8-28-97
TERRACE 2						
STA. 98+73.9N	171.91	171.88	7-30-97	175.07	174.95	8-28-97
STA. 98+66.4N	169.41	169.36	7-30-97	172.57	172.50	9-2-97
TERRACE 3						
FINAL GRADE ADJUSTED -0.80'						
STA. 97+99.1N	191.84	191.64	7-30-97	194.20	194.13	9-2-97
STA. 97+91.6±N	189.34	188.95*	7-30-97	191.70	191.74	10-2-97
STA. 101+80 E						
ANCHOR BERM						
STA. 99+17.4N	157.93	157.78	7-30-97	161.09	161.07	9-16-97
TERRACE 2						
STA. 98+73.2N	172.64	172.57	7-30-97	175.80	175.73	9-16-97
STA. 98+65.7N	170.14	170.04	7-30-97	173.30	173.30	10-2-97
<u>NOTES:</u>						
* ADDITIONAL CLAY WAS ADDED TO AMEND INITIAL COVER. CLAY THICKNESS WAS CHECKED BY ETM OR LAW AND MET OR EXCEEDED 12 INCH THICKNESS.						
** TOP SOIL THICKNESS WAS CHECKED BY ETM OR LAW AND MET OR EXCEEDED 24 INCH THICKNESS.						

I: LANDFILL TRAIL CLOSURE AS-BUILT CL-5 3 Mon Dec 08 14:47:12 1997

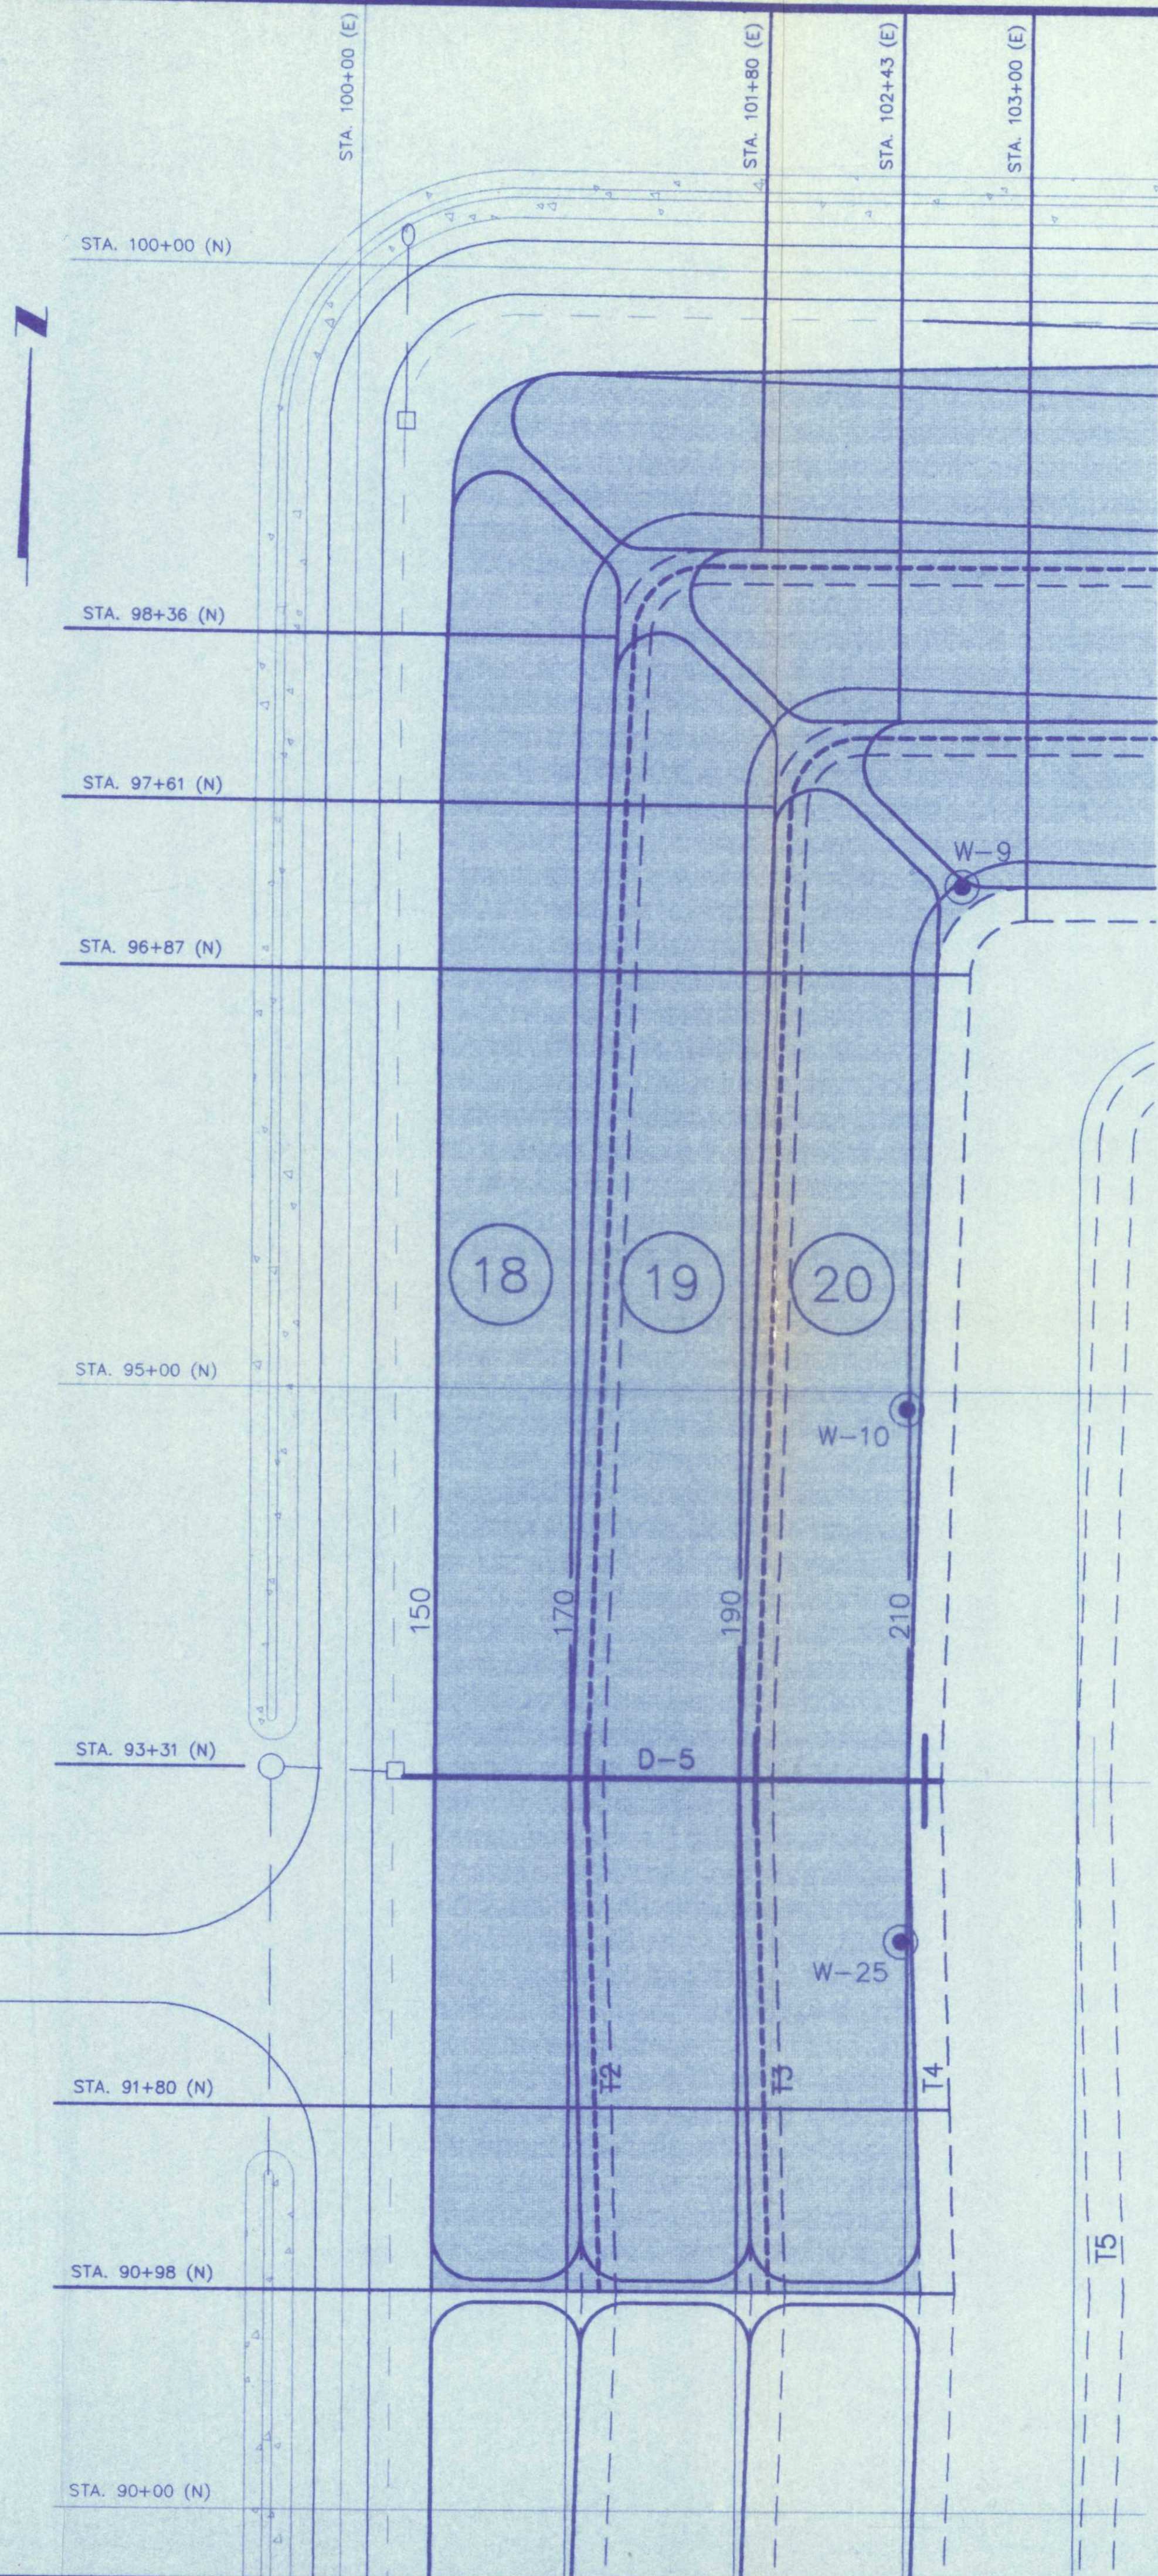

WESTERN SLOPE

STATION LOCATION	INITIAL COVER			FINAL COVER		
	DESIGN	AS-BUILT	DATE	DESIGN	AS-BUILT	DATE
STA. 90+98 N						
ANCHOR BERM						
STA. 100+80.1E	160.31	160.30	9-10-97	163.47	163.36	9-16-97
TERRACE 2						
STA. 101+06.6E	169.14	169.12	9-10-97	172.30	172.21	9-16-97
STA. 101+14.1E	166.64	166.10	9-10-97	169.80	169.75	10-2-97
TERRACE 3						
STA. 101+81.6E	189.14	189.11	9-10-97	192.30	192.28	10-2-97
STA. 101+89.1E	186.64	186.35	9-10-97	189.80	189.84	10-2-97
TERRACE 4						
FINAL GRADE ADJUSTED -1.00'						
STA. 102+56.6E	209.14	209.12	9-18-97	211.30	211.22	10-2-97
STA. 102+64.1E	206.64	206.61	9-18-97	208.80	208.82	10-2-97
STA. 91+80 N						
ANCHOR BERM						
STA. 100+79.5E	160.35	160.33	9-10-97	163.51	163.59	9-16-97
TERRACE 2						
STA. 101+03.5E	168.34	168.24	9-10-97	171.50	171.43	9-16-97
STA. 101+11.0E	165.84	165.81	9-10-97	169.00	168.95	10-2-97
TERRACE 3						
STA. 101+78.5E	188.34	188.27	9-10-97	191.50	191.46	10-2-97
STA. 101+86.0E	185.84	185.73	9-10-97	189.00	189.06	10-2-97
TERRACE 4						
FINAL GRADE ADJUSTED -1.00'						
STA. 102+53.5E	208.34	208.23	9-10-97	210.50	210.45	10-2-97
STA. 102+61.0E	205.84	205.79	9-10-97	208.00	207.92	10-2-97
STA. 93+31 N - DOWNCOMER						
ANCHOR BERM						
STA. 100+80.4E	160.39	160.37	9-5-97	163.55	164.30	10-2-97
TERRACE 2						
NORTHERN INLET @ STA. 93+46N						
STA. 100+99.7E	166.99	166.98	9-5-97	170.15	170.23	10-2-97
STA. 101+07.2E	164.49	164.45	9-5-97	167.65	167.60	10-2-97
SOUTHERN INLET @ STA. 93+16N						
STA. 100+99.7E	166.99	166.94	9-10-97	170.15	170.07	10-2-97
STA. 101+07.2E	164.49	164.37	9-10-97	167.65	167.53	10-2-97
TERRACE 3						
NORTHERN INLET @ STA. 93+46N						
STA. 101+74.7E	186.99	186.97	9-5-97	190.15	190.22	10-2-97
STA. 101+82.2E	184.49	184.40	9-5-97	187.65	187.61	10-2-97
SOUTHERN INLET @ STA. 93+16N						
STA. 101+74.7E	186.99	186.95	9-10-97	190.15	190.16	10-2-97
STA. 101+82.2E	184.49	184.45	9-10-97	187.65	187.62	10-2-97
TERRACE 4						
FINAL GRADE ADJUSTED -1.00'						
NORTHERN INLET @ STA. 93+46N						
STA. 102+49.7E	206.99	206.97	9-5-97	209.15	209.10	10-2-97
STA. 102+57.2E	204.49	204.45	9-5-97	206.65	206.68	10-2-97
SOUTHERN INLET @ STA. 93+16N						
STA. 102+49.7E	206.99	206.97	9-10-97	209.15	209.23	10-2-97
STA. 102+57.2E	204.49	204.44	9-10-97	206.65	206.54	10-2-97
STA. 96+87 N						
ANCHOR BERM						
STA. 100+80.1E	160.31	160.30	9-5-97	163.47	163.44	9-16-97
TERRACE 2						
STA. 101+10.5E	170.44	170.32	9-5-97	173.60	173.62	9-16-97
STA. 101+18.0E	167.94	167.92	9-5-97	171.10	171.13	10-2-97
TERRACE 3						
STA. 101+85.5E	190.44	190.22	9-5-97	193.60	193.56	10-2-97
STA. 101+93.0E	187.94	187.84	9-5-97	191.10	191.12	10-2-97
TERRACE 4						
FINAL GRADE ADJUSTED -1.00'						
STA. 102+60.5E	210.44	210.41	9-5-97	212.60	212.68	10-2-97
STA. 102+68.0E	207.94	207.84	9-5-97	210.10	210.12	10-2-97
STA. 97+61 N						
ANCHOR BERM						
STA. 100+80.1E	160.31	160.28	9-5-97	163.47	163.42	9-16-97
TERRACE 2						
STA. 101+12.6E	171.14	171.10	9-5-97	174.30	174.22	9-16-97
STA. 101+20.1E	168.64	168.60	9-5-97	171.80	171.71	10-2-97
TERRACE 3						
STA. 101+87.6E	191.14	191.12	9-5-97	194.30	194.18	10-2-97
STA. 101+95.1E	188.64	188.57	9-5-97	191.80	191.76	10-2-97
STA. 98+36 N						
ANCHOR BERM						
STA. 100+80.1E	159.75	159.58	9-5-97	162.91	162.93	9-16-97
TERRACE 2						
STA. 101+16.7E	171.94	171.84	9-5-97	175.10	175.08	9-16-97
STA. 101+24.2E	169.44	169.33	9-5-97	172.60	172.63	10-2-97

GAS WELLS

GAS WELL NUMBER	WELL COORDINATES		SURFACE ELEVATION
	NORTH	EAST	
W-10	94+92.90	102+49.35	209.19
W-25	92+55.31	102+45.78	208.64

LEGEND

—25.0—	FINAL CONTOURS	-----	TERRACE
D-24	DOWNCOMER PIPE (HDPE)	-----	TERRACE UNDERDRAIN
—	DOWNCOMER PIPE NUMBER	①	SIDE SLOPE UNIT
—	EXISTING DRAINAGE STRUCTURE	T1	TERRACE NUMBER
—	EXISTING PAVED DITCH		LIMITS OF SIDE SLOPE CLOSURE (THIS PROJECT)
—	—		CLOSED SIDE SLOPE UNIT (NOT IN THIS PROJECT)
●	W-25 GAS WELL	STA.	STATION
—	R.C.P. REINFORCED CONCRETE PIPE		

SEE SHEET NO. 2 FOR GENERAL NOTES

SHEET NO. CL-5

SPECIFIC PURPOSE "AS-BUILT"

SUNSHINE STATE SURVEYORS, INC.
SURVEYORS & LAND PLANNERS
331 ST. JOHNS BLVD. S.W.
JACKSONVILLE, FLORIDA 32246
PHONE NUMBER (904) 942-6660
FAX NUMBER (904) 942-3485



RECORD
ORDER NO.
CAD FILE: CLOSURE.DWG
DRAWN BY: J.B.C.
CHECKED BY: J.B.C.
SCALE: 1" = 50'
RANGE:
COUNTY: DUVAL
FIELD BOOK: 859 & 874
FILE NUMBER: 922-5248

**INCREMENTAL CLOSURE
SIDE SLOPE UNITS 18 - 20**
TRAIL RIDGE LANDFILL
FOR TRAIL RIDGE LANDFILL, INC. AND
CITY OF JACKSONVILLE, FLORIDA

NOT VALID WITHOUT THE SIGNATURE AND THE ORIGINAL RAISED SEAL OF A FLORIDA PROFESSIONAL SURVEYOR AND MAPPER.

DATE: OCTOBER 3, 1997


JOSEPH LESLIE REYNOLDS, III
FLA. REG. SURVEYOR NO. 5517

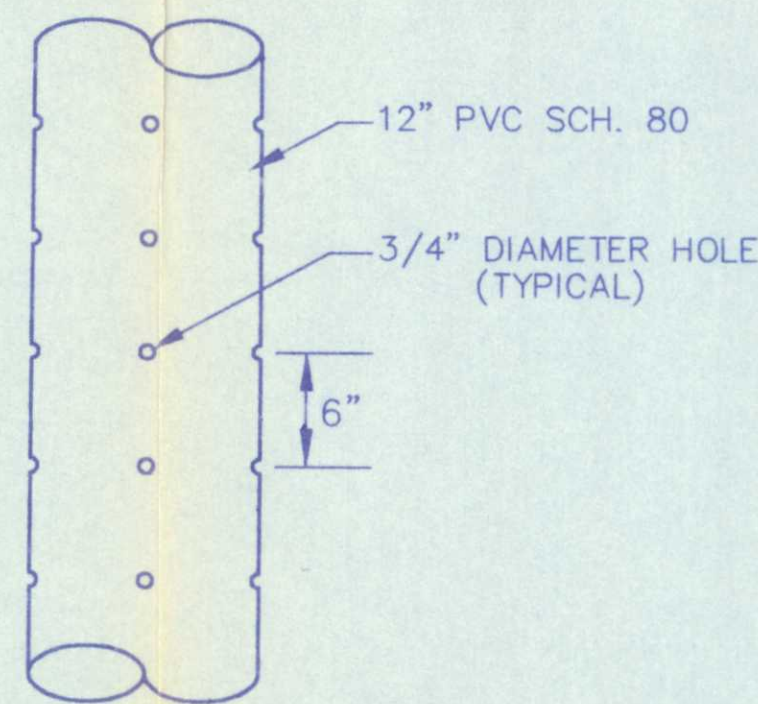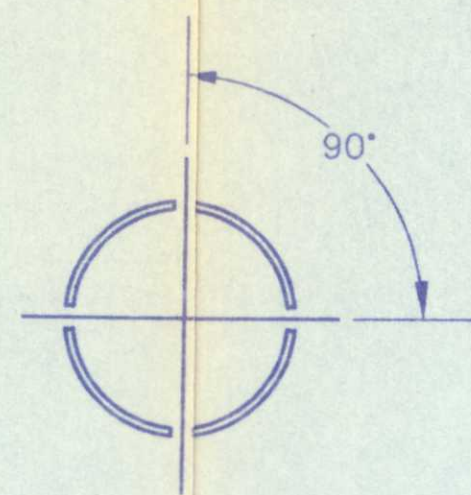

PERFORATED PIPE DETAIL

N.T.S.


D15
20/20

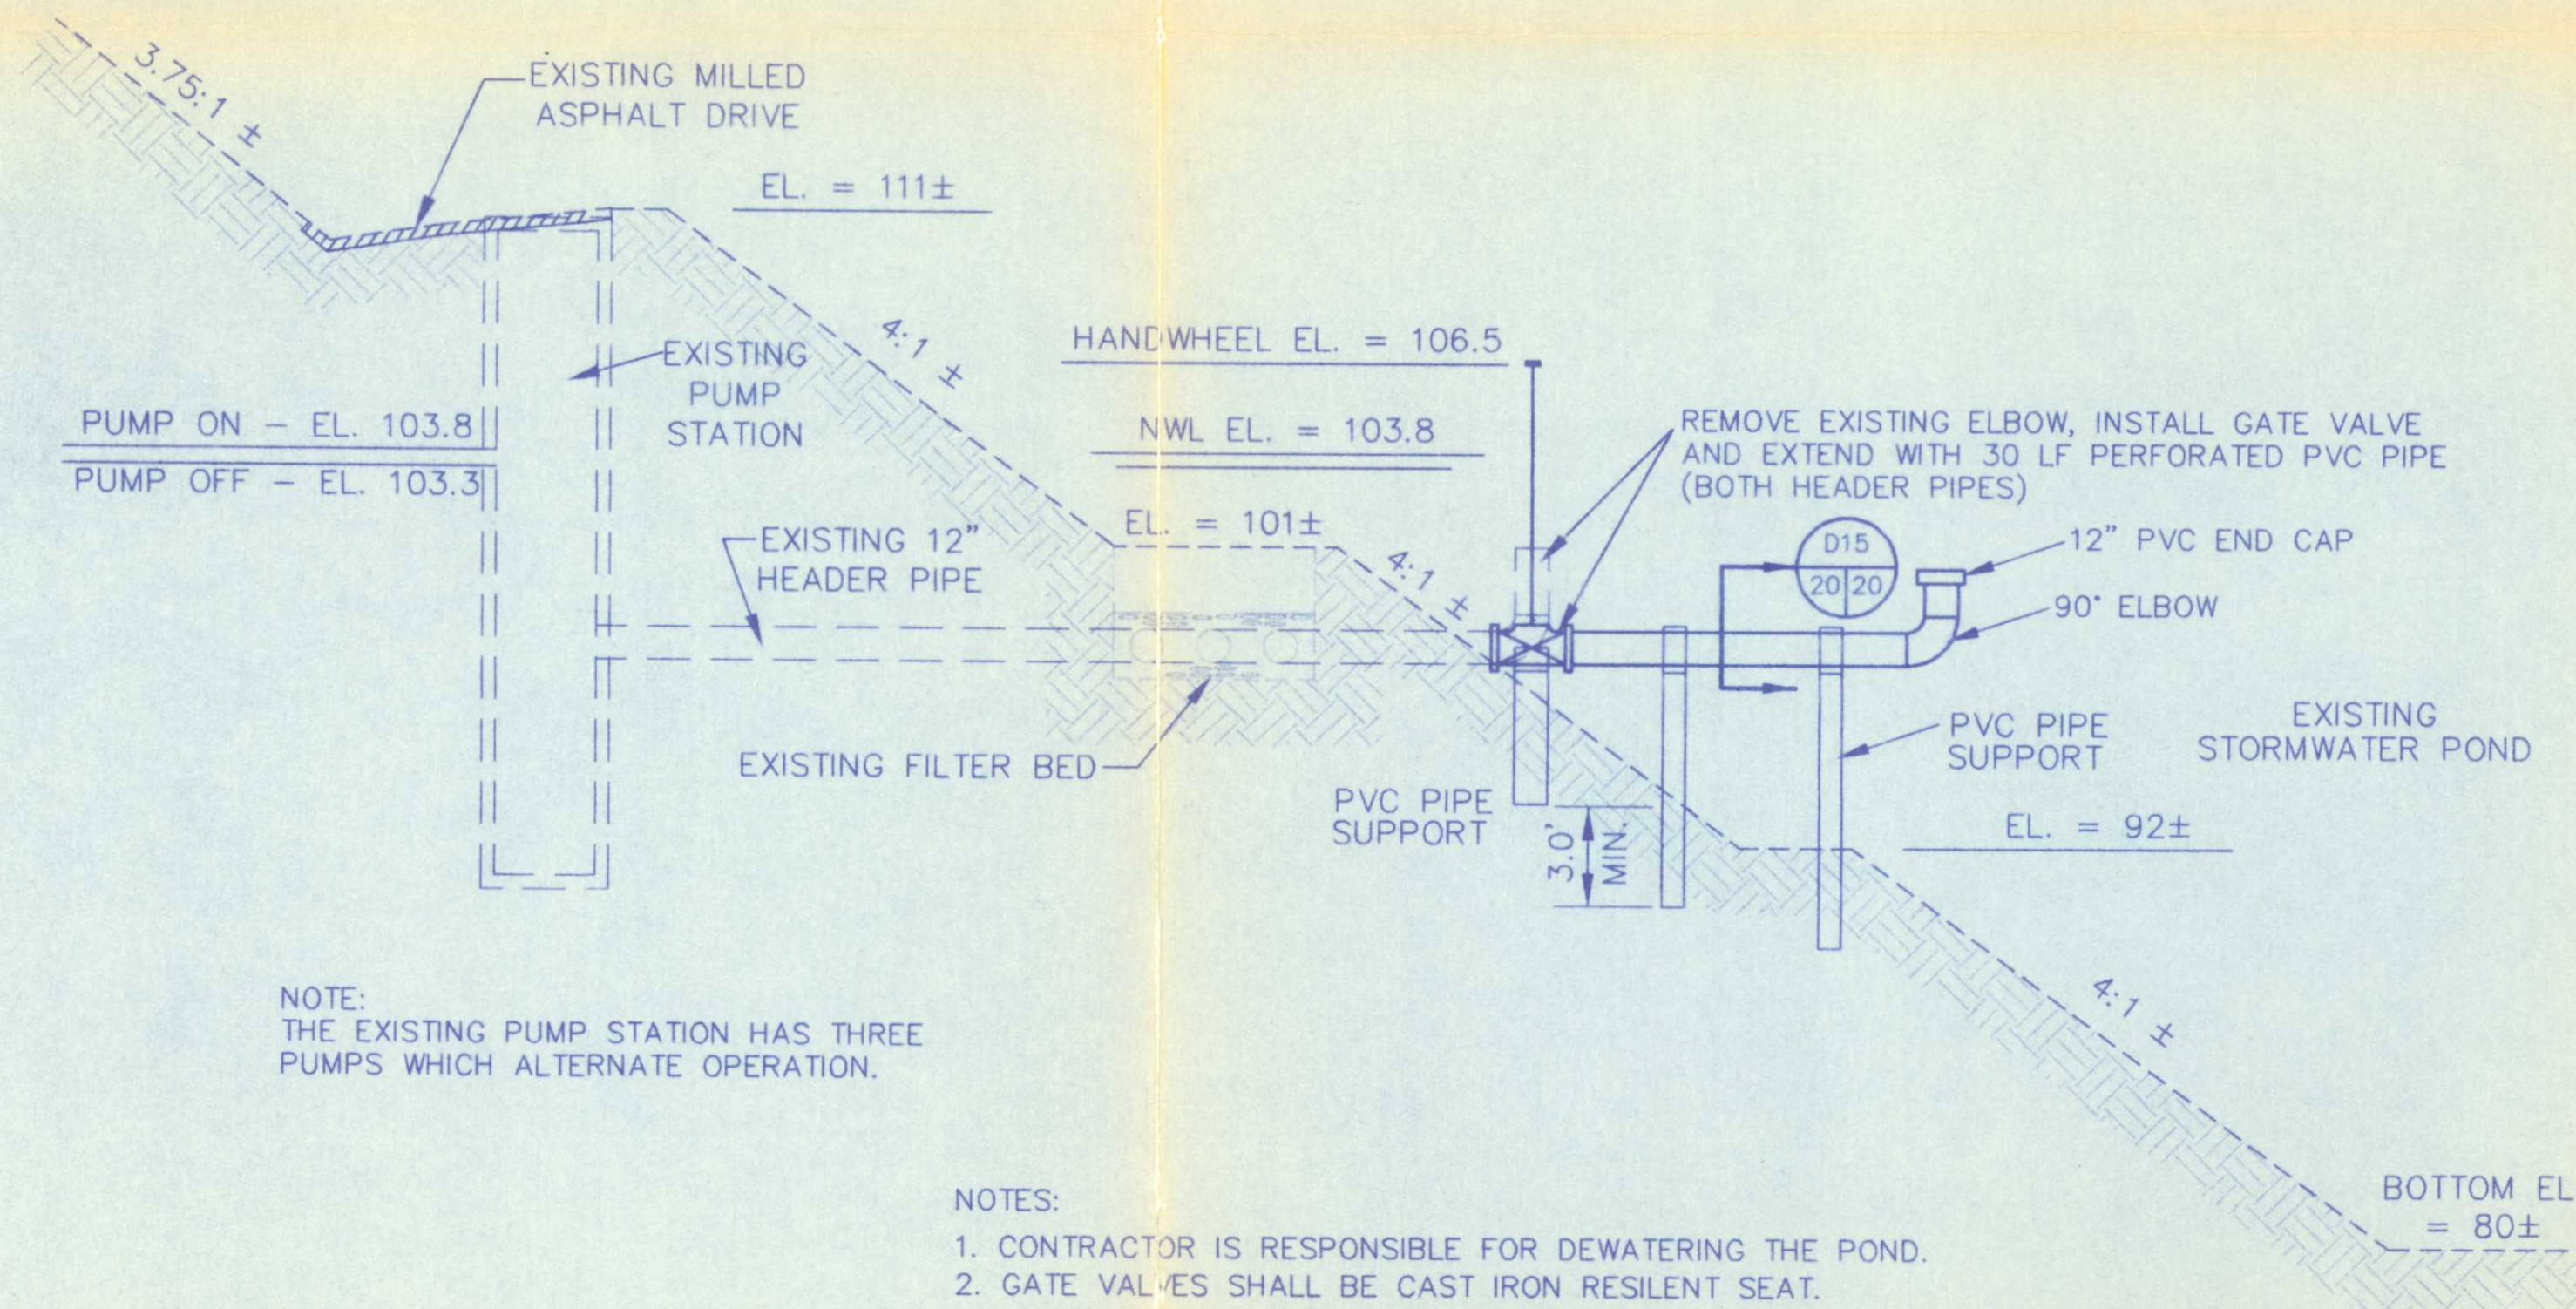

CROSS SECTION

N.T.S.

D13
20/20

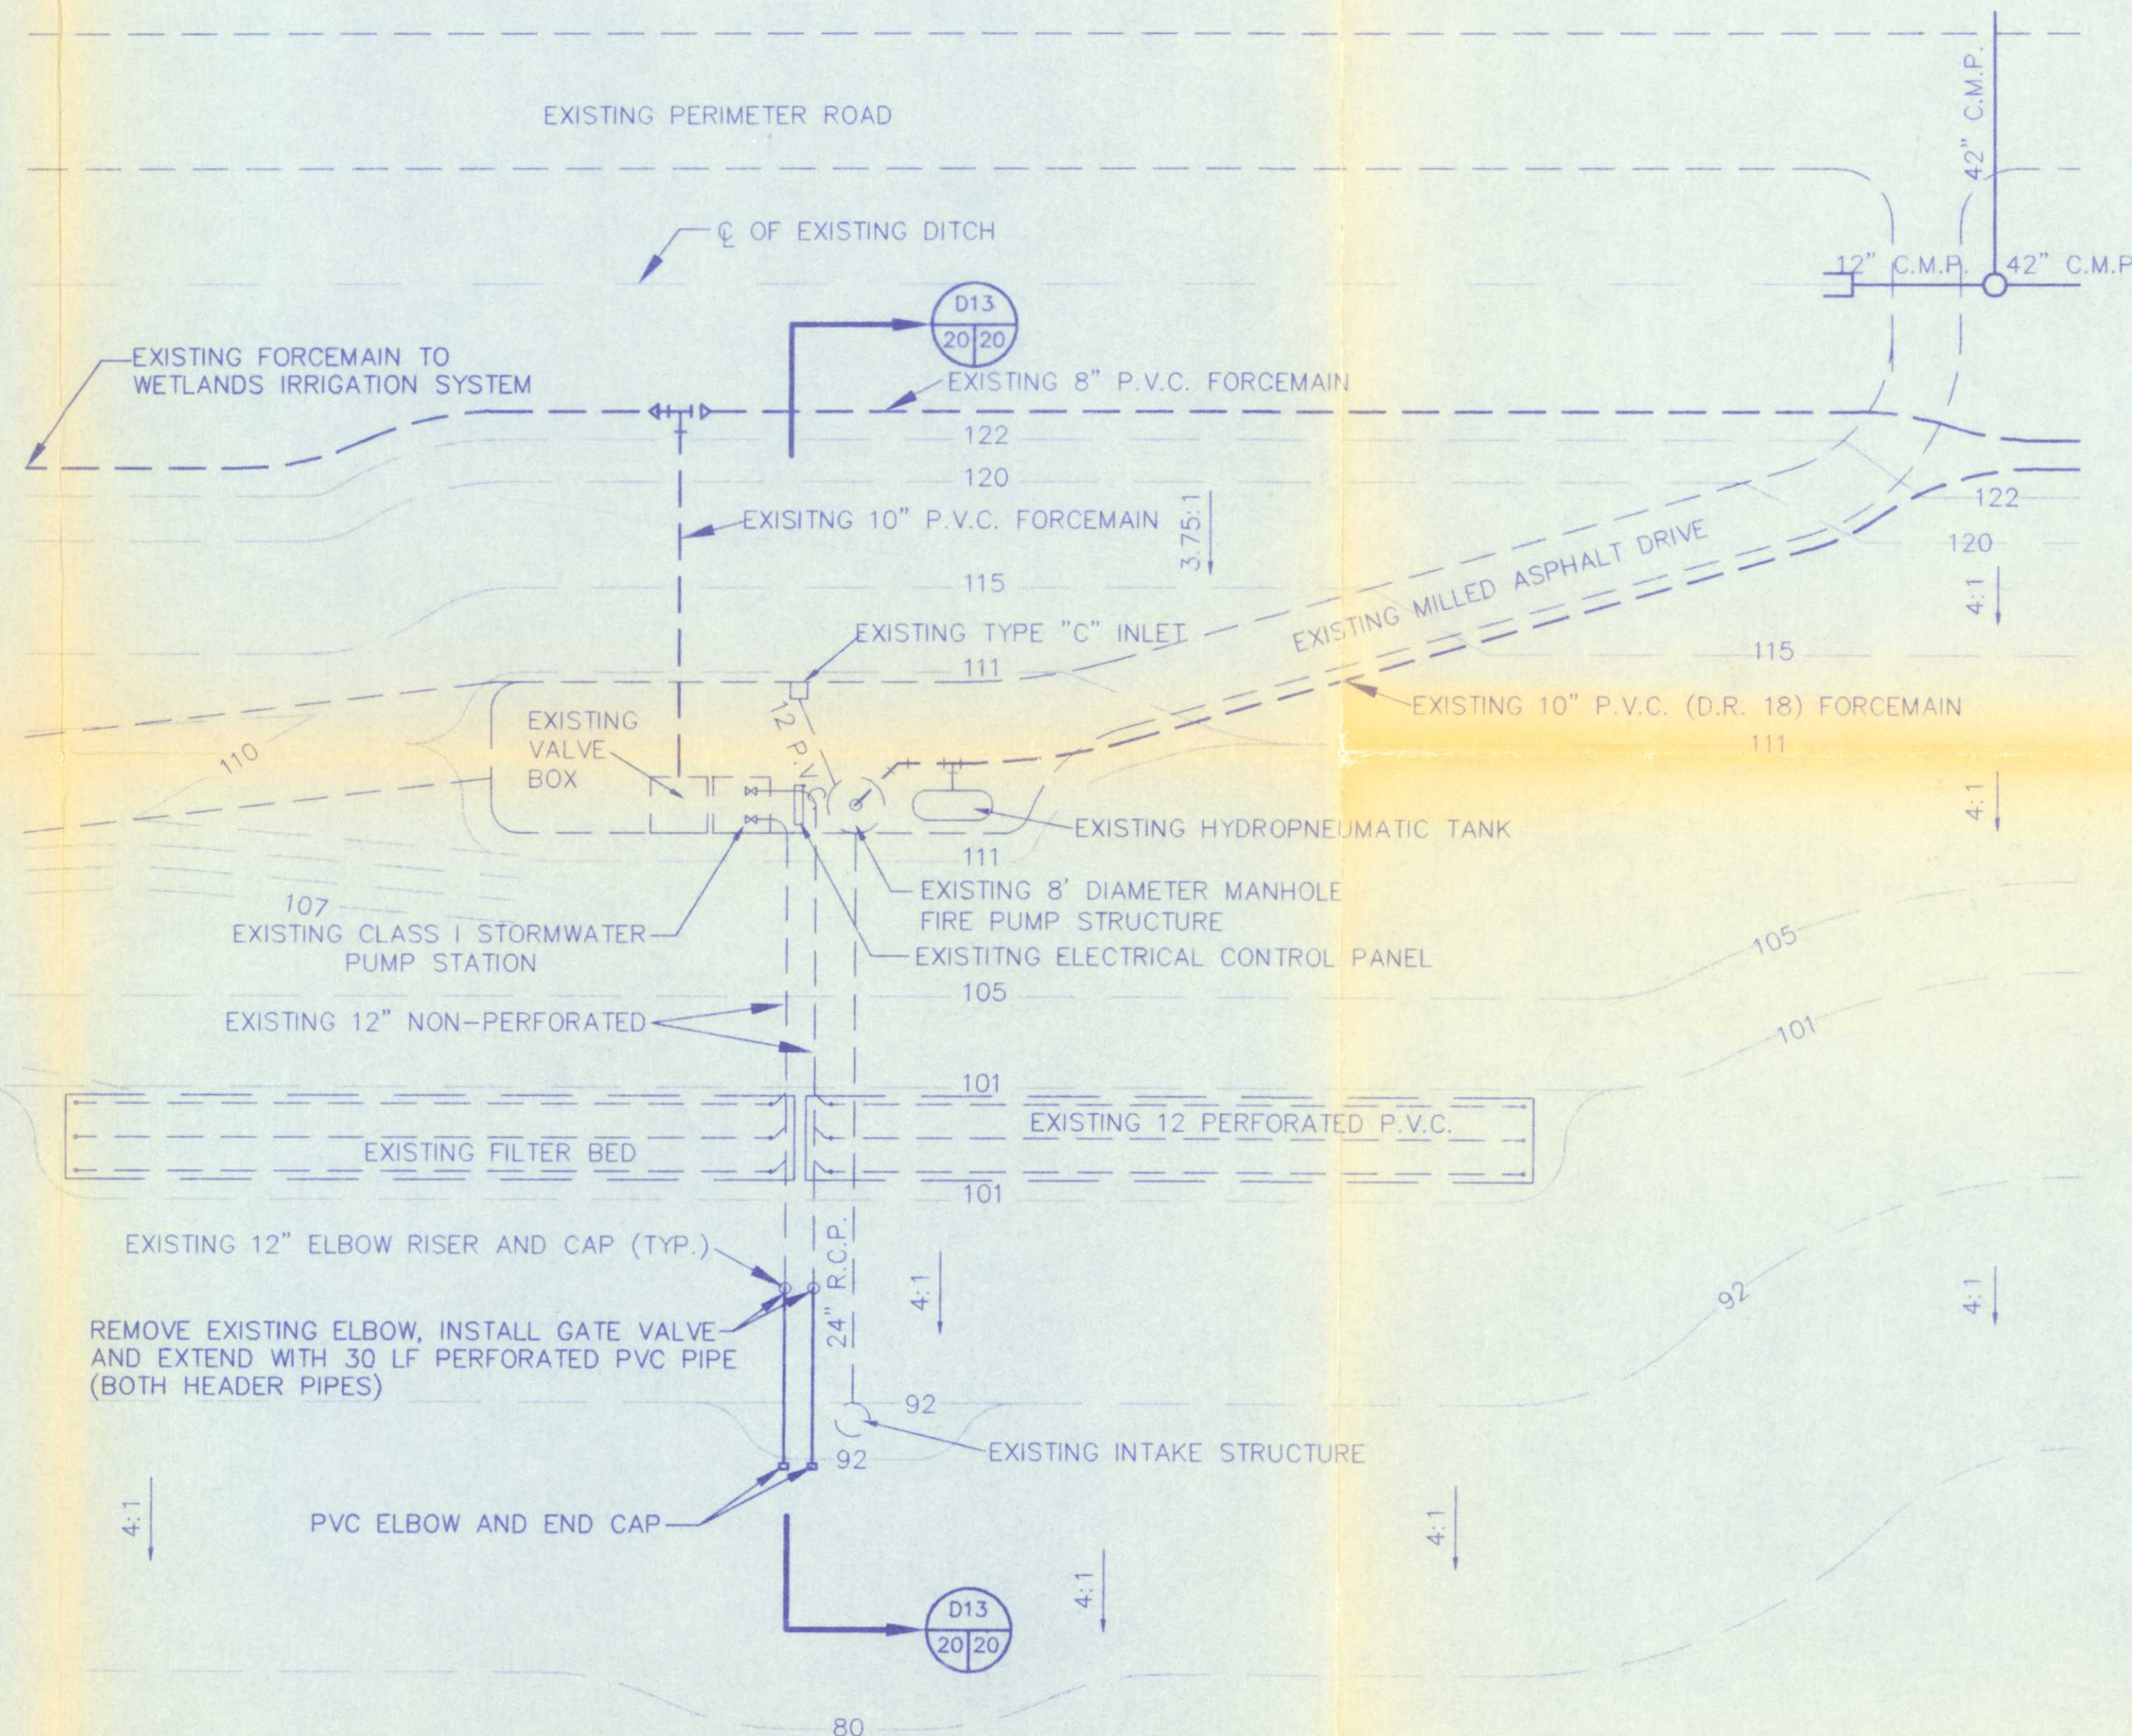

EXISTING CLASS I FILTER BED SYSTEM - PLAN VIEW

N.T.S.

CONSTRUCTION PLANS

STORM WATER SYSTEM

MODIFICATION

INCREMENTAL CLOSURE

FOR

TRAIL RIDGE LANDFILL, INC.

England-Thimms & Miller, Inc.
Consulting & Design Engineers

3131 ST. JOHNS BLUFF ROAD SOUTH

JACKSONVILLE, FLORIDA 32246

PHONE NUMBER (904) 642-8990 FAX NUMBER (904) 646-9485



DRAWING NO.

20


REVISIONS:
1-15-97
ADDED GATE VALVES AND CHANGED
PIPE TO PERFORATED W/END CAP.

ETM. NO. E 98-92-1
DRAWN BY: S.J.L.
DESIGNED BY: J.E.C.
CHECKED BY: D.C.W.
DATE: JANUARY 8, 1997


RELEASED FOR BID: 1-6-97
RELEASED FOR CONSTRUCTION:
1-9-97

James Thimms
Bosch
3/1/97


G:\LANDFILL\TRAIL\3rd-inc\Permit-Med\Fillph.dwg Sun Feb 27 14:56:41 2000

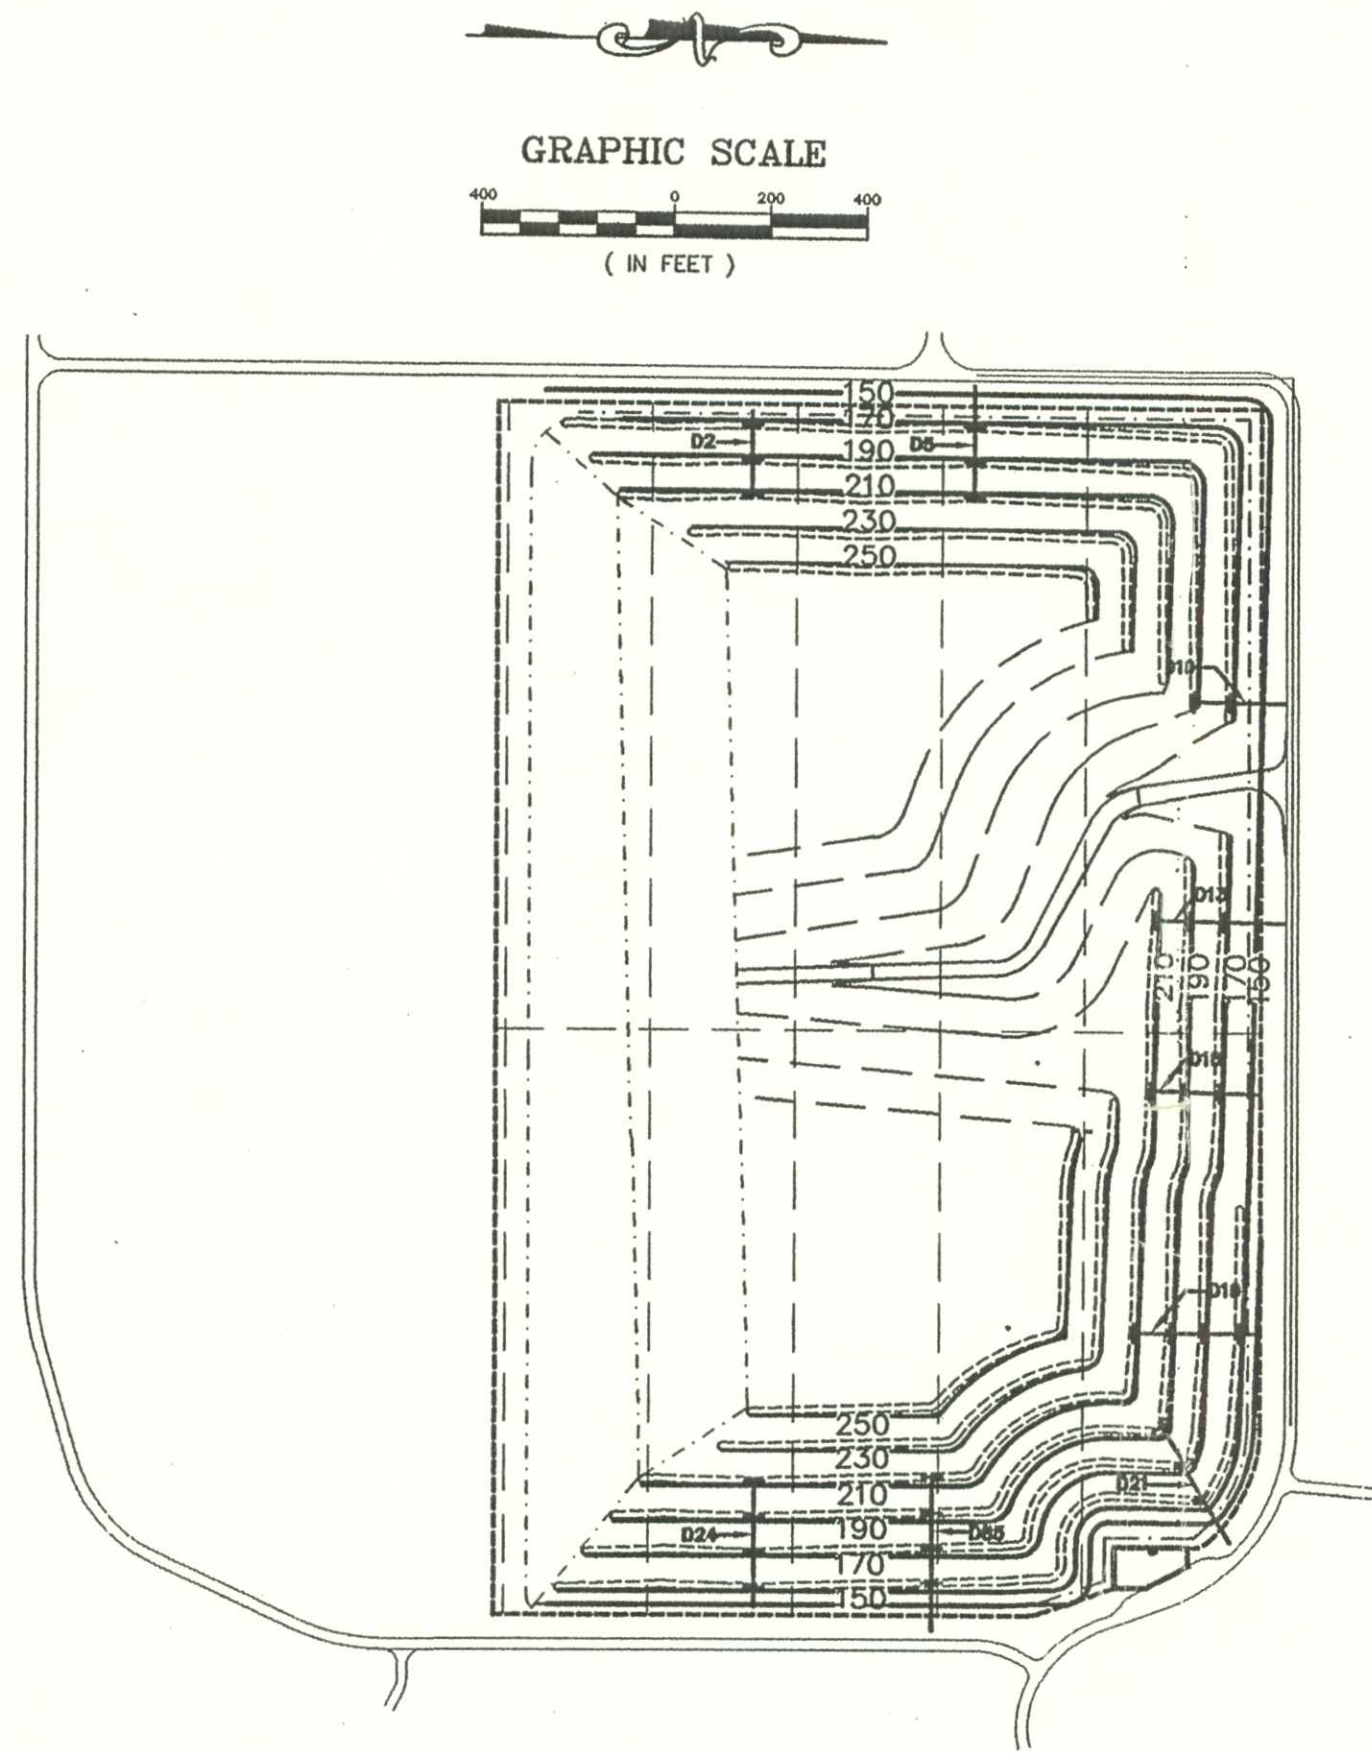


FILL PHASE 4

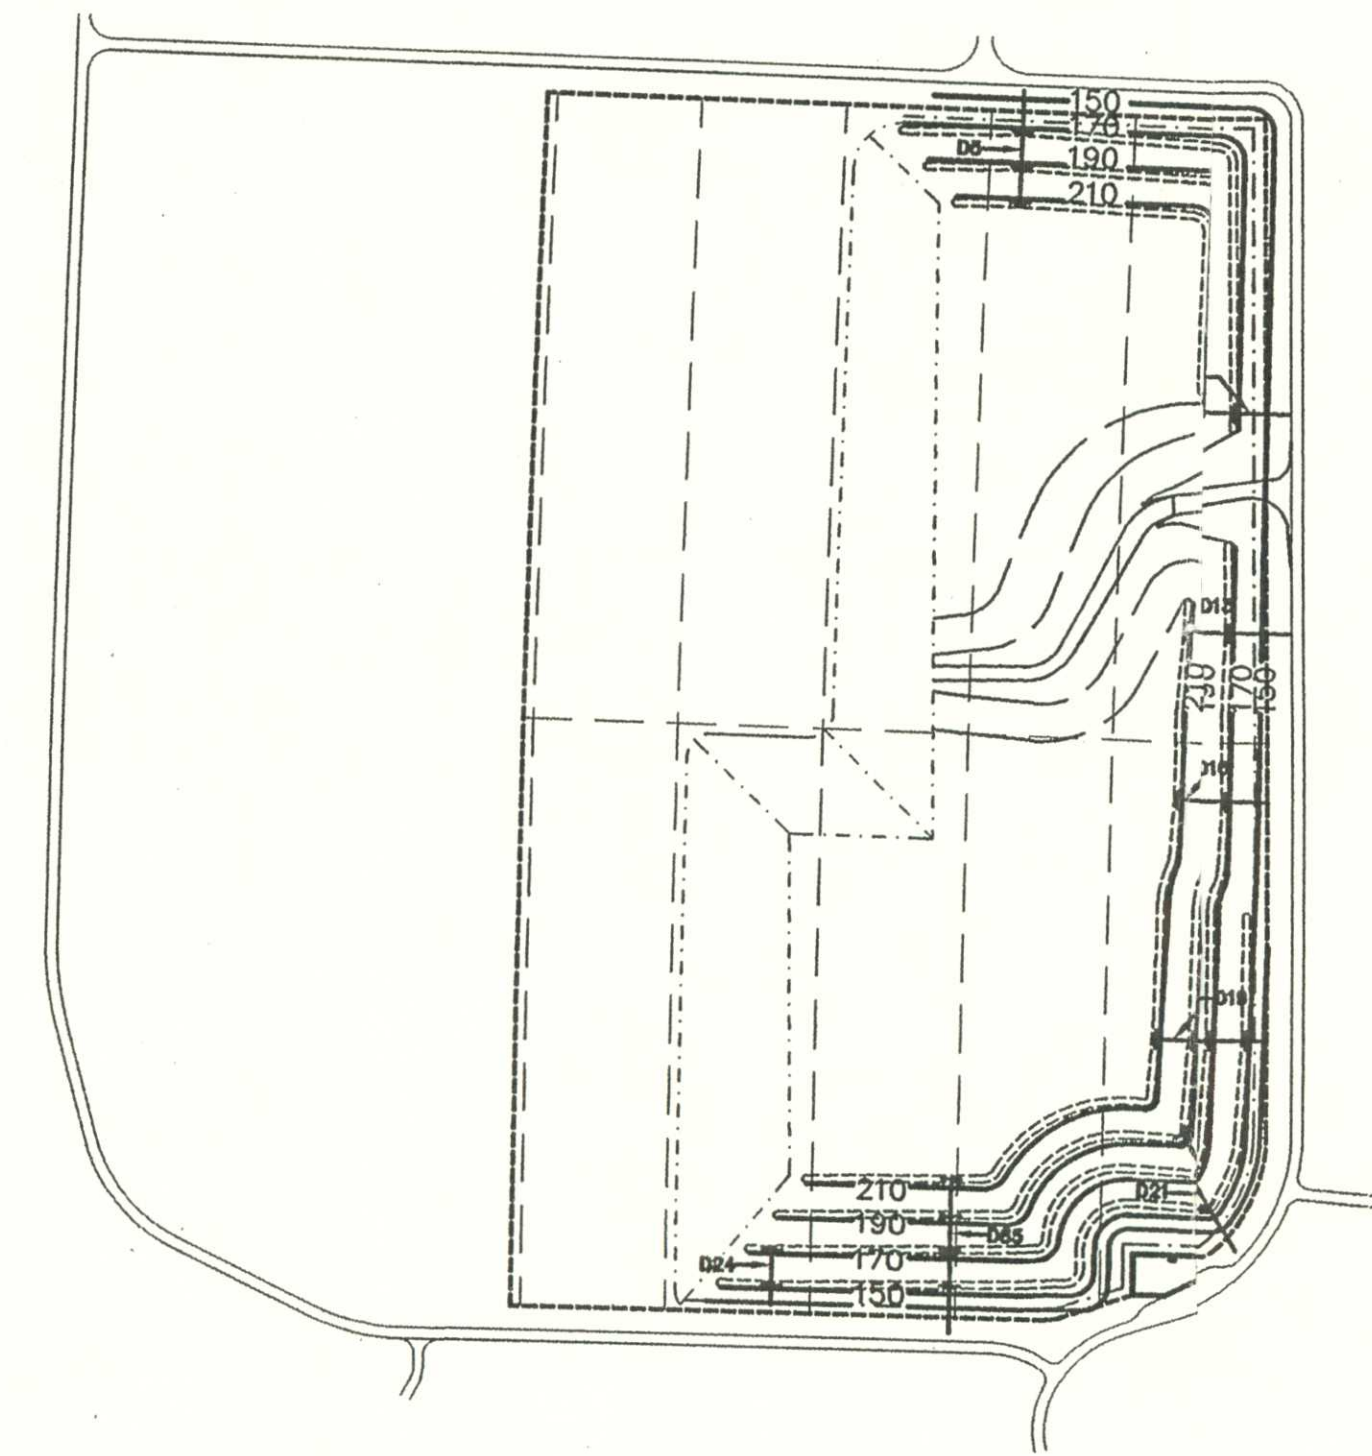


FILL PHASE 1

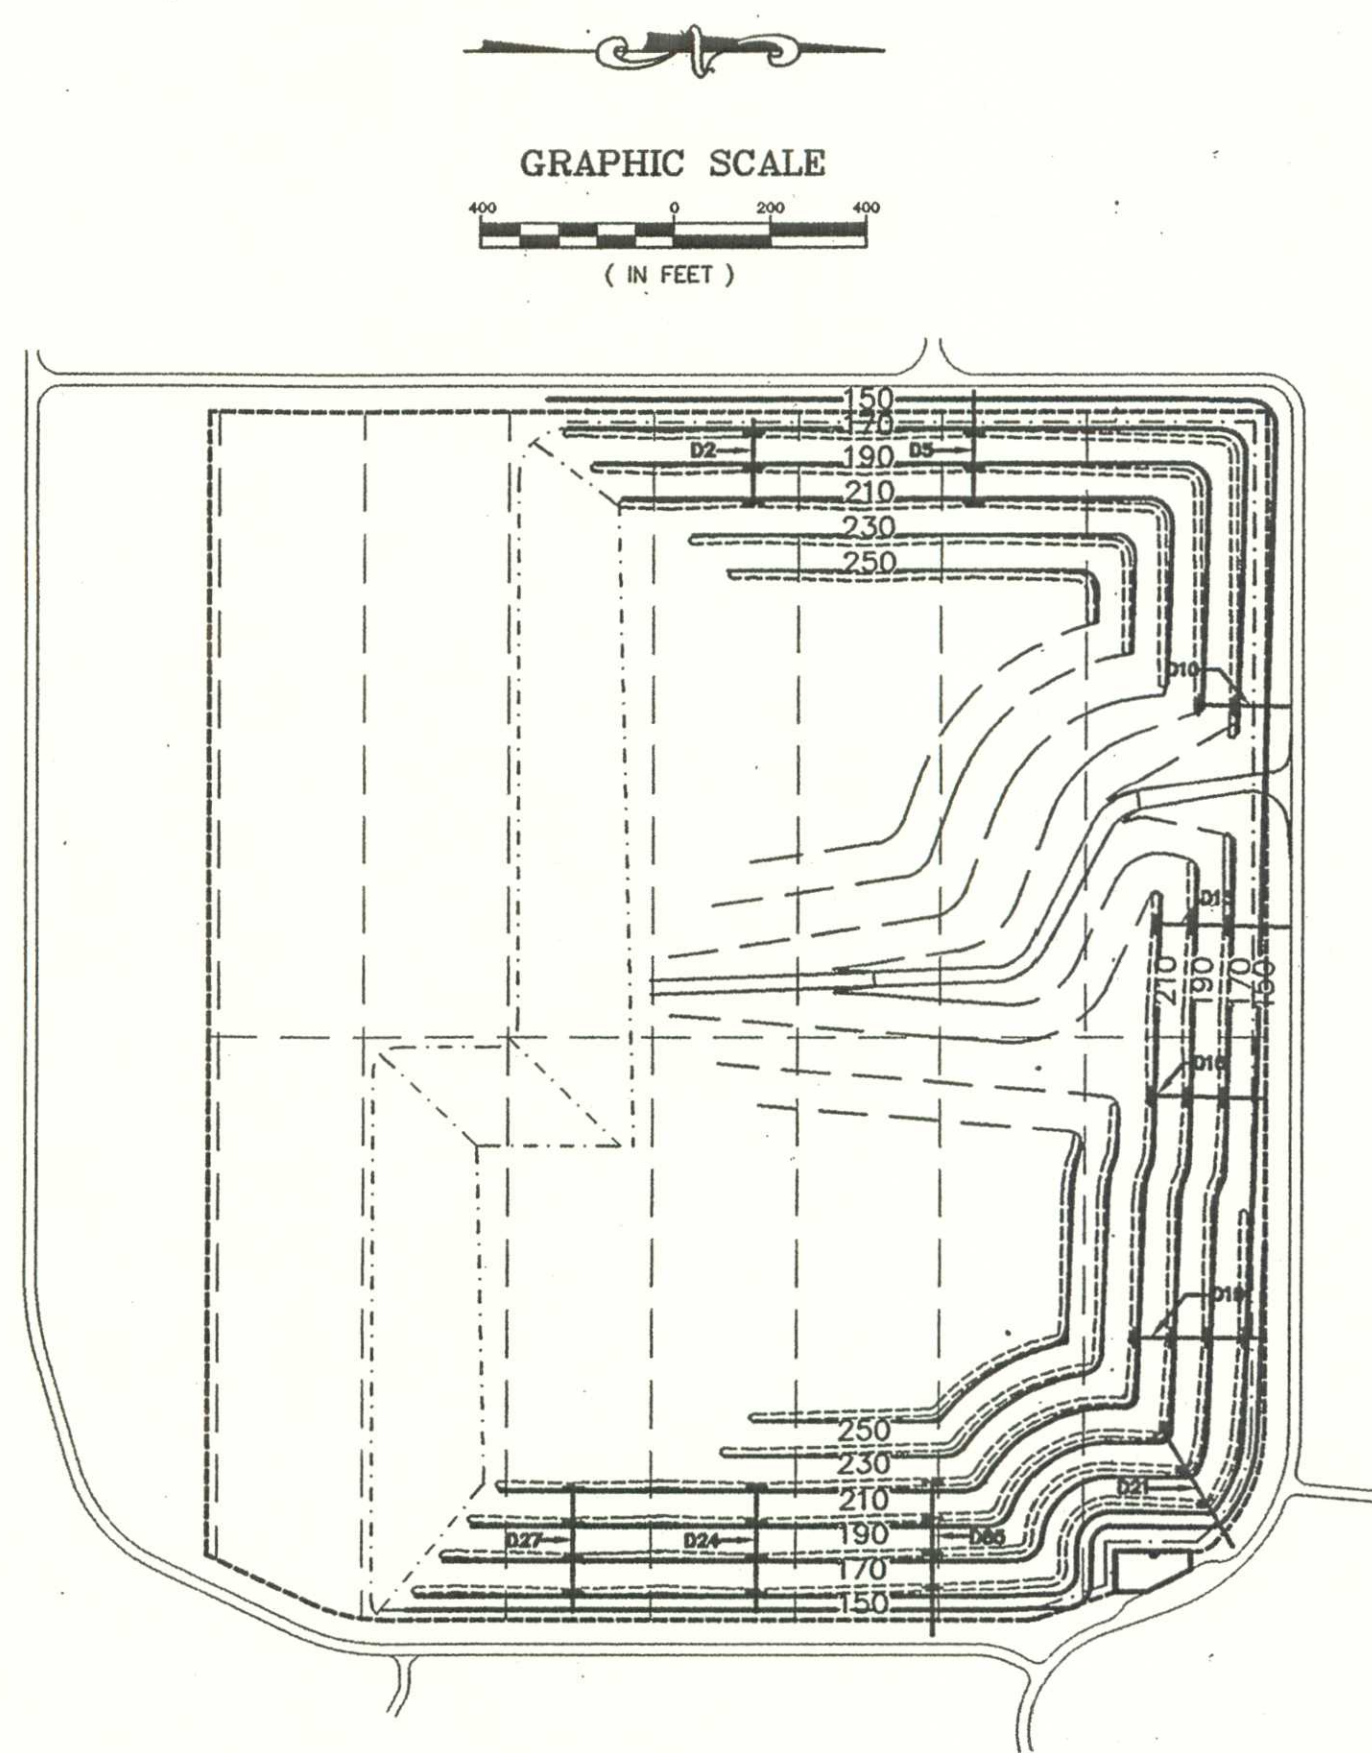


FILL PHASE 5

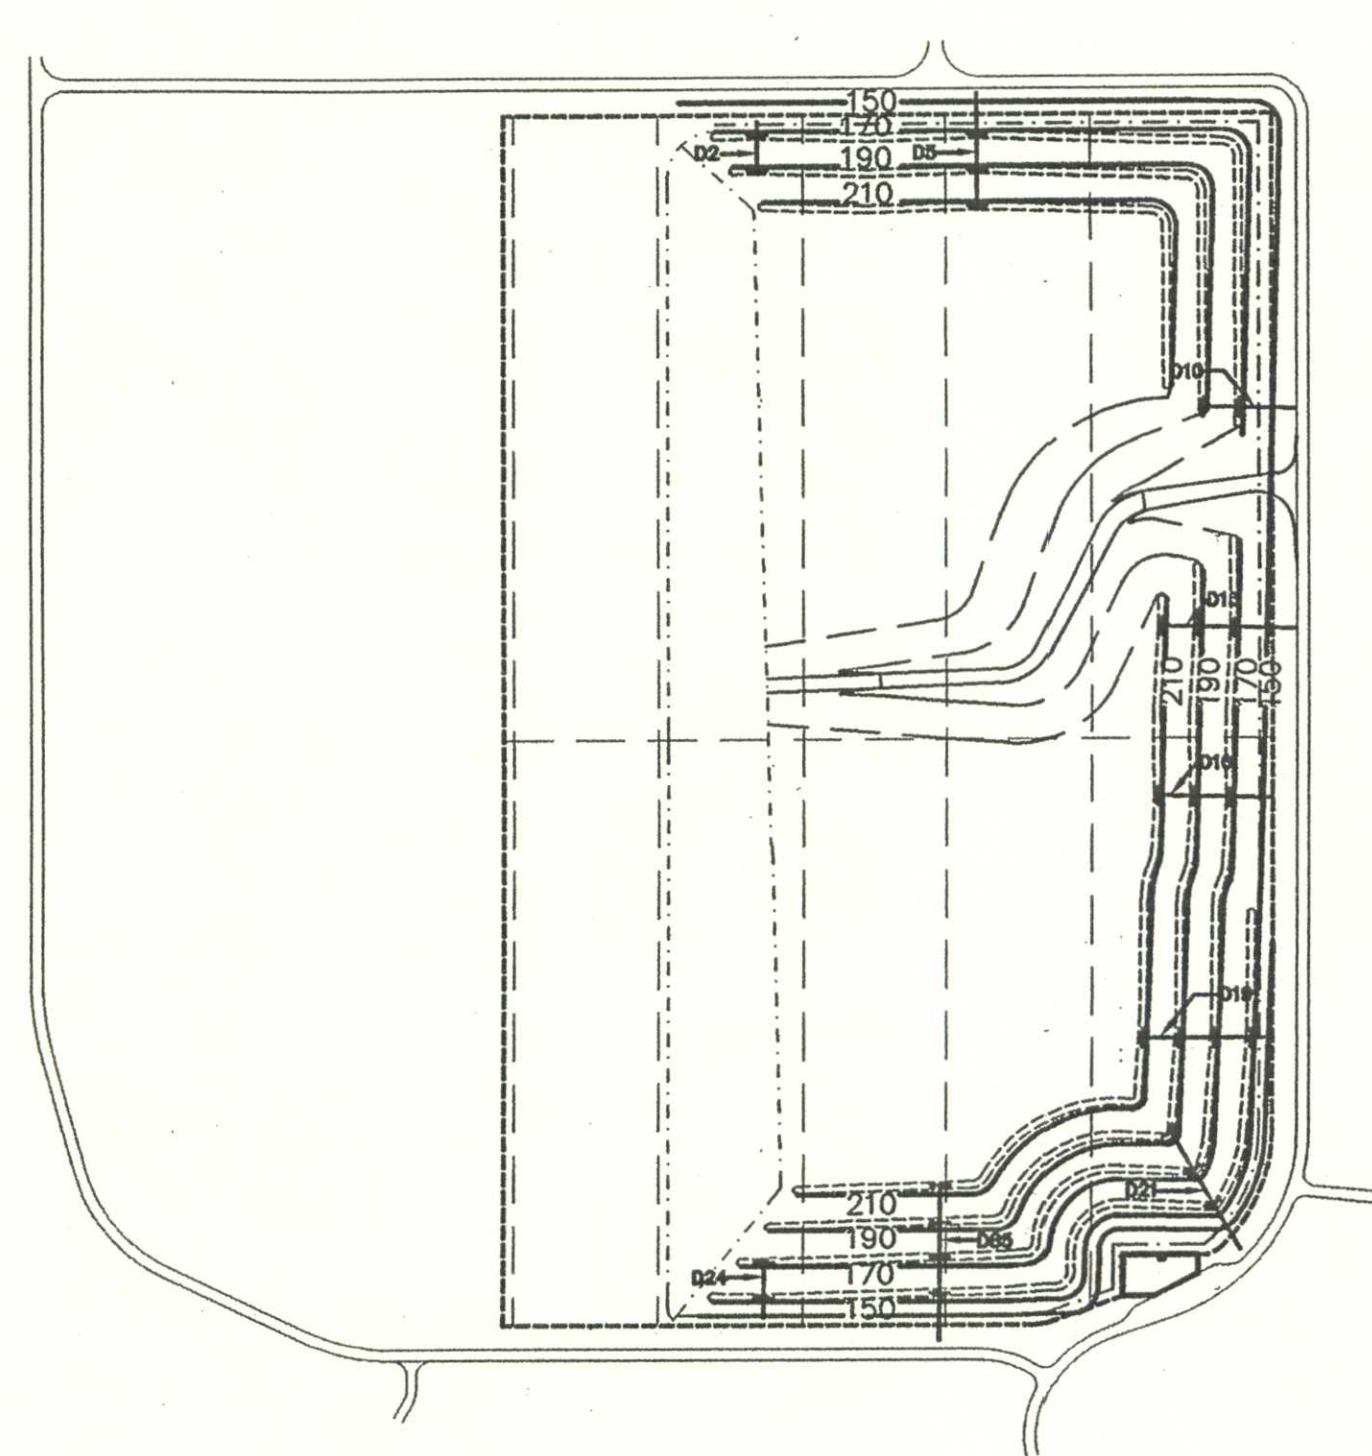

FILL PHASE 2

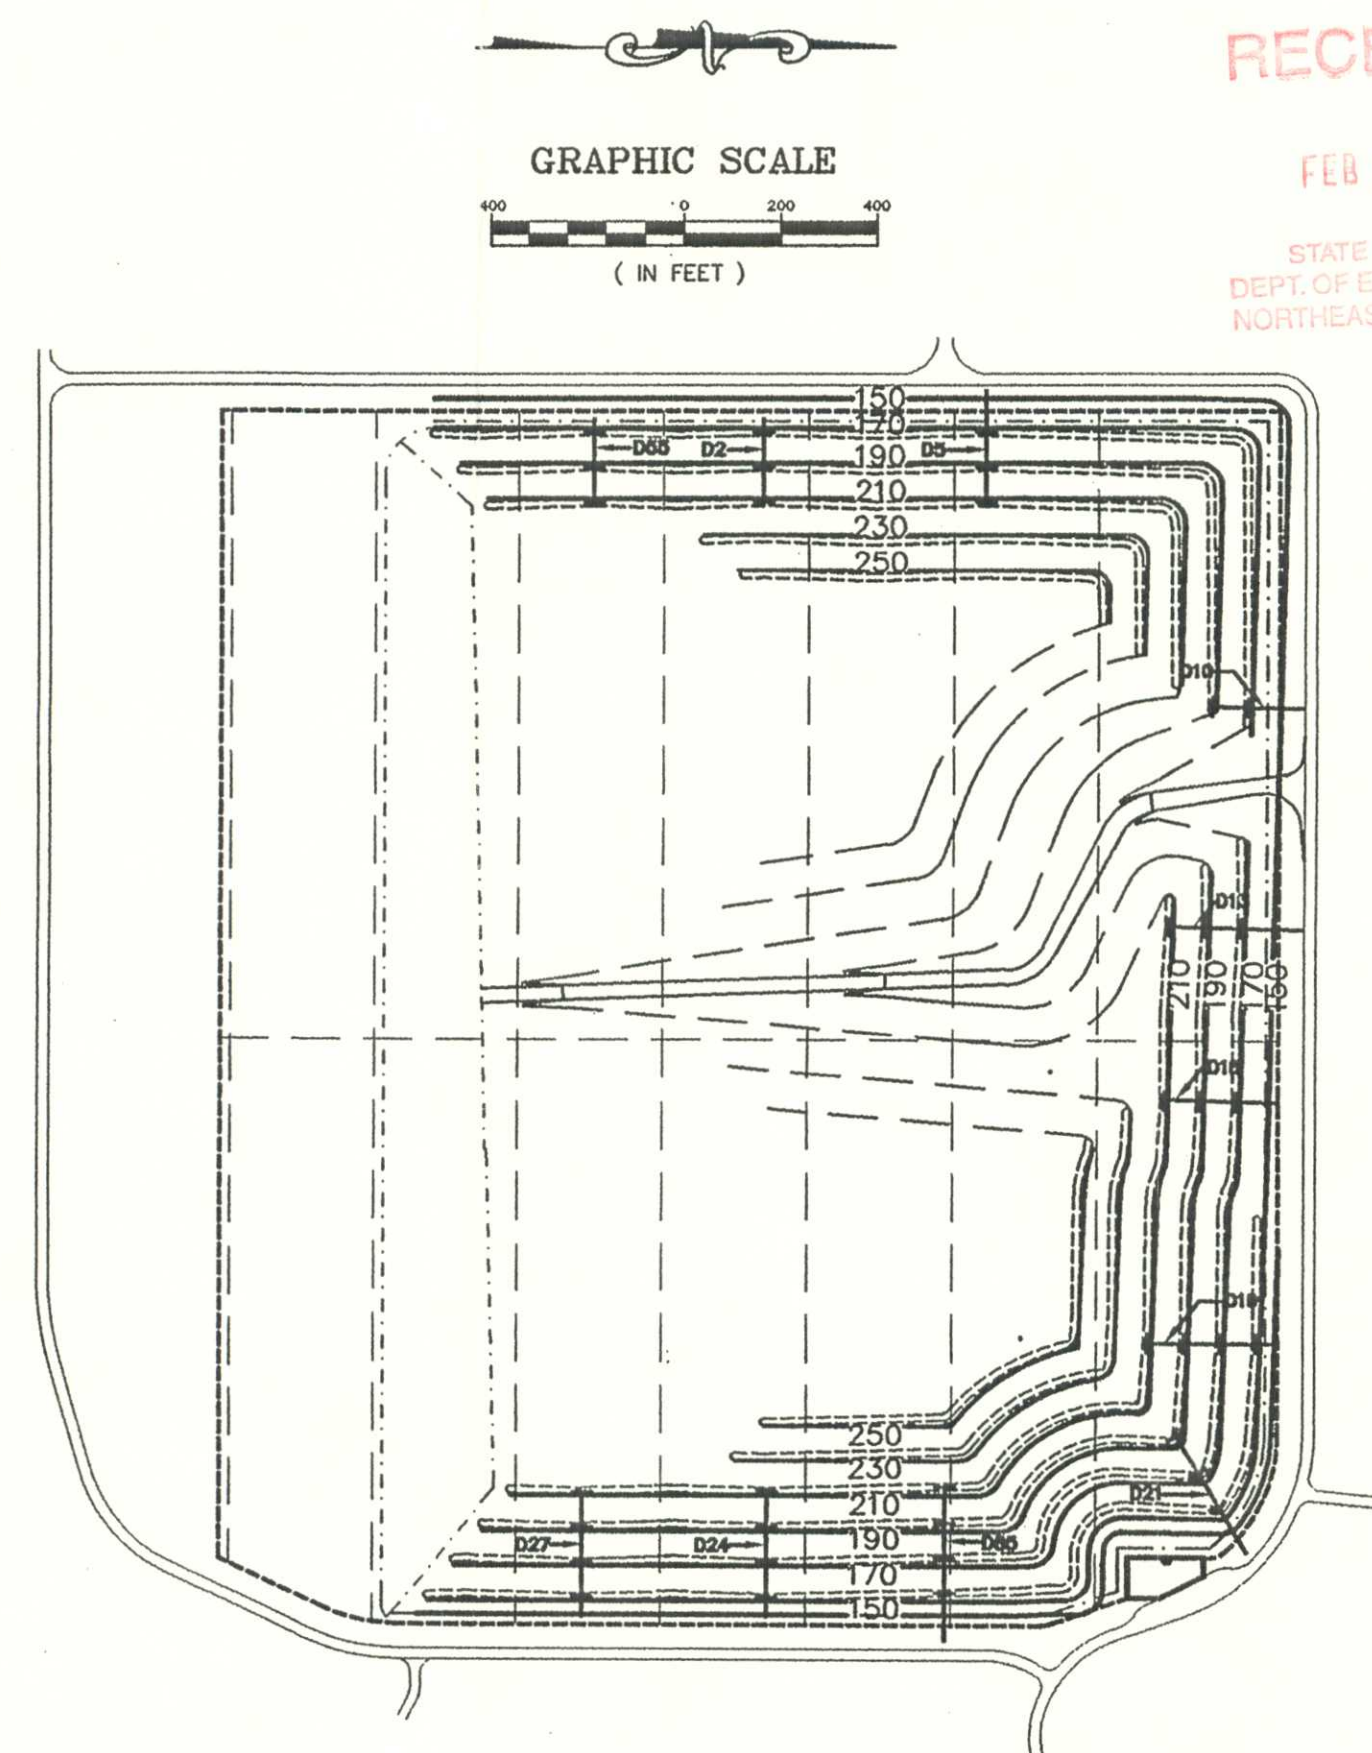

FILL PHASE 6

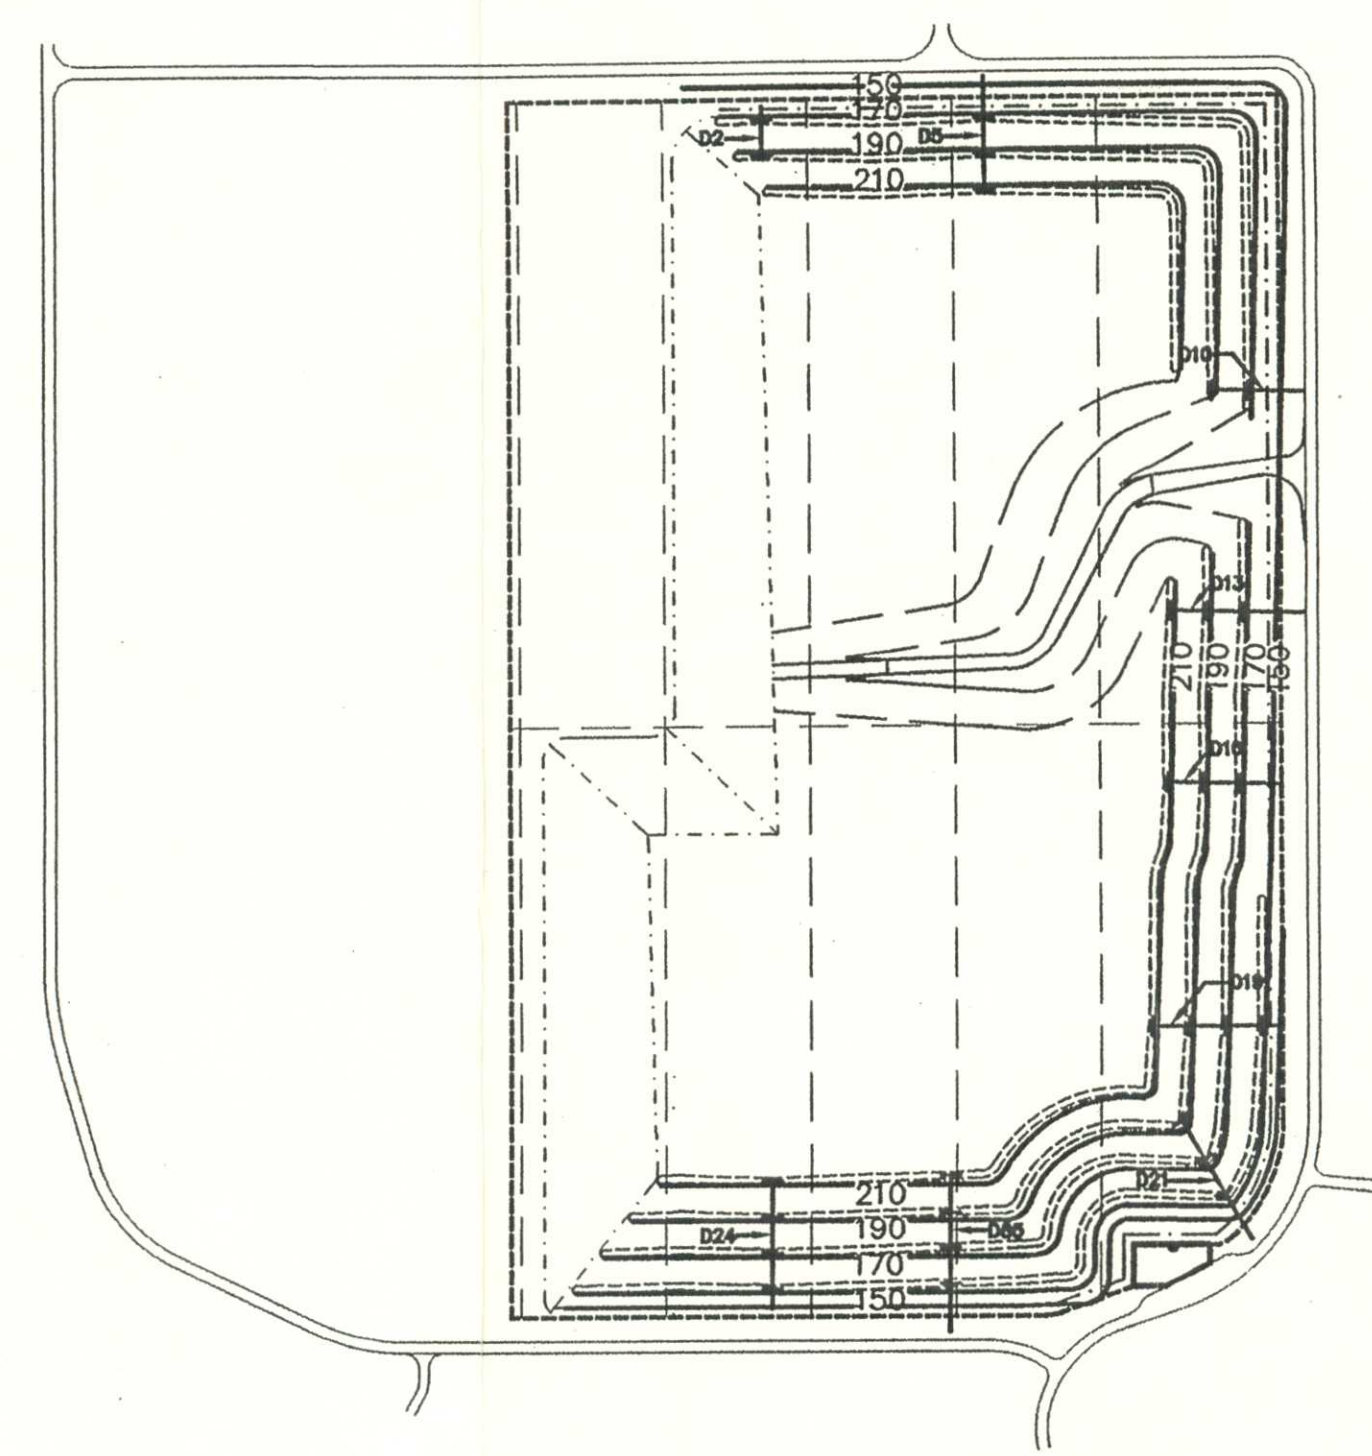

FILL PHASE 3

LEGEND

- 150— FINAL CONTOUR
- - - - - LIMITS OF LINER
- - - - - LINER PHASE LINE
- - - - - LIMITS OF FILL
- - - - - ACCESS ROAD
- ==== ROADWAY
- ===== TERRACE
- + + + + DOWNCOMER PIPE
- ////// 10' BERM

NOTE:
FILL PHASES MAY BE CHANGED
DUE TO OPERATIONAL NEEDS.

RECEIVED
FEB 28 2000
STATE OF FLORIDA
DEPT. OF ENV. PROTECTION
NORTHEAST DISTRICT-JAX

PERMIT DOCUMENT

FILL PHASING PLAN
TRAIL RIDGE LANDFILL PERMIT RENEWAL
FOR
TRAIL RIDGE LANDFILL, INC.

England-Thims & Miller, Inc.
Consulting & Design Engineers
3131 ST. JOHNS BLUFF ROAD SOUTH
JACKSONVILLE, FLORIDA 32246
PHONE NUMBER (904) 642-8890 FAX NUMBER (904) 646-9485

DRAWING NO.

11



REVISIONS:
2-25-00 REVISED FILL PHASES 1 & 2
TO INCLUDE EL. 250 & 255

ETD. NO. E 96 - 49
DRAWN BY: J.B.C.
DESIGNED BY: J.B.C.
CHECKED BY: D.C.M.
DATE: OCTOBER 28, 1996



SUBMITTED TO DEP. 10-28-96

Chris Ha Cam
Bryce B



G:\LANDFILL\TRAIL\3rd-inc\Permit-Mod\Fillph.dwg Sun Feb 27 14:55:35 2000

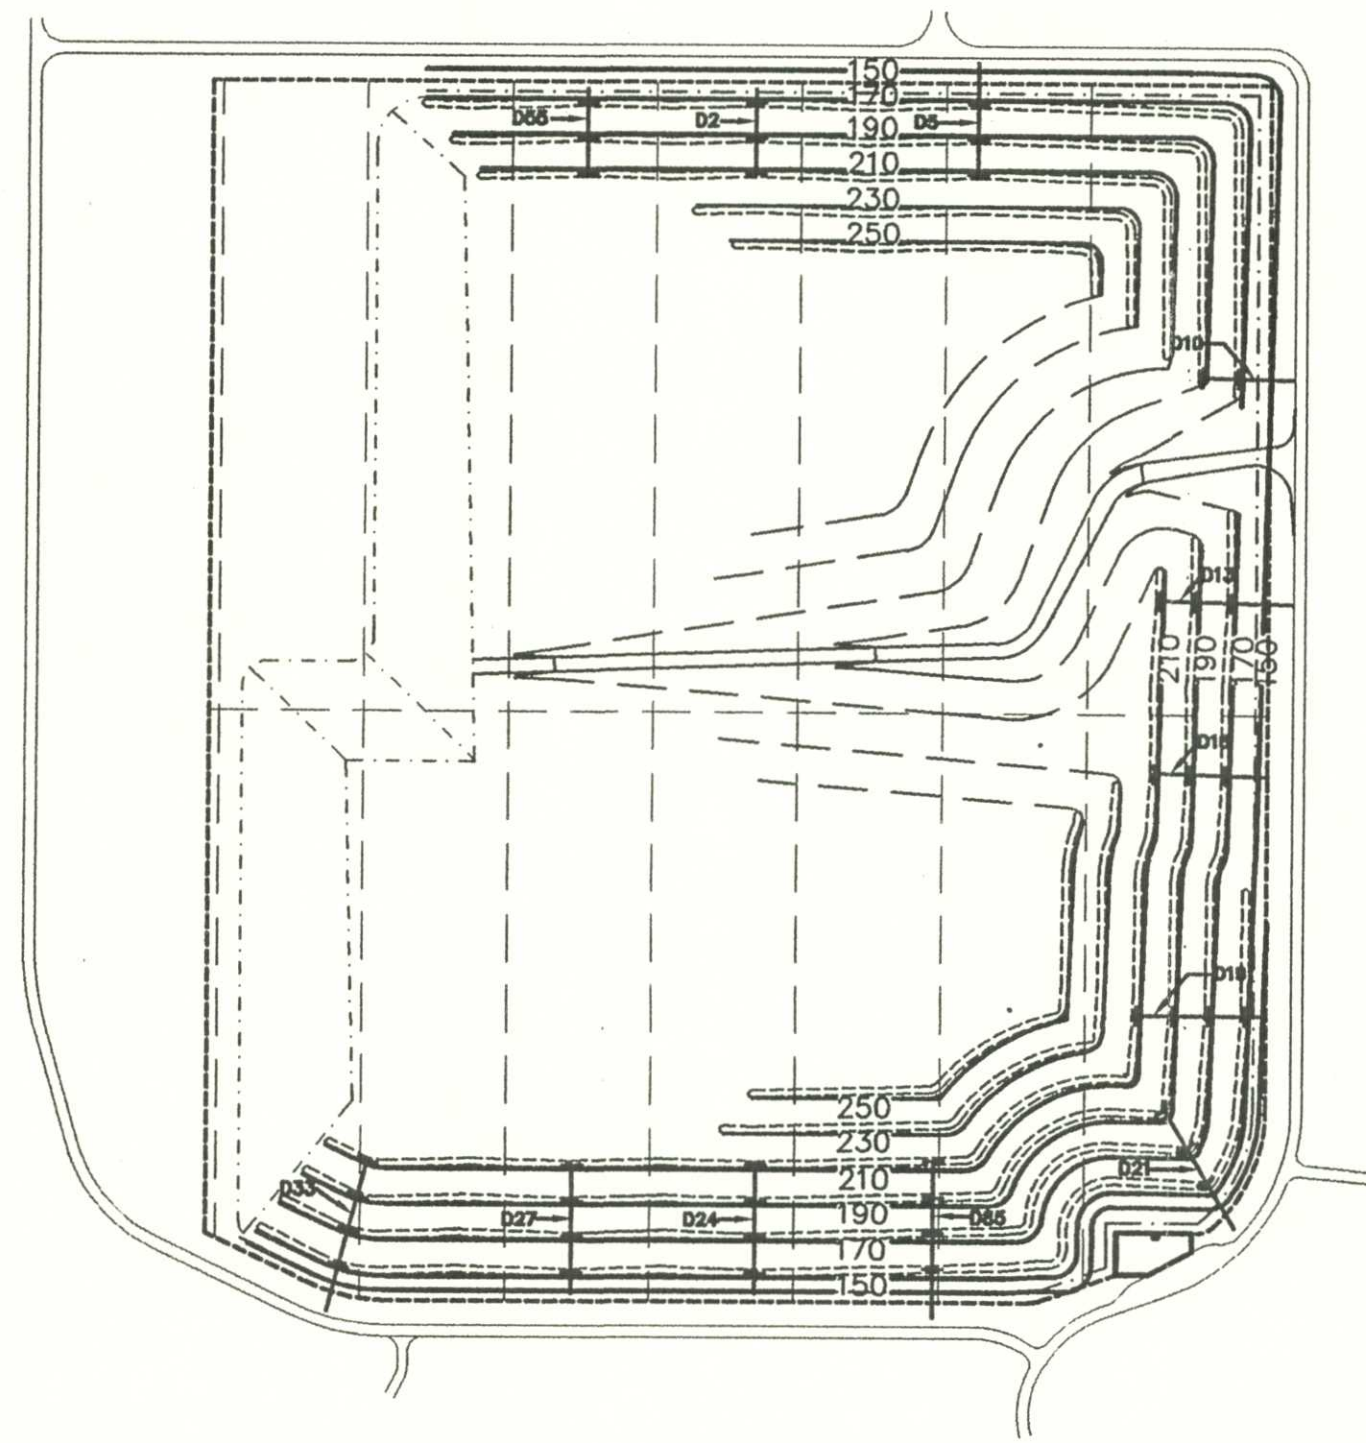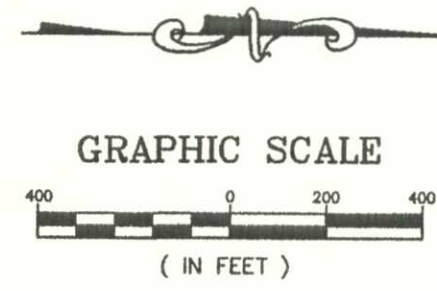



FILL PHASE 7

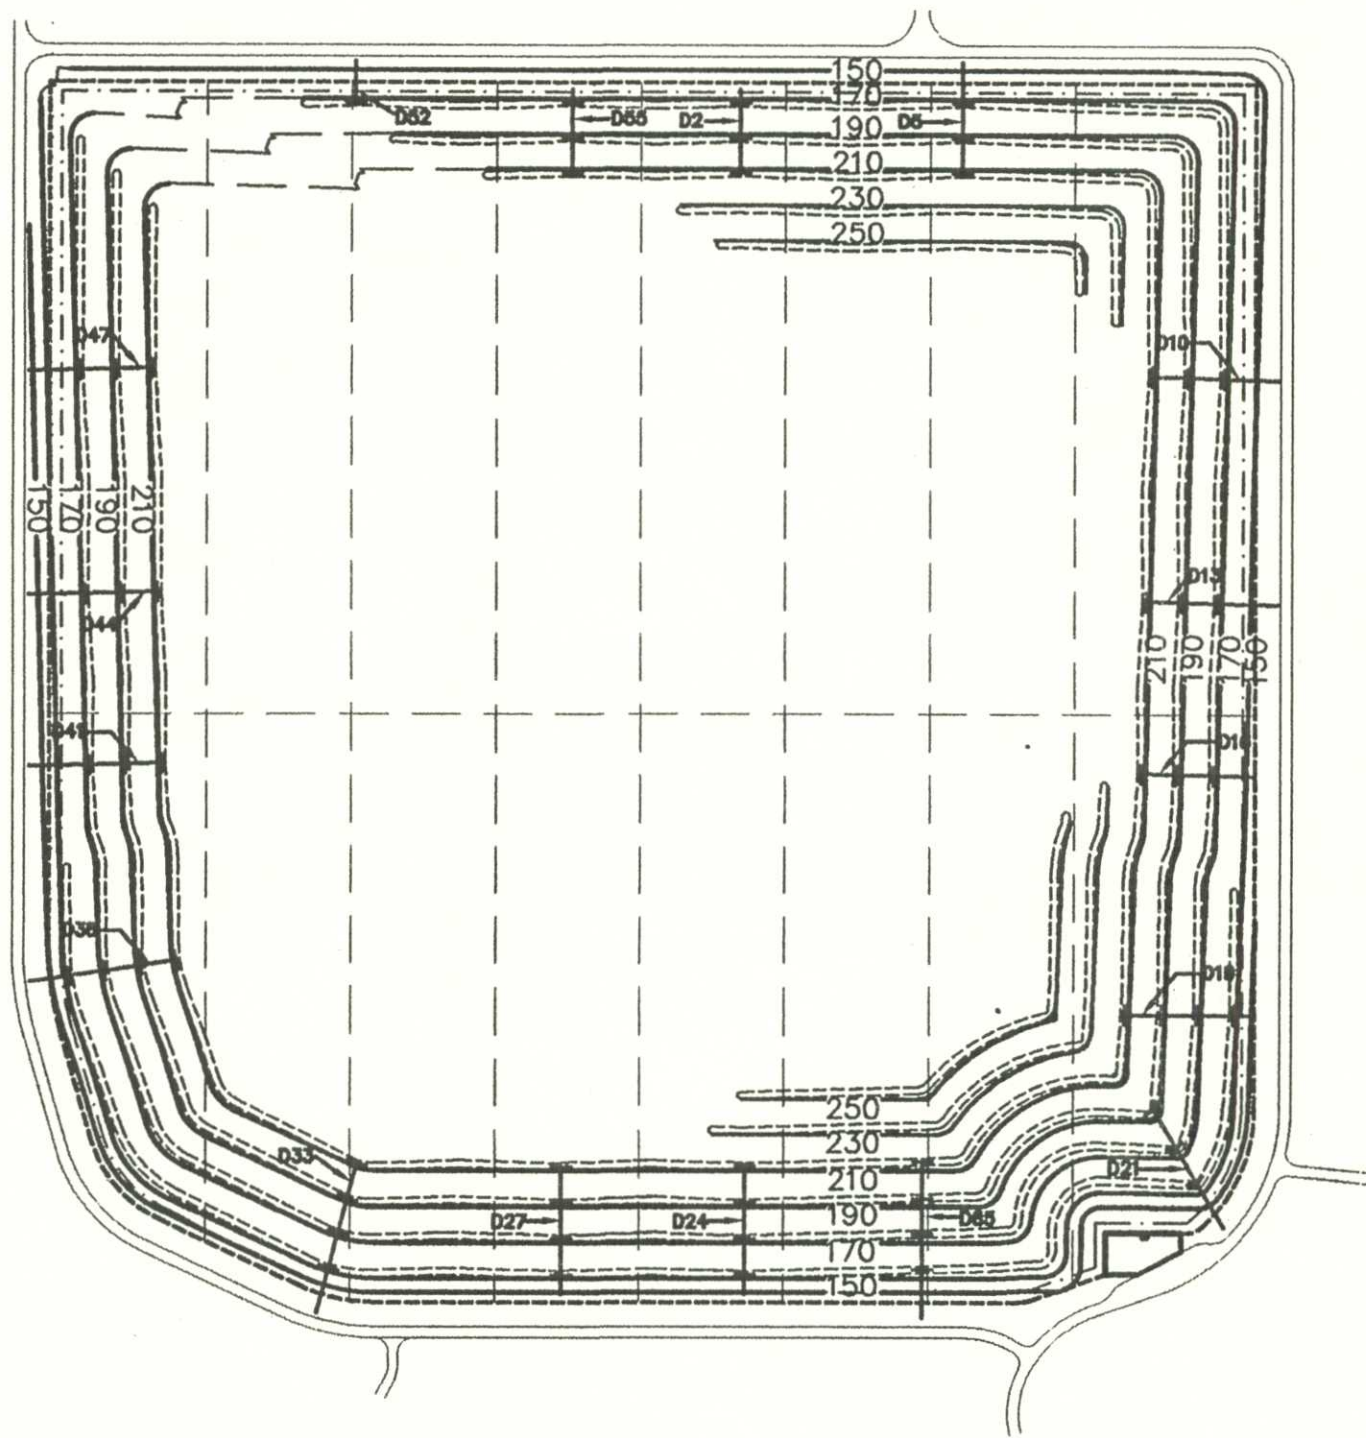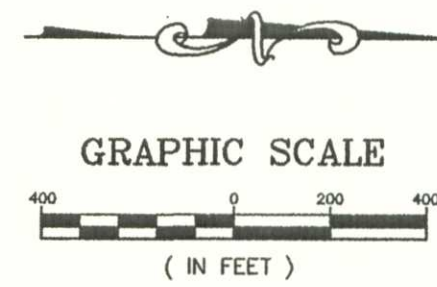



FILL PHASE 10

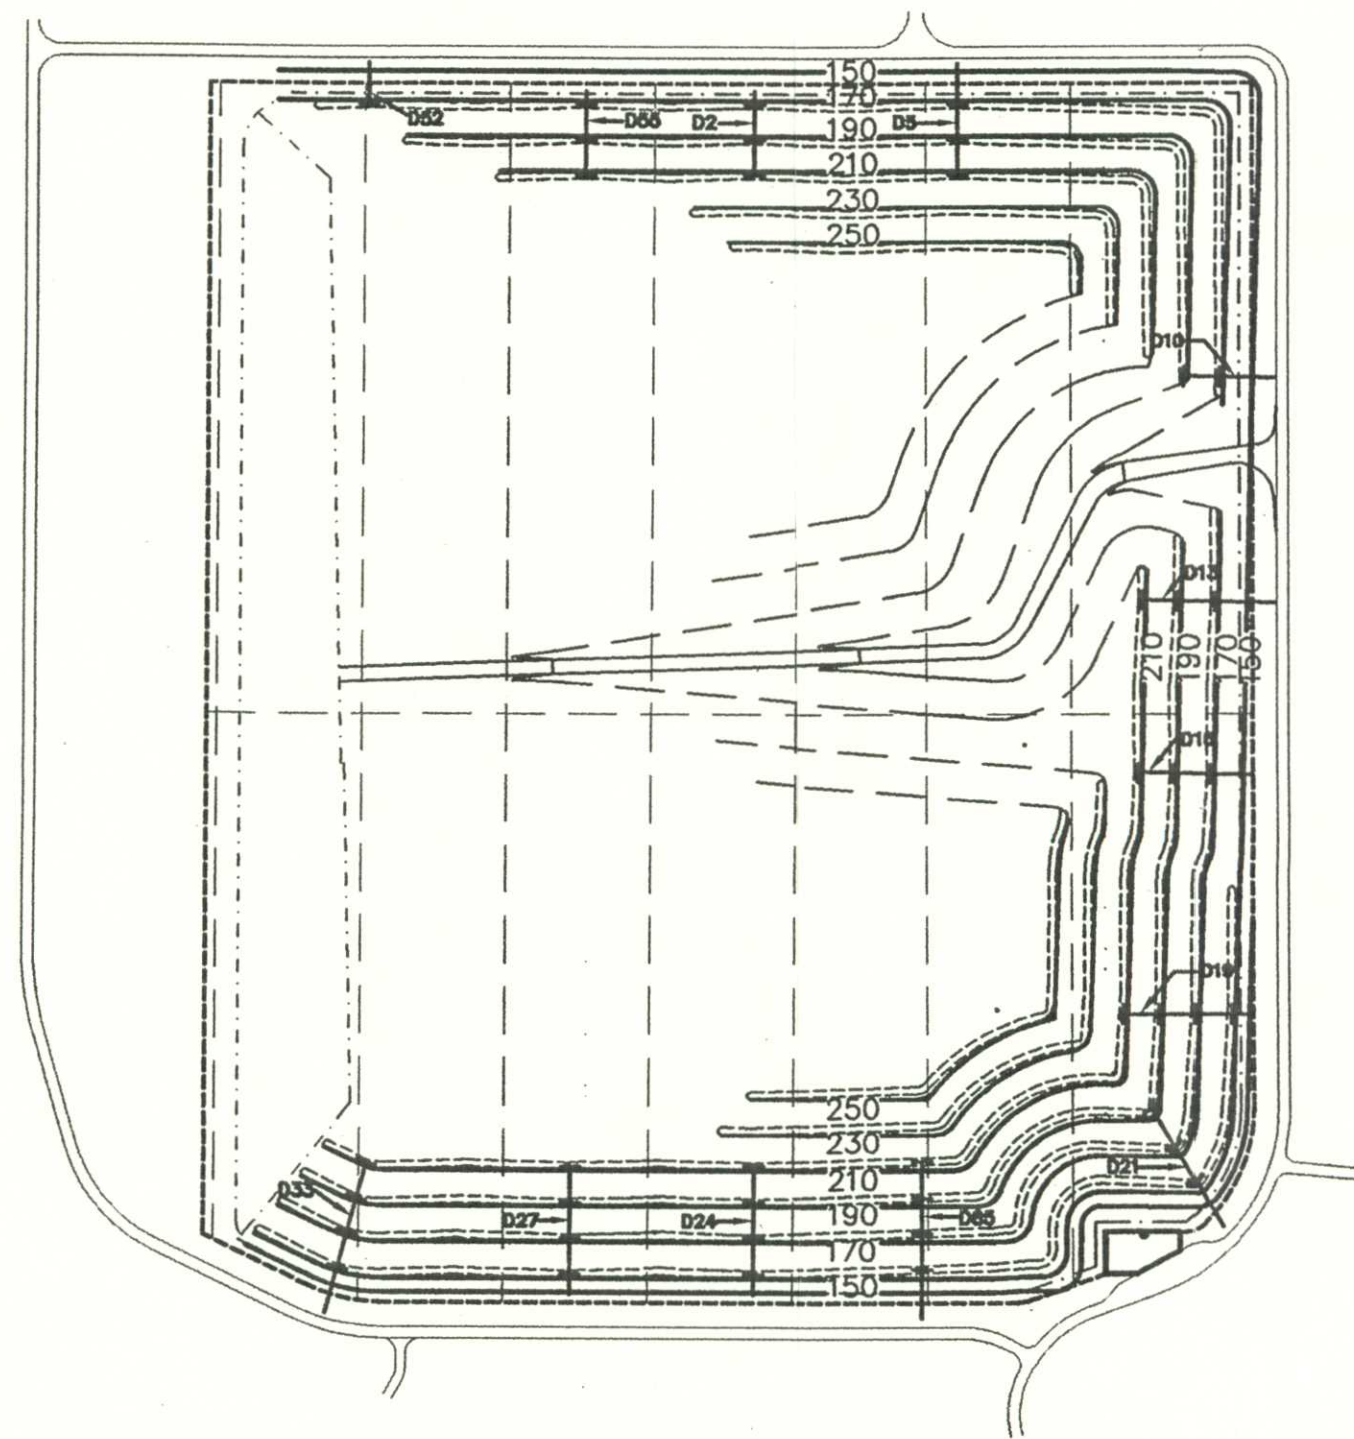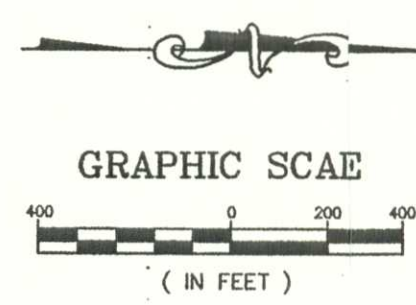



FILL PHASE 8

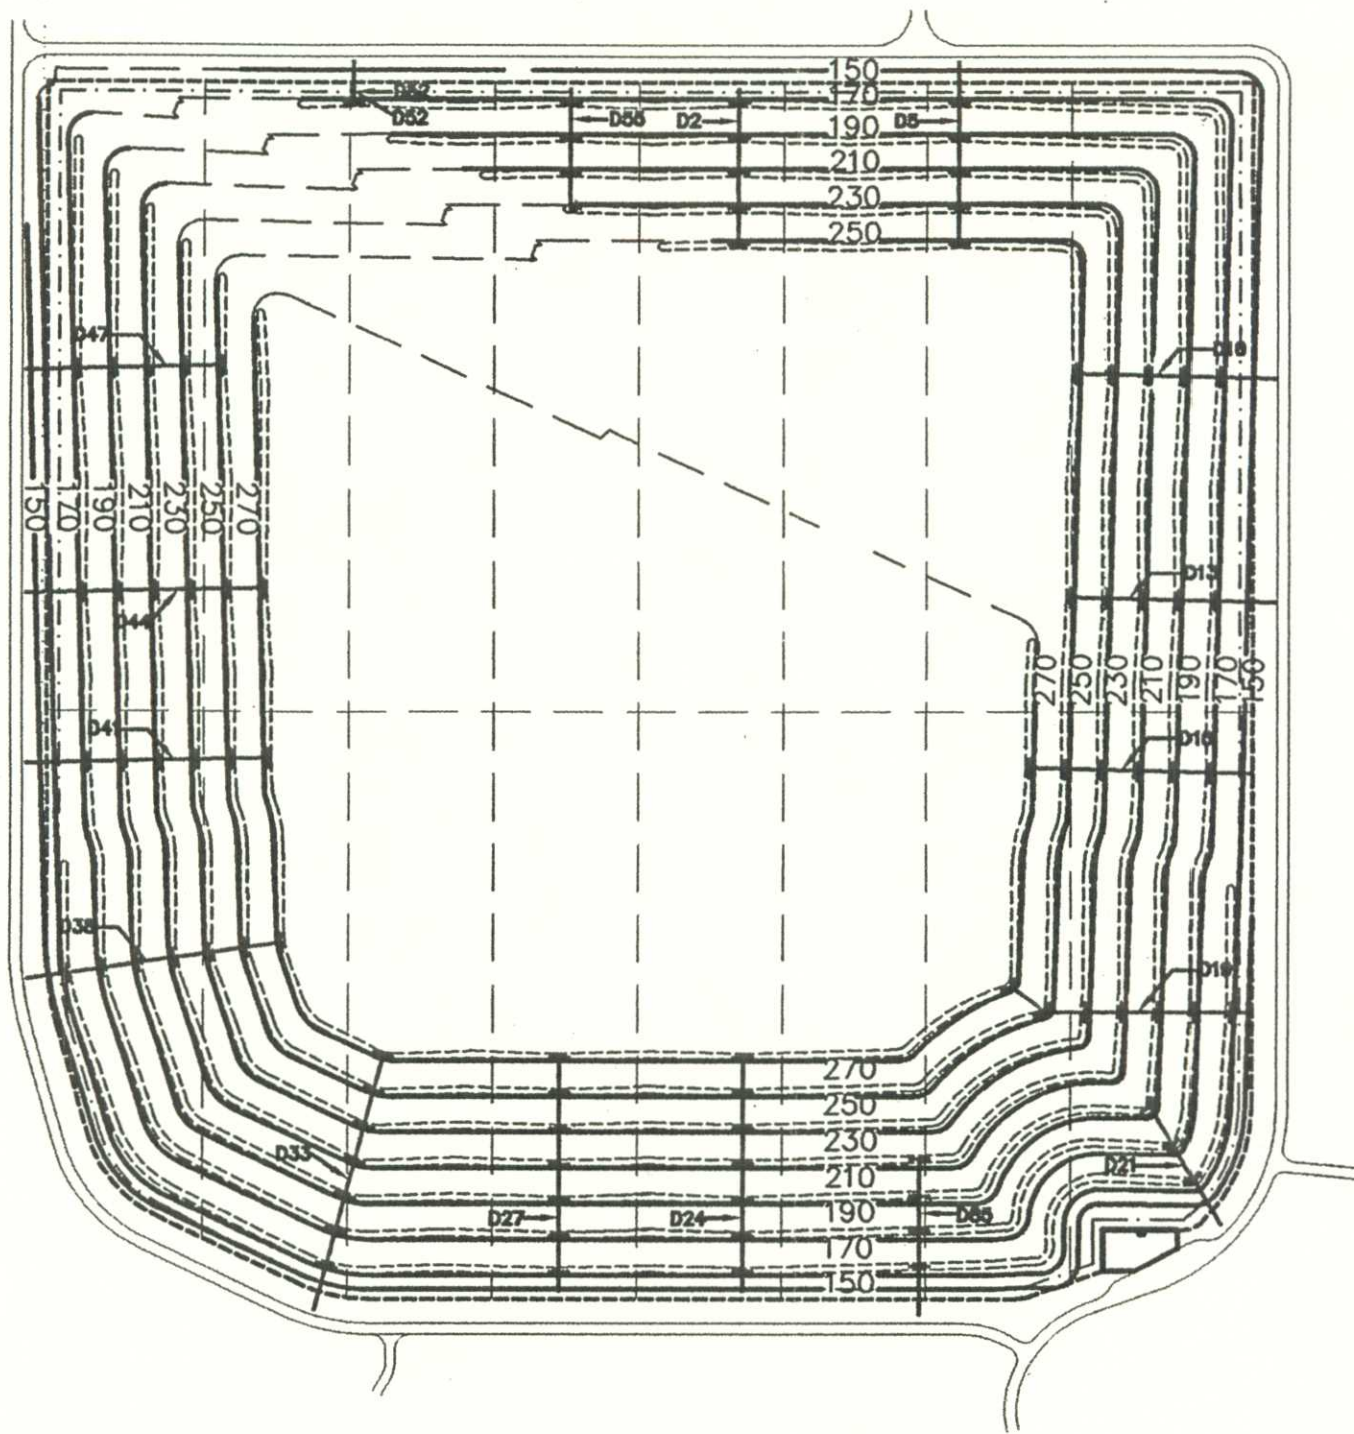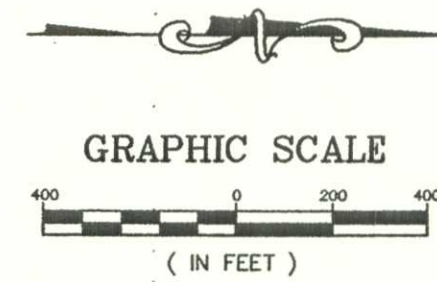

FILL PHASE 11

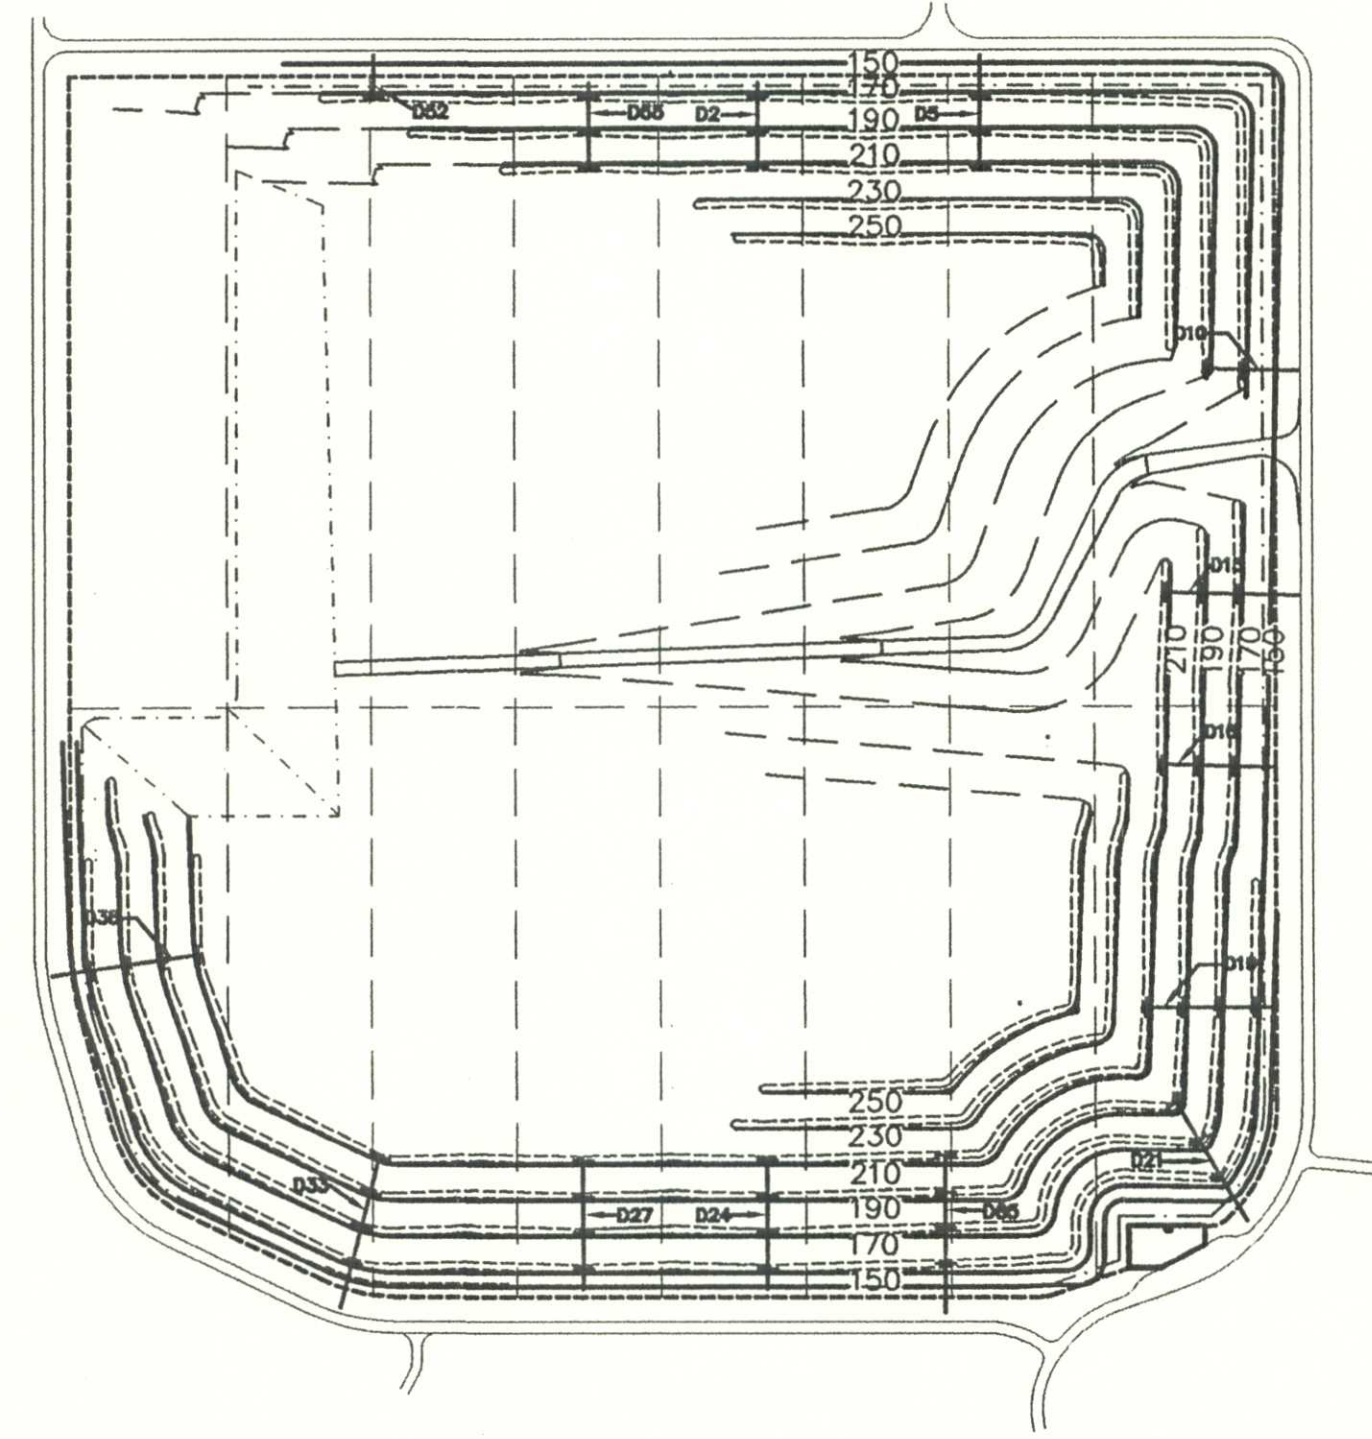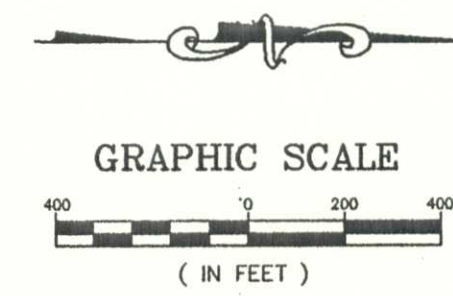

FILL PHASE 9

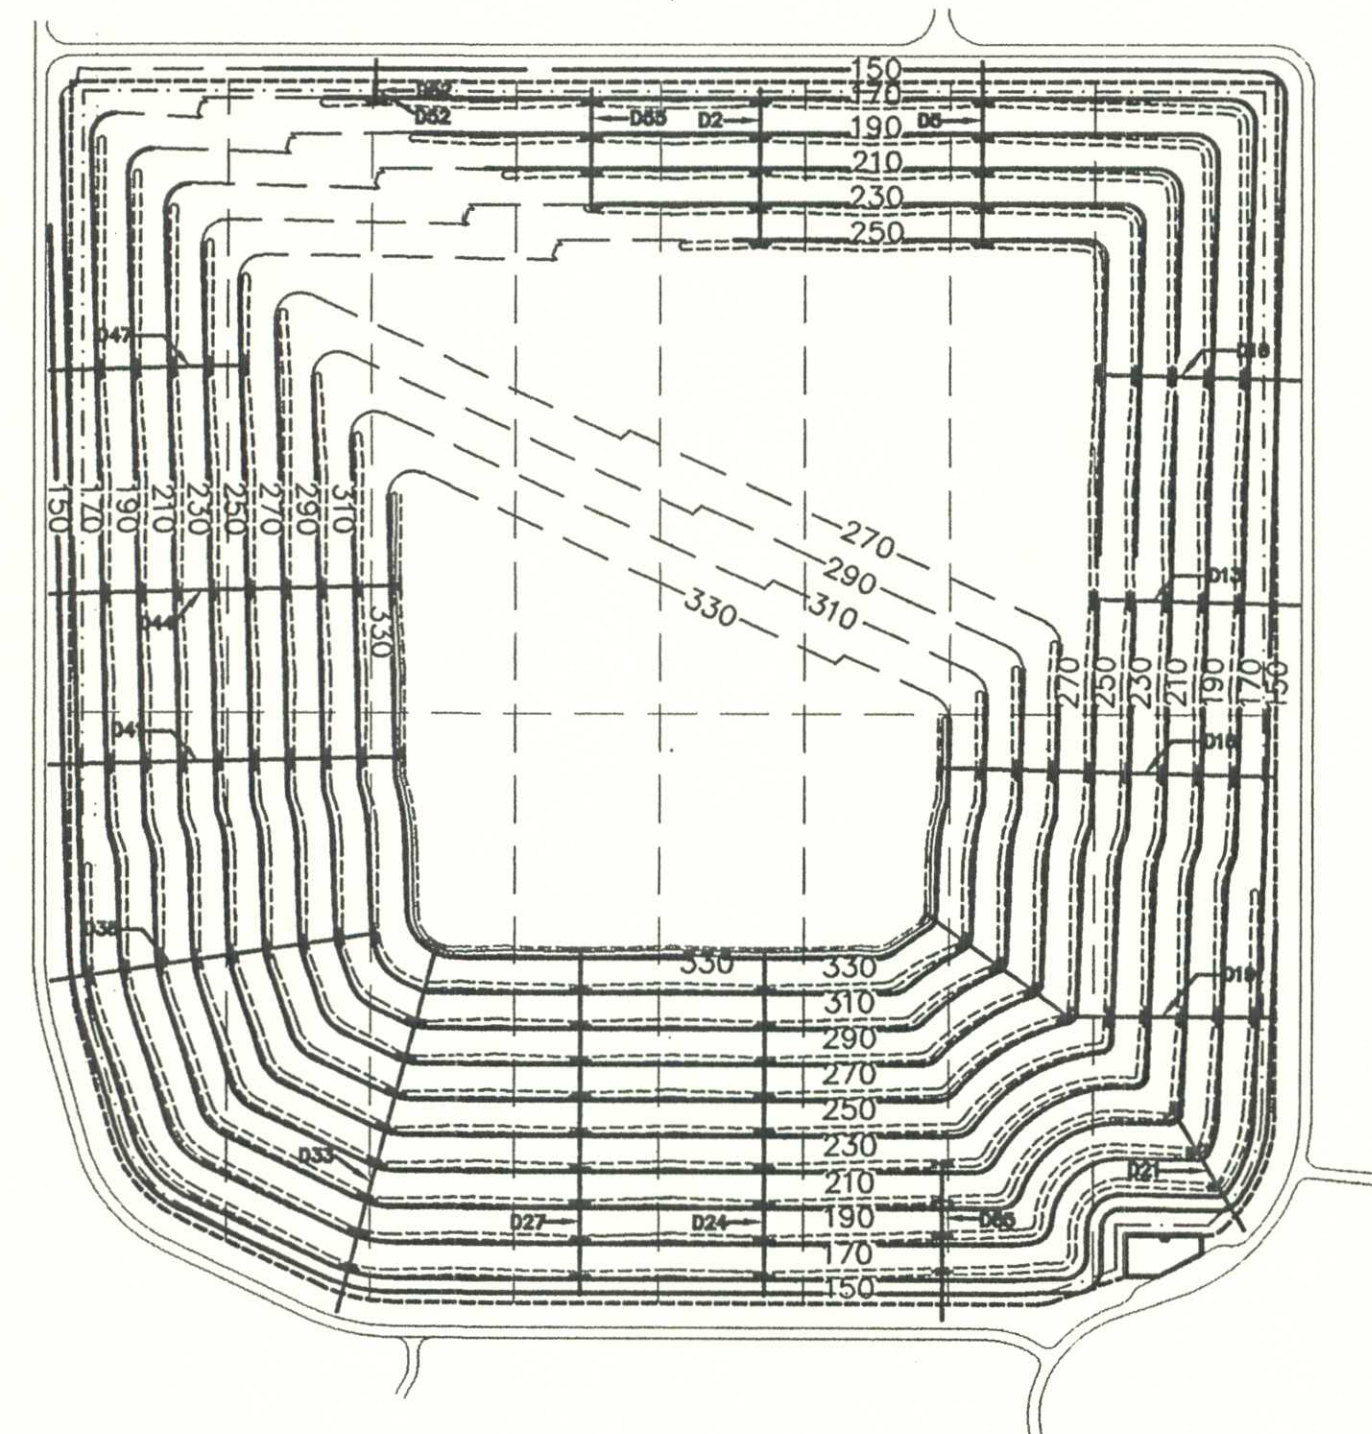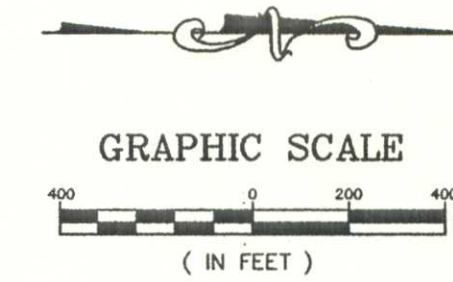

FILL PHASE 12

LEGEND

- 150— FINAL CONTOUR
- LIMITS OF LINER
- - - - - LINER PHASE LINE
- - - - - LIMITS OF FILL
- - - - - ACCESS ROAD
- ==== ROADWAY
- ===== TERRACE
- + + + + DOWNCOMER PIPE
- ////// 10' BERM

NOTE:
FILL PHASES MAY BE CHANGED
DUE TO OPERATIONAL NEEDS.

PERMIT DOCUMENT

FILL PHASING PLAN
TRAIL RIDGE LANDFILL PERMIT RENEWAL
FOR
TRAIL RIDGE LANDFILL, INC.

England-Thims & Miller, Inc.
Consulting & Design Engineers
3131 ST. JOHNS BLUFF ROAD SOUTH
JACKSONVILLE, FLORIDA 32246
PHONE NUMBER (904) 642-8990 FAX NUMBER (904) 646-9485



DRAWING NO.

12

REVISIONS:
2-25-00 REVISED FILL PHASES 7 - 12
TO INCLUDE EL. 230 & 250

ETN. NO. E 96 - 49

DRAWN BY: J.B.C.


DESIGNED BY: J.B.C.

CHECKED BY: D.C.M.



DATE: OCTOBER 28, 1996

SUBMITTED TO DEP: 10-28-96



Christina Cam
Boyle

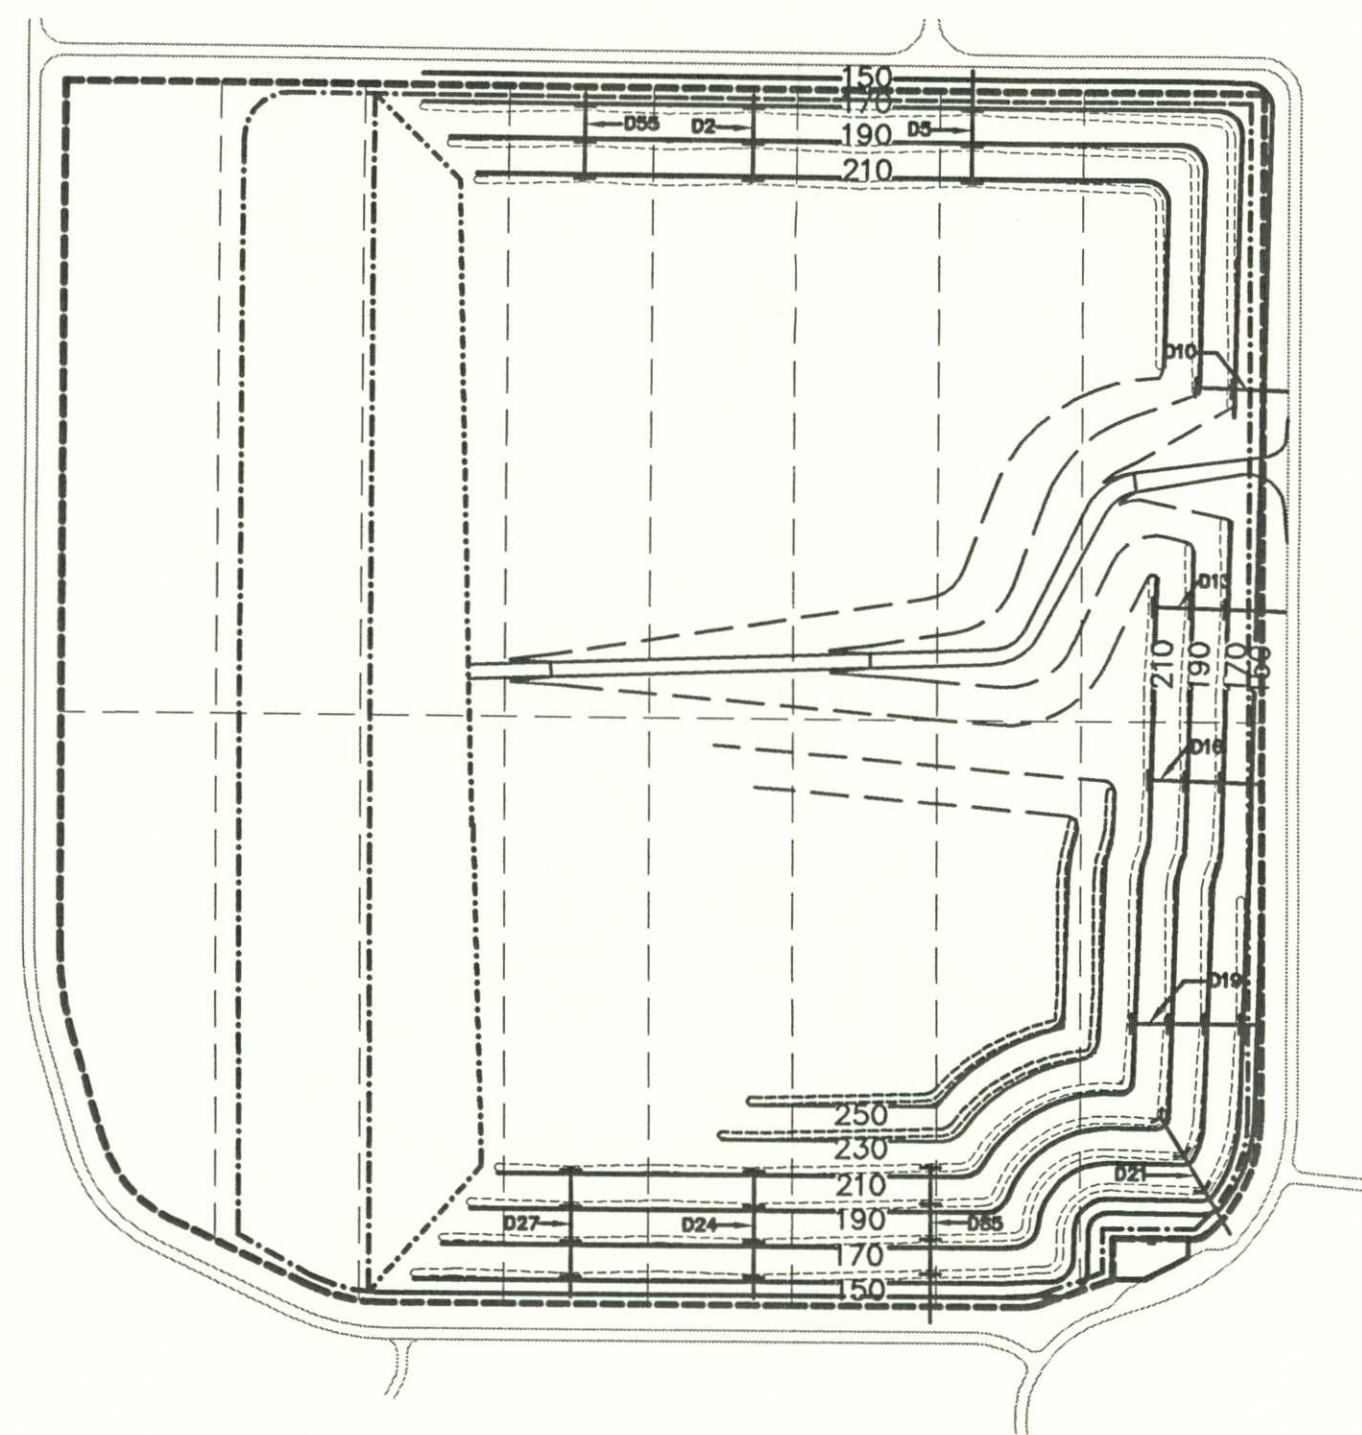



NOTE: THE WASTE PLACEMENT IN PHASES VA AND VC
WILL BE TO THE TOP OF THE ANCHOR BERM.

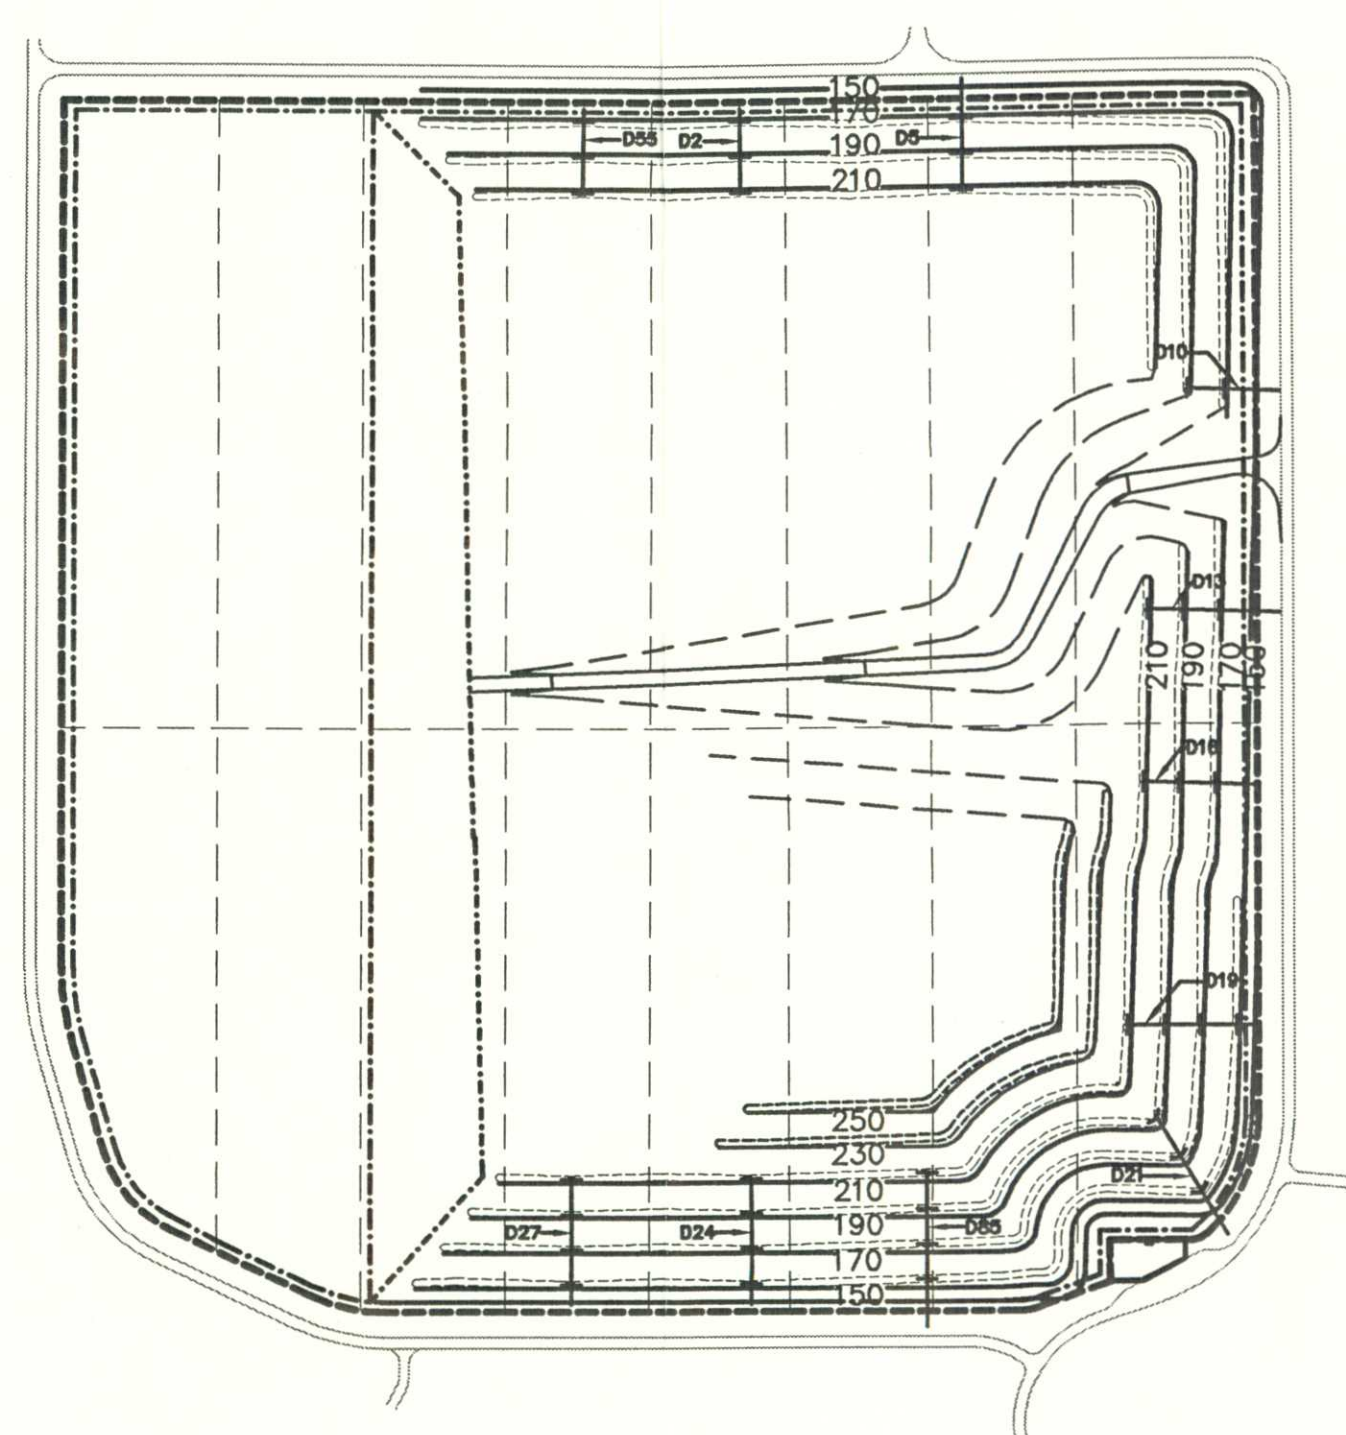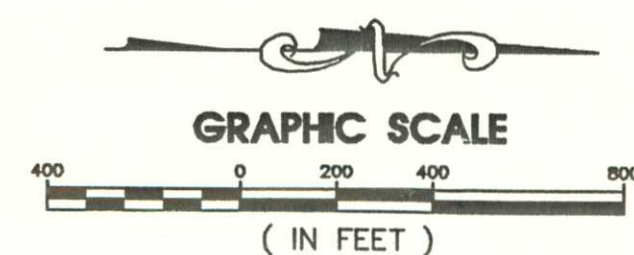


NOTE: THE WASTE PLACEMENT IN PHASES VB AND VD
WILL BE TO THE TOP OF THE ANCHOR BERM.

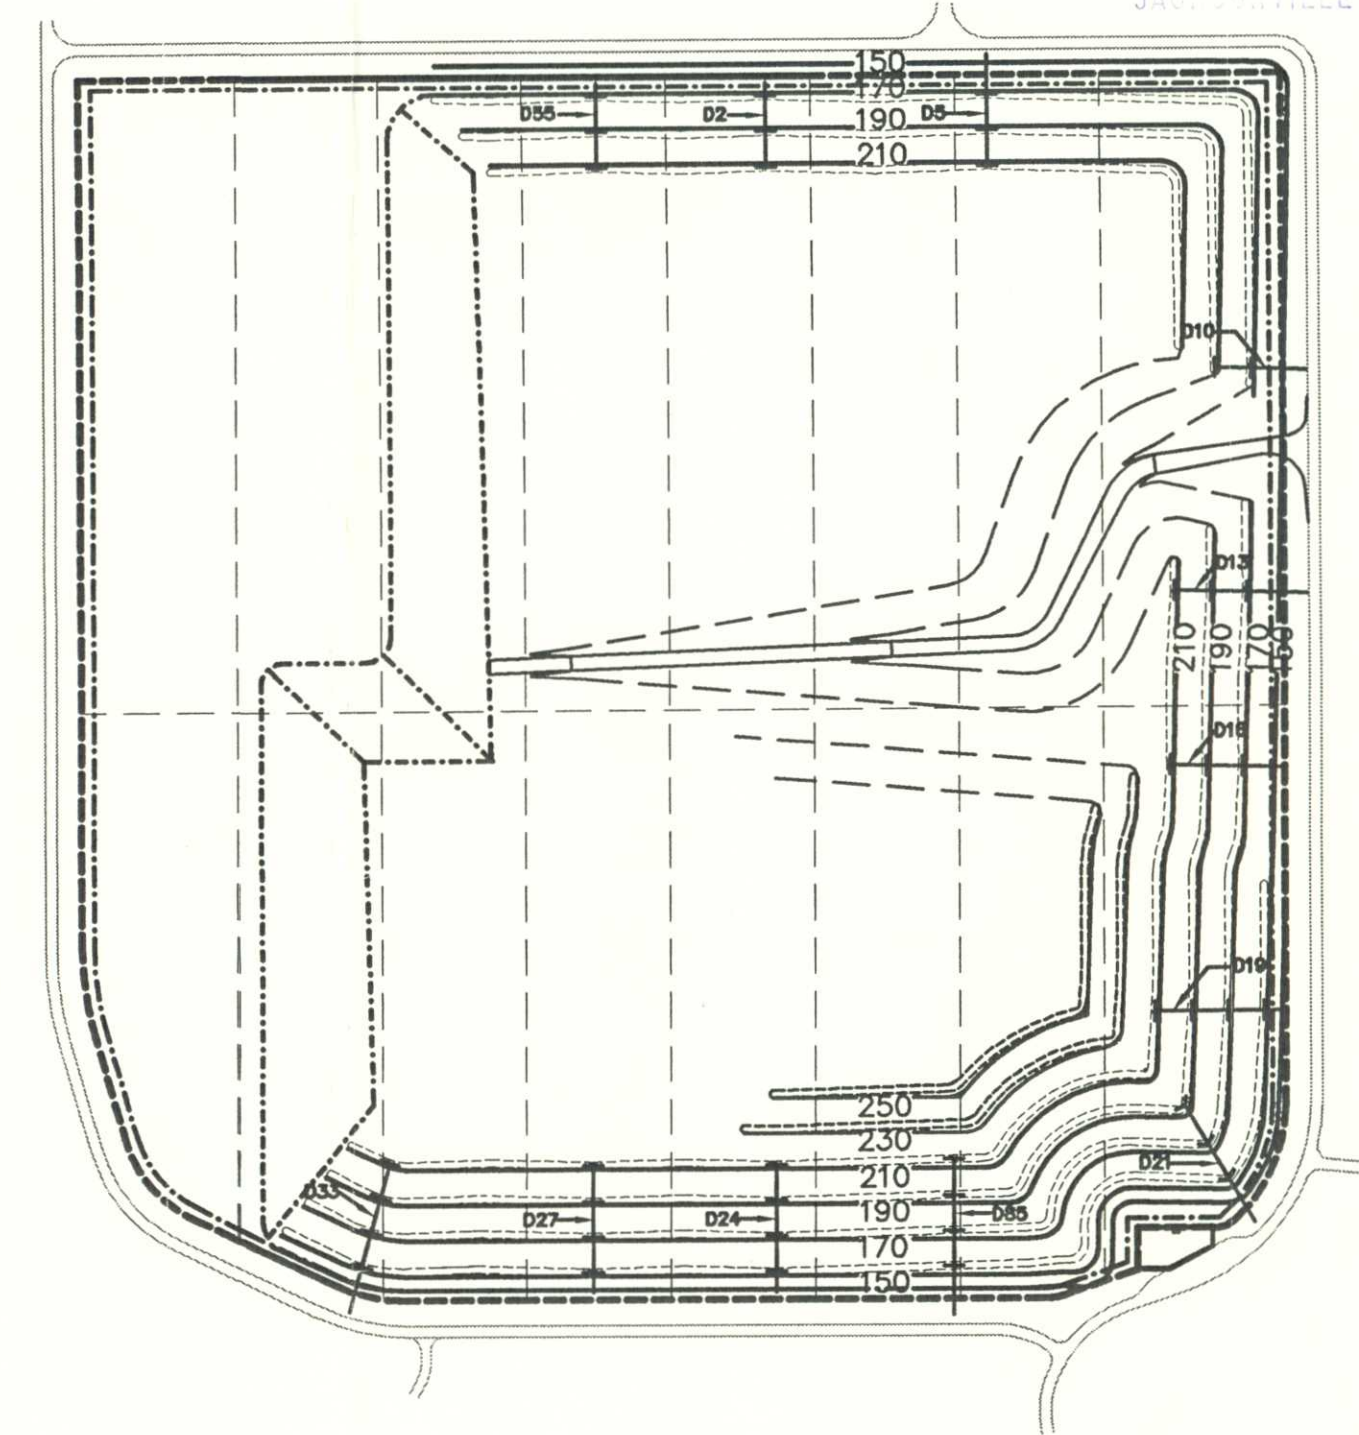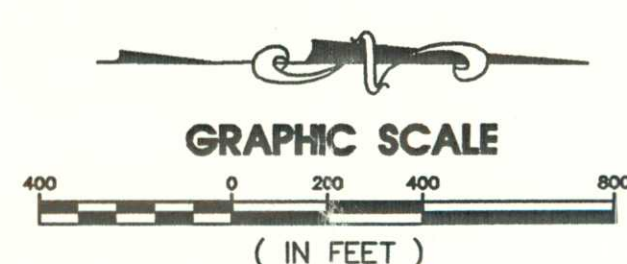


FILL PHASE 7

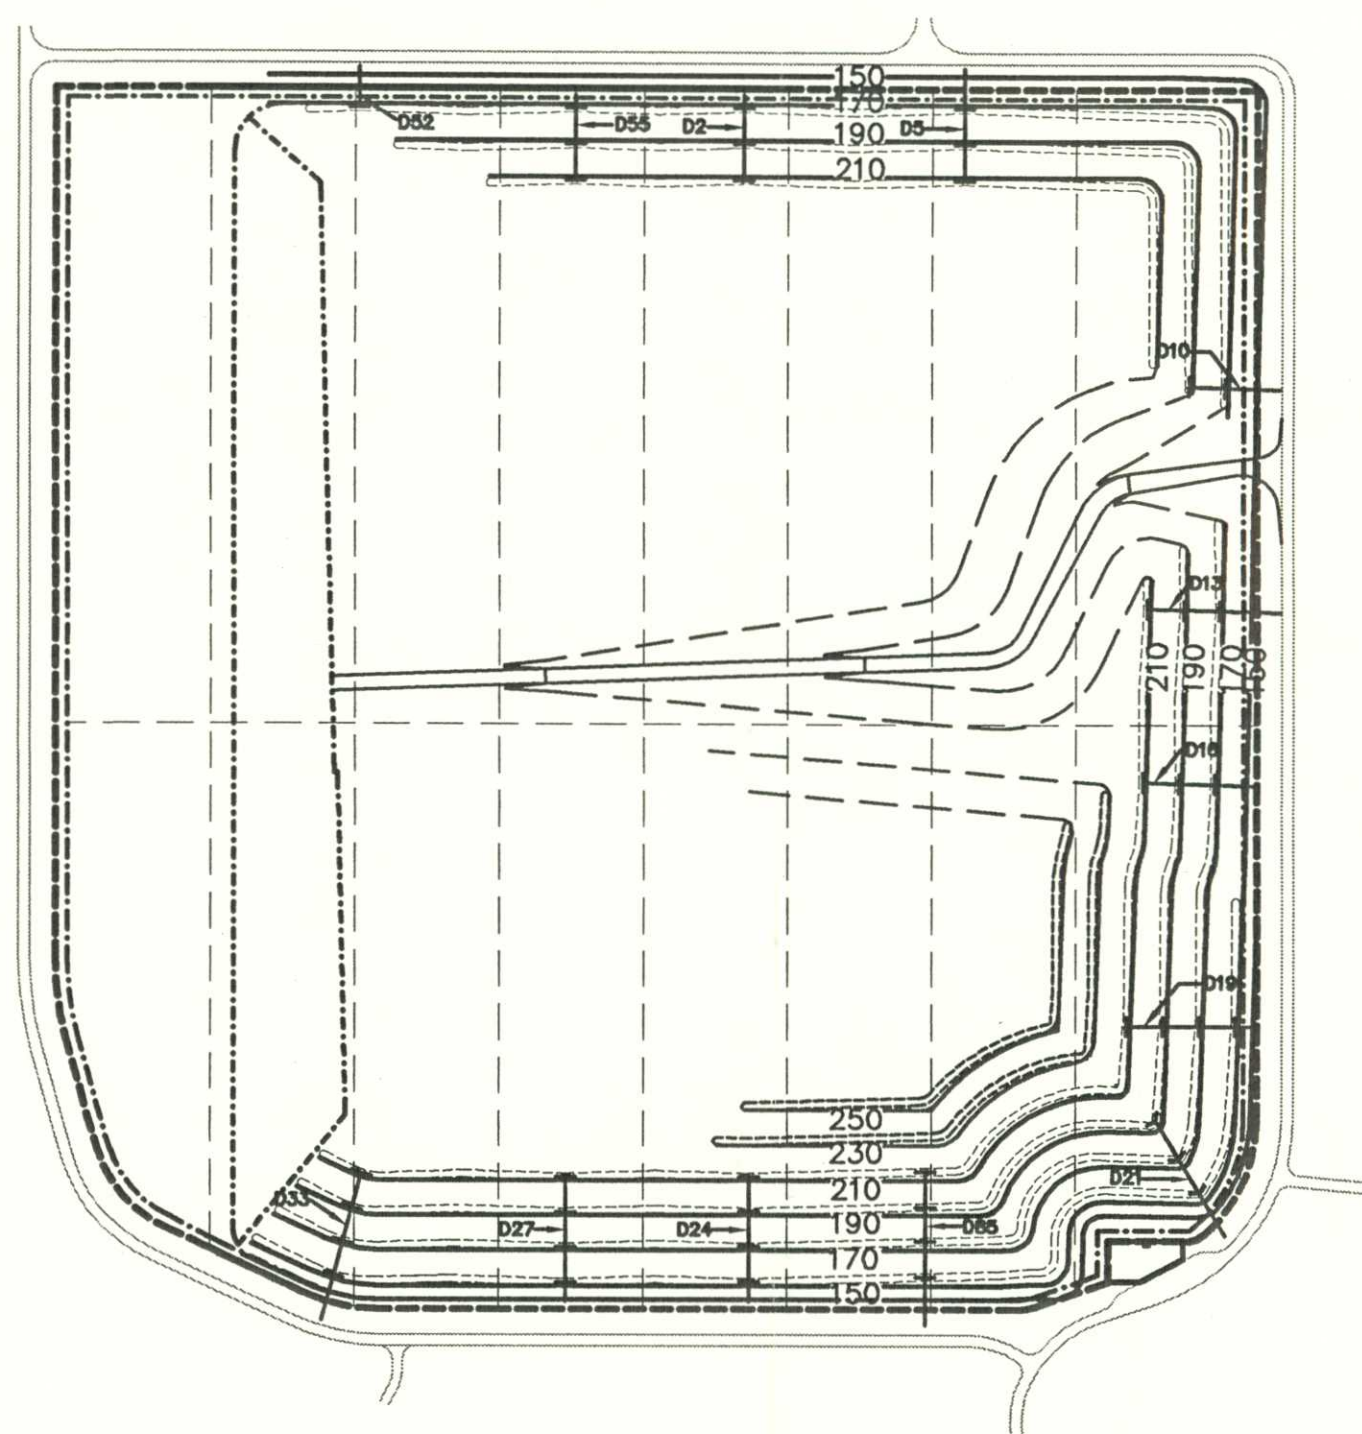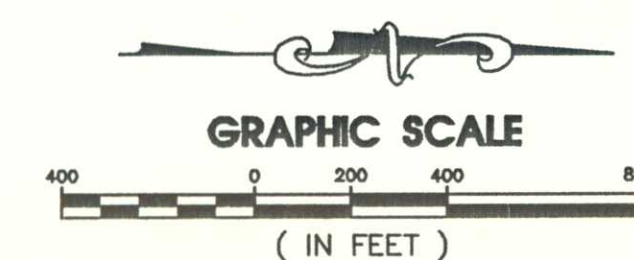

FILL PHASE 8

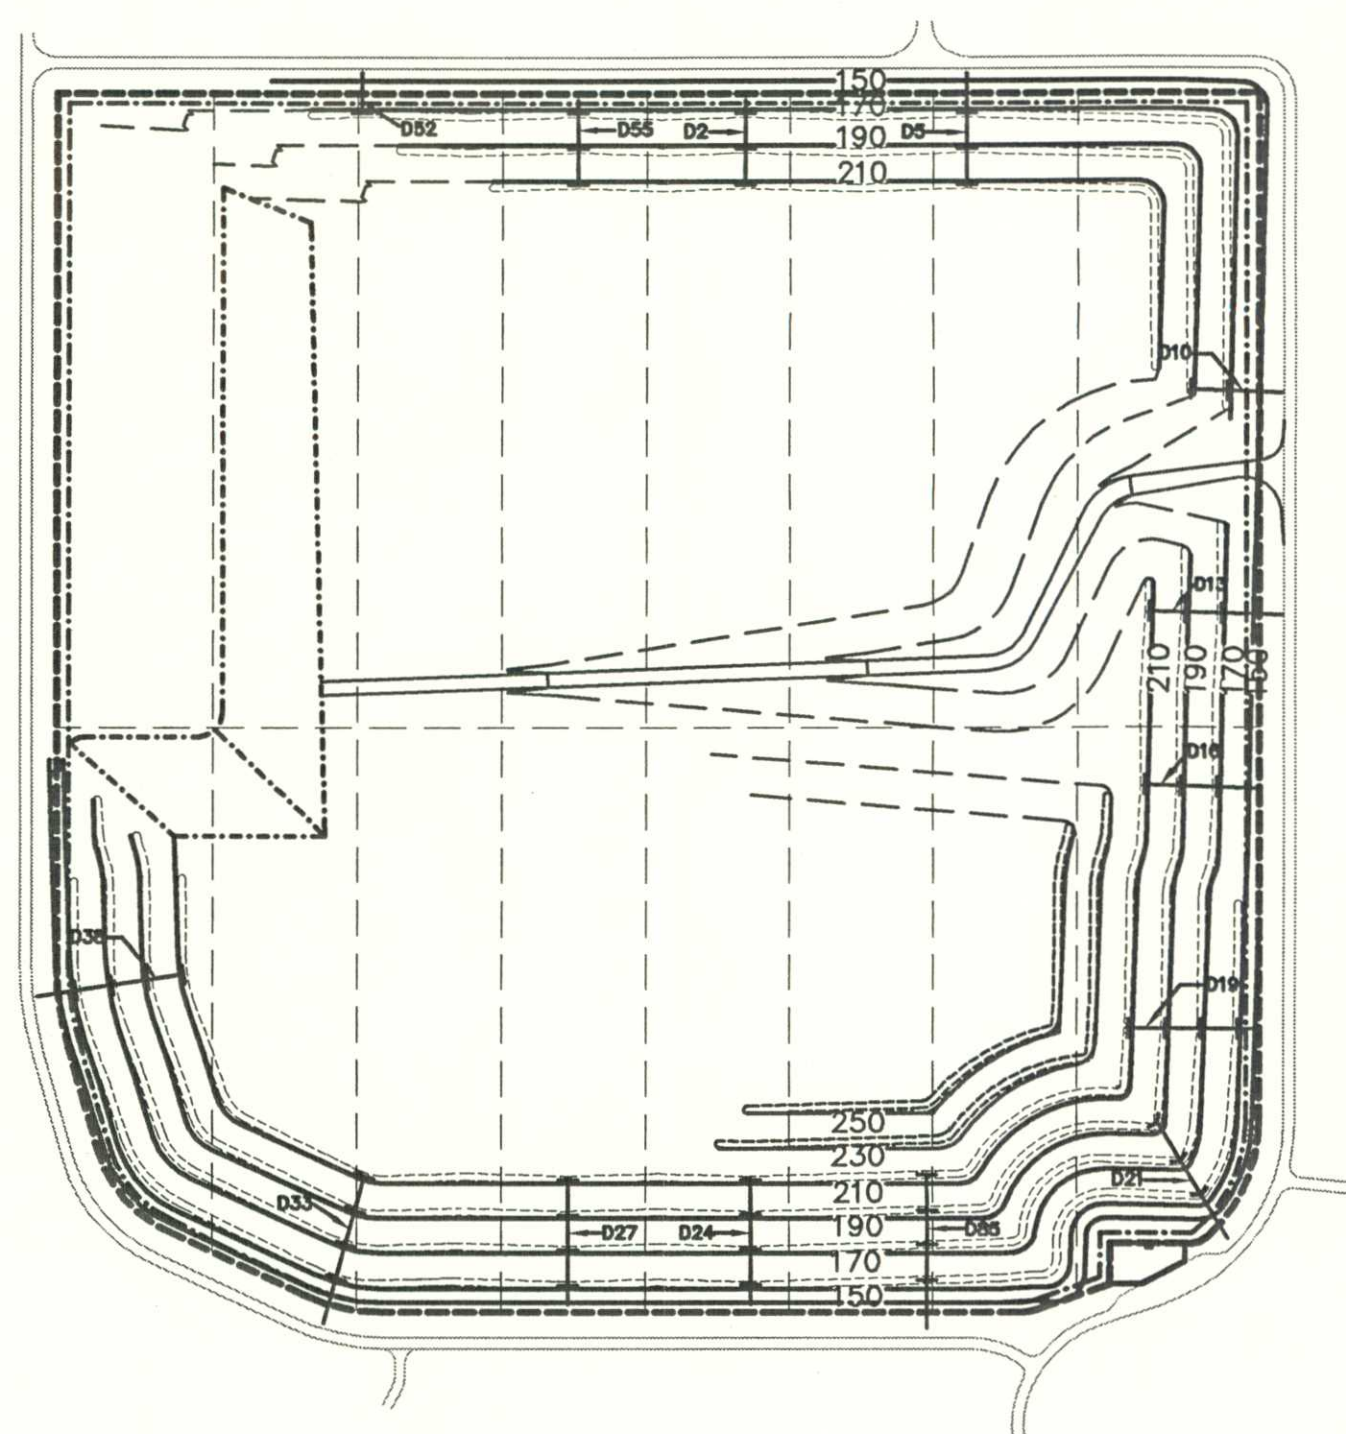

FILL PHASE 9

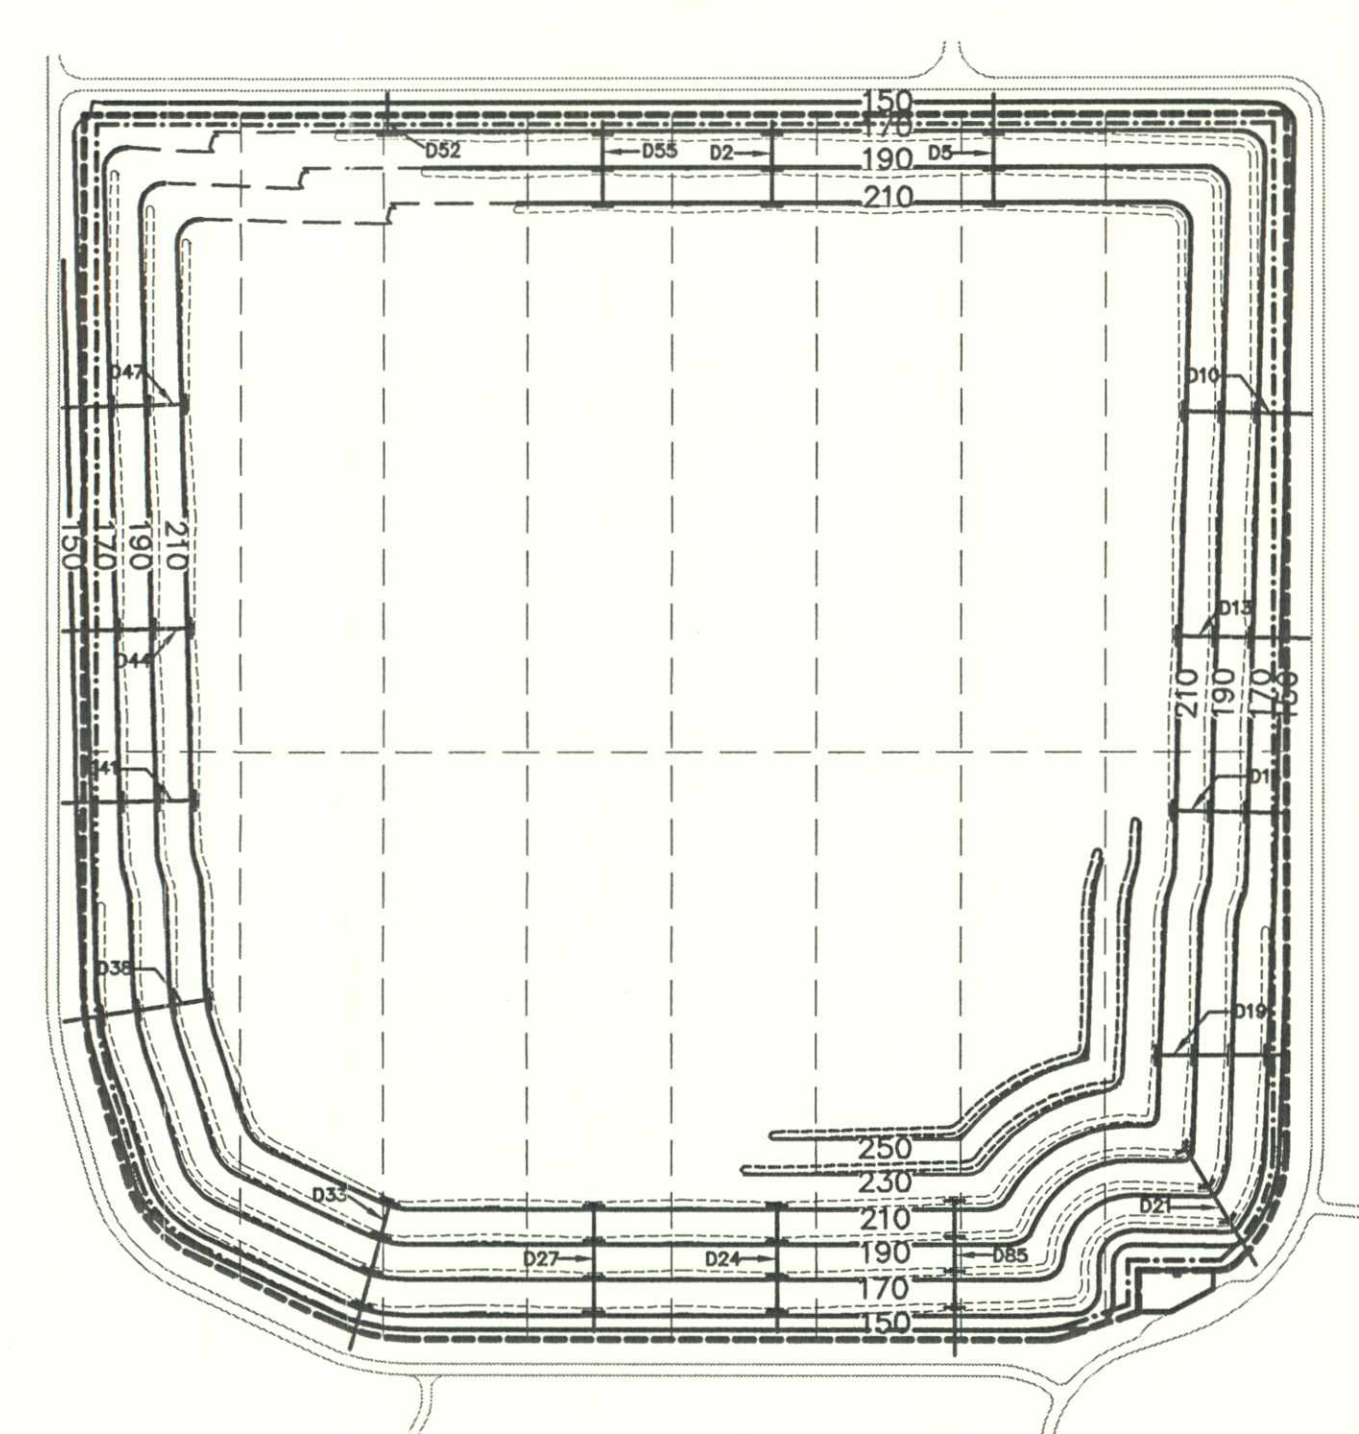

FILL PHASE 10

NOTE
FILL PHASING MAY BE CHANGED
DUE TO OPERATIONAL NEEDS.

LEGEND

—150—	FINAL CONTOUR
— — — — —	LIMITS OF LINER
— — — — —	LINER PHASE LINE
- . - . - . - . - . - .	LIMITS OF FILL
=====	ACCESS ROAD
=====	ROADWAY
-----	TERRACE
+ + + + +	DOWNCOMER PIPE

STATE OF FLORIDA
DEP - NE DISTRICT
JACKSONVILLE

PERMIT DOCUMENT

FILL PHASING PLAN

**TRAIL RIDGE LANDFILL PERMIT RENEWAL
FOR
TRAIL RIDGE LANDFILL, INC.**

England • Thimby & Miller, Inc.
ENGINEERS - PLANNERS - SURVEYORS - LANDSCAPE ARCHITECTS
14776 ST. AUGUSTINE ROAD JACKSONVILLE, FLORIDA 32258
CERTIFICATE OF AUTHORIZATION NUMBER: 2584
PHONE NUMBER (904) 642-8980 FAX NUMBER (904) 646-8486



12

SUBMITTED TO DEP: 10-28-96

REVISIONS:

2-25-00 REVISED FILL PHASES 7 - 12
TO INCLUDE EL. 230 & 250

2-6-00 REVISED FILL PHASES 7, 10
TO REMOVE WESTERN HIGH RISE
(EL. 230 & 250)

1-15-01 ADDED FILL PHASES 6A AND 6B AND
MODIFIED FILL PHASES 7, 8 & 9
ACCORDINGLY





ETM NO. E 98-49

DRAWN BY: JBC

DESIGNED BY: IBC

DESIGNED BY: J.B.C.


DATE: OCTOBER 28 1998

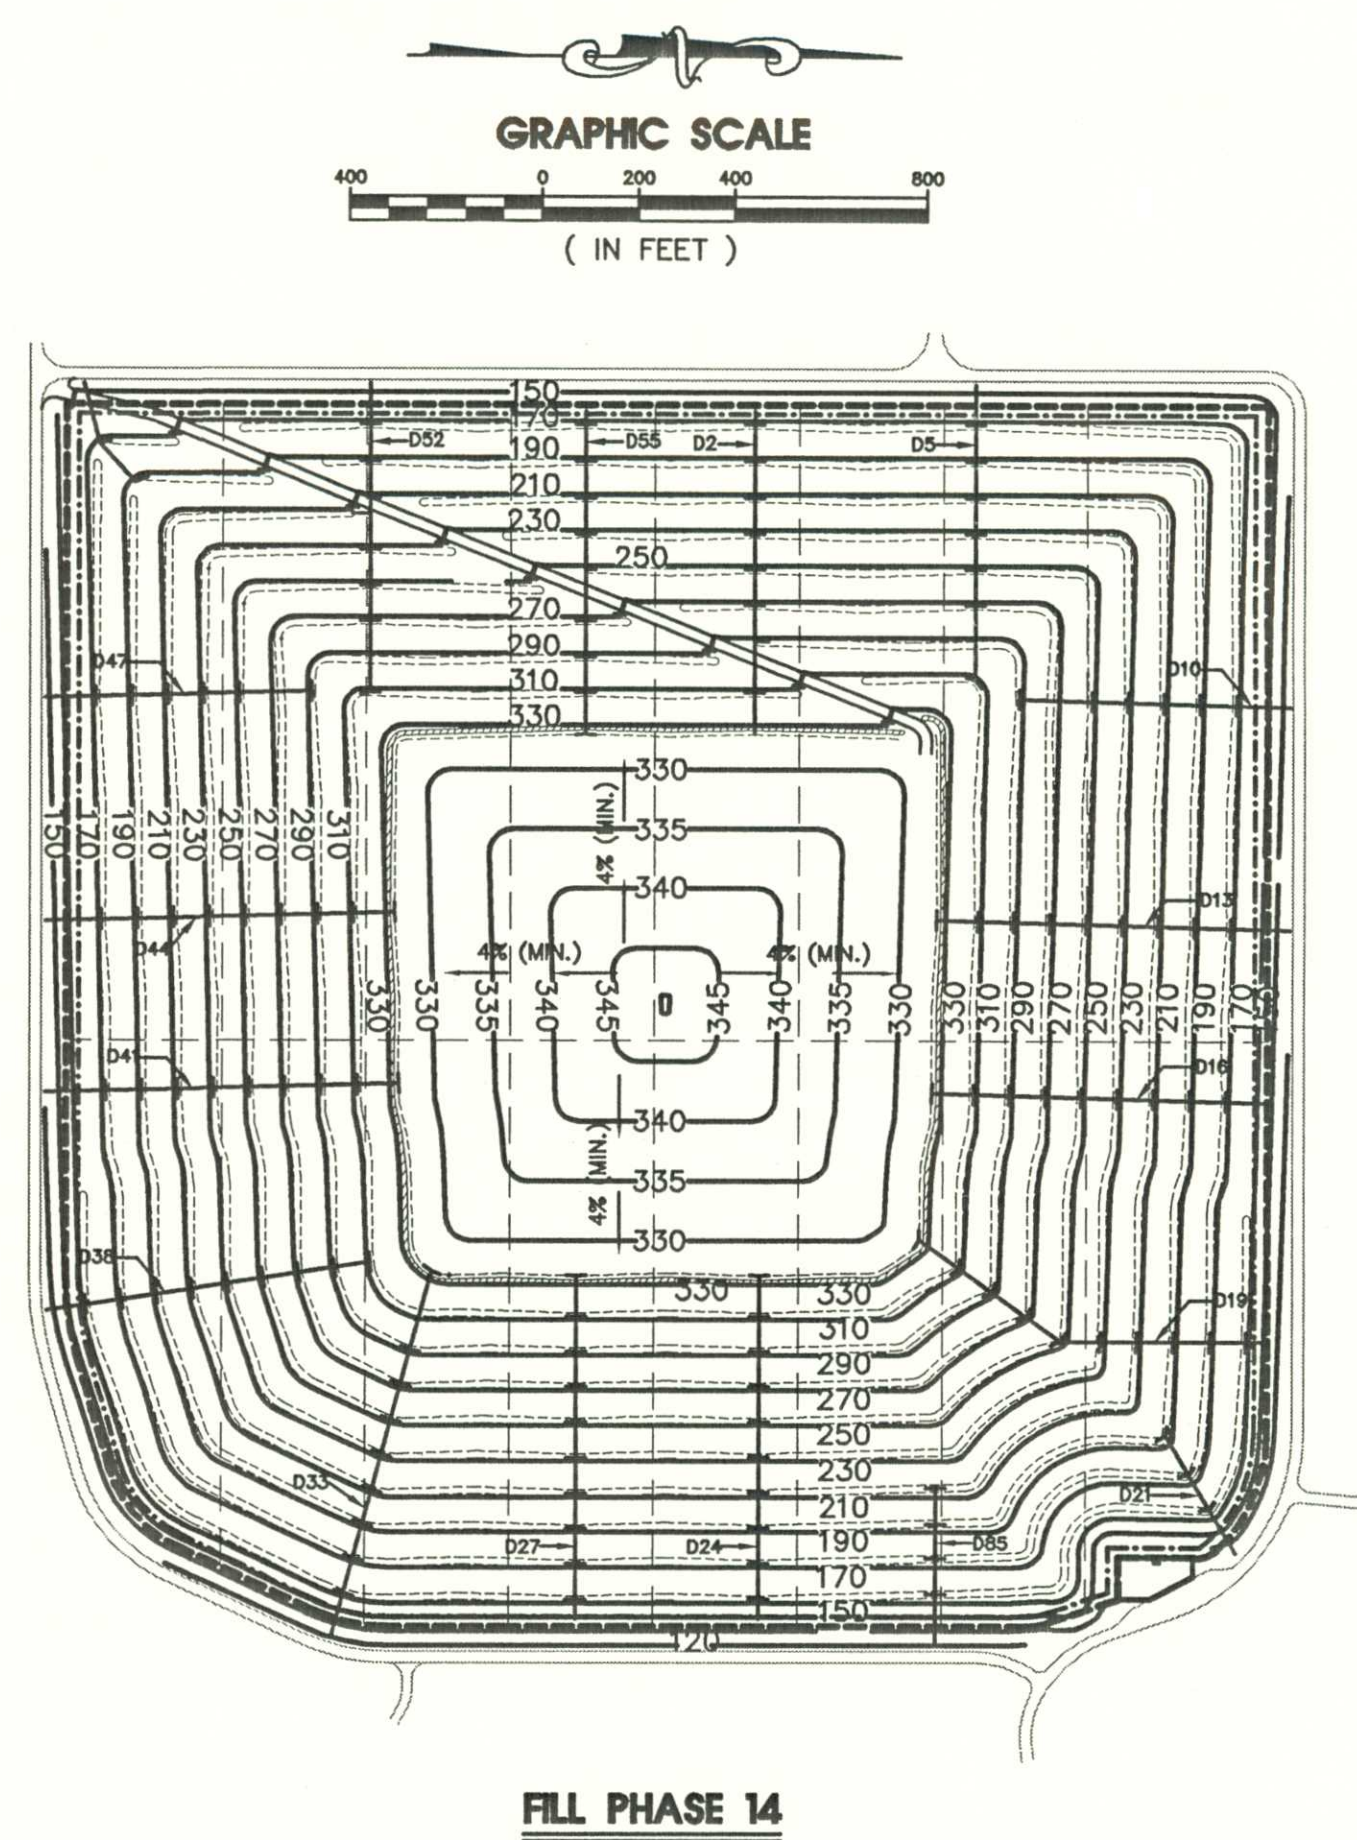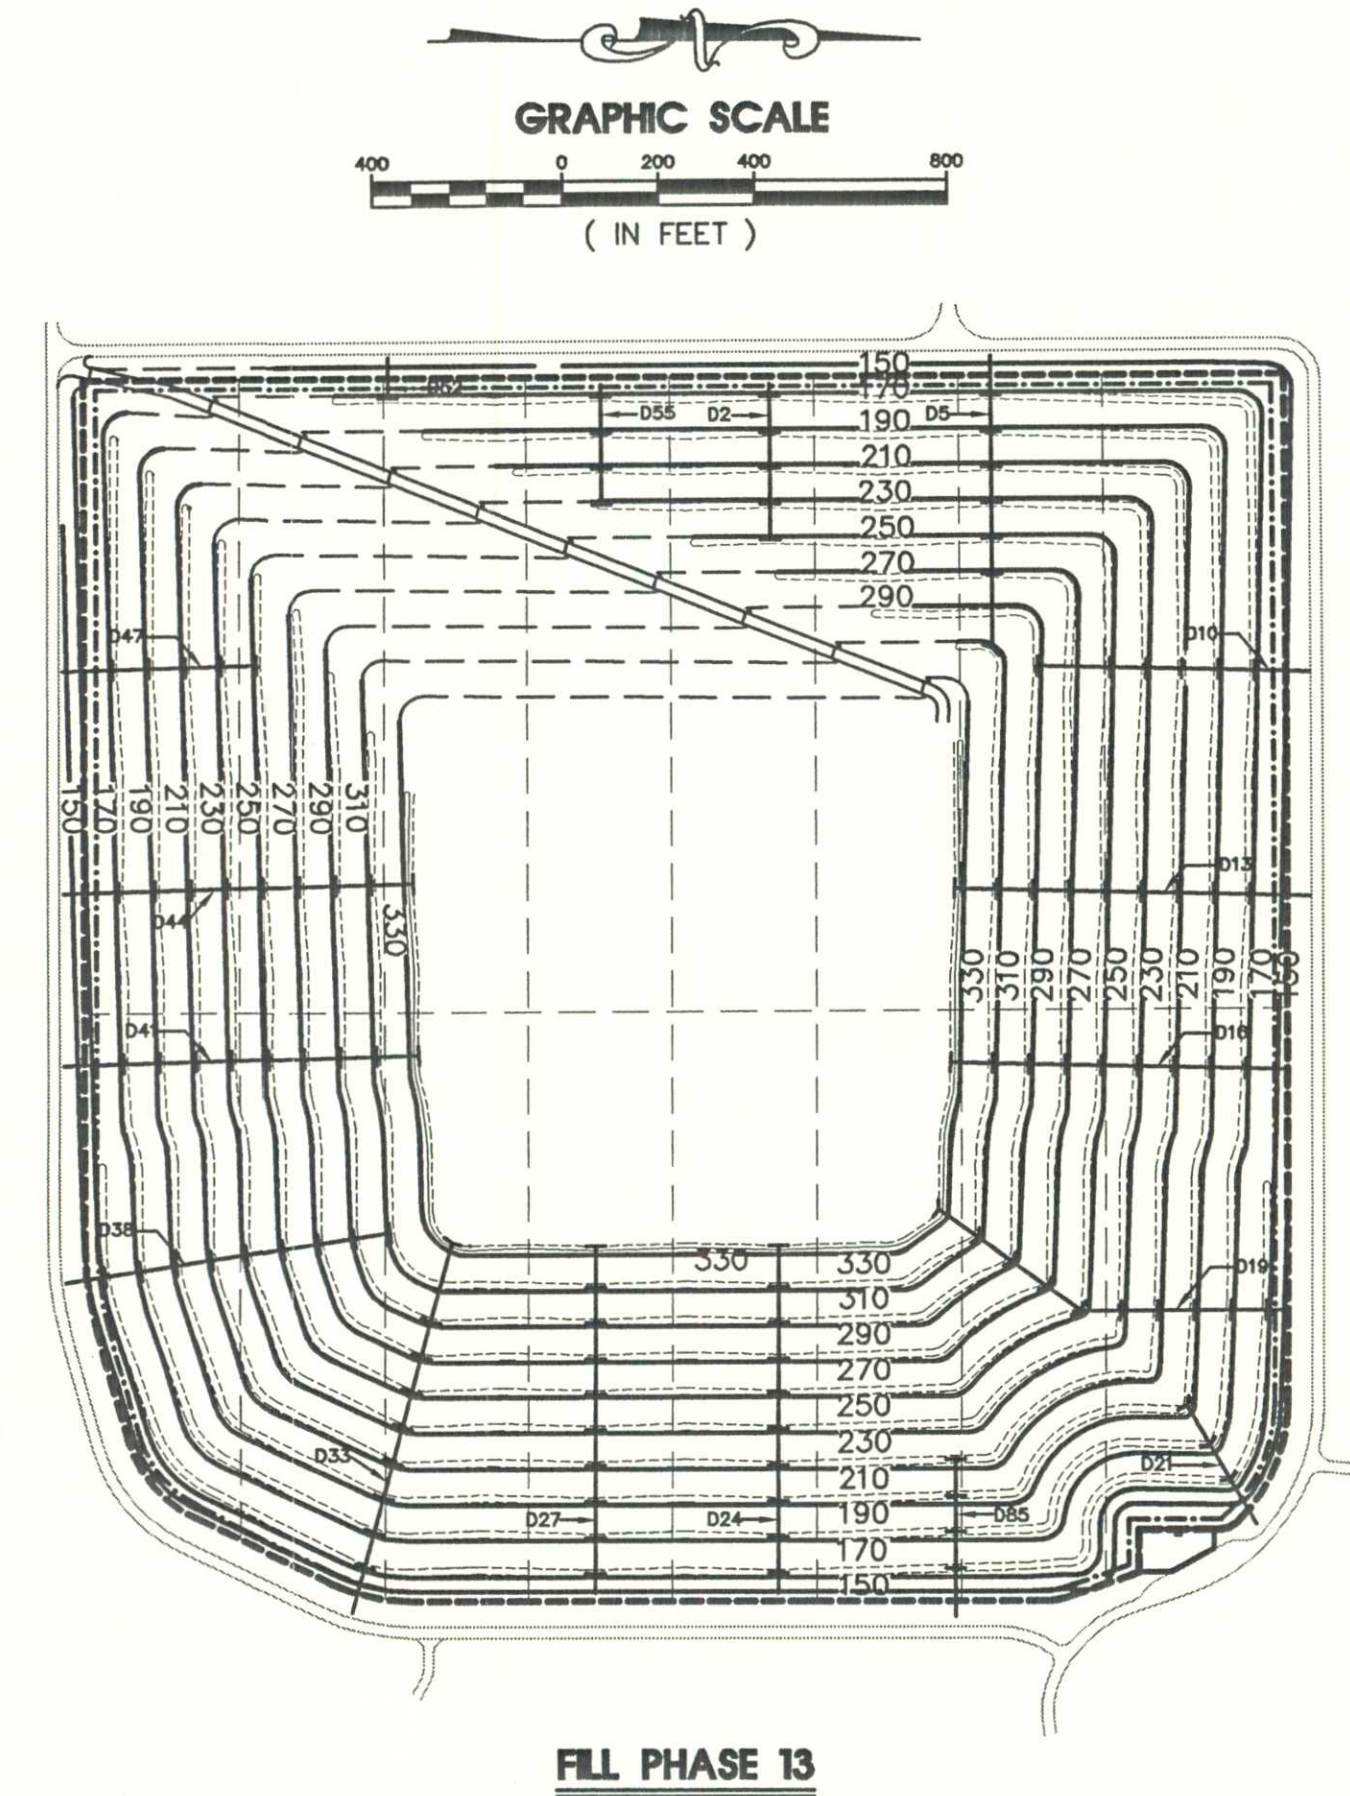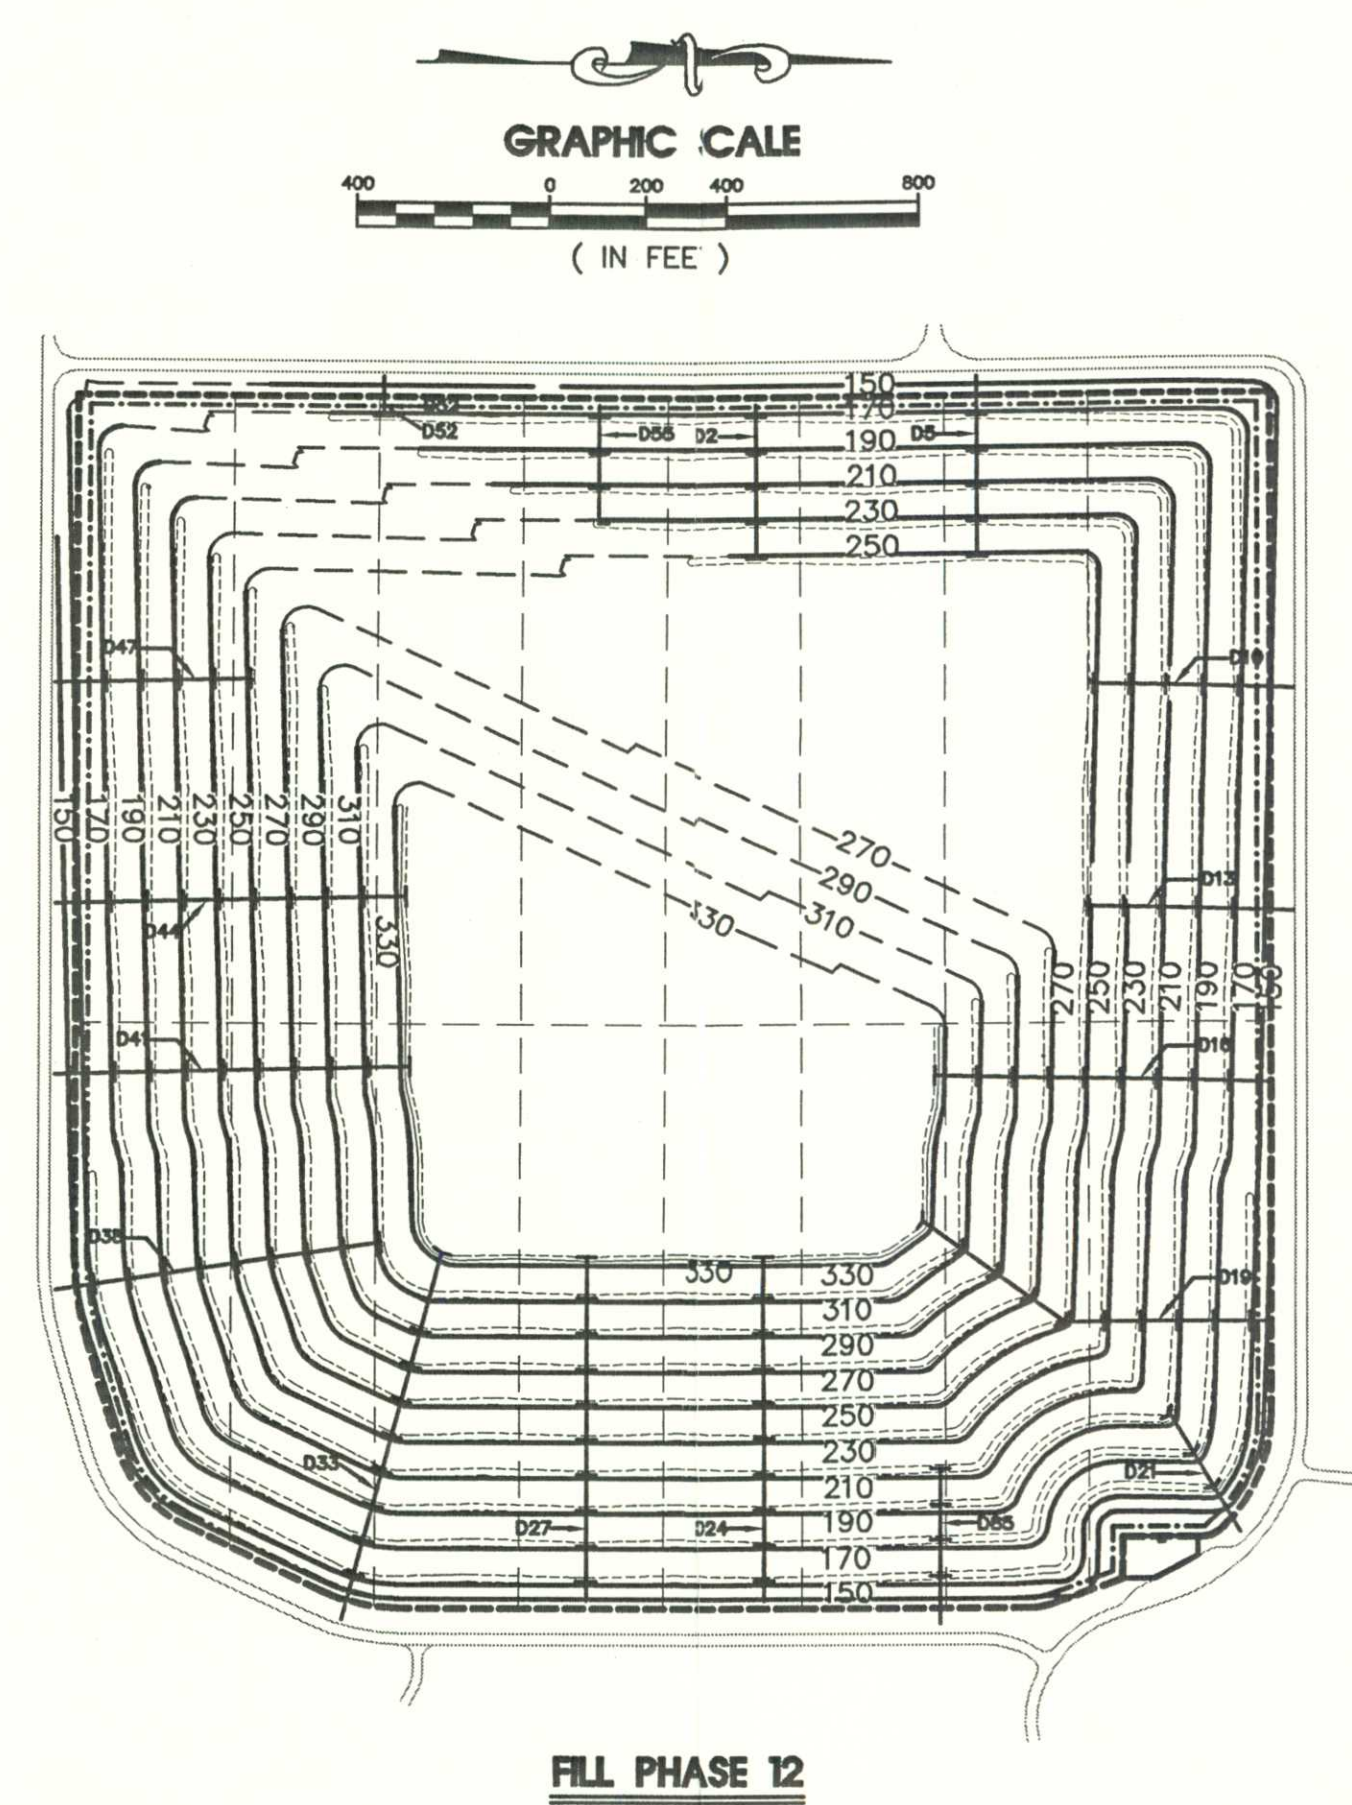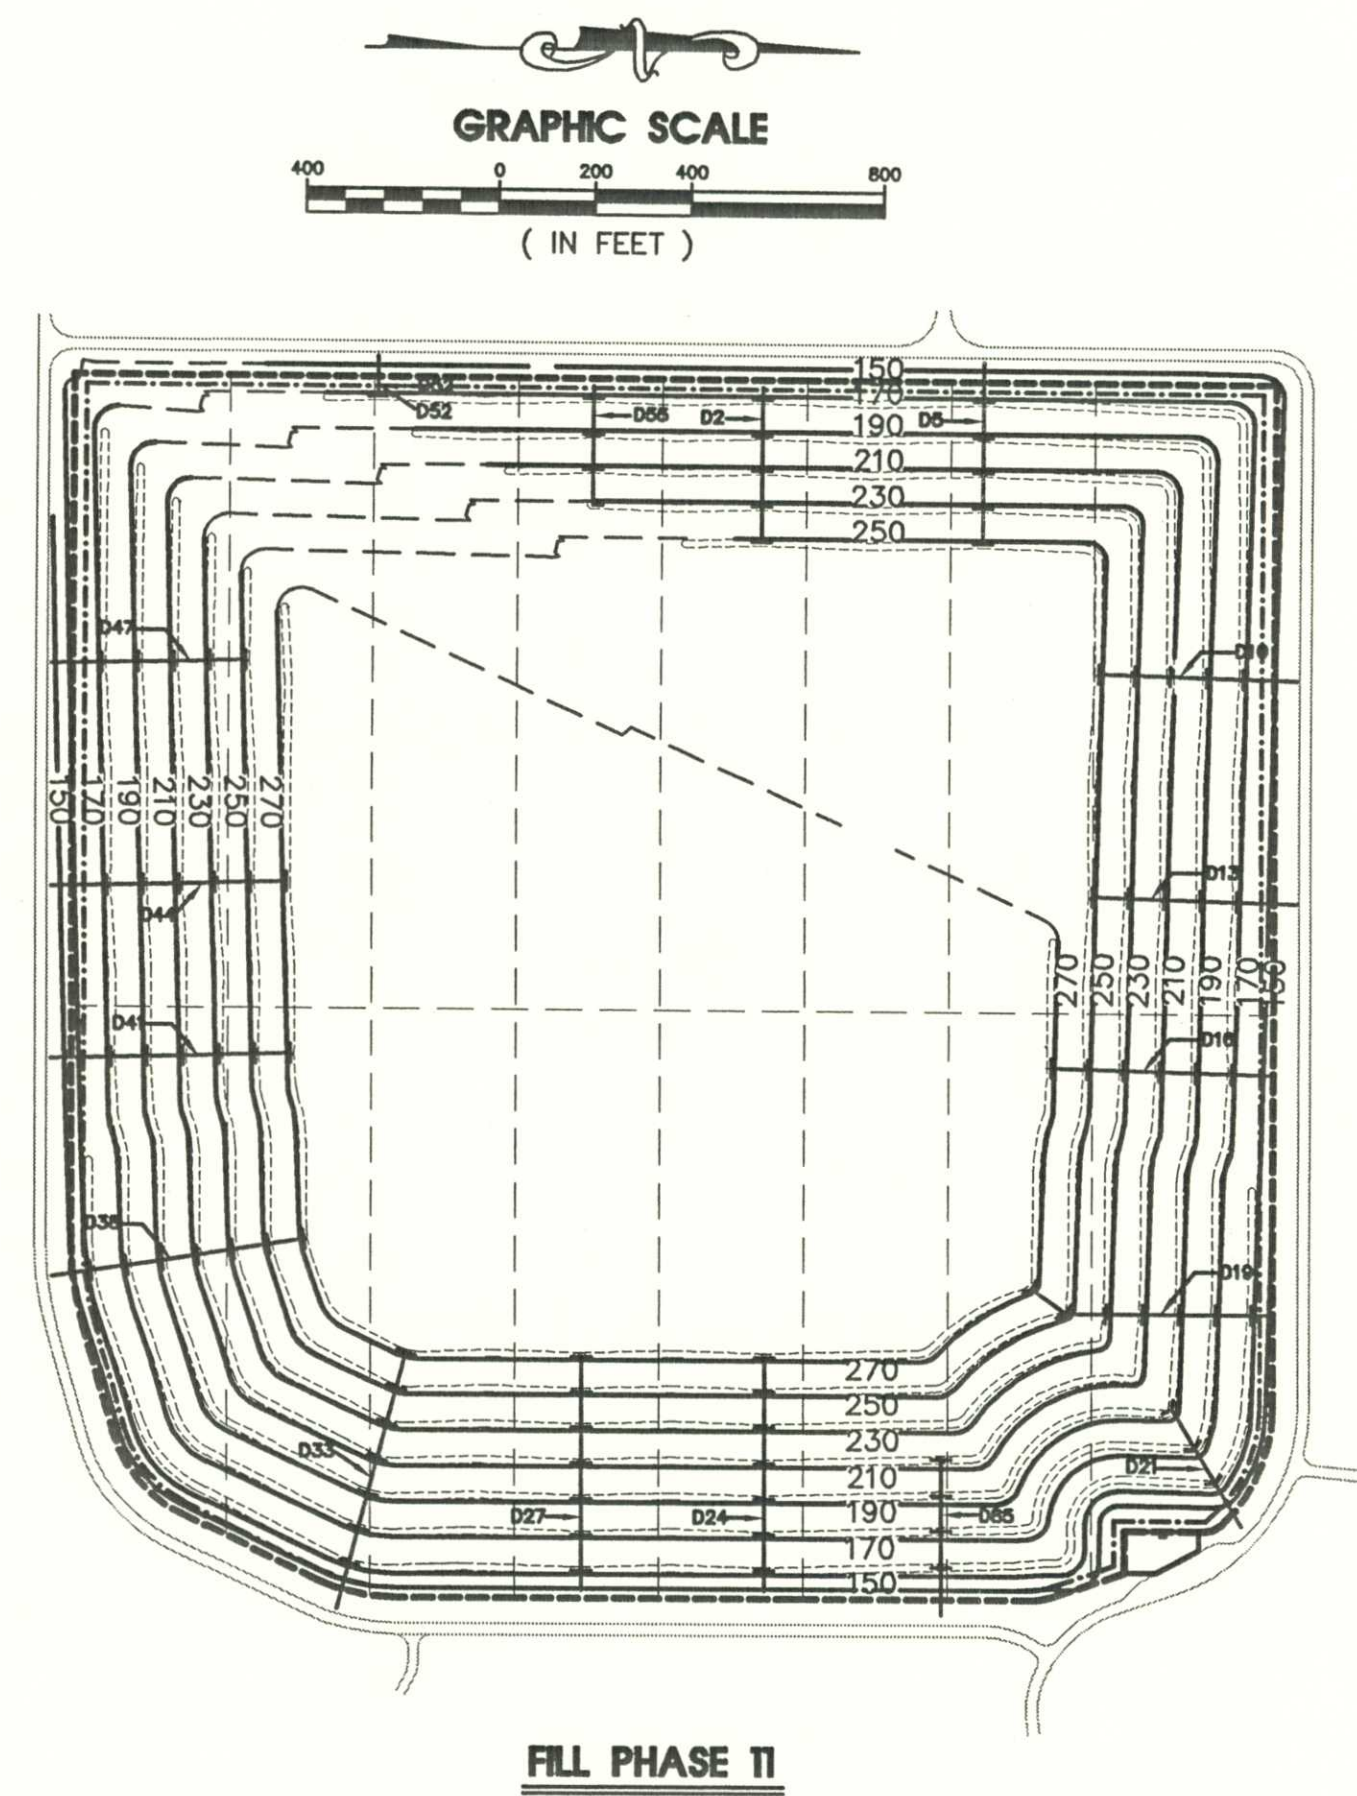

NOTE
FILL PHASING MAY BE CHANGED
DUE TO OPERATIONAL NEEDS.

- LEGEND**

 - 150— FINAL CONTOUR
 - LIMITS OF LINER
 - - - - - LINER PHASE LINE
 - · - · - · - LIMITS OF FILL
 - ===== ACCESS ROAD
 - ===== ROADWAY
 - ===== TERRACE
 - + + + + + DOWNCOMER PIPE
 - ===== 10' BERM

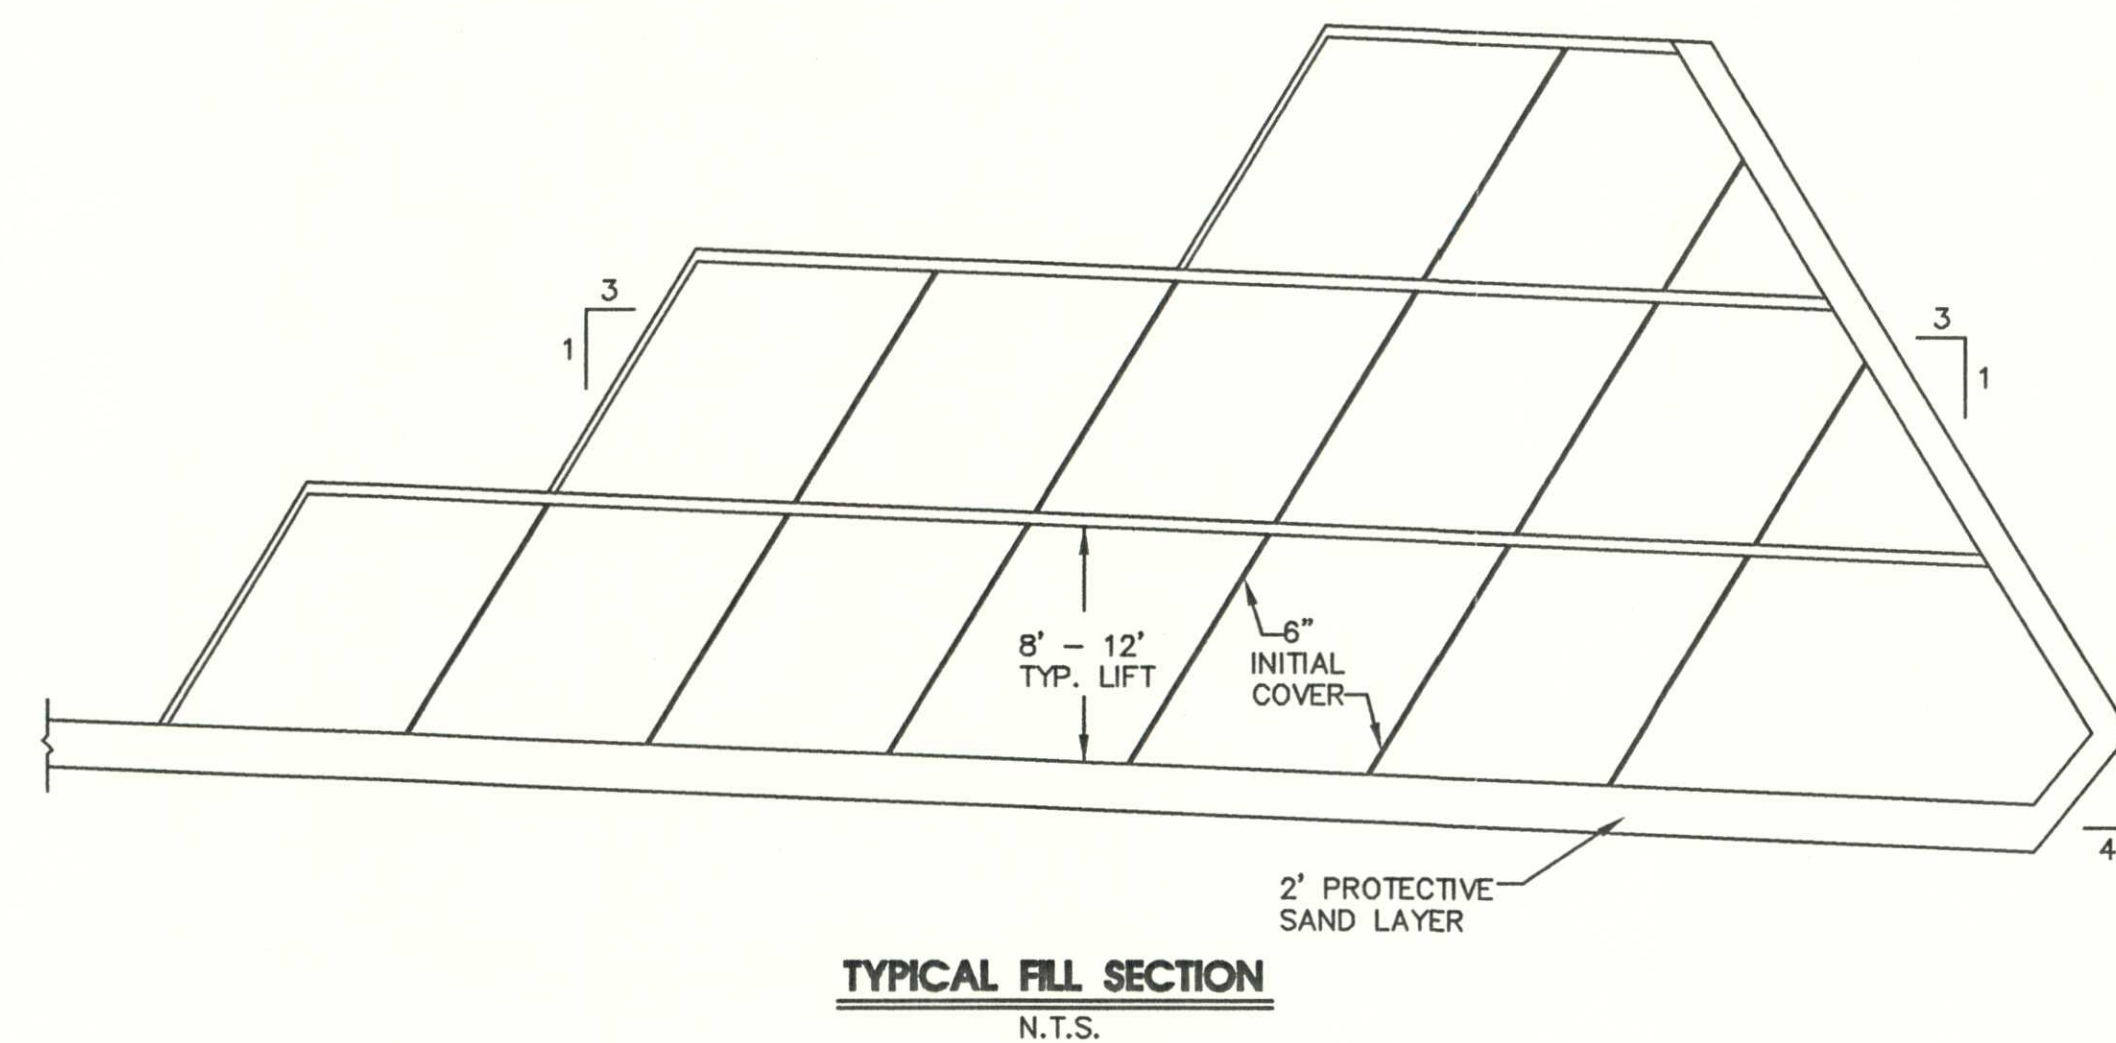

PERMIT DOCUMENT

FILL PHASING PLAN

**TRAIL RIDGE LANDFILL PERMIT RENEWAL
FOR
TRAIL RIDGE LANDFILL, INC.**

England-Thim & Miller, Inc.
ENGINEERS - PLANNERS - SURVEYORS - LANDSCAPE ARCHITECTS
14776 ST. AUGUSTINE ROAD JACKSONVILLE, FLORIDA 32268
CERTIFICATE OF AUTHORIZATION NUMBER: 2584
PHONE NUMBER (904) 842-8980 FAX NUMBER (904) 846-9485

DRAWING NO.

13

SUBMITTED TO DEP: 10-28-96

REVISIONS:

2-25-00	REVISED FILL PHASES 7 - 12 TO INCLUDE EL 230 & 250
2-2-6-00	TO REVISED FILL PHASES 7 - 10 TO REMOVE WESTERN HIGH RISE (EL 230 & 250)
11-15-01	MOVED FILL PHASES 11 AND 12 TO THIS SHEET.

ETM NO. E 96-49
DRAWN BY: J.B.C.
DESIGNED BY: J.B.C.
CHECKED BY: D.C.M.
DATE: OCTOBER 28