


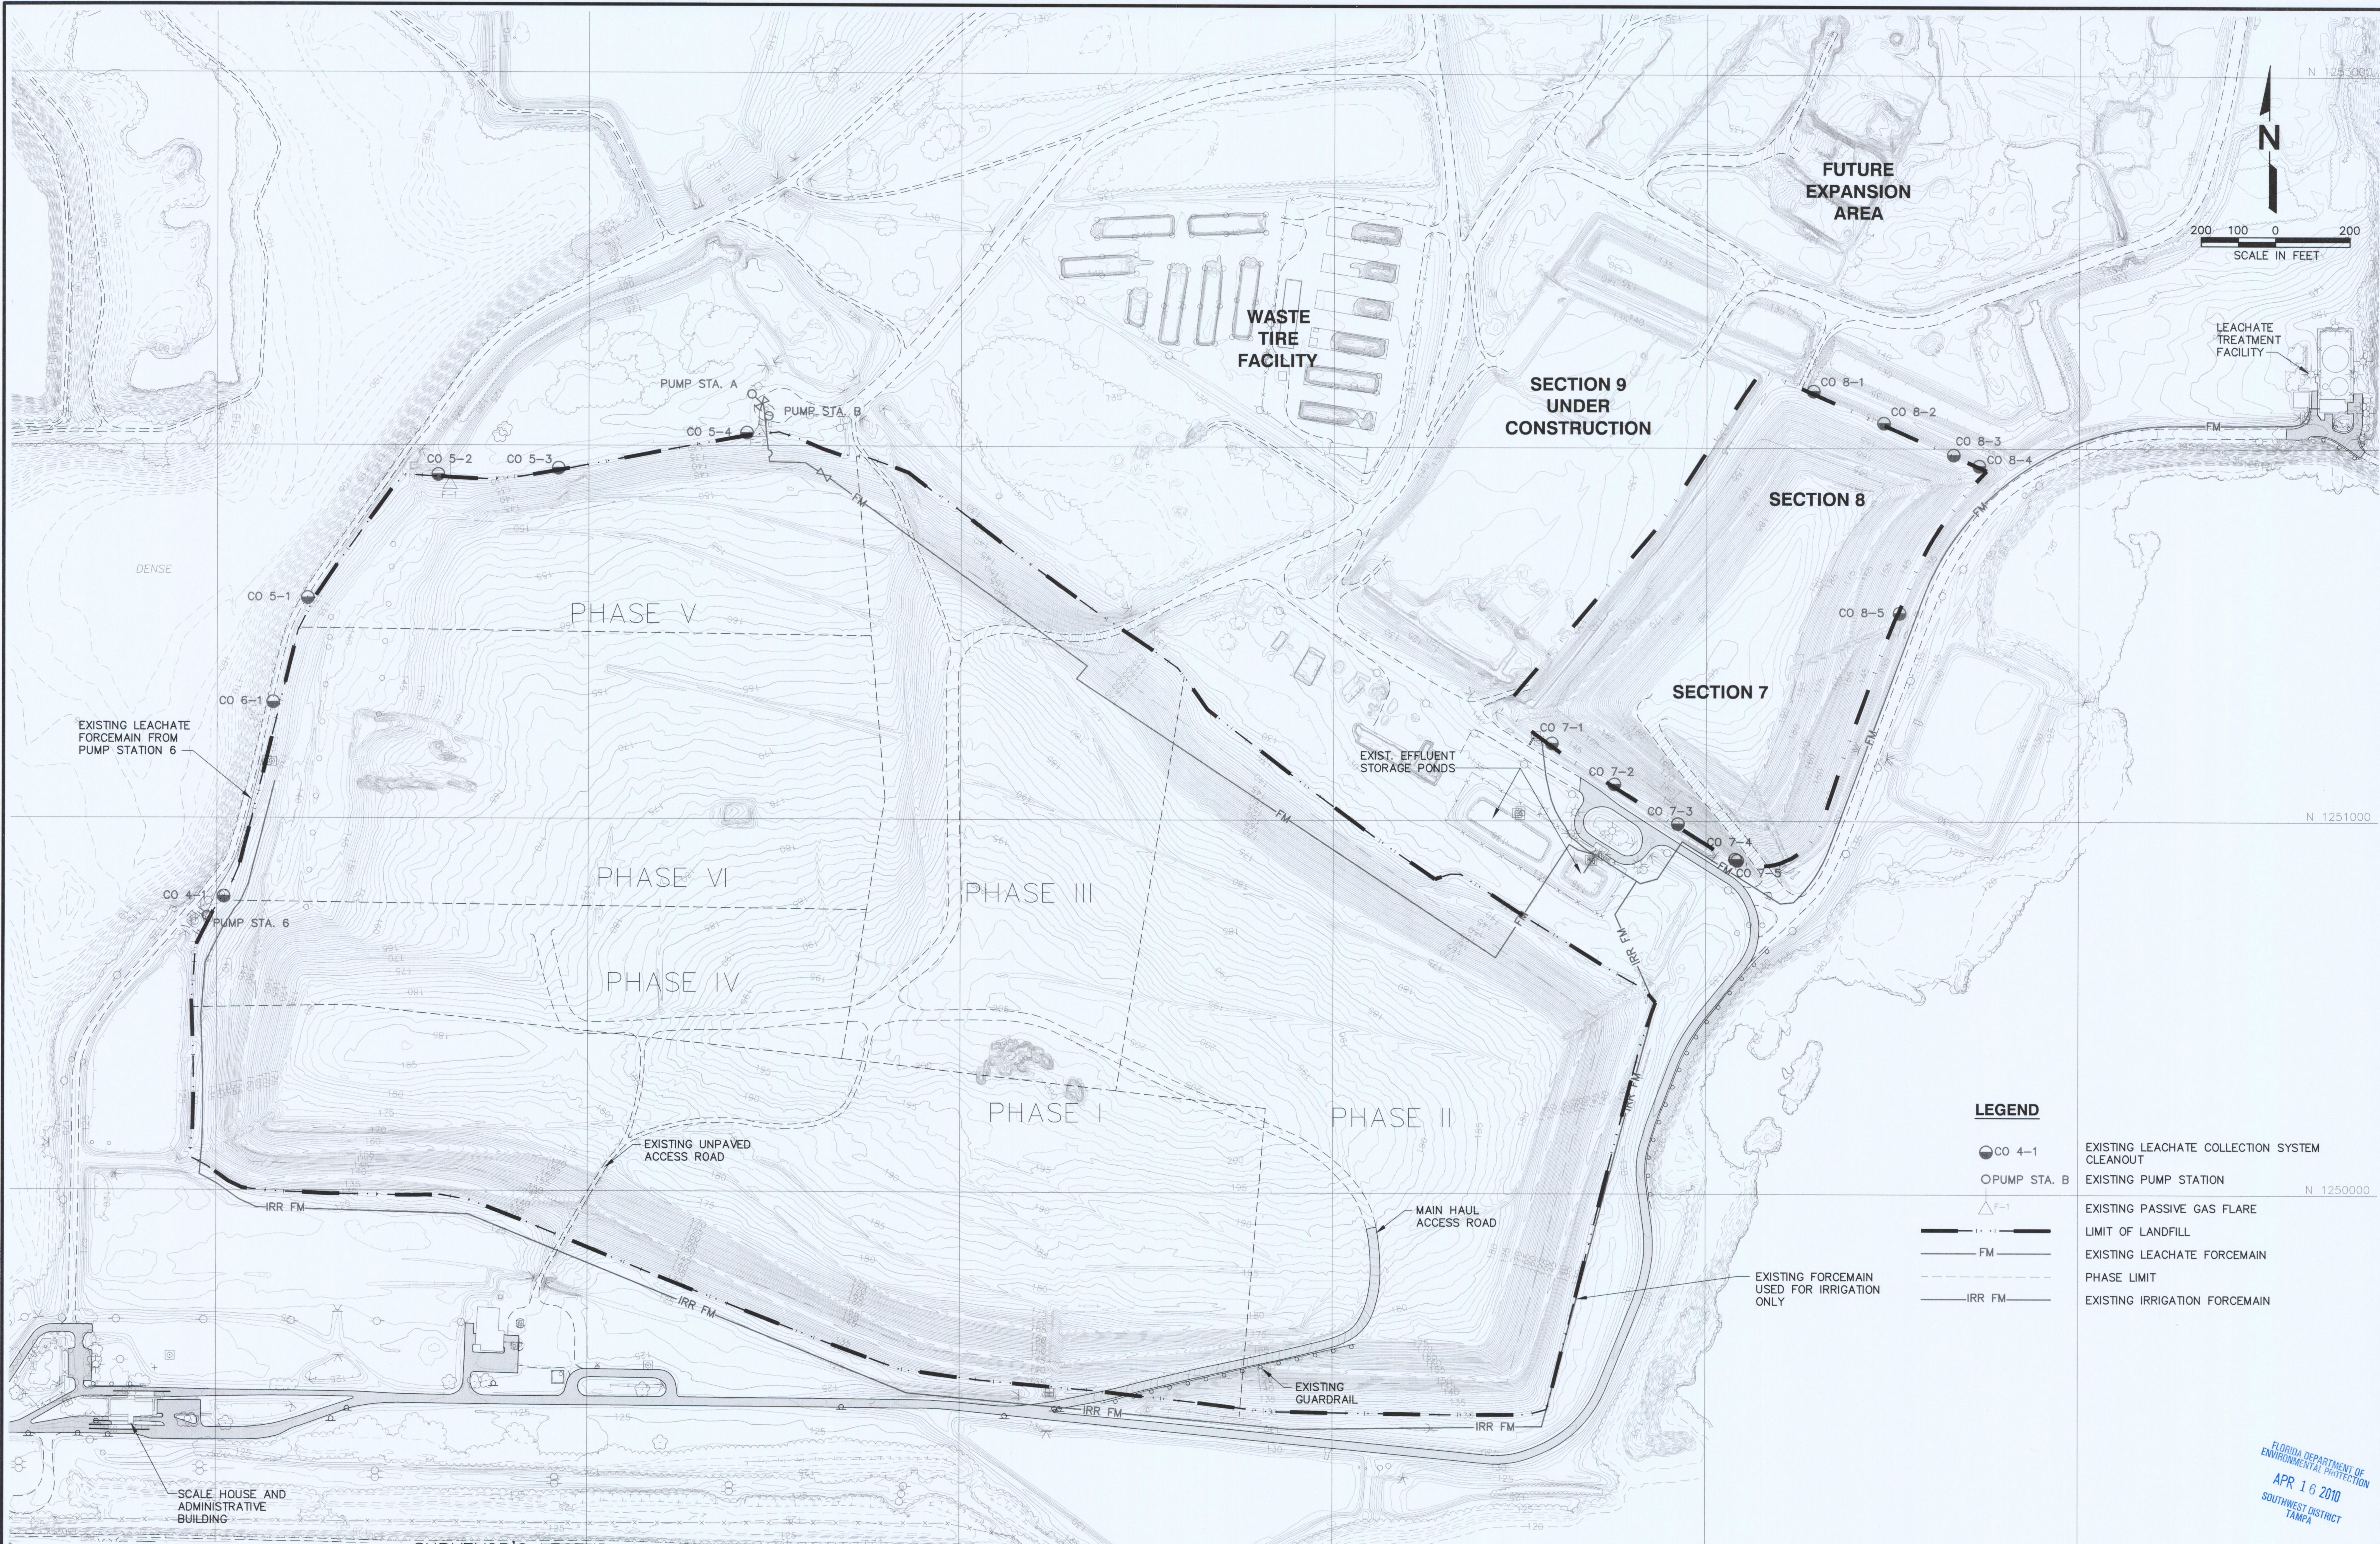

SURVEYOR'S LEGEND:											
△ CONTROL	MAIL BOX	✱ AIR CONDITIONER	○ SHRUB	— WALL	— EDGE OF GROVE						
○ UTILITY POLE	— GUYWIRE	✱ MISCELLANEOUS SYMBOL	— CURB	— RAILROAD	— EDGE OF WATER						
⊙ LIGHT POLE	⊙ MANHOLE	✱ CULVERT	▨ PAVED SURFACE	— STRUCTURE	— SWAMPLINE						
⊙ TRAFFIC LIGHT	⊙ HYDRANT	— SWAMP/MARSH	— CONCRETE SURFACE	— TREE LINE	— OBSCURED CONTOUR						
○ SIGN	⊙ CATCH BASIN	○ TREE	— UNPAVED ROAD	— SHRUB LINE	— DEPRESSION CONTOUR						
○ POST	○ VALVE	✱ PALM	— FENCE	— PIPELINE	— W.E. WATER ELEVATION						
△ FLAG	✱ ELECTRICAL		— GUARDRAIL	— RECREATION	× 120.1 SPOT ELEVATION						
(THESE FEATURES ARE REPRESENTED BY SYMBOL NOT TO SCALE)											

LEGEND	
● CO 4-1	EXISTING LEACHATE COLLECTION SYSTEM CLEANOUT
○ PUMP STA. B	EXISTING PUMP STATION
△ F-1	EXISTING PASSIVE GAS FLARE
—	LIMIT OF LANDFILL
— FM	EXISTING LEACHATE FORCEMAIN
—	PHASE LIMIT
— IRR FM	EXISTING IRRIGATION FORCEMAIN

SURVEY SOURCE NOTES:
1. TOPOGRAPHIC SURVEY INFORMATION SHOWN WAS DEVELOPED BY PICKETT & ASSOCIATES, INC., 475 SOUTH FIRST AVENUE, BARTOW, FL 33830. AERIAL PHOTO DATE: 01/14/08.
2. NORTH, THE GRID, AND THE COORDINATES SHOWN HERE ARE REFERENCED TO THE WEST ZONE OF THE FLORIDA STATE PLAN COORDINATE SYSTEM, NAD 83, 1990 ADJUSTMENT.

BY
DRG

DESCRIPTION
REVISED FOR THE RECORD

DATE
4/15/10

REV
A

PROJECT TITLE
SOUTHEAST COUNTY LANDFILL
LANDFILL GAS COLLECTION
AND CONTROL SYSTEM PROJECT

DRAWING TITLE
SITE PLAN - EXISTING CONDITIONS

CLIENT
HILLSBOROUGH COUNTY
SOLID WASTE
MANAGEMENT DEPARTMENT
TAMPA, FLORIDA

SCS ENGINEERS
STEARN, CONRAD AND SCHMIDT
CONSULTING ENGINEERS
4041 PARK OAKS BLVD., SUITE 100, TAMPA, FL 33610
813 821-0880 FAX 813 823-8757
FLORIDA CERTIFICATE OF AUTHORIZATION NO. 00004882
PROJ. NO. 09207055.00
DWN. BY: SDA/CTN
CHK. BY: DCR
APP. BY: RJD

CADD FILE:
075500EXIST

DATE:
OCTOBER 8, 2008

SCALE:
AS SHOWN

DRAWING NO.

RAYMOND J. DEVER, P.E.
LICENSE NO. 43031

APR 16 2010
SOUTHWEST DISTRICT
TAMPA