
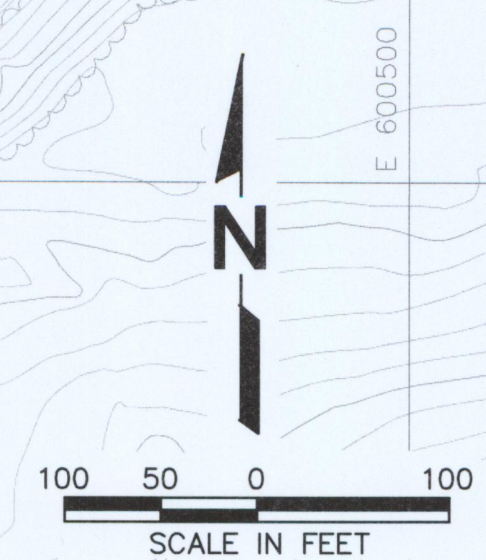


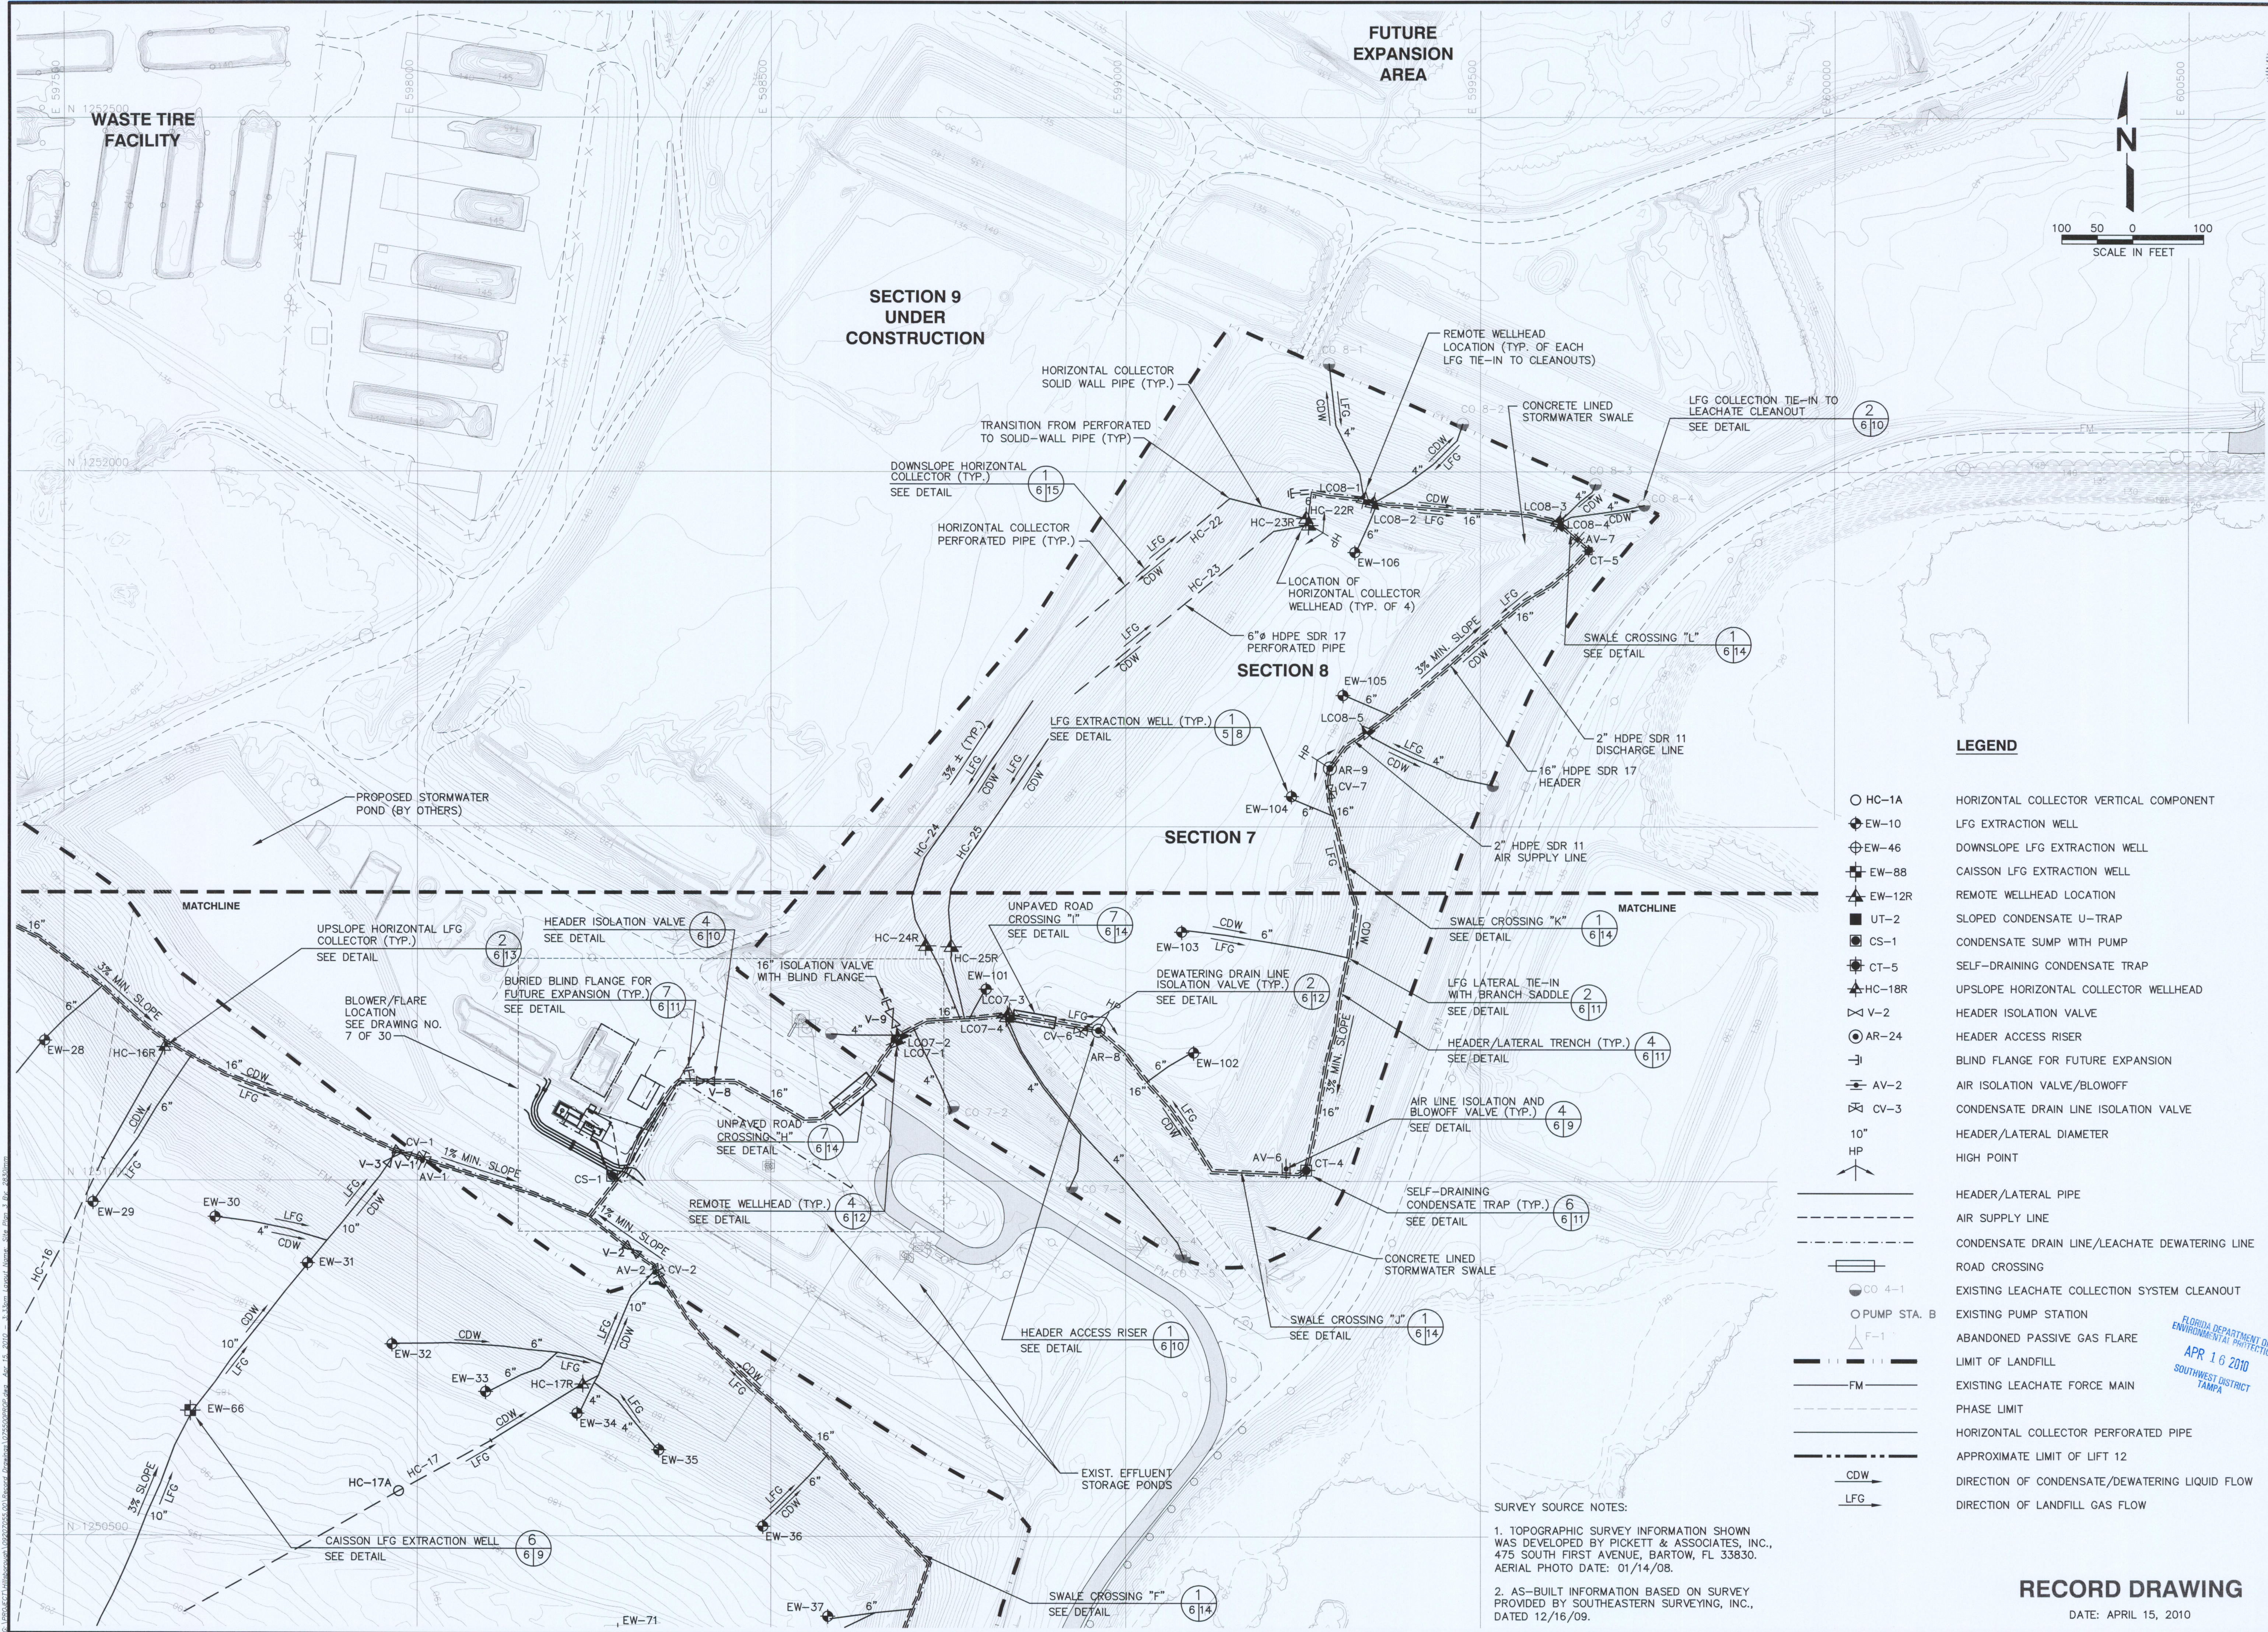

LEGEND

- | | |
|----------|--|
| ○ HC-1A | HORIZONTAL COLLECTOR VERTICAL COMPONENT |
| ⊕ EW-10 | LFG EXTRACTION WELL |
| ⊕ EW-46 | DOWNSLOPE LFG EXTRACTION WELL |
| ⊕ EW-88 | CAISSON LFG EXTRACTION WELL |
| ⊕ EW-12R | REMOTE WELLHEAD LOCATION |
| ■ UT-2 | SLOPED CONDENSATE U-TRAP |
| ⊕ CS-1 | CONDENSATE SUMP WITH PUMP |
| ⊕ CT-5 | SELF-DRAINING CONDENSATE TRAP |
| ⊕ HC-18R | UPSLOPE HORIZONTAL COLLECTOR WELLHEAD |
| ⊕ V-2 | HEADER ISOLATION VALVE |
| ⊕ AR-24 | HEADER ACCESS RISER |
| ⊕ V-1 | BLIND FLANGE FOR FUTURE EXPANSION |
| ⊕ AV-2 | AIR ISOLATION VALVE/BLOWOFF |
| ⊕ CV-3 | CONDENSATE DRAIN LINE ISOLATION VALVE |
| 10" HP | HEADER/LATERAL DIAMETER |
| HP | HIGH POINT |
| --- | HEADER/LATERAL PIPE |
| --- | AIR SUPPLY LINE |
| --- | CONDENSATE DRAIN LINE/LEACHATE DEWATERING LINE |
| --- | ROAD CROSSING |
| --- | EXISTING LEACHATE COLLECTION SYSTEM CLEANOUT |
| --- | EXISTING PUMP STATION |
| --- | ABANDONED PASSIVE GAS FLARE |
| --- | LIMIT OF LANDFILL |
| --- | EXISTING LEACHATE FORCE MAIN |
| --- | PHASE LIMIT |
| --- | HORIZONTAL COLLECTOR PERFORATED PIPE |
| --- | APPROXIMATE LIMIT OF LIFT 12 |
| --- | DIRECTION OF CONDENSATE/DEWATERING LIQUID FLOW |
| --- | DIRECTION OF LANDFILL GAS FLOW |

SURVEY SOURCE NOTES:

1. TOPOGRAPHIC SURVEY INFORMATION SHOWN WAS DEVELOPED BY PICKETT & ASSOCIATES, INC., 475 SOUTH FIRST AVENUE, BARTOW, FL 33830. AERIAL PHOTO DATE: 01/14/08.

2. AS-BUILT INFORMATION BASED ON SURVEY PROVIDED BY SOUTHEASTERN SURVEYING, INC., DATED 12/16/09.

RECORD DRAWING
DATE: APRIL 15, 2010

BY	DESCRIPTION
DRC	REVISED FOR THE RECORD
DATE	4/15/10
REV	1
SITE PLAN - 3	
SOUTHEAST COUNTY LANDFILL LANDFILL GAS COLLECTION AND CONTROL SYSTEM PROJECT	
HILLSBOROUGH COUNTY SOLID WASTE MANAGEMENT DEPARTMENT TAMPA, FLORIDA	
SCS ENGINEERS STEARNES, CONRAD AND SCHMIDT CONSULTING ENGINEERS 4041 PARK OAKS BLVD., SUITE 100, TAMPA, FL 33610 813-821-0080 FAX 813-823-6757 FLORIDA CERTIFICATE OF AUTHORIZATION NO. 00004892 PROJ. NO. 09207055.00 OWN. BY: DAW/CTN CHK. BY: DRC APP. BY: DAW/DRC	
CADD FILE:	075500PROP
DATE:	OCTOBER 8, 2008
SCALE:	AS SHOWN
DRAWING NO.	6 of 30