


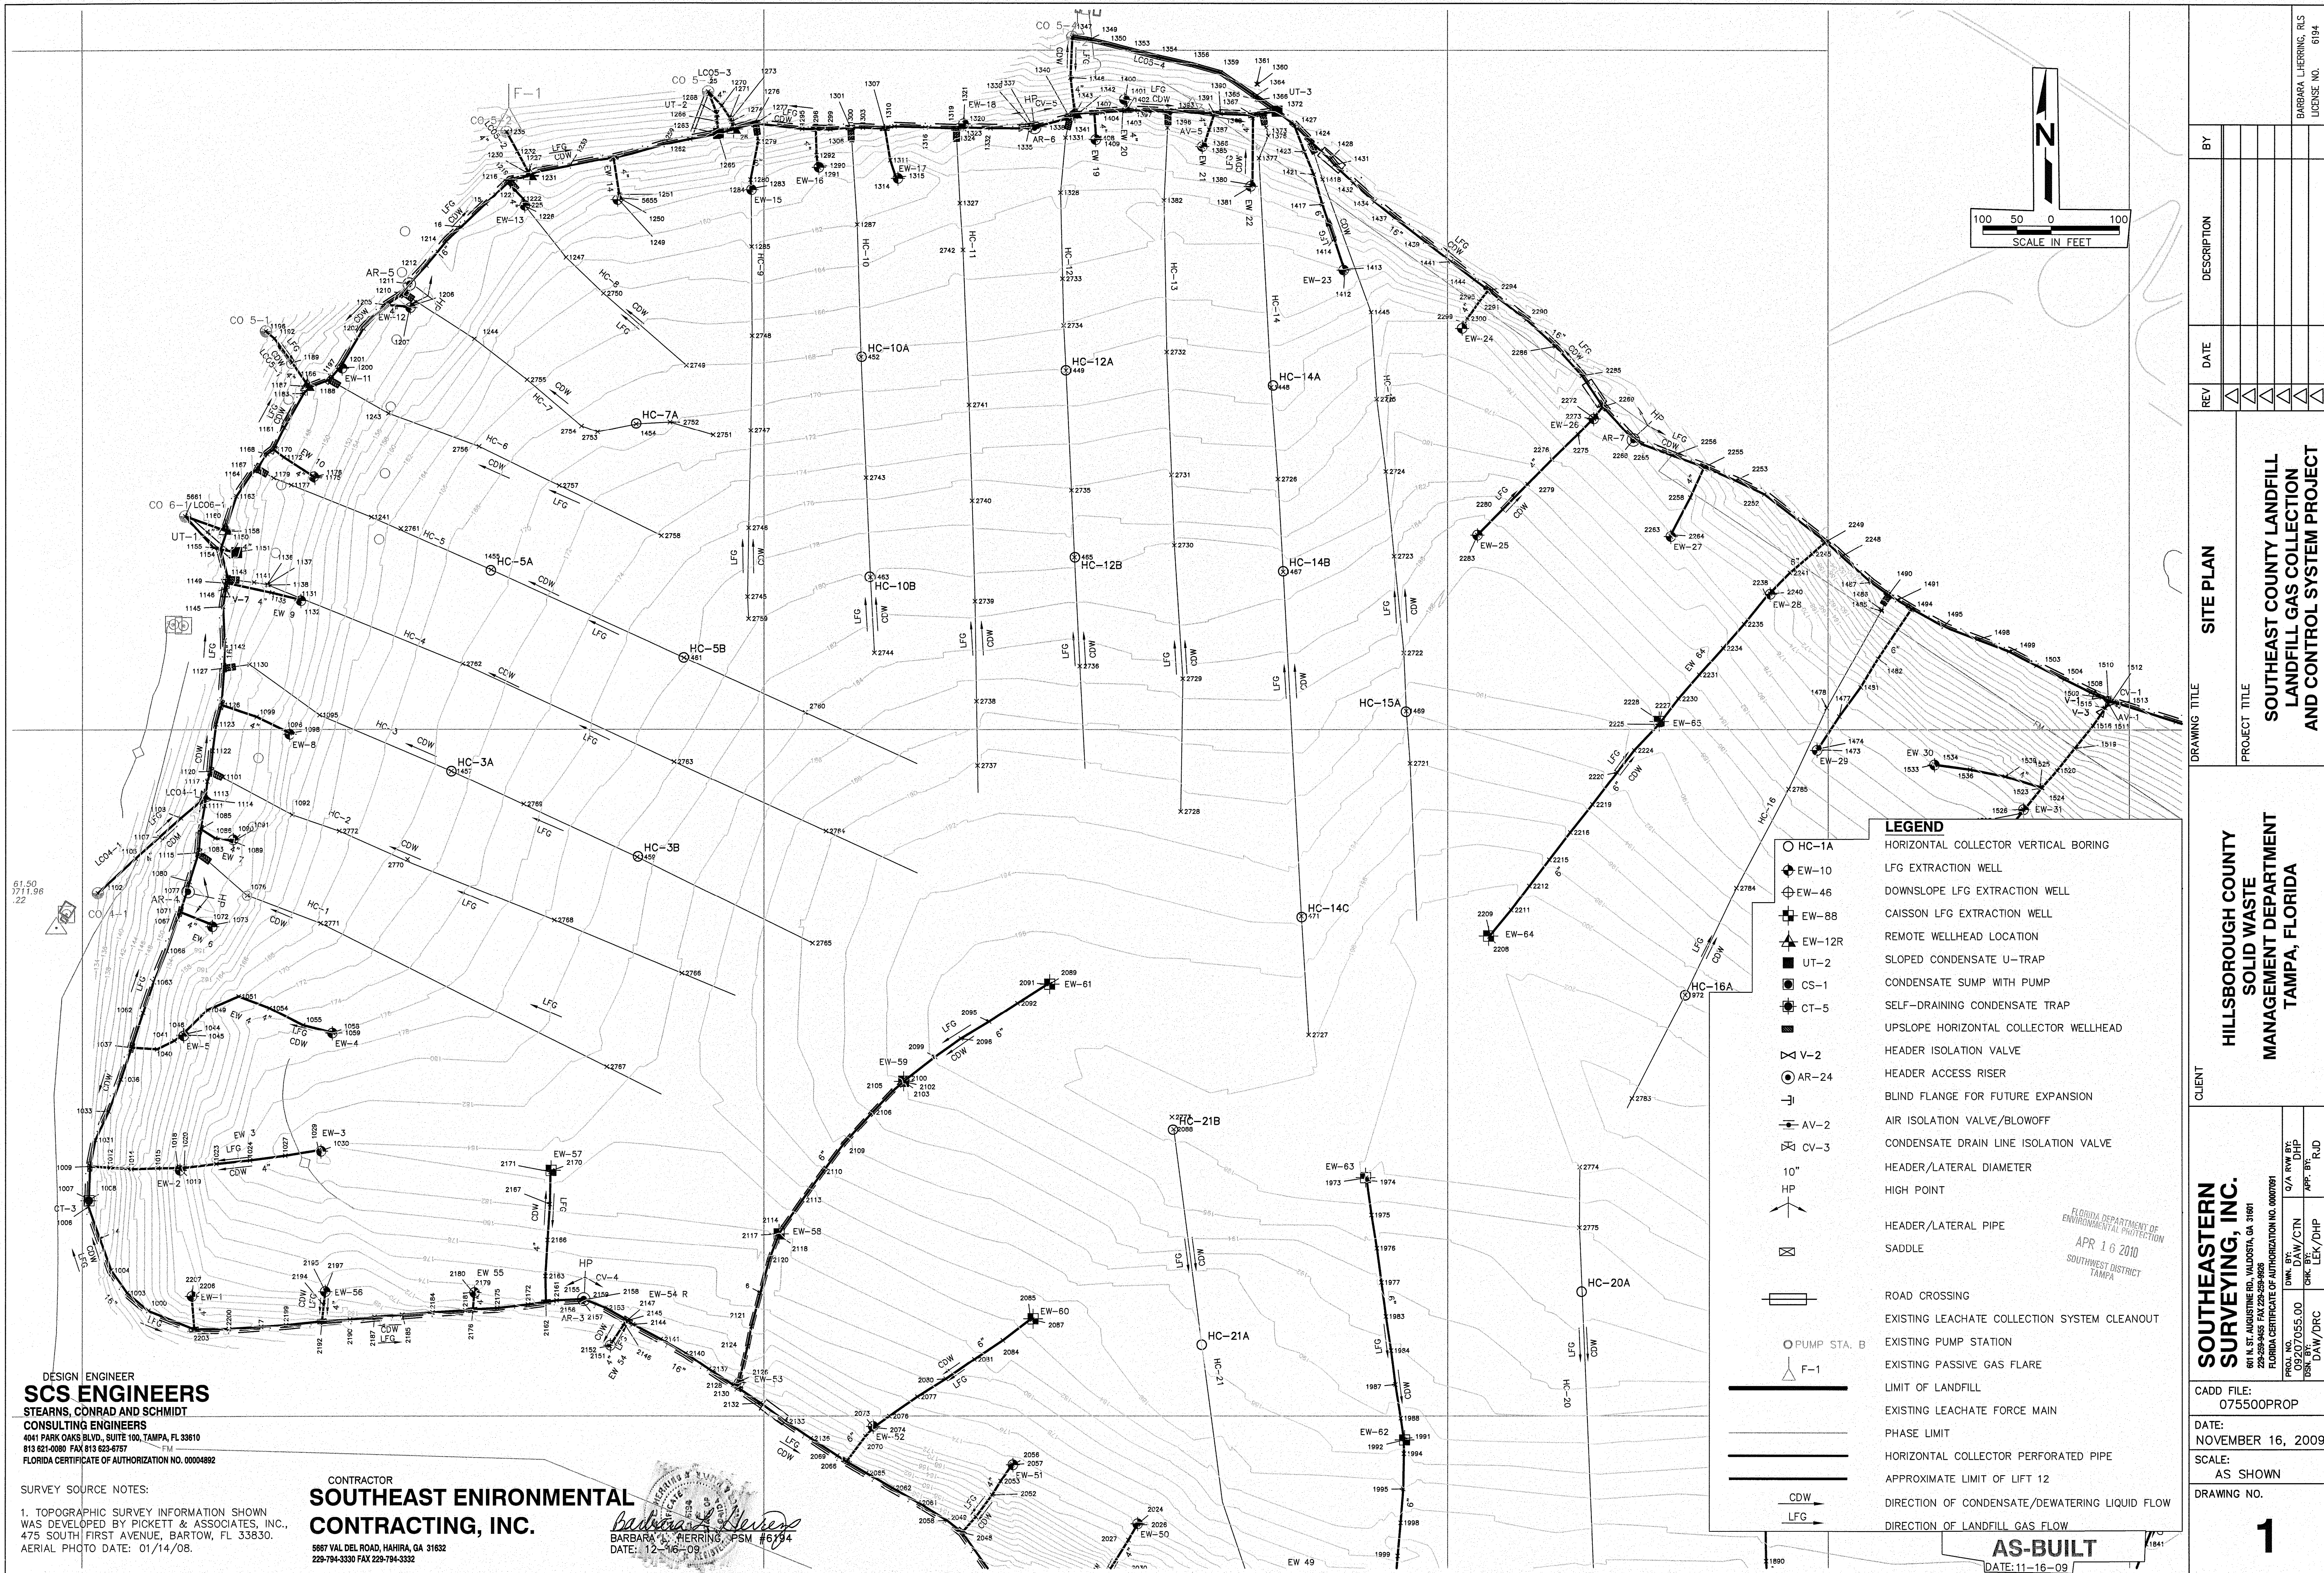

DESIGN ENGINEER
SCS ENGINEERS
STEARNS, CONRAD AND SCHMIDT
CONSULTING ENGINEERS
4041 PARK OAKS BLVD., SUITE 100, TAMPA, FL 33610
813 821-0080 FAX 813 823-6757
FLORIDA CERTIFICATE OF AUTHORIZATION NO. 00004892

SURVEY SOURCE NOTES:
1. TOPOGRAPHIC SURVEY INFORMATION SHOWN
WAS DEVELOPED BY PICKETT & ASSOCIATES, INC.,
475 SOUTH FIRST AVENUE, BARTOW, FL 33830.
AERIAL PHOTO DATE: 01/14/08.

CONTRACTOR
**SOUTHEAST ENIRONMENTAL
CONTRACTING, INC.**

5687 VAL DEL ROAD, HAHIRA, GA 31632
229-794-3330 FAX 229-794-3332

BARBARA L. HERRING, PSM #6194
DATE: 12-16-09

- LEGEND**
- HC-1A HORIZONTAL COLLECTOR VERTICAL BORING
 - ⊕ EW-10 LFG EXTRACTION WELL
 - ⊕ EW-46 DOWNSLOPE LFG EXTRACTION WELL
 - ⊕ EW-68 CAISSON LFG EXTRACTION WELL
 - △ EW-12R REMOTE WELLHEAD LOCATION
 - ⊕ UT-2 SLOPED CONDENSATE U-TRAP
 - ⊕ CS-1 CONDENSATE SUMP WITH PUMP
 - ⊕ CT-5 SELF-DRAINING CONDENSATE TRAP
 - ⊕ UPSLOPE HORIZONTAL COLLECTOR WELLHEAD
 - ⊕ V-2 HEADER ISOLATION VALVE
 - ⊕ AR-24 HEADER ACCESS RISER
 - ⊕ BLIND FLANGE FOR FUTURE EXPANSION
 - ⊕ AV-2 AIR ISOLATION VALVE/BLOWOFF
 - ⊕ CV-3 CONDENSATE DRAIN LINE ISOLATION VALVE
 - 10" HP HEADER/LATERAL DIAMETER
 - HP HIGH POINT
 - ⊕ HEADER/LATERAL PIPE
 - ⊕ SADDLE
 - ROAD CROSSING
 - PUMP STA. B EXISTING LEACHATE COLLECTION SYSTEM CLEANOUT
 - △ F-1 EXISTING PASSIVE GAS FLARE
 - EXISTING LEACHATE FORCE MAIN
 - PHASE LIMIT
 - HORIZONTAL COLLECTOR PERFORATED PIPE
 - APPROXIMATE LIMIT OF LIFT 12
 - CDW DIRECTION OF CONDENSATE/DEWATERING LIQUID FLOW
 - LFG DIRECTION OF LANDFILL GAS FLOW

AS-BUILT
DATE: 11-16-09

SOUTHEASTERN SURVEYING, INC.		CLIENT		HILLSBOROUGH COUNTY SOLID WASTE MANAGEMENT DEPARTMENT TAMPA, FLORIDA		DRAWING TITLE		SITE PLAN		REV		DATE		DESCRIPTION		BY	
601 N. ST. AUGUSTINE RD., VALDOSTA, GA 31601		229-259-9455 FAX 229-529-9926		FLORIDA CERTIFICATE OF AUTHORIZATION NO. 00007091		PROJECT TITLE		SOUTHEAST COUNTY LANDFILL LANDFILL GAS COLLECTION AND CONTROL SYSTEM PROJECT		△		△					
PROJ. NO. 030207055.00		DWN. BY: KAW/CTN		O/A RVM BFC						△		△					
TSP: DAW/DRC		13K/B: DAW/DRC		4PK: BFC						△		△					
CADD FILE: 075500PROP		DATE: NOVEMBER 16, 2009		SCALE: AS SHOWN		DRAWING NO. 1										BARBARA L'HERRING, RLS LICENSE NO. 6194	