


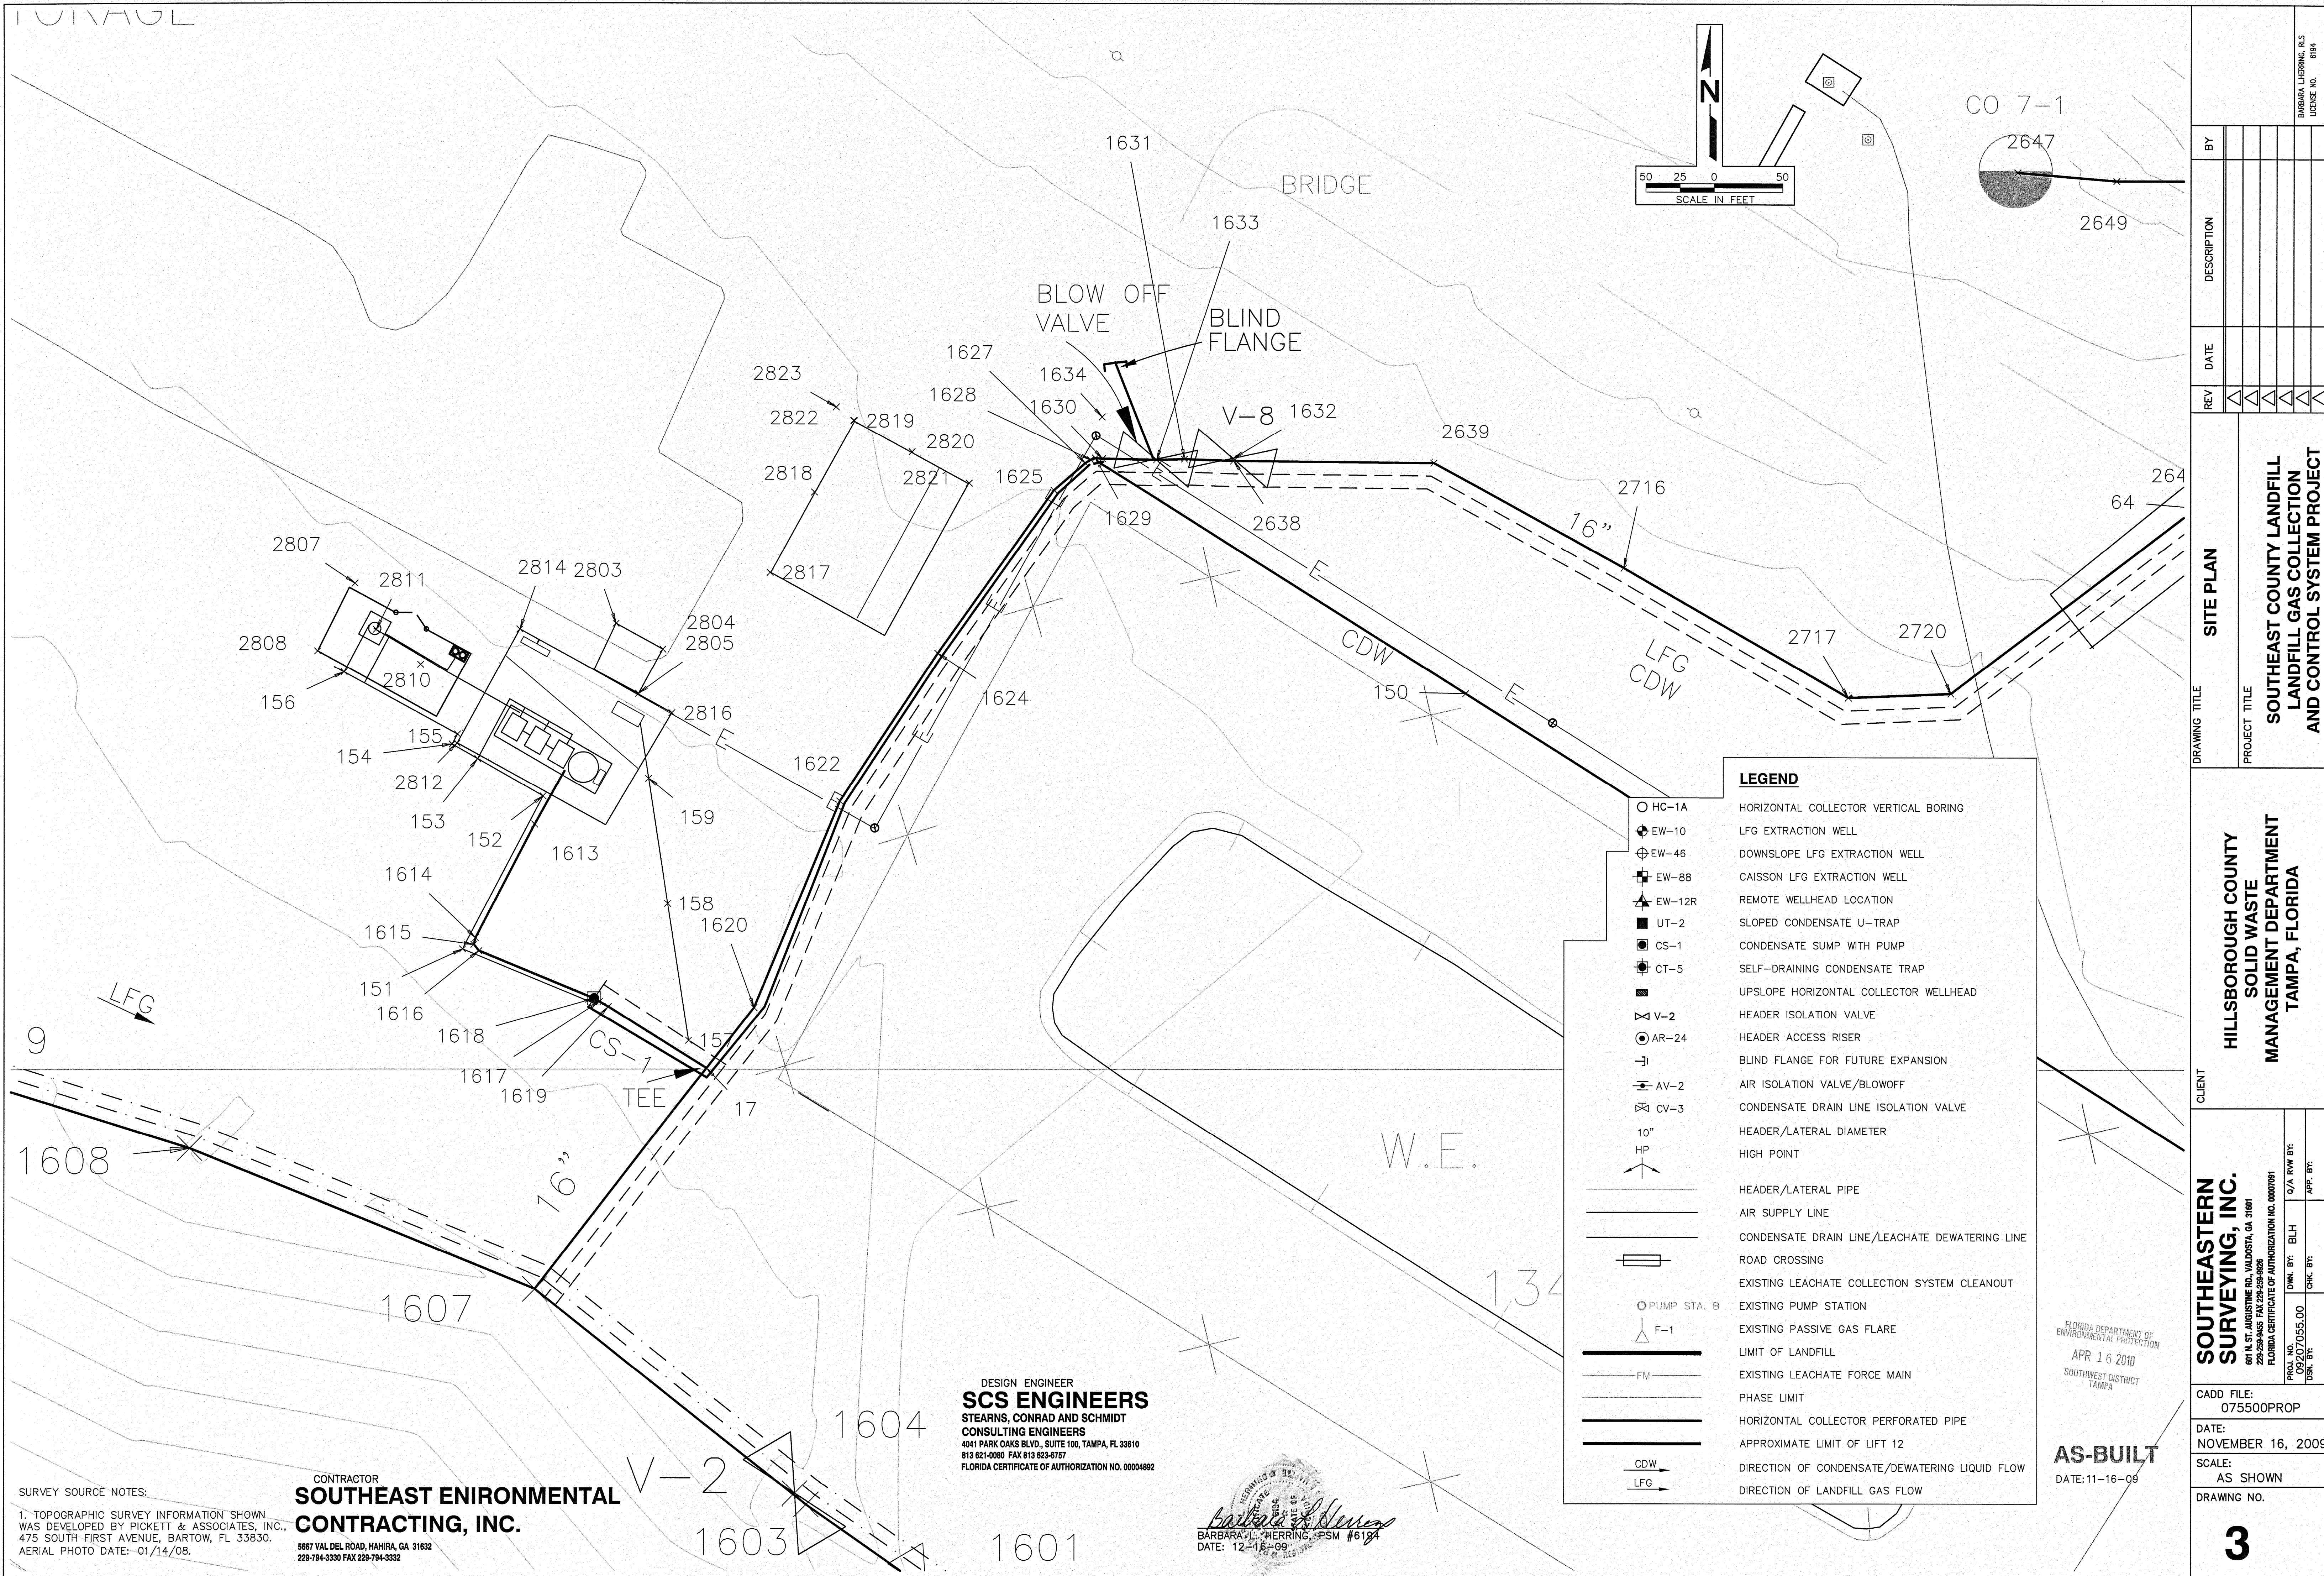

SURVEY SOURCE NOTES:

1. TOPOGRAPHIC SURVEY INFORMATION SHOWN WAS DEVELOPED BY PICKETT & ASSOCIATES, INC., 475 SOUTH FIRST AVENUE, BARTOW, FL 33830. AERIAL PHOTO DATE: 01/14/08.

CONTRACTOR
SOUTHEAST ENIRONMENTAL CONTRACTING, INC.

5867 VAL DEL ROAD, HAHIRA, GA 31632
229-794-3330 FAX 229-794-3332

DESIGN ENGINEER
SCS ENGINEERS
STEARNS, CONRAD AND SCHMIDT
CONSULTING ENGINEERS
4041 PARK OAKS BLVD., SUITE 100, TAMPA, FL 33610
813 621-0080 FAX 813 623-6757
FLORIDA CERTIFICATE OF AUTHORIZATION NO. 00004892

BARBARA L. HERRING, PSM #6184
DATE: 12-16-09

LEGEND

- HC-1A HORIZONTAL COLLECTOR VERTICAL BORING
- ⊕ EW-10 LFG EXTRACTION WELL
- ⊕ EW-46 DOWNSLOPE LFG EXTRACTION WELL
- ⊕ EW-88 CAISSON LFG EXTRACTION WELL
- △ EW-12R REMOTE WELLHEAD LOCATION
- ▀ UT-2 SLOPED CONDENSATE U-TRAP
- CS-1 CONDENSATE SUMP WITH PUMP
- ⊕ CT-5 SELF-DRAINING CONDENSATE TRAP
- ▀ UPSLOPE HORIZONTAL COLLECTOR WELLHEAD
- ⊕ V-2 HEADER ISOLATION VALVE
- ⊕ AR-24 HEADER ACCESS RISER
- ⊕ BLIND FLANGE FOR FUTURE EXPANSION
- ⊕ AV-2 AIR ISOLATION VALVE/BLOWOFF
- ⊕ CV-3 CONDENSATE DRAIN LINE ISOLATION VALVE
- 10" HP HEADER/LATERAL DIAMETER
- 10" HP HIGH POINT
- HEADER/LATERAL PIPE
- AIR SUPPLY LINE
- CONDENSATE DRAIN LINE/LEACHATE DEWATERING LINE
- ROAD CROSSING
- EXISTING LEACHATE COLLECTION SYSTEM CLEANOUT
- EXISTING PUMP STATION
- EXISTING PASSIVE GAS FLARE
- LIMIT OF LANDFILL
- EXISTING LEACHATE FORCE MAIN
- PHASE LIMIT
- HORIZONTAL COLLECTOR PERFORATED PIPE
- APPROXIMATE LIMIT OF LIFT 12
- CDW DIRECTION OF CONDENSATE/DEWATERING LIQUID FLOW
- LFG DIRECTION OF LANDFILL GAS FLOW

FLORIDA DEPARTMENT OF
ENVIRONMENTAL PROTECTION
APR 16 2010
SOUTHWEST DISTRICT
TAMPA

AS-BUILT
DATE: 11-16-09

SOUTHEASTERN SURVEYING, INC.										HILLSBOROUGH COUNTY SOLID WASTE MANAGEMENT DEPARTMENT TAMPA, FLORIDA										SITE PLAN																																																											
601 N. ST. AUGUSTINE RD., VALDOSTA, GA 31601 229-259-9468 FAX 229-259-9626 FLORIDA CERTIFICATE OF AUTHORIZATION NO. 00007091																				DRAWING TITLE																																																											
CADD FILE: 075500PROP																				PROJECT TITLE																																																											
DATE: NOVEMBER 16, 2009																				SOUTHEAST COUNTY LANDFILL																																																											
SCALE: AS SHOWN																				LANDFILL GAS COLLECTION																																																											
DRAWING NO. 3																				AND CONTROL SYSTEM PROJECT																																																											
PROJ. NO. 09207055.00										DWN. BY: BLH										REV										DATE										DESCRIPTION										BY																													
TDR. BY:										O/A R/W BY:																																																																					
CHK. BY:																																																																															
APP. BY:																																																																															
										</																																																																					