
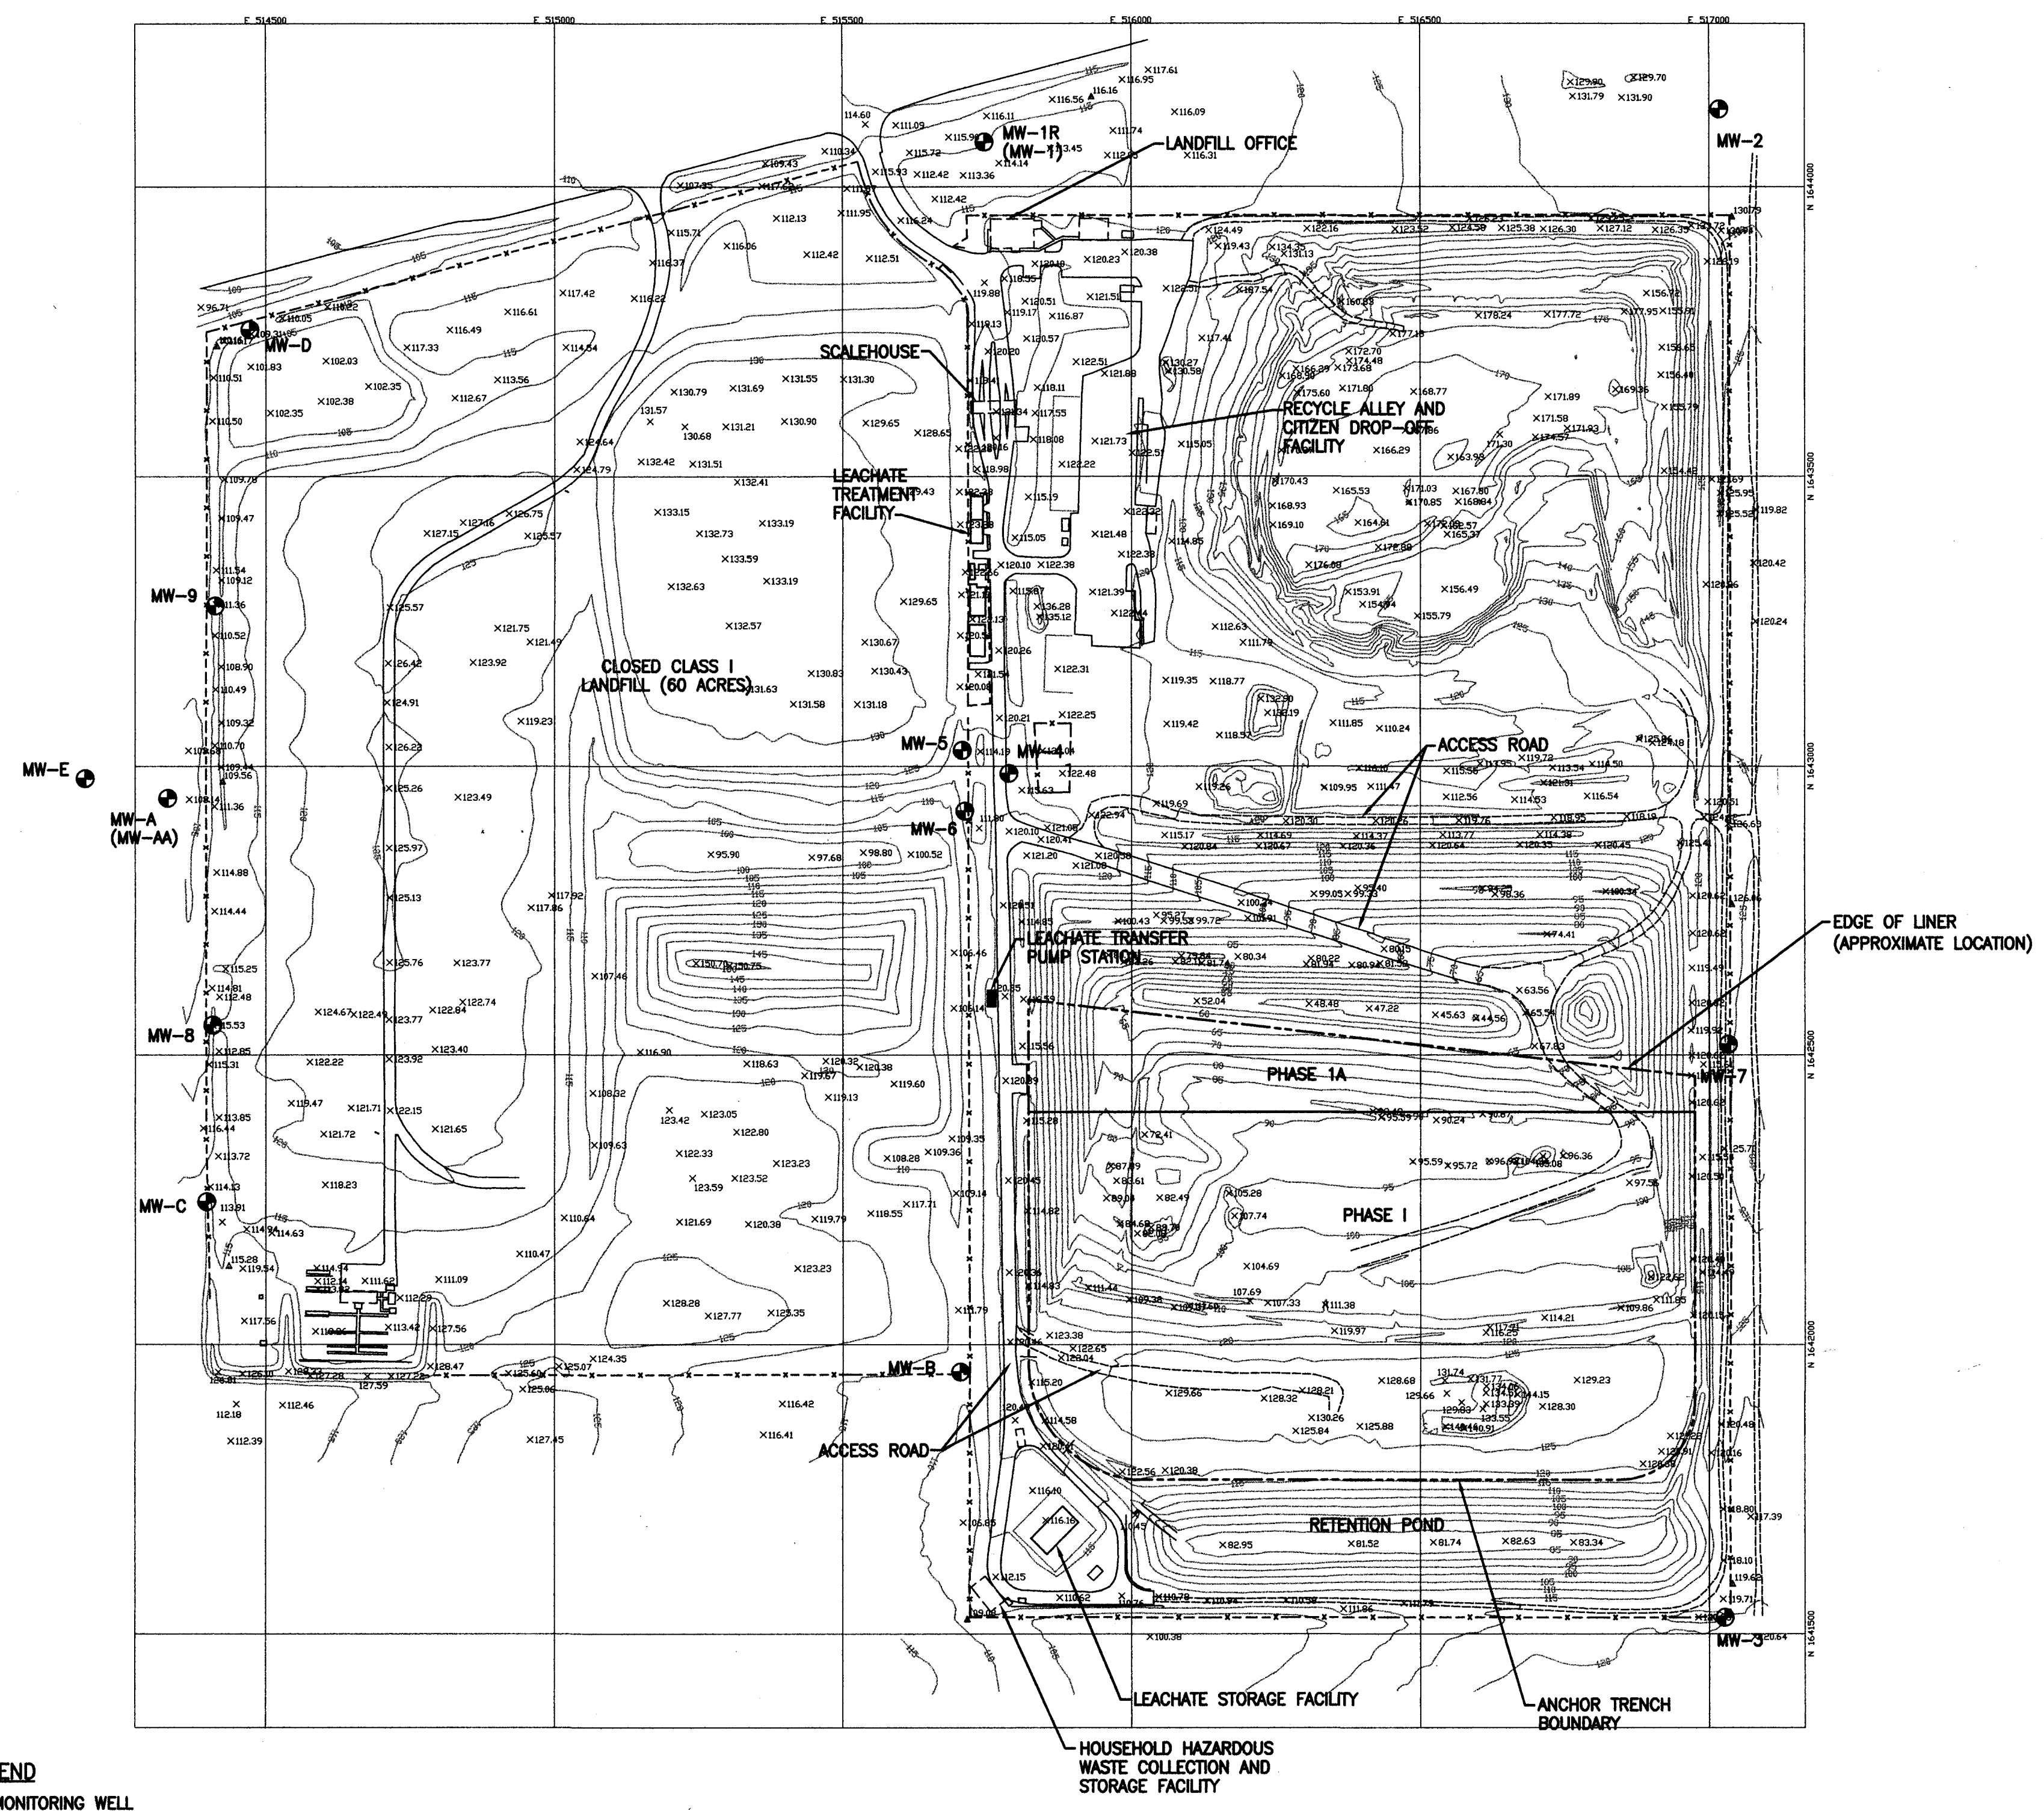


1028266
①

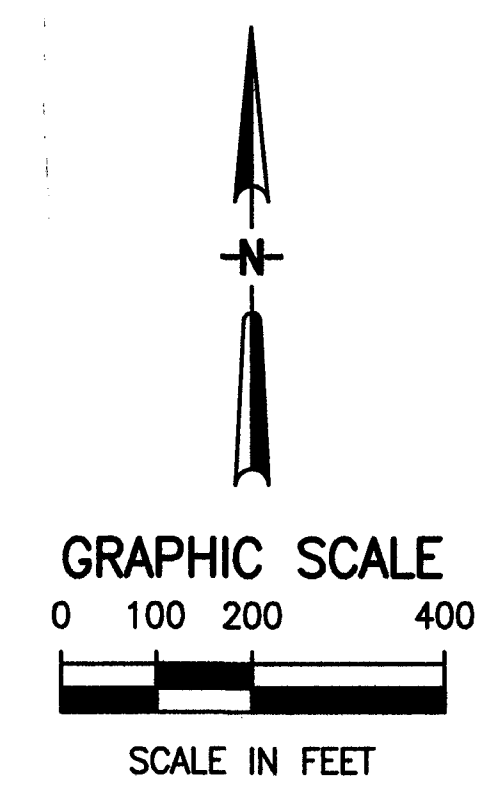

LEGEND
 ● MONITORING WELL
 Note:
 Survey data provided by PTI, 12/2000.

FLORIDA DEPARTMENT OF ENVIRONMENTAL PROTECTION
 JUL 20 2001
 SOUTHWEST DISTRICT TAMPA

07/19/01 10:02 PEU je005f2-1-200 scale.dwg

| | |
|-----------|------------------|
| DESIGNED | _____ |
| DRAWN | _____ |
| CHECKED | _____ |
| LTR. | DATE |
| REVISIONS | BY |
| APPRO. | PROJECT ENGINEER |

730 Northwest 74th Road/Gainesville, Florida 32611 / (352) 377-5821

| | | | | | |
|---------------------------------------|--|------------------|---------------------|-----------|--------------|
| CITRUS COUNTY CENTRAL LANDFILL | | SITE PLAN | APPROVED FOR JEA BY | DATE | PROJECT NO. |
| | | | | JULY 2001 | 03860-005-01 |
| | | | | SCALE | DWG. NO. |
| | | | | 1" = 200' | |
| | | | P.E. # | | |