





SOUTHWEST  
FLORIDA  
SOLID WASTE

# MAINTENANCE AND STORAGE BUILDING FOR LEE COUNTY WASTE TO ENERGY FACILITY

10500 BUCKINGHAM ROAD FORT MYERS, FLORIDA 33905

## INDEX OF DRAWINGS:

SHEET #	SHEET DESCRIPTION
1	COVER SHEET
2	2007 AERIAL
3	SITE & UTILITY PLAN
4	PAVING, GRADING & DRAINAGE
5	DETAILS
6	LIFT STATION
7	EROSION CONTROL
A-1	PROJECT DATA, NOTES & UL DETAILS
A-2	GROUND FLOOR PLAN, SECOND FLOOR PLAN, WINDOW & ROOM FINISH SCHEDULES
A-3	EXTERIOR ELEVATIONS & INTERIOR ELEVATIONS
A-4	BUILDING SECTIONS
A-5	BUILDING SECTIONS
A-6	WALL SECTIONS & NOTES
A-7	WALL SECTIONS & NOTES
A-8	WALL SECTIONS, NOTES & STAIR DETAILS
P-1	PLUMBING PLANS
P-2	PLUMBING SCHEDULES AND DETAILS
M-1	HVAC PLAN
M-2	HVAC SCHEDULES AND DETAILS
FP-1	FIRE PROTECTION PLAN
E-1	POWER AND SYSTEMS PLAN, LIGHTING PLAN
E-2	ELECTRICAL NOTES, SCHEDULES AND RISER DIAGRAM
E-3	DETAILS
S-1	STRUCTURAL NOTES
S-2	STRUCTURAL PLANS
S-3	STRUCTURAL SECTIONS

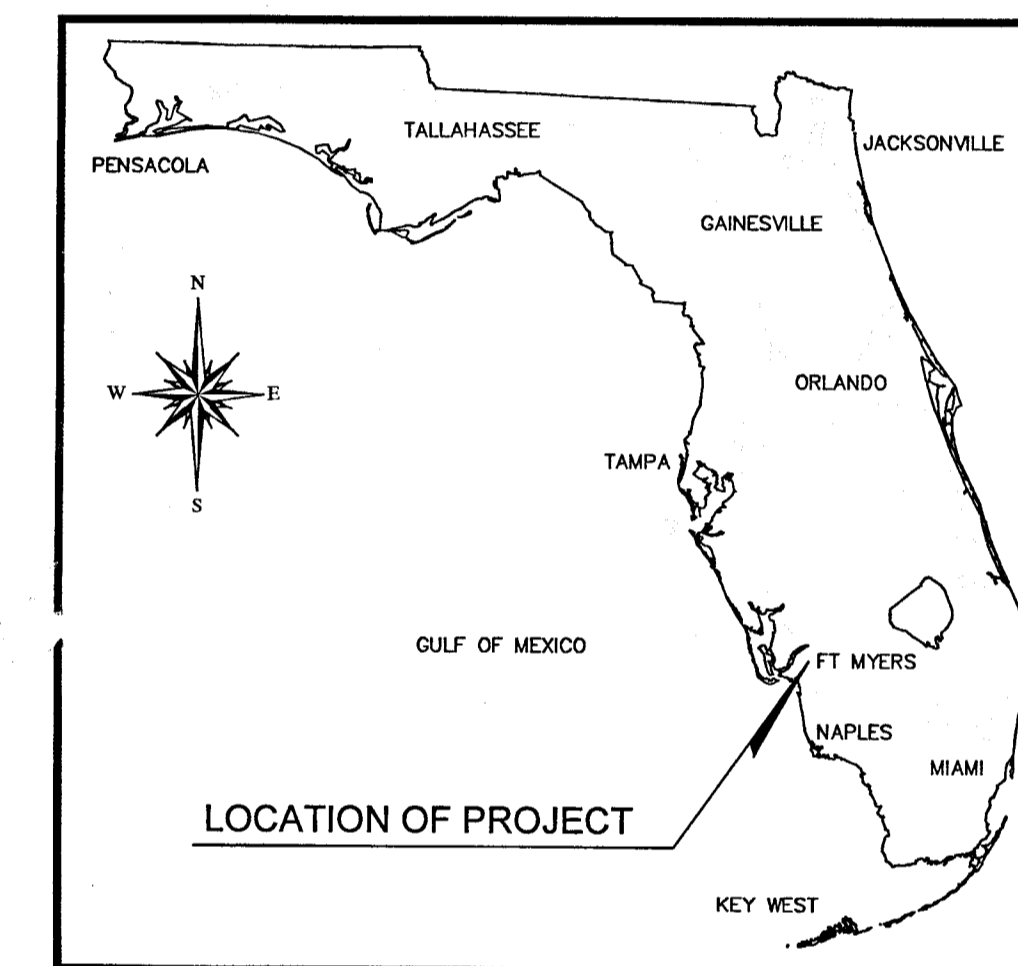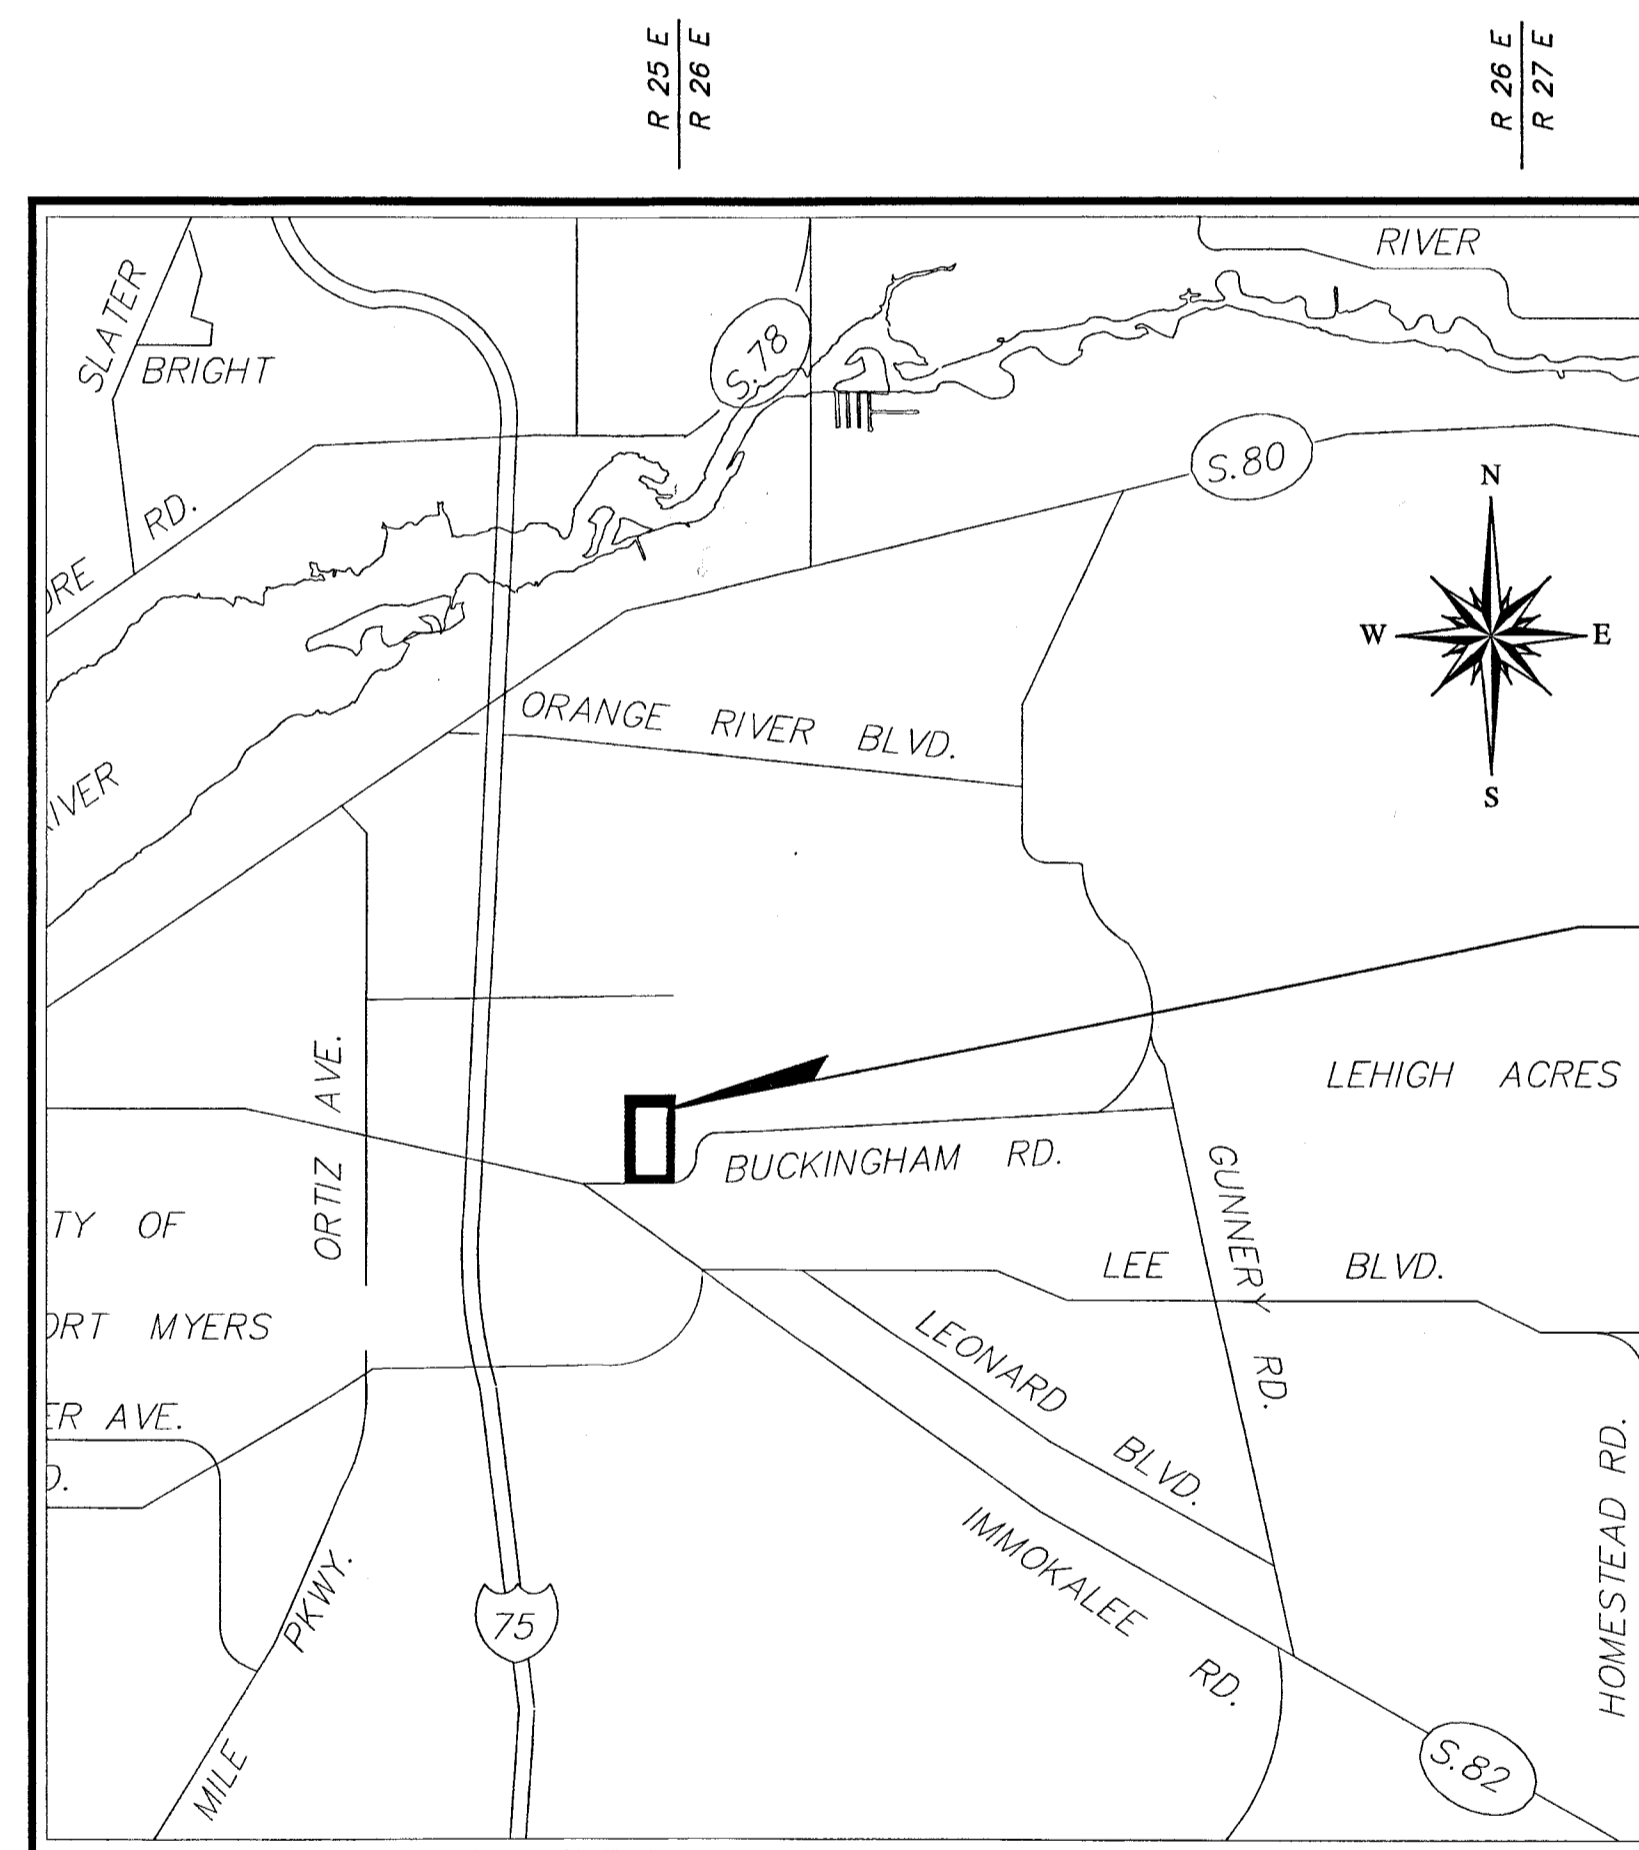

VICINITY MAP  
N.T.S.

THIS IS TO CERTIFY THAT THESE PLANS AND THE ASSOCIATED CONSTRUCTION PROJECT ARE IN SUBSTANTIAL COMPLIANCE WITH THE LEE COUNTY LAND DEVELOPMENT CODE WITH THE EXCEPTION OF THE FOLLOWING DEVIATIONS WHICH HAVE BEEN APPROVED BY THE DIRECTOR OF PUBLIC WORKS: NONE

DEVELOPMENT ORDER APPROVED:  
LEE COUNTY PUBLIC WORKS ADMINISTRATION

APPROVED BY: \_\_\_\_\_ DATE: \_\_\_\_\_  
Jim Lavender  
Public Works Director

### PREPARED FOR:

LEE COUNTY SOLID WASTE  
DIRECTOR: LINDSEY SAMPSON, P.E.  
PROJECT MANAGER: MIKE AVOGLIA  
ADDRESS:  
10500 BUCKINGHAM ROAD  
FORT MYERS, FLORIDA 33905  
PHONE (239) 338-3302  
FAX (239) 461-5871  
avoglims@leegov.com




### COUNTY COMMISSIONERS:

BOB JANES	DISTRICT 1
BRIAN BIGELOW	DISTRICT 2
RAY JUDAH	DISTRICT 3
TAMMY HALL	DISTRICT 4
FRANK MANN	DISTRICT 5

MAY, 2009

NO.	REVISIONS	SHEETS	DATE	NO.	REVISIONS	SHEETS	DATE

ATTENTION IS DIRECTED TO THE FACT THAT THESE PLANS MAY HAVE BEEN ALTERED IN SIZE BY REPRODUCTION. THIS MUST BE CONSIDERED WHEN OBTAINING SCALED DATA.

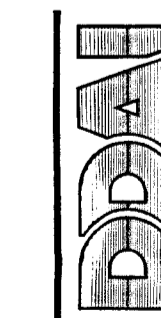


PLANS PREPARED BY:  
**DAVID DOUGLAS ASSOCIATES, INC.**

1821 Victoria Avenue Fort Myers, Florida 33901  
Ph. 239-337-3330, Fax 239-337-1236  
Website: www.ddai-engineers.com  
Florida Certification of Business #7568

DDAI CONTACT: STEVE HURLEY, PROJECT MANAGER

D.O. PLANS  
APPROVED BY:   
DATE: 6-18-09  
P.E. NO.: 38590  
PROJECT ENGINEER

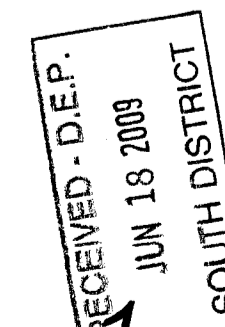

SHEET NO. 1

LAYOUT: LAYOUT1

FILE NAME: 01108-0071.CSDWG

LOCATION: H:\08-0071\LC MAINTENANCE STORAGE BLDG\CADD\DWG1

PLOT BY: SSTUART

PLOT DATE: THU 6-18-2009 8:17 AM

