


BLOWER BLDG. FLOOR PLAN
SCALE: 3/16" = 1'-0"

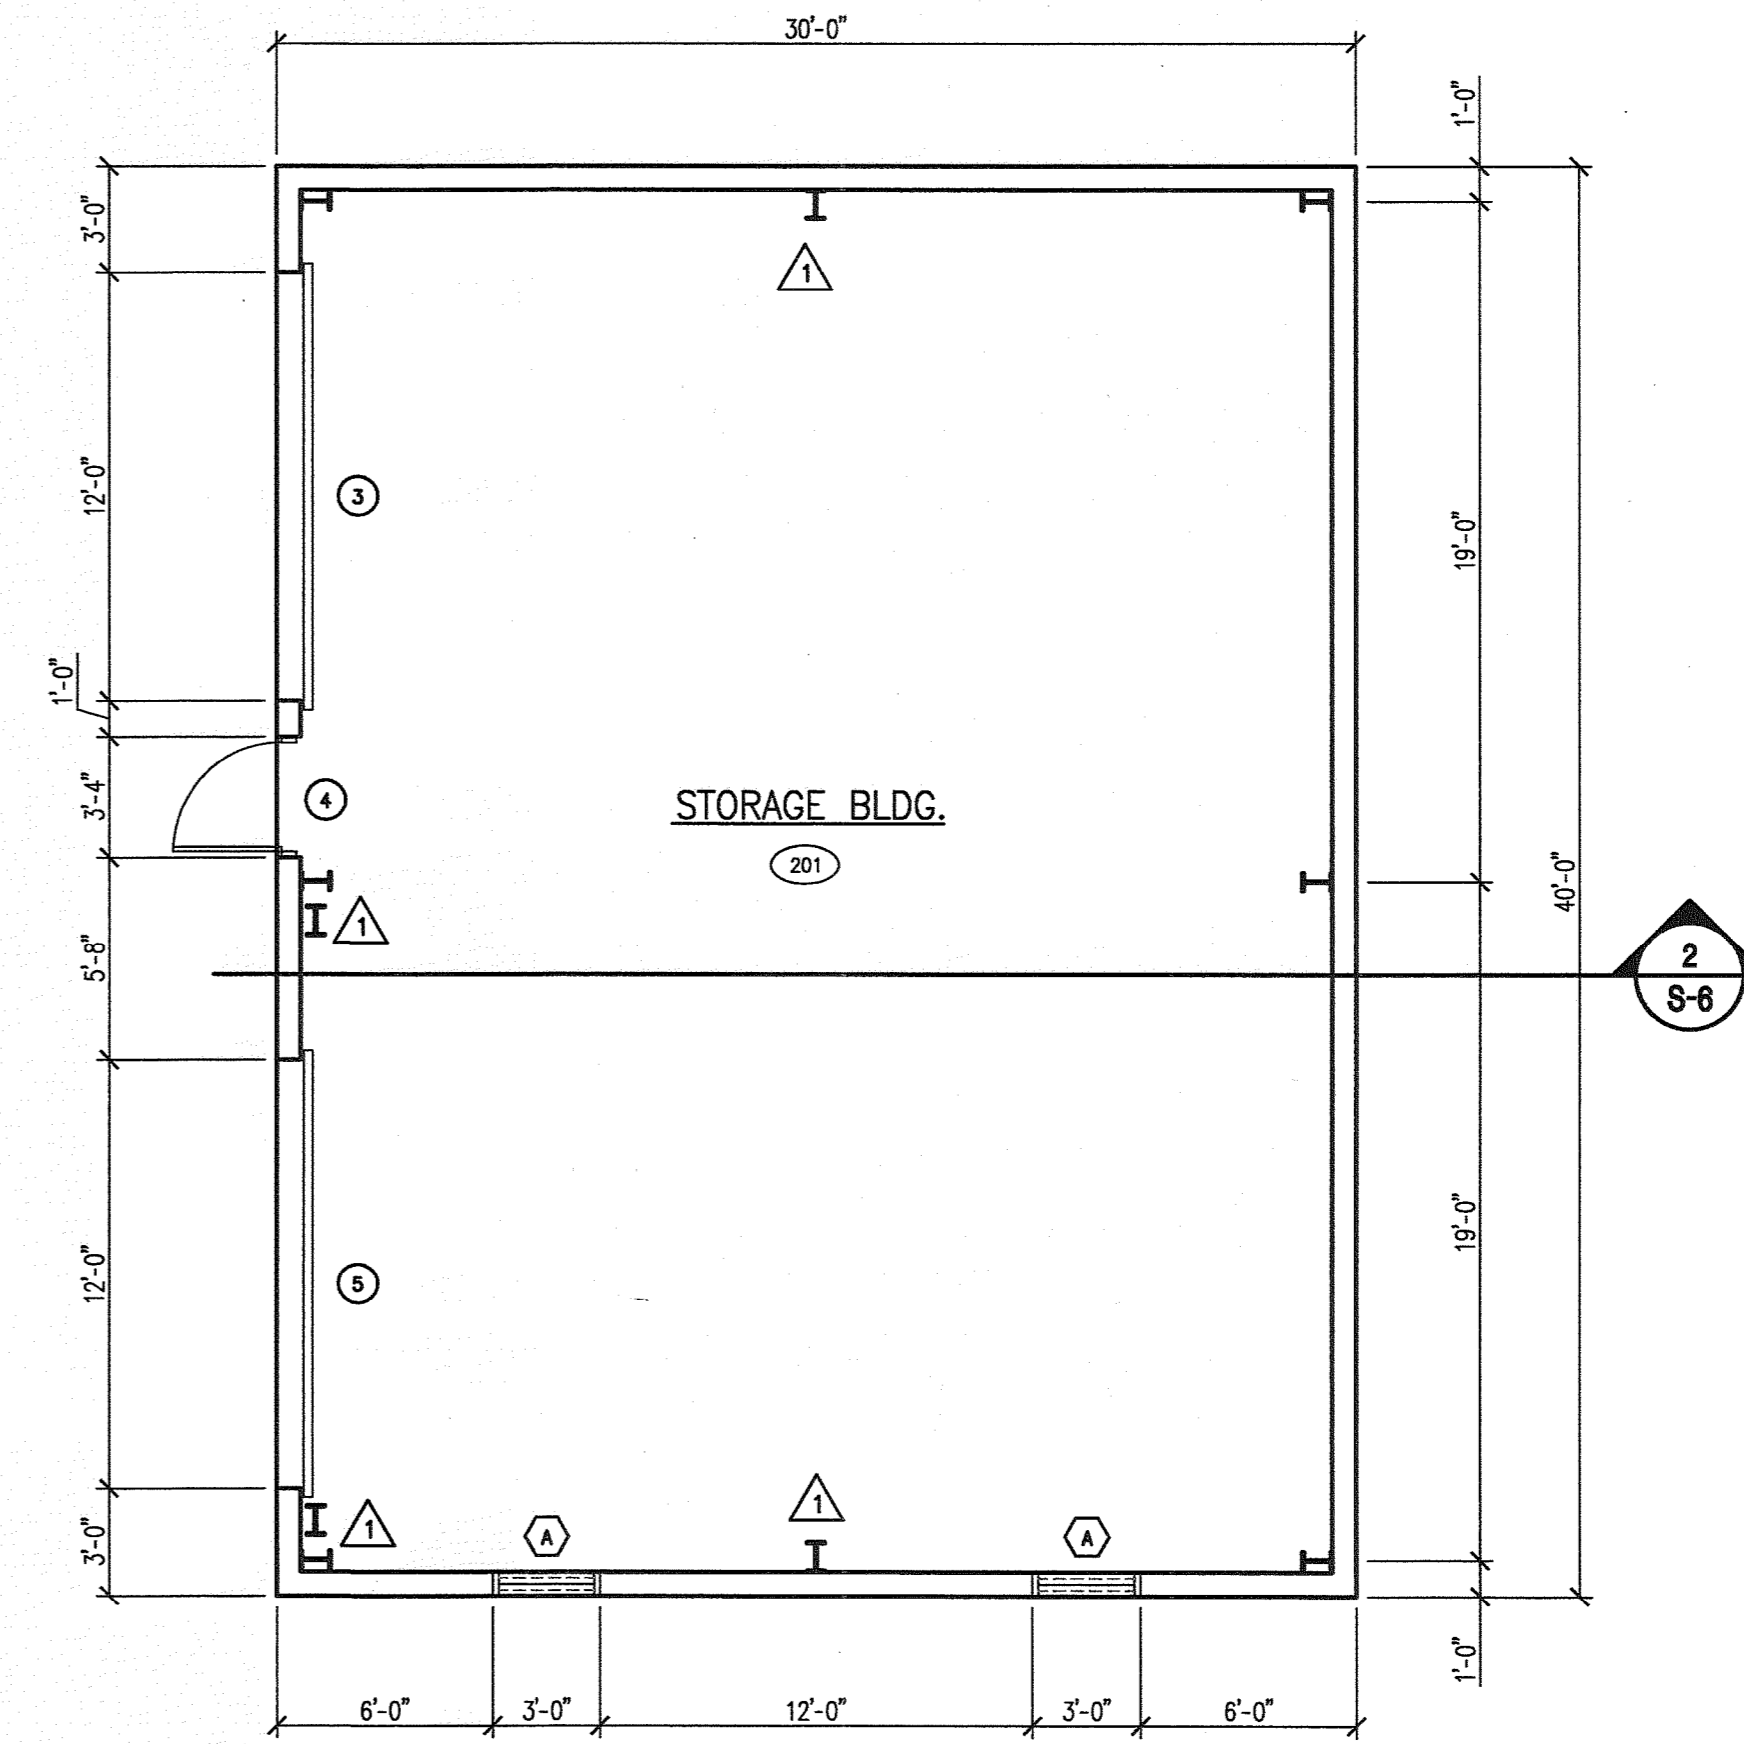


STORAGE BLDG. FLOOR PLAN
SCALE: 3/16" = 1'-0"

ROOM FINISH SCHEDULE

ROOM #	ROOM NAME	FLOOR	BASE	WALLS				CEILING	CEILING HT.	REMARKS
				NORTH	SOUTH	EAST	WEST			
100	BLOWER BLDG.	CONC.	MTL.	MTL.	MTL.	MTL.
200	STORAGE BLDG.	CONC.	MTL.	MTL.	MTL.	MTL.


WALL LEGEND

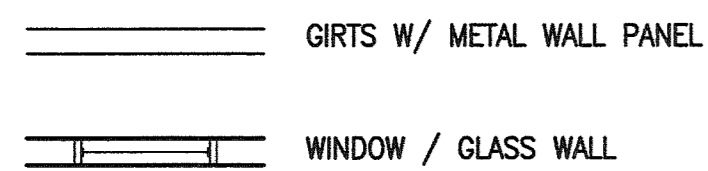

DOOR SCHEDULE

(NO)	TYPE	SIZE	MAT.	FRAME	SILL	FIRE RATING	REMARKS
1	A	3'-0" X 7'-0"	H.M.	MTL.	ALUM.	W/ CLOSER
2	B	12'-0" X 10'-0"	MTL.	MTL.
3	B	12'-0" X 12'-0"	MTL.	MTL.
4	A	3'-0" X 7'-0"	H.M.	MTL.	ALUM.	W/ CLOSER
5	B	12'-0" X 12'-0"	MTL.	MTL.
6							
7							
8							


NOTE: ALL DOOR HARDWARE SHALL BE LEVER TYPE

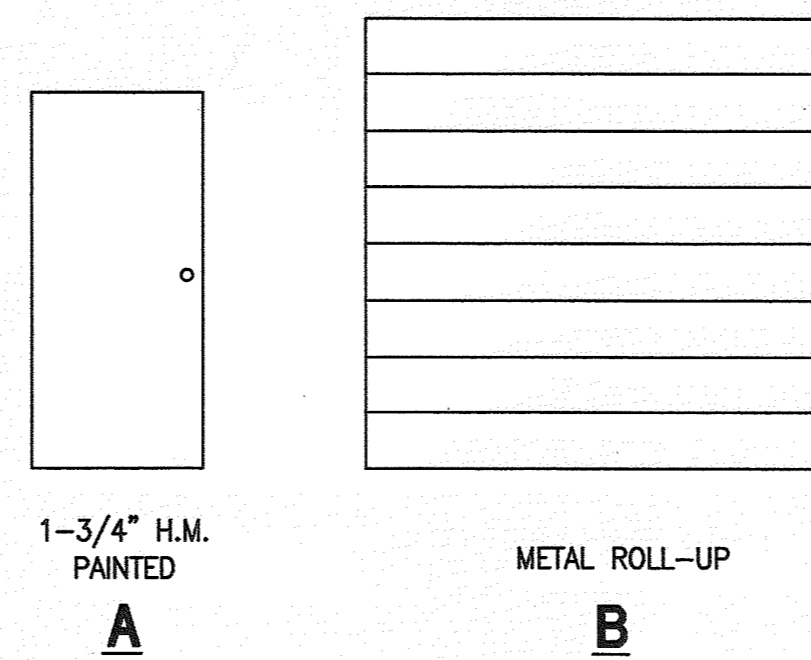

DOOR TYPES

WINDOW SCHEDULE

MARK	TYPE	M.O. UNIT	MANUFACTURER	FLA. PRODUCT APPROVAL NO.
A	SINGLE HUNG	3'-0" X 4'-0"	WINCO	2548
B				
C				

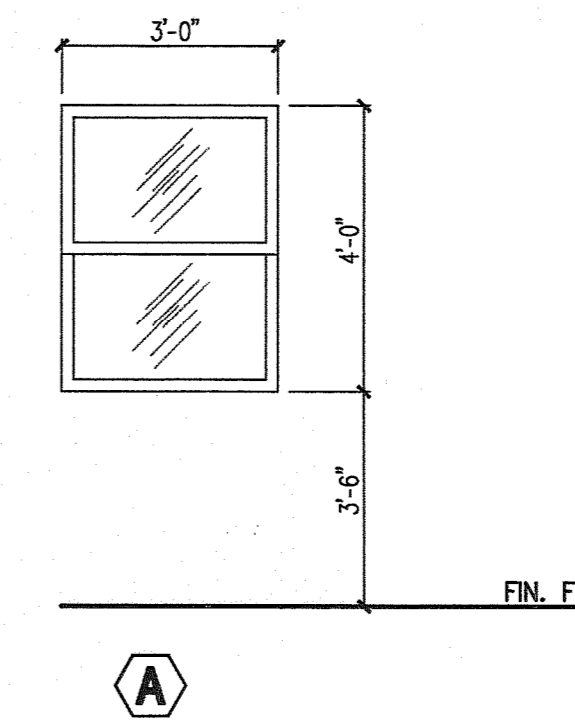

WINDOW TYPES

DRAWING TITLE
BLOWER/STORAGE BUILDINGS FLOOR PLAN
PROJECT
SOUTHEAST COUNTY LANDFILL LANDFILL GAS COLLECTION AND CONTROL SYSTEM

CLIENT
HILLSBOROUGH COUNTY SOLID WASTE MANAGEMENT DEPARTMENT TAMPA, FLORIDA

SCS ENGINEERS
STEARNS, CONRAD AND SCHMIDT
CONSULTING ENGINEERS
4041 Park Oaks Blvd., Suite 100, Tampa, FL 33610
PH (813) 821-0800 FAX NO. (813) 822-6757
FLORIDA CERTIFICATE OF AUTHORIZATION NO. 00004882
PROJ. NO. 092070555.00
DATE: APR 16 2010

CADD FILE:
BE-3531 - S-1
DATE:
JULY 2008
SCALE:
AS SHOWN

DRAWING NO.
S-1 of 30

RECORD DRAWING
DATE: APRIL 15, 2010

ELIZABETH A. BROADWAY
PROFESSIONAL ENGINEER
FLORIDA REGISTRATION NO. 38558

BROADWAY ENGINEERING, P.A.
CIVIL, MECHANICAL, STRUCTURAL AND BUILDING DESIGN
1335 W. Cass Street
Tampa, Florida 33606 813-251-9244
Fax 813-251-9330 Bus. Email: info@broadway-eng.com
Cadd. Email: EAB@broadway-eng.com
BE-3531 Certificate of Authorization No. 4599

C:\Users\ELABE\My Documents\RECORD\S-1-RECORD\S-1-RECORD.dwg Apr 15, 2010 - 3:28pm Layer Name: S-1 By: DOUGLAS GORR